


KEYNOTES:


- 1 PROVIDE WIRE GUARDS ON SPRINKLERS IN THIS AREA.
- 2 PIPING TO BE RUN BENEATH BULKHEAD CEILING AND AGAINST WALL. USE SIDEWALL SPRINKLERS ALONG BALCONY. PROVIDE EXTENDED COVERAGE OF SIDEWALL HEADS IF REQUIRED. PROVIDE WIRE GUARDS ON SPRINKLERS. PAINT EXPOSED PIPING. CONFIRM COLOURS WITH ARCHITECT.
- 3 PAINT EXPOSED PIPING. CONFIRM COLOUR WITH ARCHITECT. PIPING TO SERVE SIDE WALL SPRINKLER HEADS FOR THE BALCONY.

This drawing must not be scaled. The contractor shall verify all dimensions and other data on site prior to commencement of work. All discrepancies, errors, and omissions are to be reported to the architect. Drawing and specifications, as instruments of service, are the property of the architect, the copyright in the same being reserved to him. No reproduction may be made without the permission of the architect, and when made, must bear his name. All prints to be returned to the architect on request.

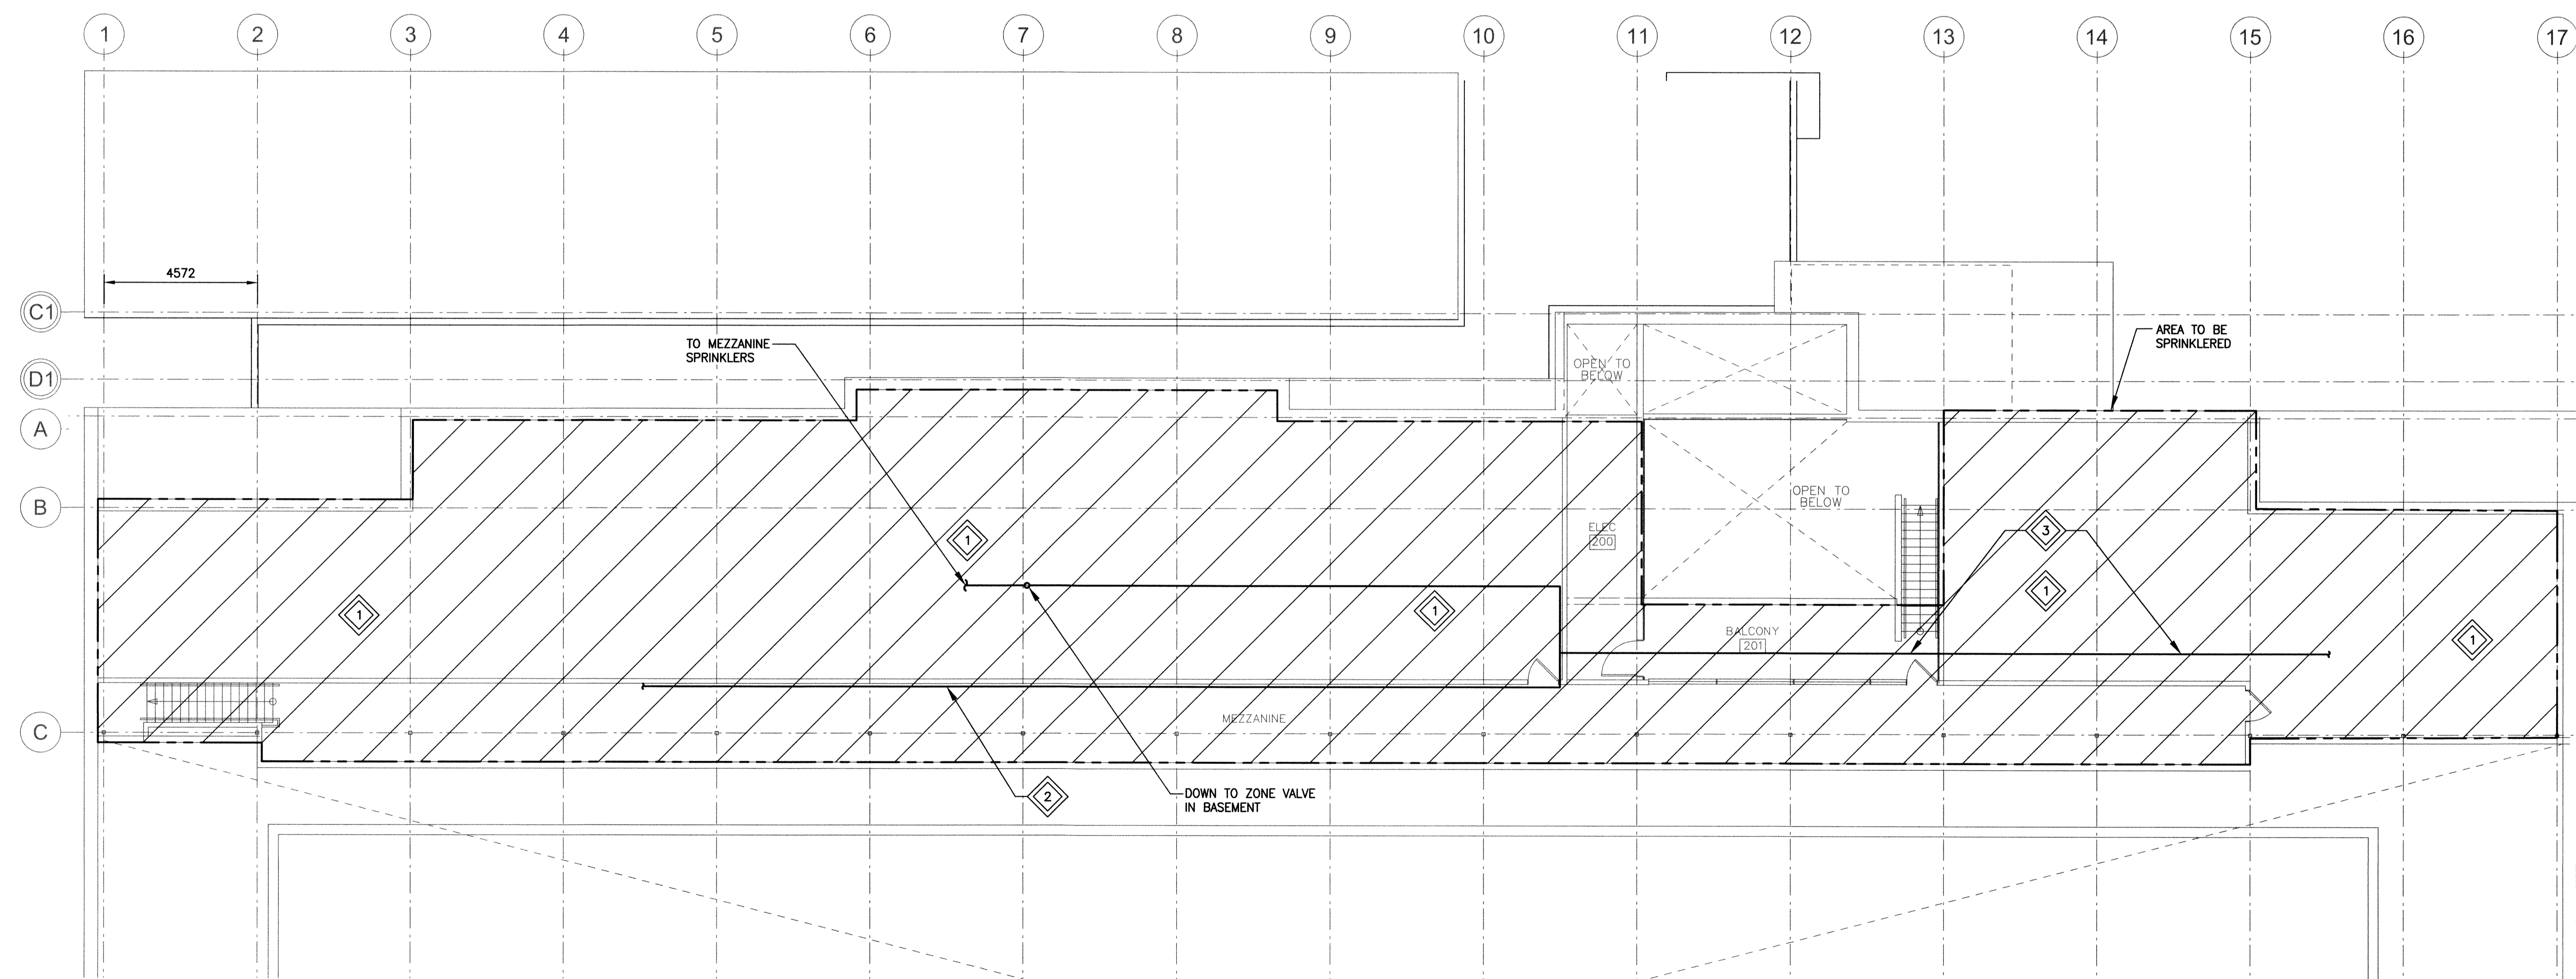

1 MEZZANINE PLAN - NEW FIRE PROTECTION
SCALE: 1:100


SCALE VERIFIED BY: *ALC*

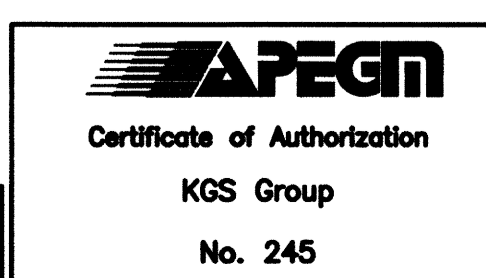

Issue / rev.

#	date	issue notes
0	2016/07/15	ISSUED FOR CONSTRUCTION

professional seals

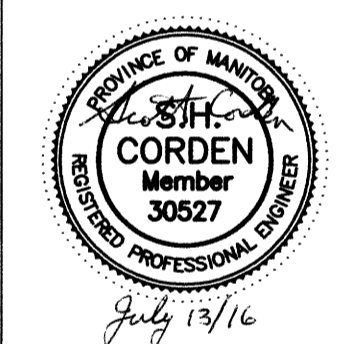

project information

SEVEN OAKS POOL

444 Adsum Drive
Winnipeg, MB
Canada

client

City of Winnipeg
4th Floor - 86 King Street
Winnipeg, MB

drawing information

**MECHANICAL
MEZZANINE FLOOR PLAN
NEW FIRE PROTECTION**

drawn by: RLR
approved by: *ALC*
scale: AS NOTED
date issued: 2016.07.15
proj. #: 14-1736-008
rev. #: R-0

**SEVEN OAKS POOL
RENOVATION & ADDITION**
BID OPPORTUNITY NO. 645-2016

**M4
02**

File Name: P:\Projects\2014\14-1736-008\DWG\Mech\14-1736-008_M4-02.dwg - Tab: M4-02 Plotted By: deroche 16/07/13 [Wed 4:43pm]