

Issue / rev.

0	2016/07/15	ISSUED FOR CONSTRUCTION
#	date	issue notes

professional seals



project information

SEVEN OAKS POOL

444 Adsum Drive
Winnipeg, MB
Canada

client

City of Winnipeg
4th Floor - 86 King Street
Winnipeg, MB

drawing information

MECHANICAL SECTIONS AND DETAILS

drawn by: RLR

approved by: *[Signature]*


scale: AS NOTED

date issued: 2016.07.15


proj. #: 14-1736-008

rev. #: R-0


SEVEN OAKS POOL RENOVATION & ADDITION
 BID OPPORTUNITY NO. 645-2016

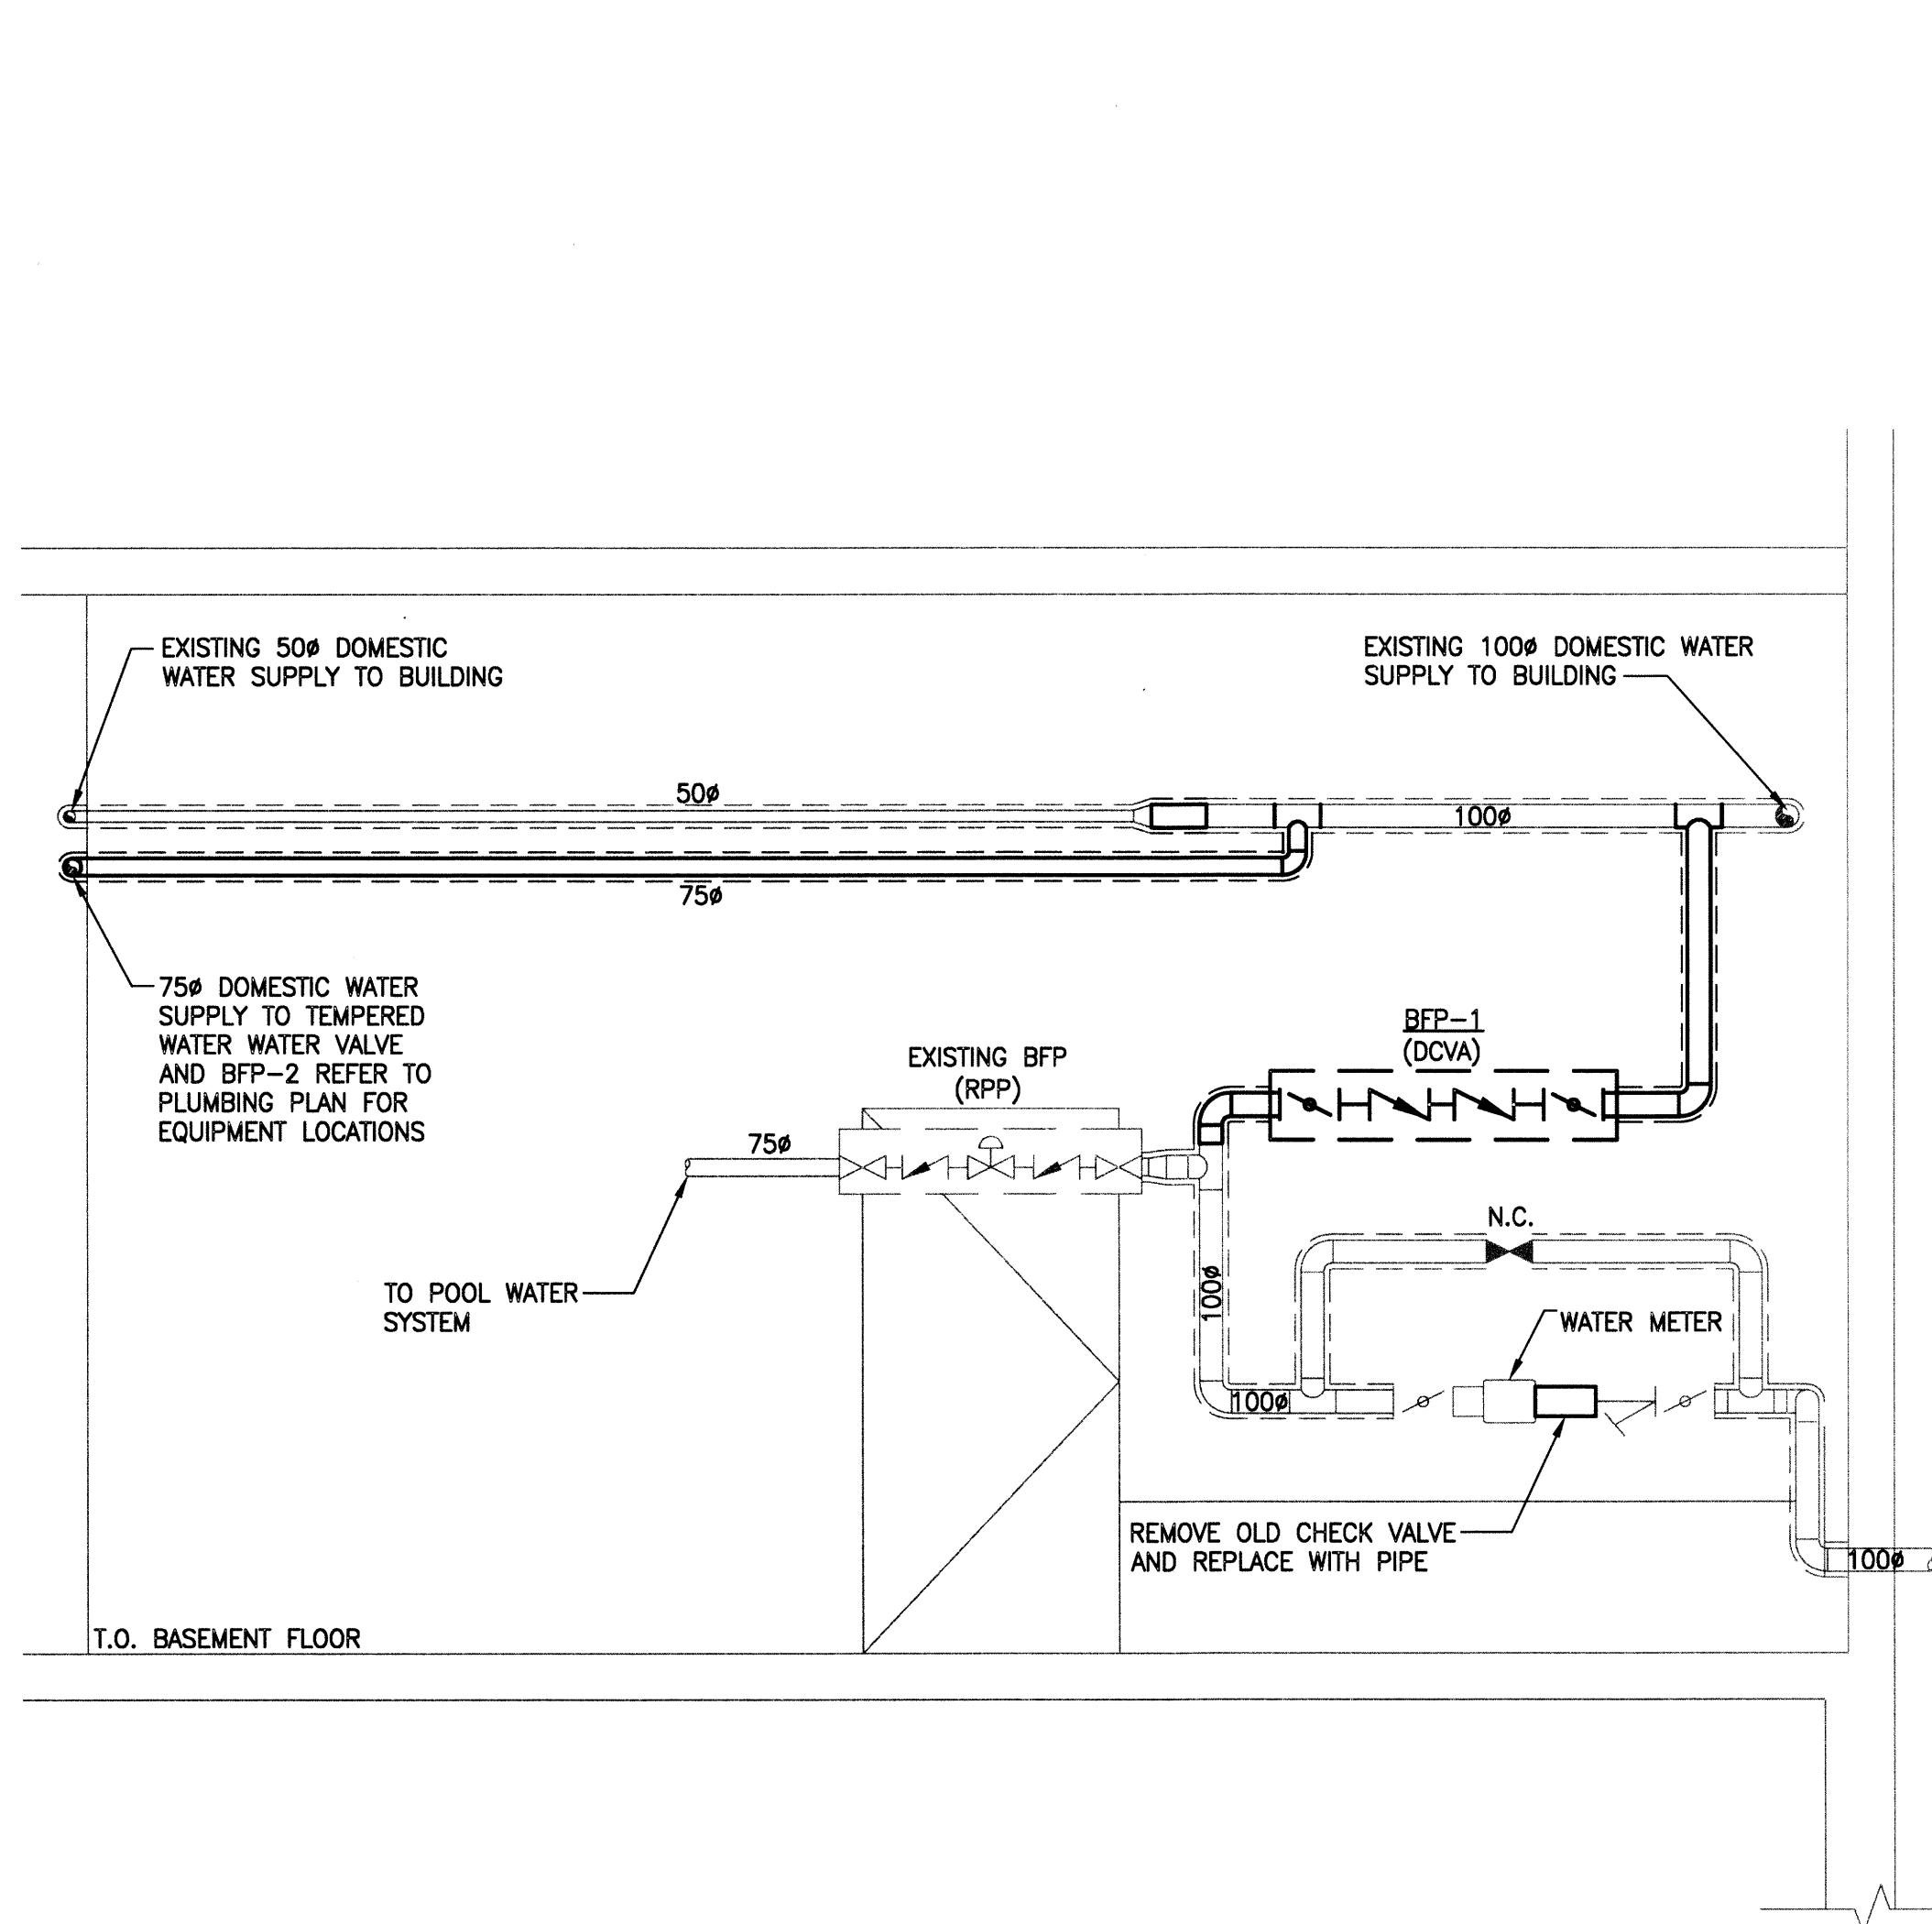


1 DOMESTIC WATER SERVICE ENTRANCE DETAIL
 M2-00 SCALE: N.T.S.

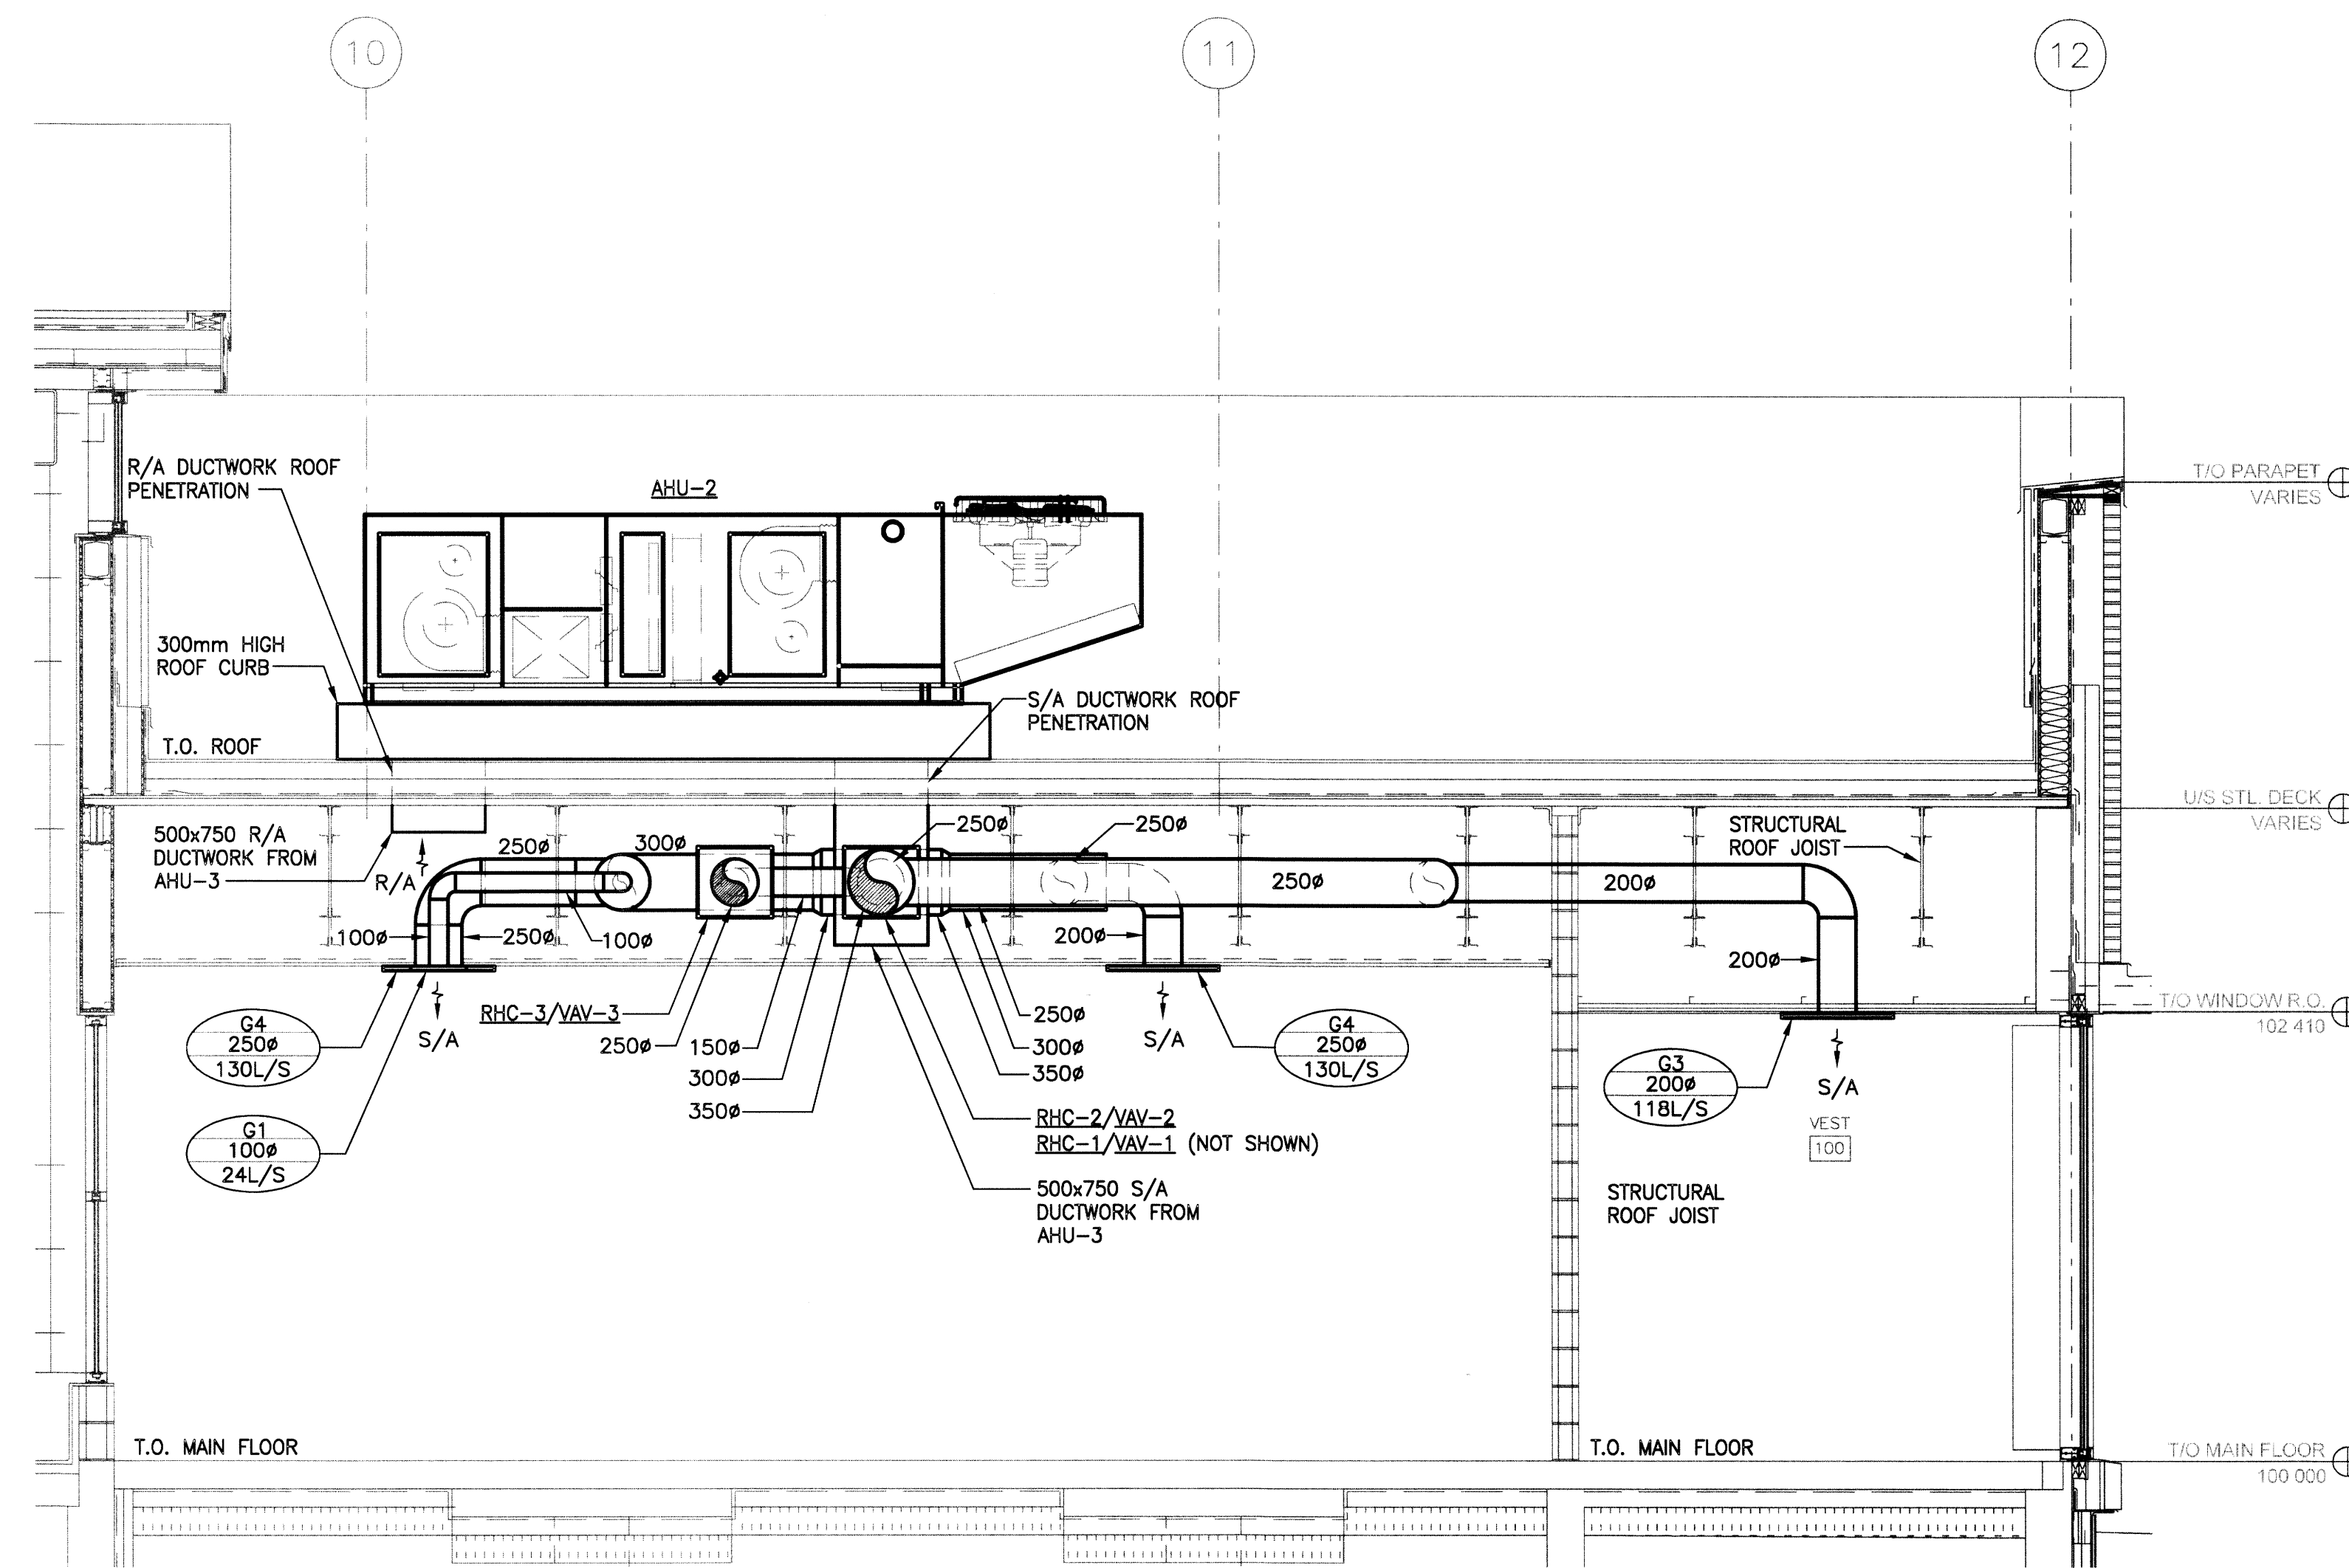


2 AHU-2 AND DUCTWORK DETAILS
 M3-01 SCALE: N.T.S.

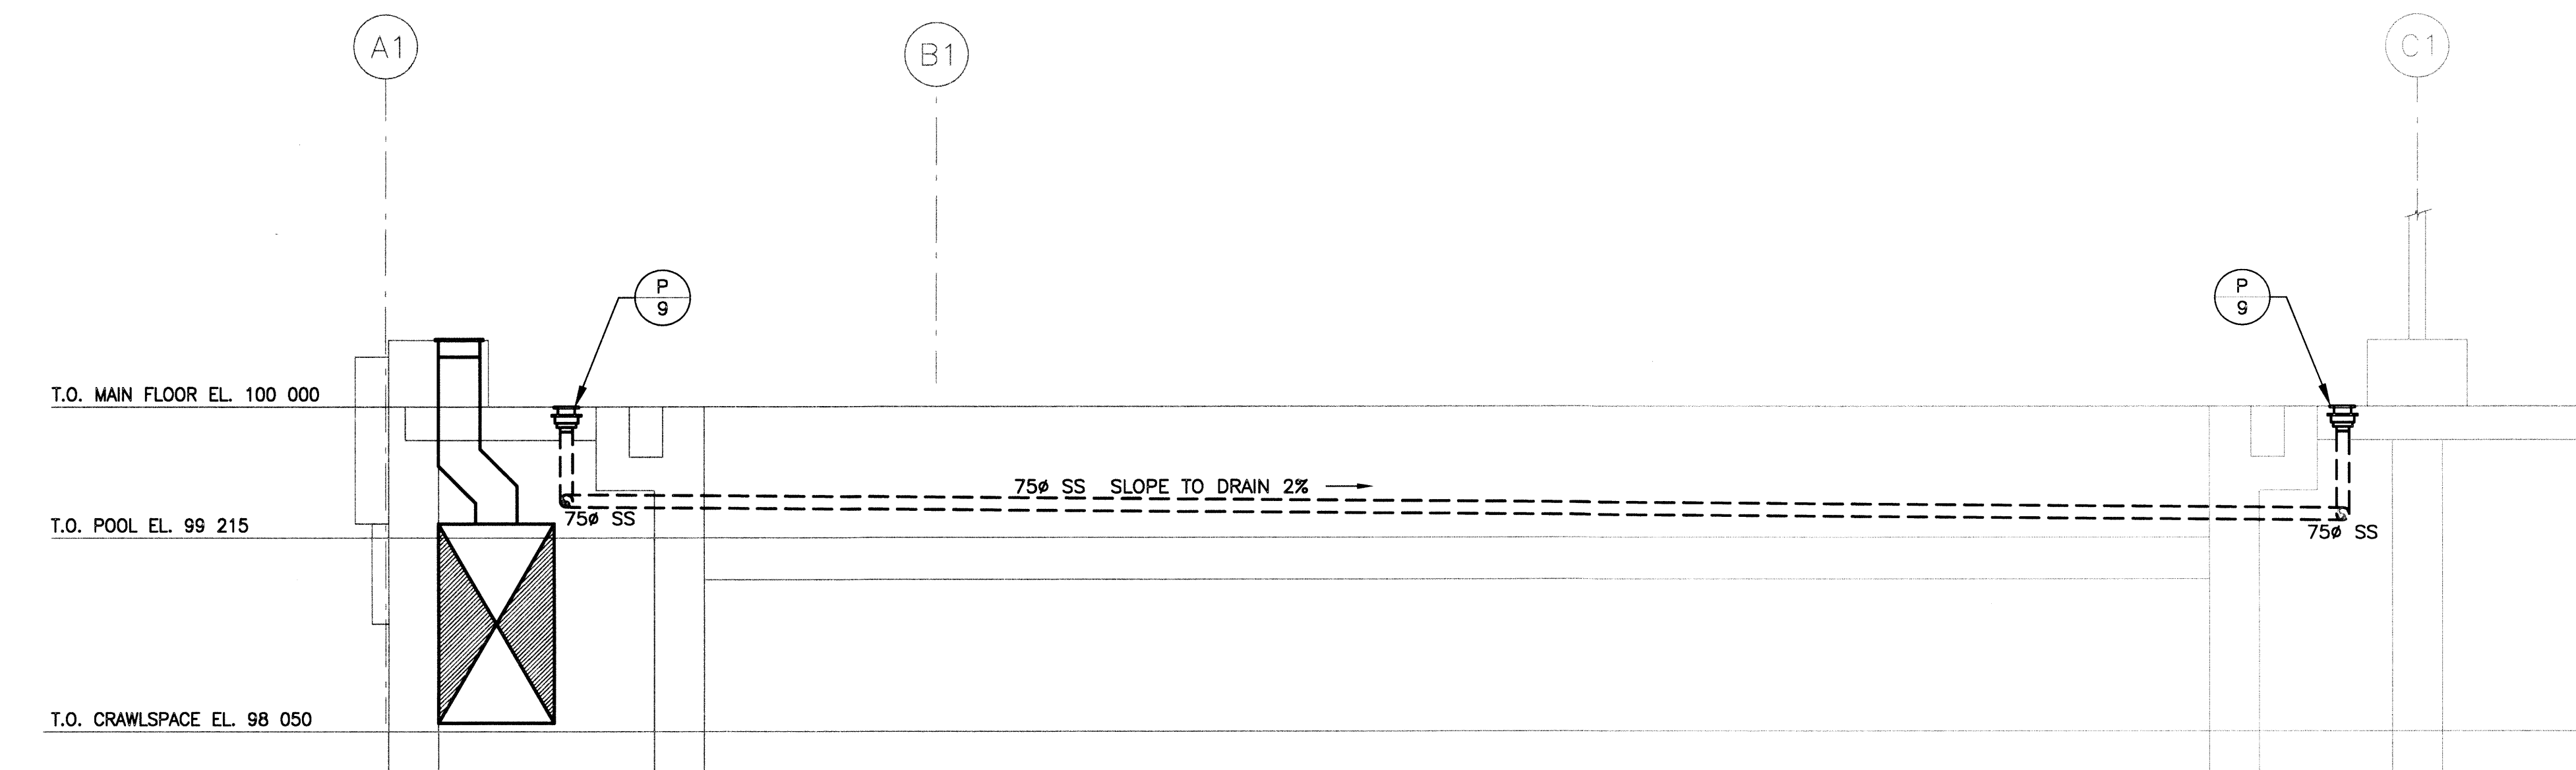

3 POOL DRAINS SANITARY PIPING DETAIL
 M2-01 SCALE: N.T.S.

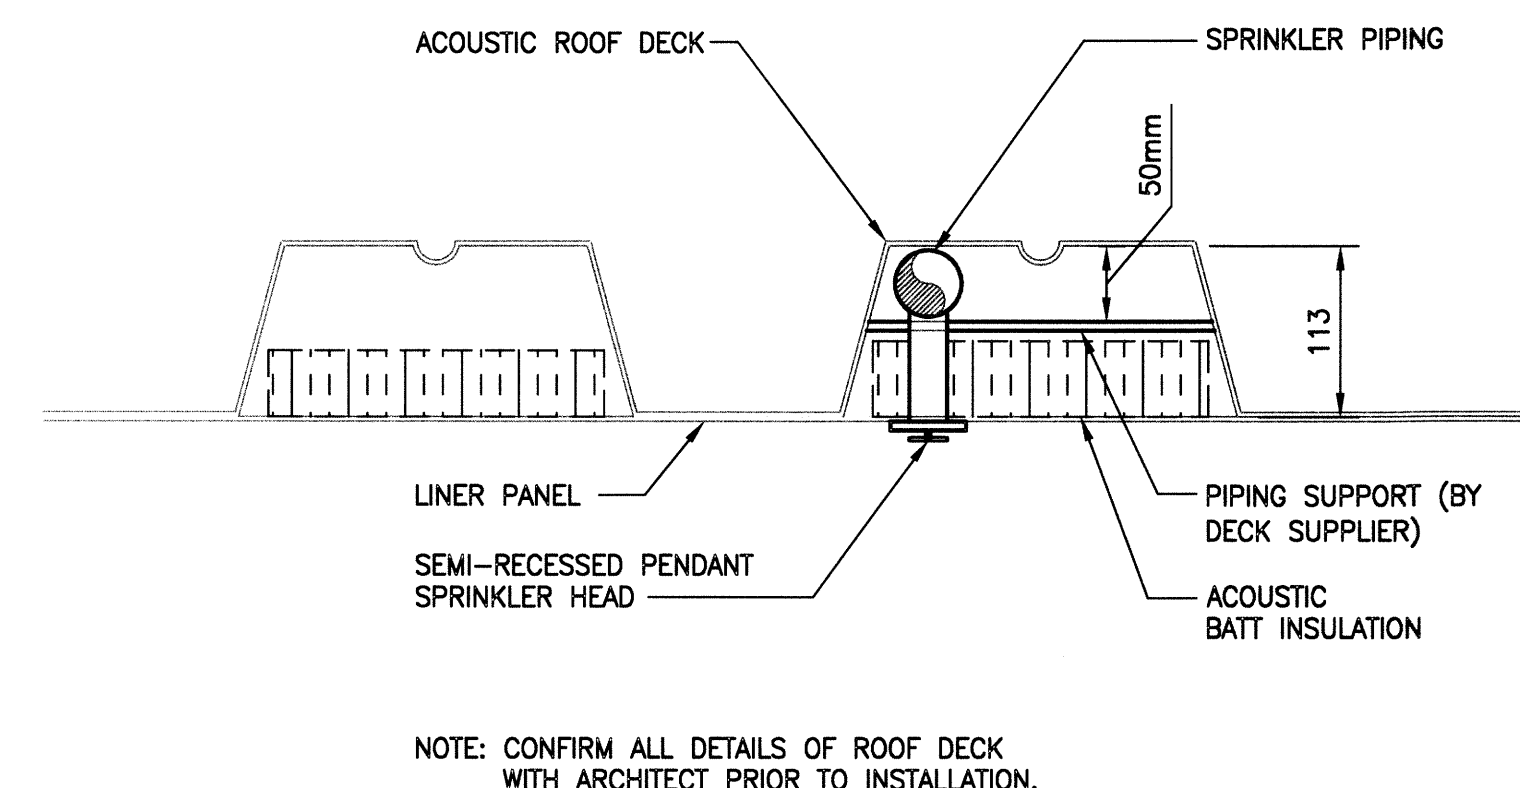

4 SPRINKLER PIPING INSTALLATION DETAIL IN SPLASH PAD
 SCALE: N.T.S.

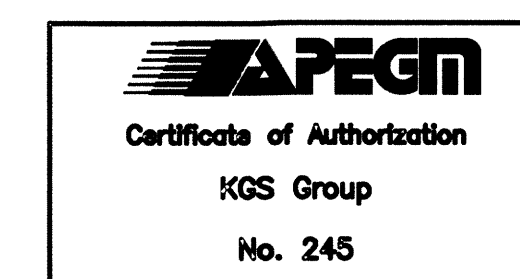

File Name: P:\Projects\2014\14-1736-008\Drawings\Mech\14-1736-008_Mech\14-1736-008_M2-01.dwg - Tab: M2-01 Plotted By: sderocher 16/07/13 [Wed 3:47pm]

This drawing must not be scaled. The contractor shall verify all dimensions and other data on site prior to commencement of work. All discrepancies, errors, and omissions are to be reported to the architect. Drawing and specifications, as instruments of service, are the property of the architect. The copyright in the same being reserved to him. No reproduction may be made without the permission of the architect, and when made, must bear his name. All prints to be returned to the architect on request.