





AREA CLASSIFICATION - MAIN FLOOR

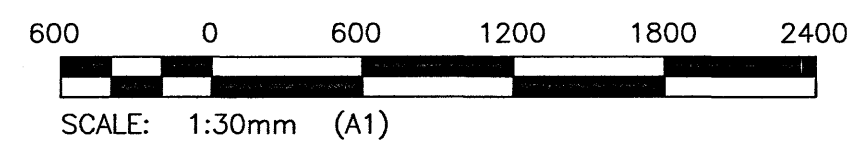



LEGEND:

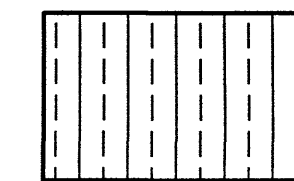

CATEGORY 1 (MOISTURE)

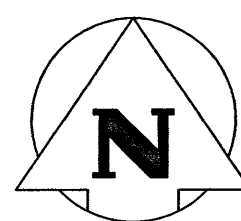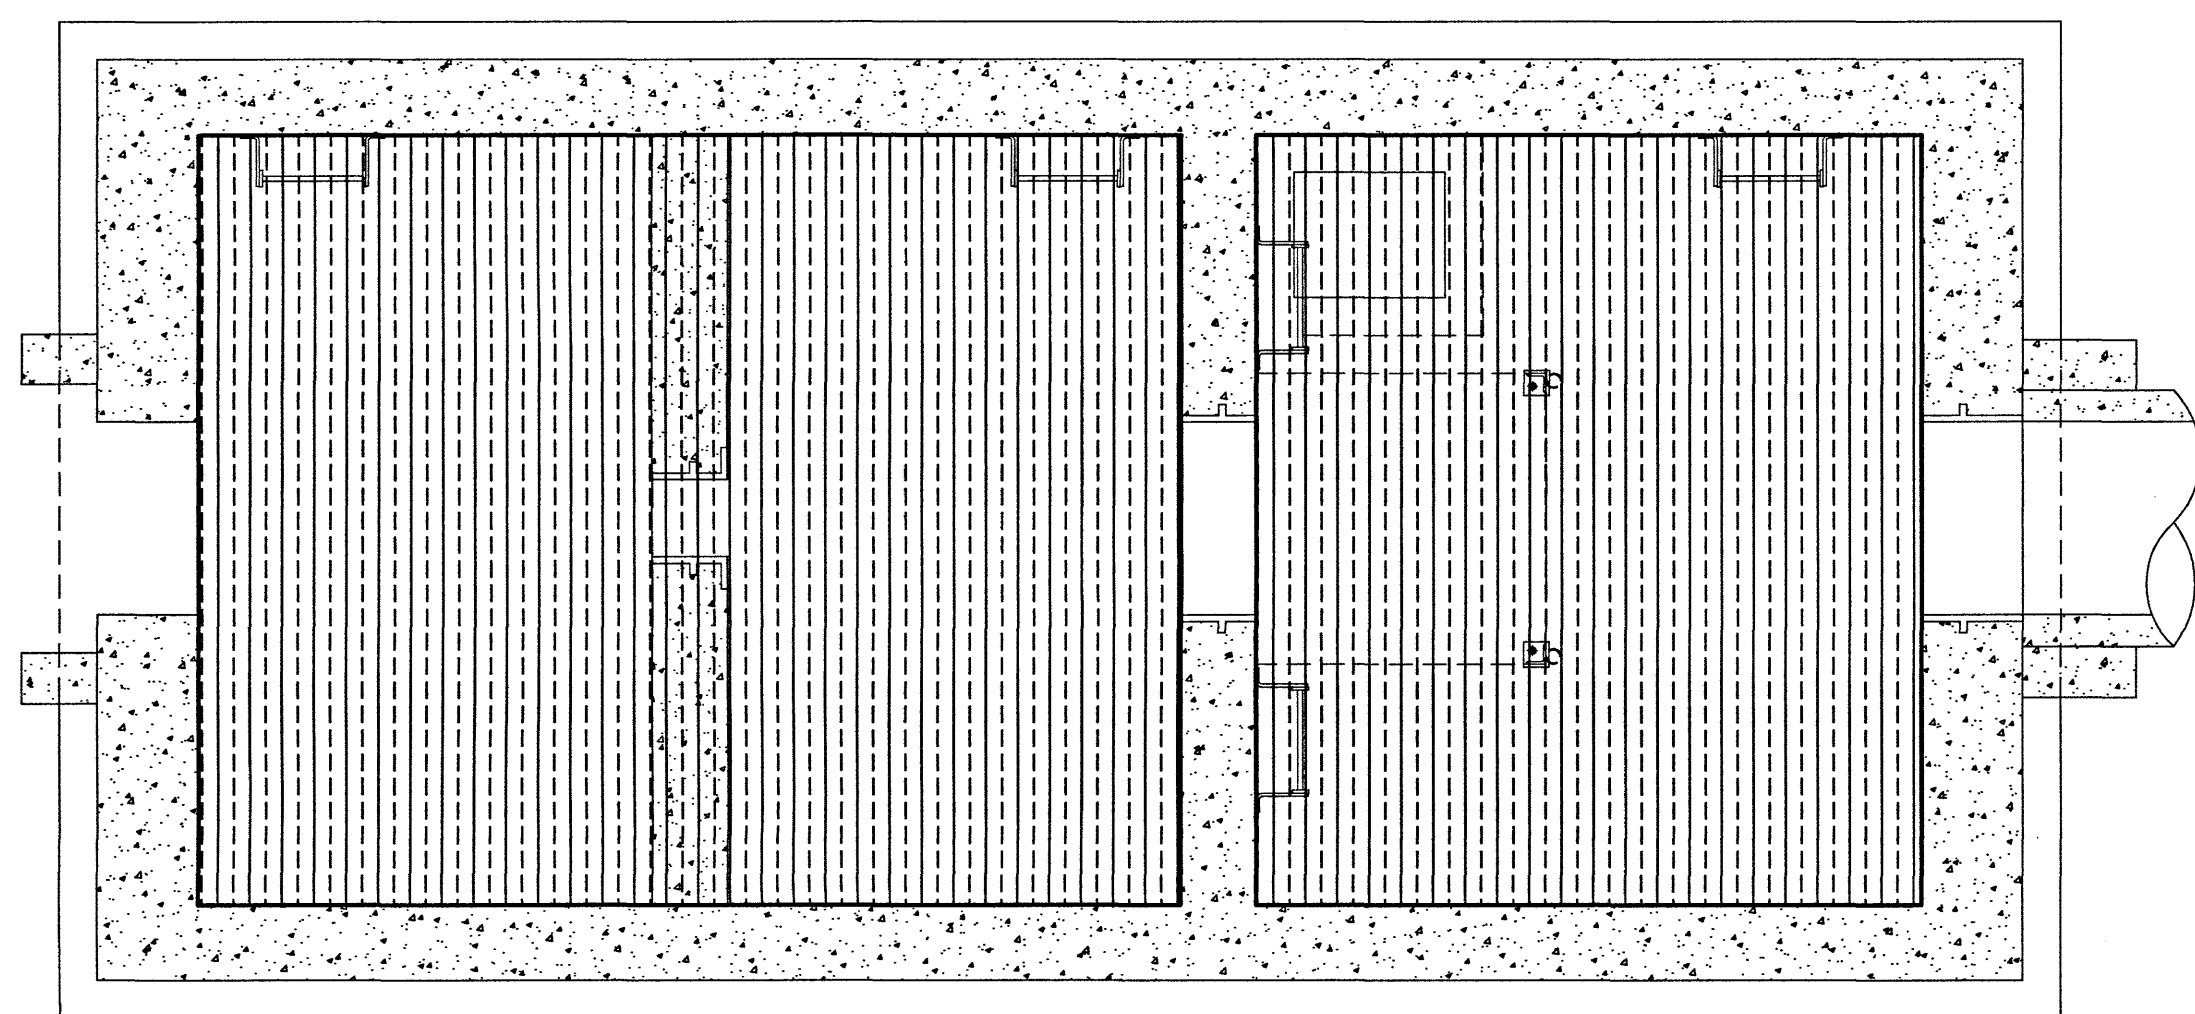


AREA CLASSIFICATION - LOWER LEVEL

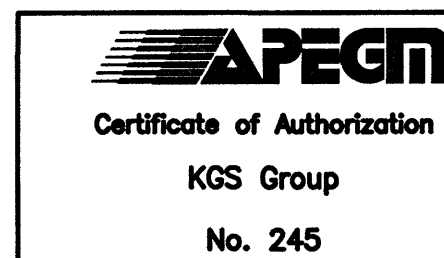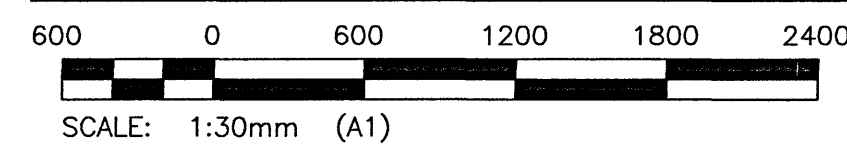

B.M. -				
ELEV. -				
00	ISSUED FOR CONSTRUCTION	2016/09/02	DDN	1/13
NO.	REVISIONS	DATE	DESIGN	CHECK

<b>KGS GROUP</b> CONSULTING ENGINEERS	
DESIGNED BY: C. S. ROBINSON	CHECKED BY: <i>J.A. BOUCHARD</i>
DRAWN BY: J. P. DELEON	APPROVED BY: <i>J.A. BOUCHARD</i>
SCALE: AS NOTED	ISSUED FOR CONSTRUCTION
DATE: 2016/06/28	BY: DATE:
CONSULTANT NO.: 15-0107-019_E14	

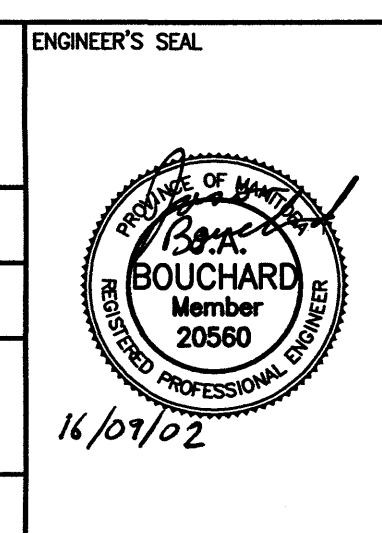

<b>THE CITY OF WINNIPEG</b> WATER AND WASTE DEPARTMENT	
WEST END SEWAGE TREATMENT PLANT EFFLUENT MONITORING STATION GENERAL ARRANGEMENT DRAWING AREA CLASSIFICATION MAIN AND LOWER LEVEL FLOOR PLAN	
CITY DRAWING NUMBER 1-0103-EHLC-Z001	SHEET REV. SIZE 00 00 A1