


Filepath: P:\Projects\2017\17-0109-007\Elec\17-0109-007\_E1-00 - Tab:E1-00 Plotted By: dderoché 17/06/21 [Wed 4:02pm]  
 24"x36" PLOT SCALE: 1"=11'

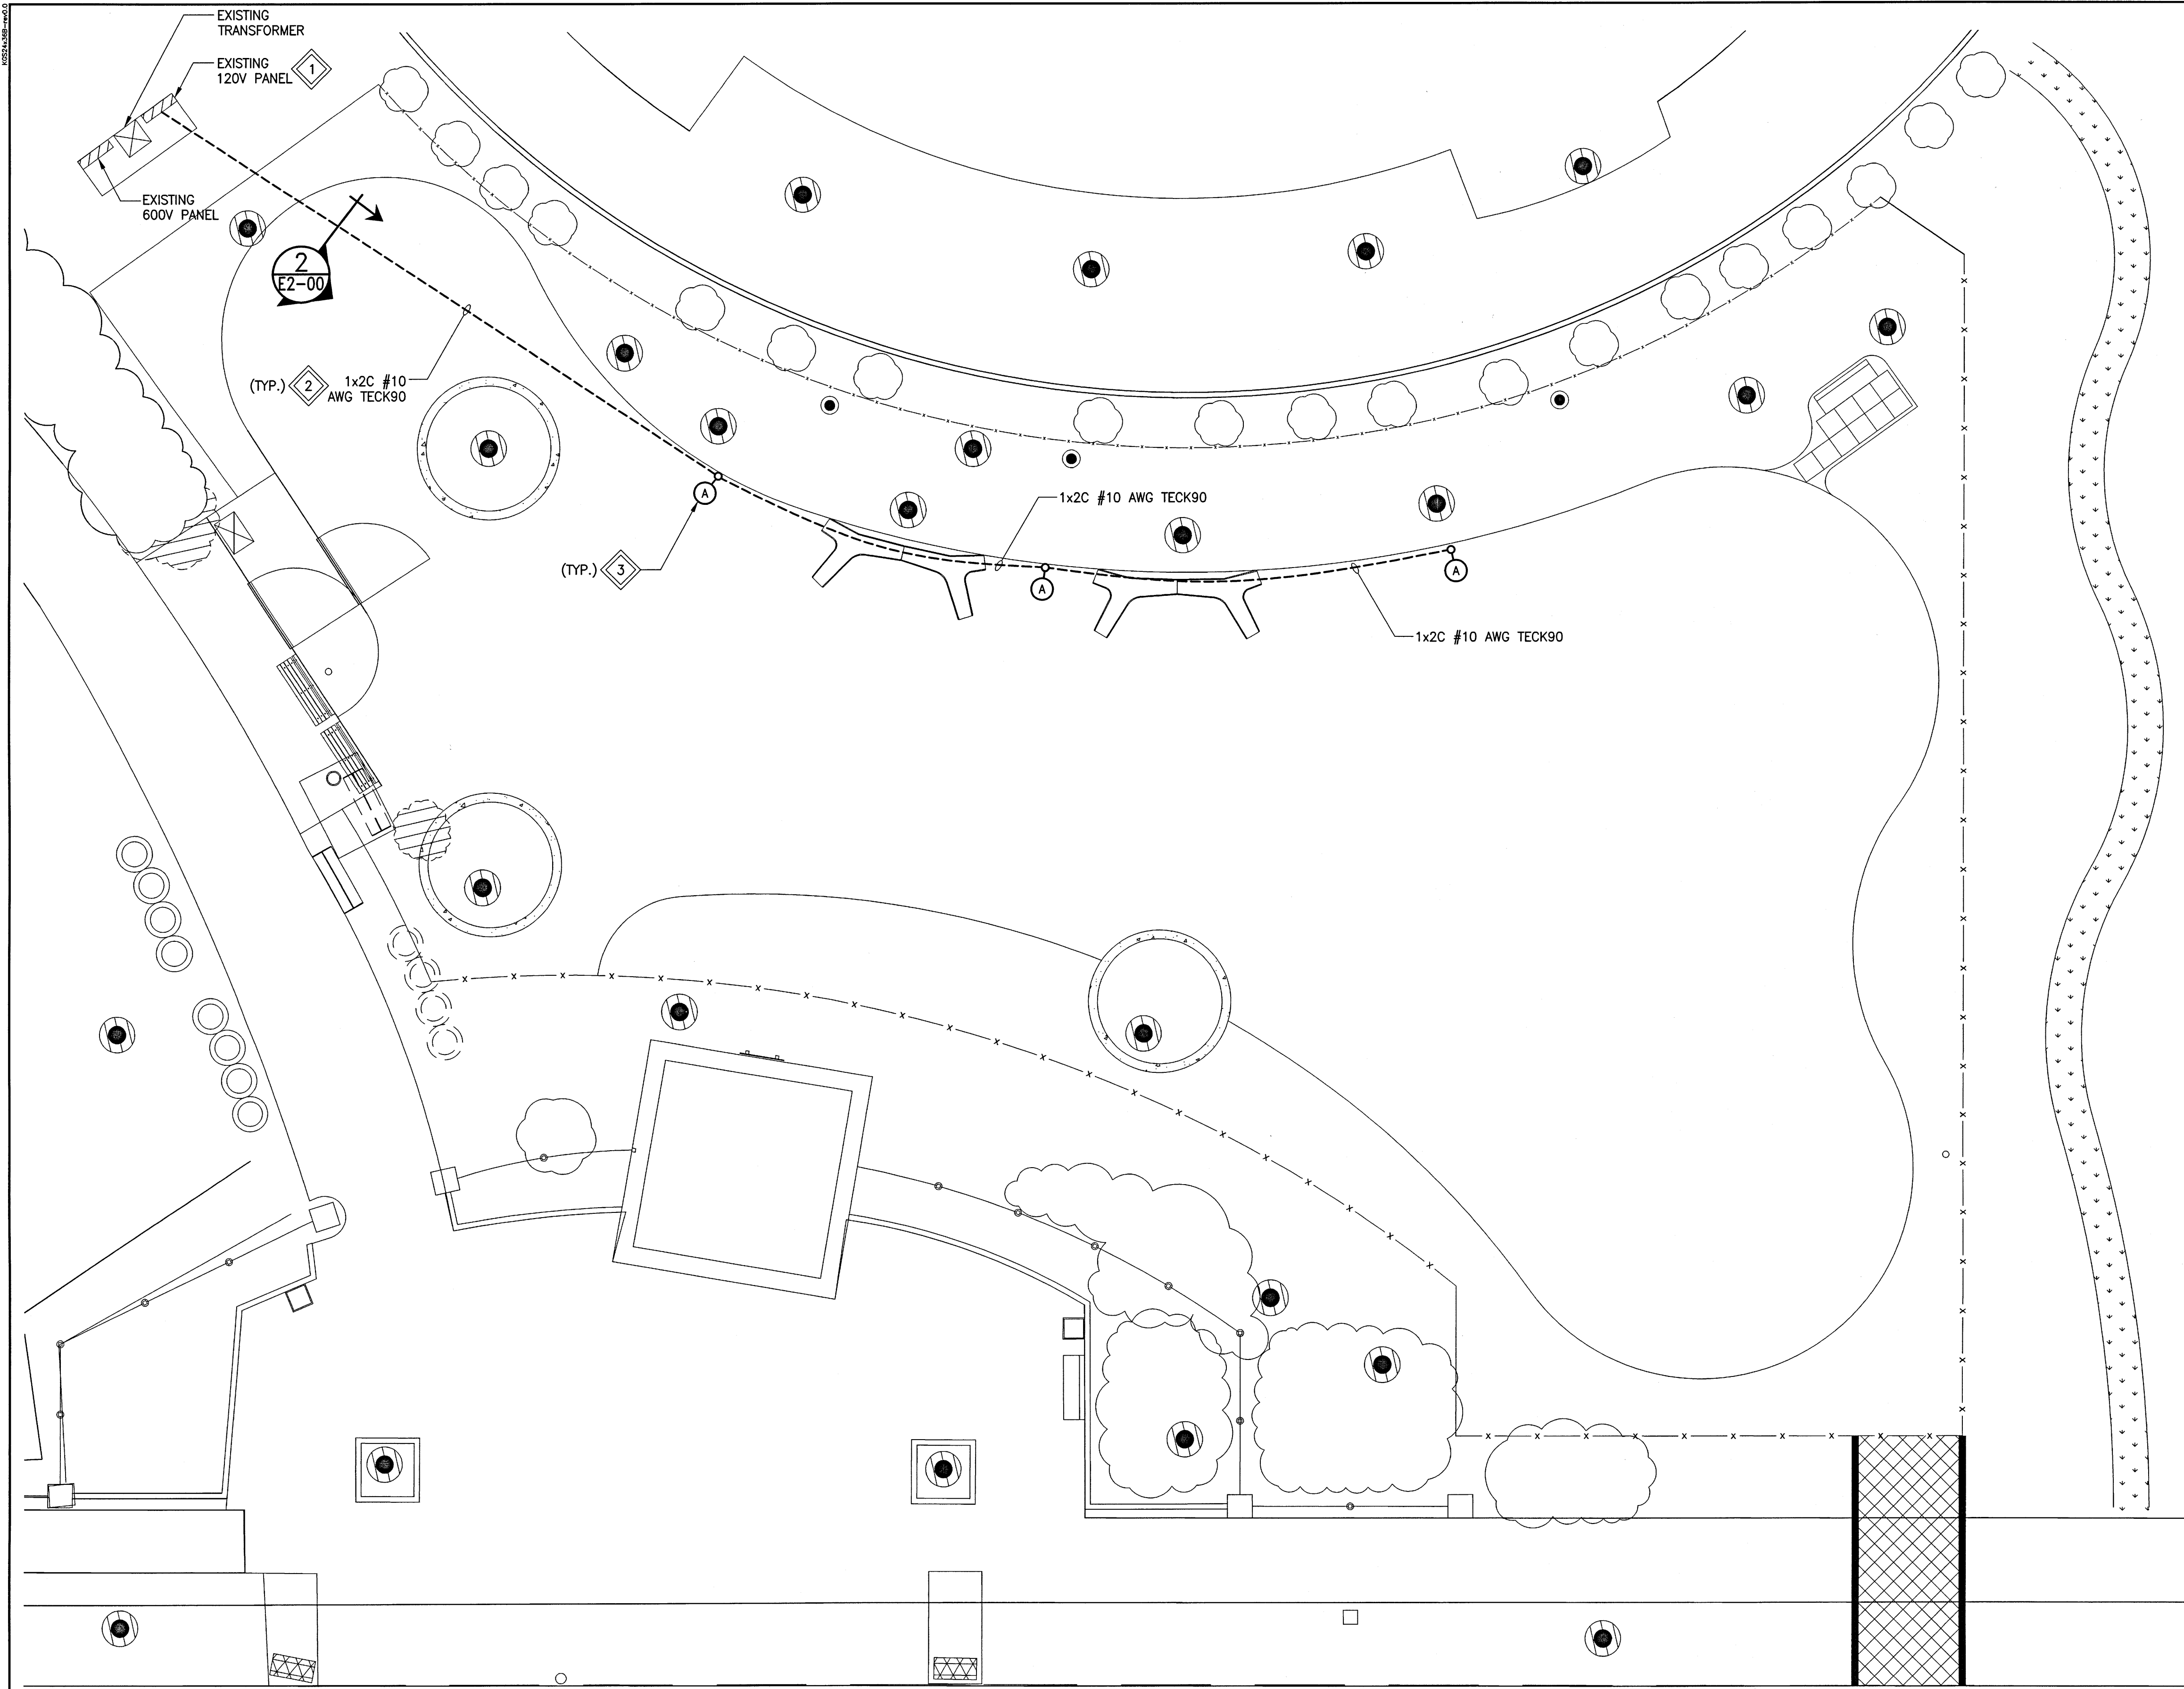

**GENERAL NOTES:**

1. GRAY LINE WEIGHT DENOTES EXISTING.
2. PROVIDE LOCATES FOR ALL UNDERGROUND SERVICES IN PROJECT AREA. CONSULT WITH ENGINEER FOR ANY CLASHES WITH EXISTING SERVICES.
3. ELECTRICAL CONTRACTOR SHALL COORDINATE THE REQUIRED FEEDER TRENCH WITH THE GENERAL CONTRACTOR.
4. ELECTRICAL CONTRACTOR TO INSTALL POLE PLUMB ON BASE. PROVIDE SHIMS AS REQUIRED.
5. CONFIRM FINAL POLE PILE LOCATIONS WITH ARCHITECTURAL PRIOR TO INSTALLING PILE.

**KEYNOTES:**

1. EXISTING 120V DISTRIBUTION CONSISTS OF FEDERAL PIONEER "NBLP" PANELBOARD. PROVIDE NEW 15A-1P BREAKER MATCH EXISTING KA RATING.
2. PROVIDE UNDERGROUND CABLE TO LIGHT FIXTURES FROM EXISTING 120V DISTRIBUTION PANEL. ROUTE CABLE THROUGH BOTTOM OF DISTRIBUTION ENCLOSURE.
3. PROVIDE THREE (3) LED FIXTURES AND THREE (3) 14' POLES WITH ALL REQUIRED ACCESSORIES. PROVIDE INTEGRAL CONTROL WITH PHOTOCELL. SYSTEM TO BE COMPLETE AND OPERATIONAL. PROVIDE "P1" PILE TYPE. SEE DRAWING E2-00 DETAIL 1.

0	17/06/21	ISSUED FOR CONSTRUCTION	BS	CLS
NO.	YY/MM/DD	DESCRIPTION	DESIGN BY	DESIGN CHECK
REVISIONS / ISSUE				


CLIENT:  
**SCATLIFF + MILLER + MURRAY**  
 visionary urban design + landscapes

PROJECT:  
**BONNYCASTLE PARK IMPROVEMENT**

DWG. DESCRIPTION:  
**ELECTRICAL SITE PLAN**

AUTHENTICATION FOR CURRENT REVISION	DESIGN BY: JLL	DATE (YY/MM/DD): 17/06/07
ENG. STAMP	DESIGN CHECK: CLS	DATE: 17/06/21
	DRAWN BY: RAH	DATE: 17/06/07
	DWG. CHECK: CLS	DATE: 17/06/21
DWG. NO. 17-0109-007	E1-00	REV. 0

**APEGM**  
 Certificate of Authorization  
 KGS Group  
 No. 245

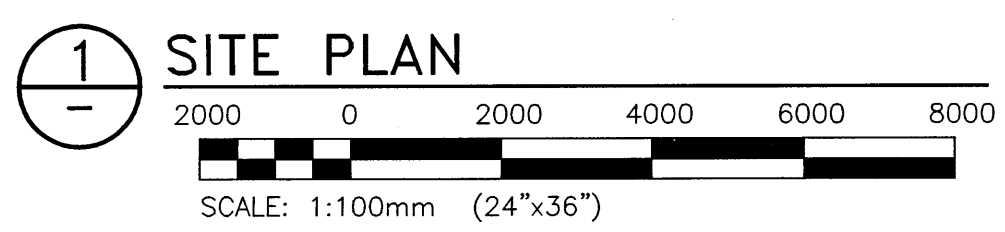

ASSINIBOINE AVE.