


DEMOLITION NOTES

- (A) PROVIDE DEMOLITION OF EXISTING UTILITY METER SOCKET AND ASSOCIATED CONDUIT AND WIRING. RETAIN METER FOR RE-USE. IN-FILL EXISTING WALL PENETRATION IF IT IS NOT BEING RE-USED.
- (B) PROVIDE DEMOLITION OF EXISTING 600V DISTRIBUTION PANELS. TURN OVER TO THE CITY.
- (C) PROVIDE DEMOLITION OF EXISTING CONTROL PANELS AND THE 120/240V PANELBOARD, PANEL A. DEMOLISH ALL ASSOCIATED CONDUIT AND CABLE.
- (D) PROVIDE DEMOLITION OF EXISTING RTU PANEL. TURN OVER TO THE CITY. DEMOLISH ALL ASSOCIATED CONDUIT AND CABLE.
- (E) PROVIDE DEMOLITION OF EXISTING 600:120/240V TRANSFORMER AND ASSOCIATED CABLING AND CONDUIT.
- (F) RETAIN EXISTING BATTERY CHARGER FOR RE-USE.
- (G) PROVIDE DEMOLITION OF EXISTING LIGHT FIXTURE AND ALL ASSOCIATED CABLE, CONDUIT, AND CONTROLS.
- (H) PROVIDE DEMOLITION OF EXISTING UNIT HEATERS AND ASSOCIATED CABLING, CONDUIT, AND CONTROLS.
- (J) PROVIDE DEMOLITION OF EXISTING SUPPLY FAN AND DUCT HEATER AND ASSOCIATED CABLING, CONDUITS, AND CONTROLS.
- (K) PROVIDE DEMOLITION OF EXISTING NATURAL GAS ENGINE CONTROLS AND ASSOCIATED CONDUIT, CABLING, AND BATTERIES.
- (L) PROVIDE DEMOLITION OF EXISTING ROOM HIGH AND LOW TEMPERATURE SWITCHES AND ASSOCIATED CABLING AND CONDUIT.
- (M) PROVIDE DEMOLITION OF EXISTING LIGHT SWITCHES. RETAIN EXISTING THROUGH-FLOOR CONDUIT FOR RE-USE.
- (N) PROVIDE DEMOLITION OF EXISTING DEVICE BOX AND ASSOCIATED CONDUIT AND CABLE.
- (O) PROVIDE DEMOLITION OF EXISTING DAMPER ACTUATORS AND ASSOCIATED CABLING. RETAIN CONDUIT FOR RE-USE WHERE APPLICABLE.
- (P) PROVIDE DEMOLITION OF ALL EXISTING 120V RECEPTACLES, INCLUDING WIRING AND CONDUIT.

LEGEND:

- EXISTING
- - - DEMOLISH

MAIN FLOOR PLAN
SCALE: 1 : 20

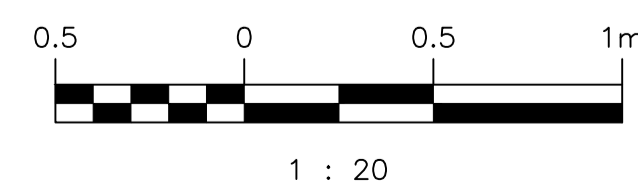

NO.	REVISIONS	DATE	DESIGN	CHECK
00	ISSUED FOR TENDER, BID OPP. 767-2016	2016/08/23	BJC	DB

<p>SNC-LAVALIN INC. 148 Nature Park Way Winnipeg, MB, Canada R3P 0X7 204-786-8080</p>	
DESIGNED BY: B. CLEVEN	CHECKED BY: D. BECKER
DRAWN BY: Y. KONIG	APPROVED BY: I. PARKINSON
SCALE: 1:20	ISSUED FOR CONSTRUCTION BY: K. ZUREK
DATE: 2016/03/23	DATE: 2016-08-29
CONSULTANT NO.:	

ENGINEER'S SEAL

ORIGINAL DRAWING
SEALED BY:
B. J. CLEVEN
SNC-LAVALIN INC.
MEMBER # 31479
2016-08-29
REV. 00

THE CITY OF WINNIPEG
WATER AND WASTE DEPARTMENT

ROUTE 90 UNDERPASS PUMPING STATION
2016 UPGRADES
ELECTRICAL FLOOR PLAN
MAIN FLOOR
DEMOLITION

CITY DRAWING NUMBER	SHEET	REV.	SIZE
1-0310U-E0004	001	00	A1

DRAWING NUMBER	REFERENCE DRAWINGS
----------------	--------------------