


KEYNOTE LEGEND	
1	EXISTING LIGHTING TO BE REVISED TO SUIT NEW ROOM LAYOUT. REFER TO BASEMENT RCP & ELECTRICAL.
2	EXISTING LIGHTING FIXTURES TO BE REMOVED AND REPLACED WITH NEW. REFER TO BASEMENT RCP & ELECTRICAL.
3	AREA OF ACT TO BE DEMOLISHED FOR NEW BULKHEAD. REFER TO BASEMENT RCP FOR DETAILS.
4	EXISTING CEILING AND ASSOCIATED LIGHTING TO BE DEMOLISHED. REFER TO BASEMENT RCP & ELECTRICAL FOR NEW FINISHES & LIGHTING LAYOUT.

DEMOLITION LEGEND	
	EXISTING ACOUSTIC PLASTER
	EXISTING ACOUSTIC CEILING TILE
	EXISTING GYPSUM BOARD, PAINTED
	EXISTING EXPOSED STRUCTURE
	EXISTING TO BE DEMOLISHED
	EXISTING AREA N.I.C.

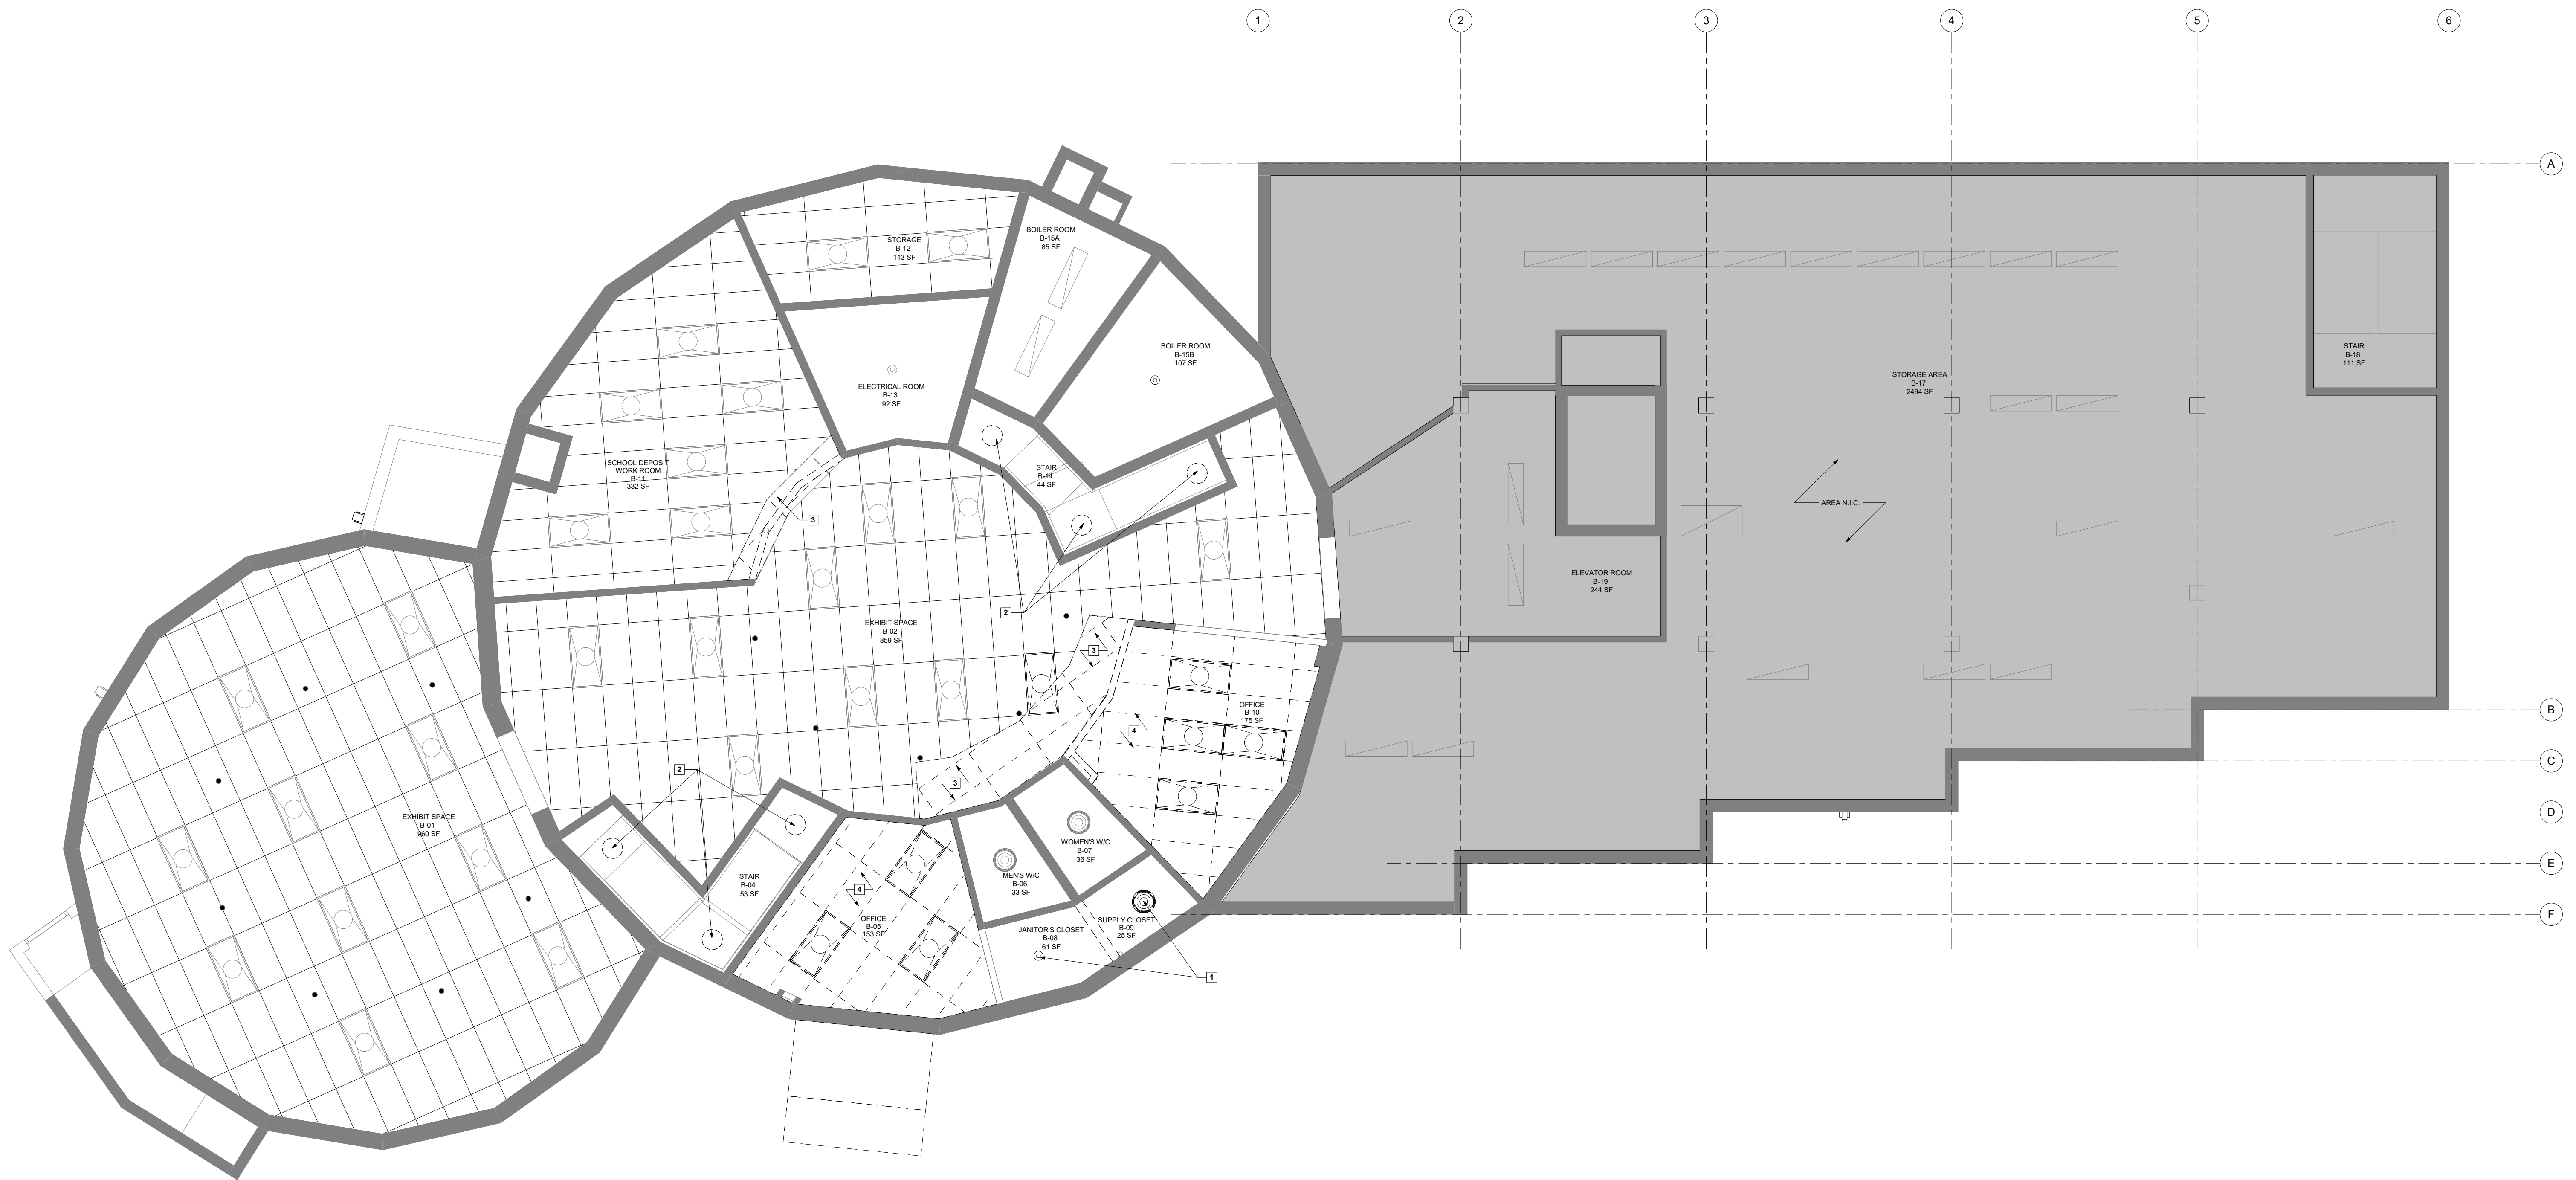

1 DEMO - BASEMENT
3/16" = 1'-0"



Project:
St. Vital Library

6 Fermor Ave. Winnipeg, MB
Project Number: 1605
Bid Opportunity Number: 788-2016

Drawing Title:
DEMOLITION -
BASEMENT RCP

#	Issue/Revision	Date
1	ISSUED FOR CONSTRUCTION	SEPT 9, 2016

Sheet No: D104

This drawing is property of the Architect and cannot be reproduced or used without the consent of the Architect. The contractor is responsible for checking and verifying all levels and dimensions and shall report all discrepancies to the Architect and obtain clarification prior to commencing work.