




1 ELECTRICAL SITE PLAN
SCALE: 1:200

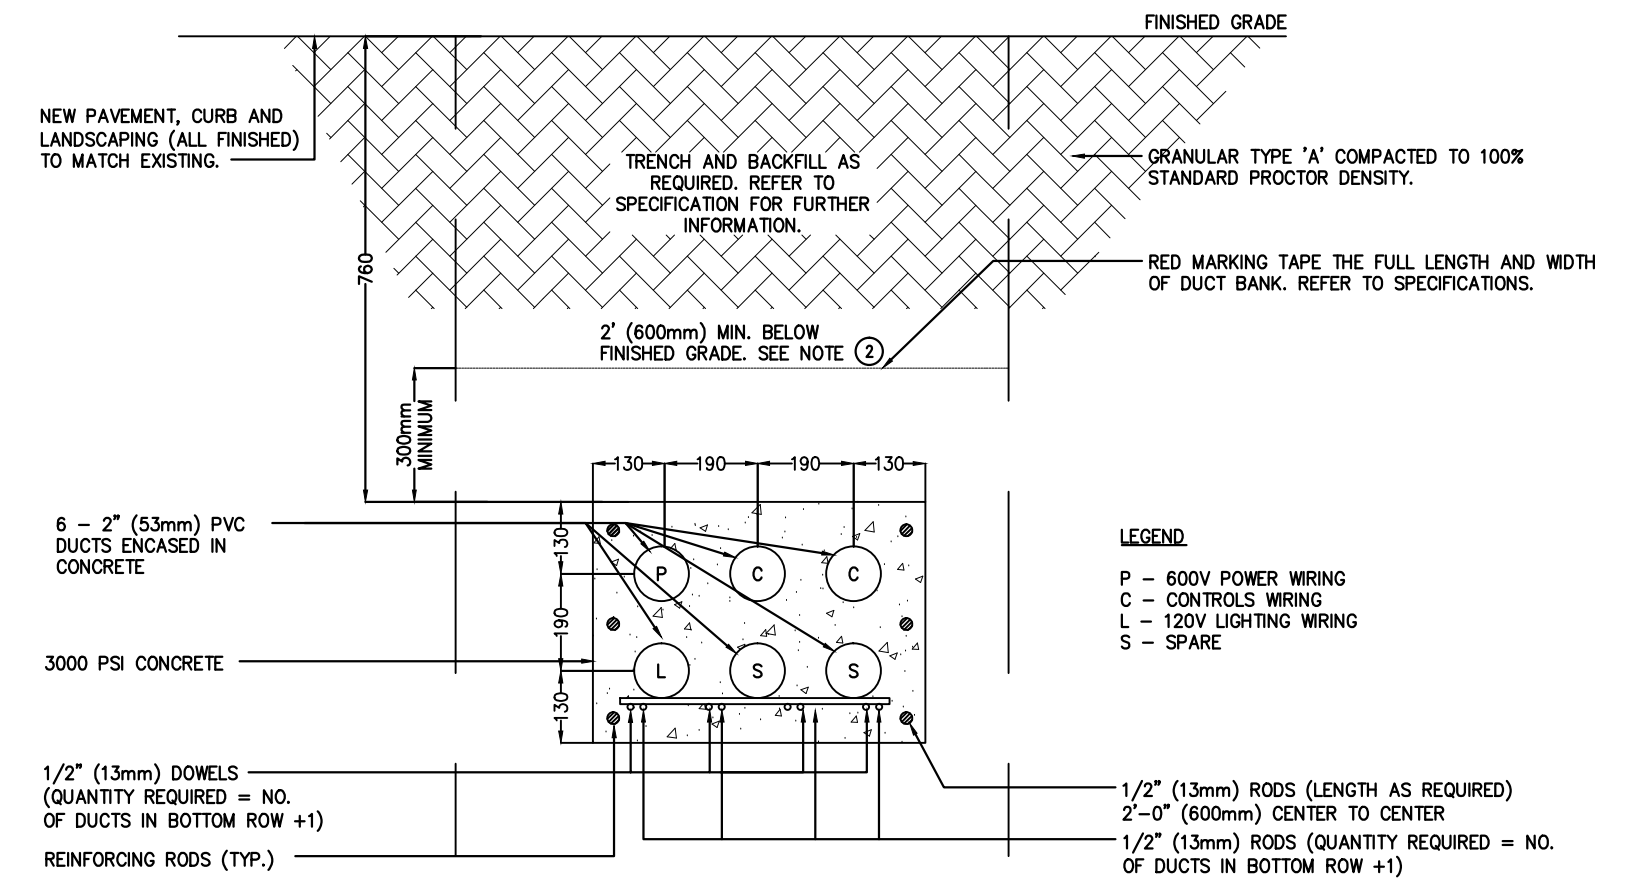


DUCTBANK DETAIL - SECTION 'A-A'

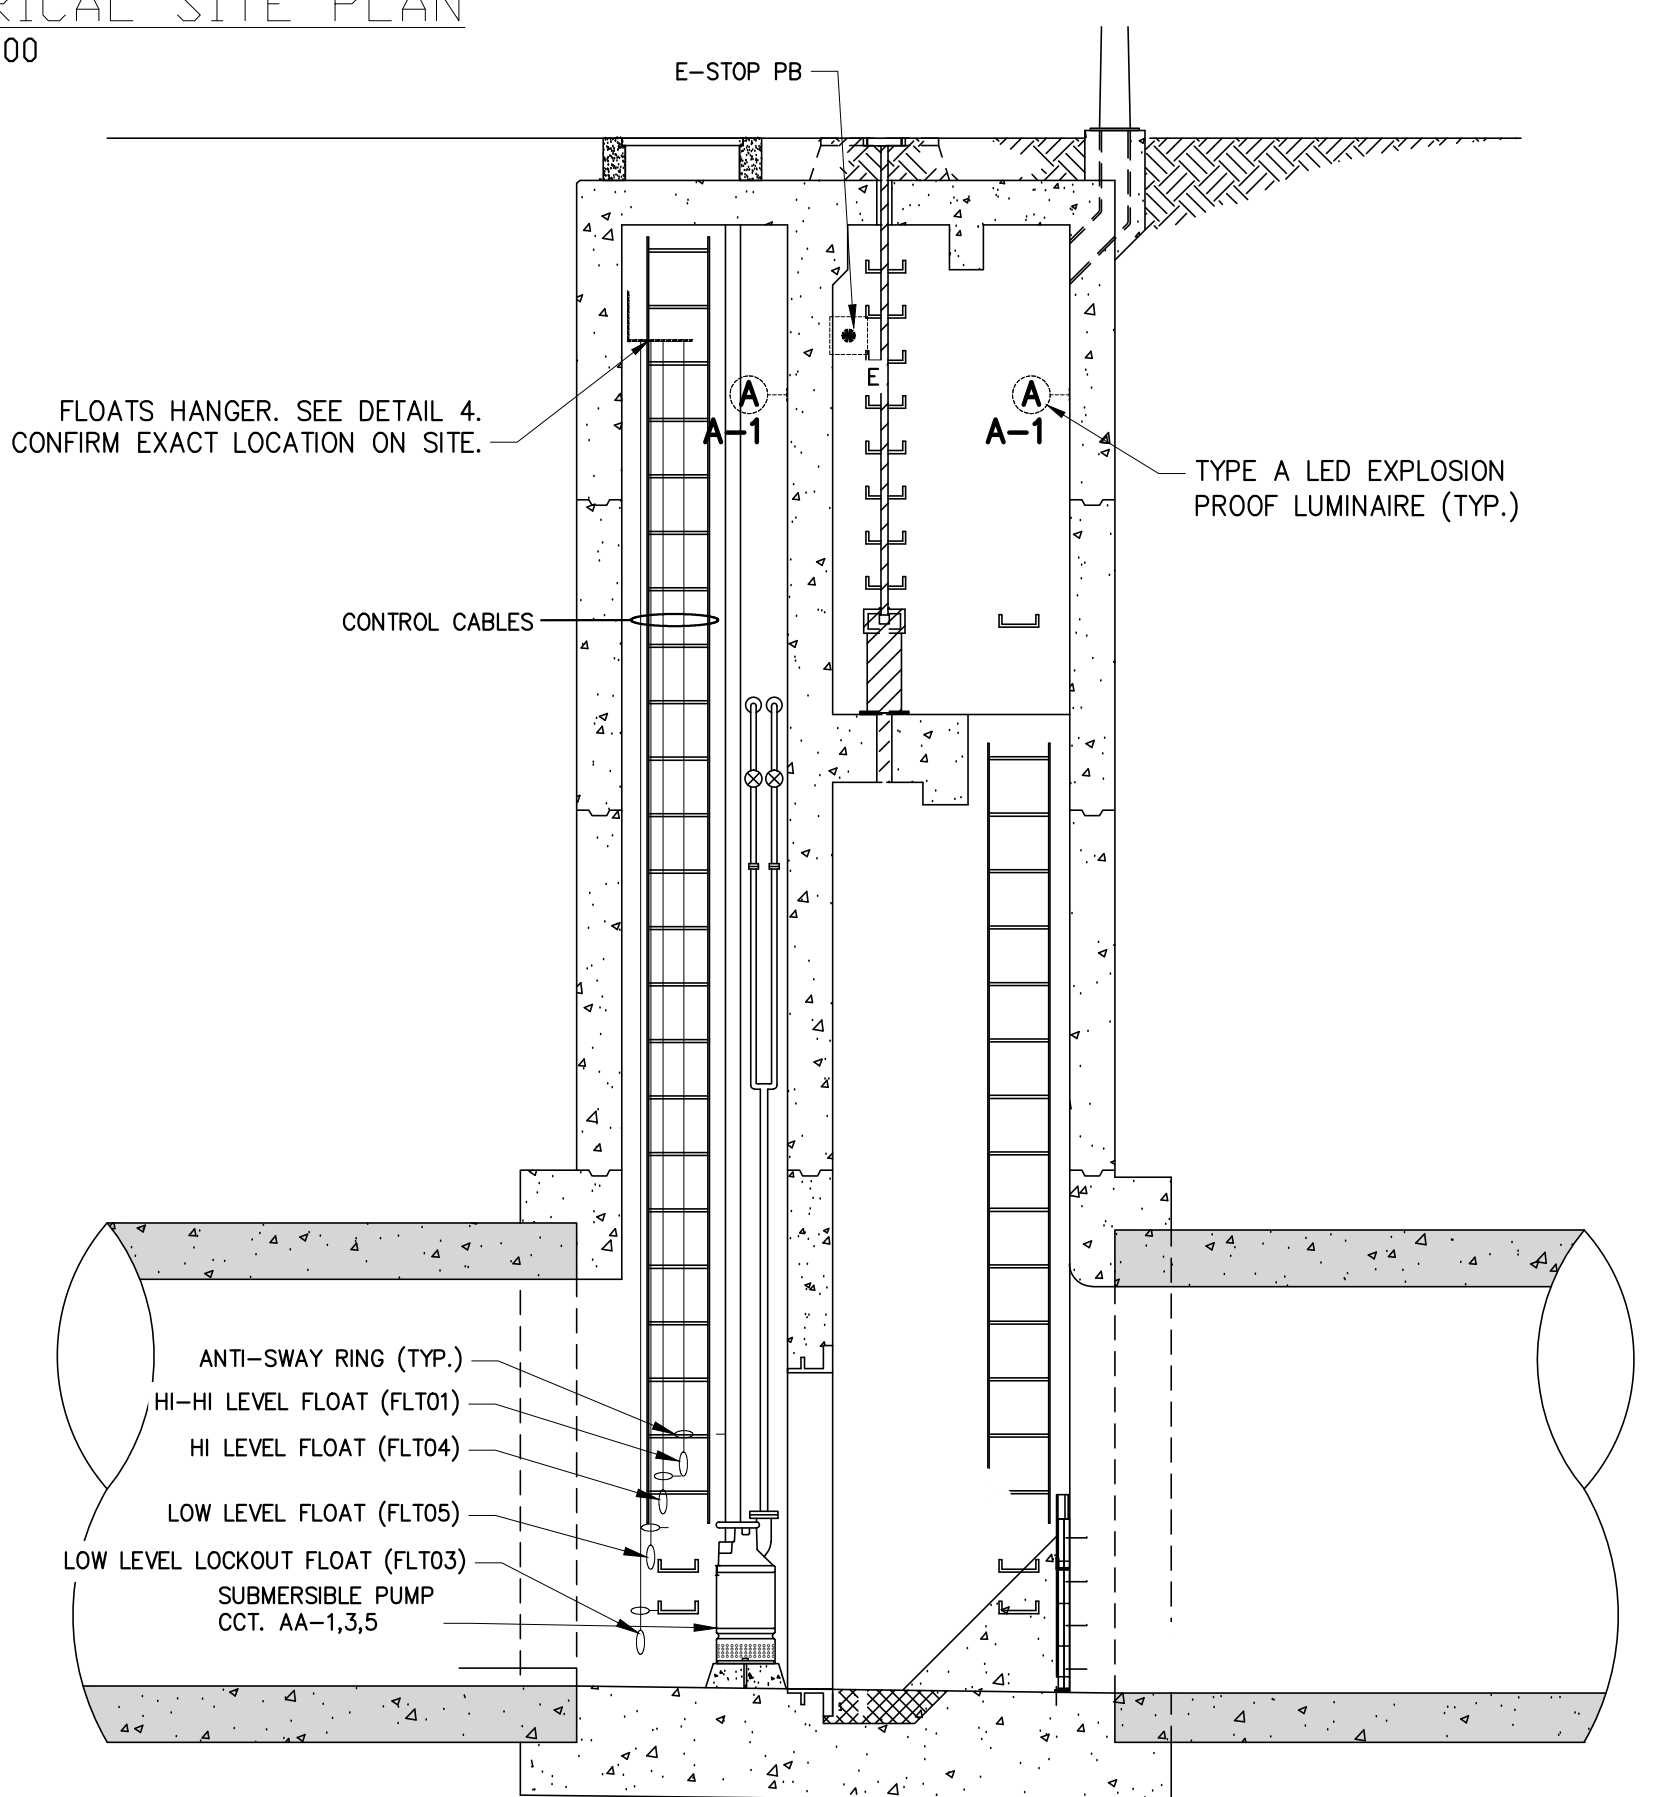


2 SUBMERSIBLE PUMP CHAMBER
SCALE: NTS

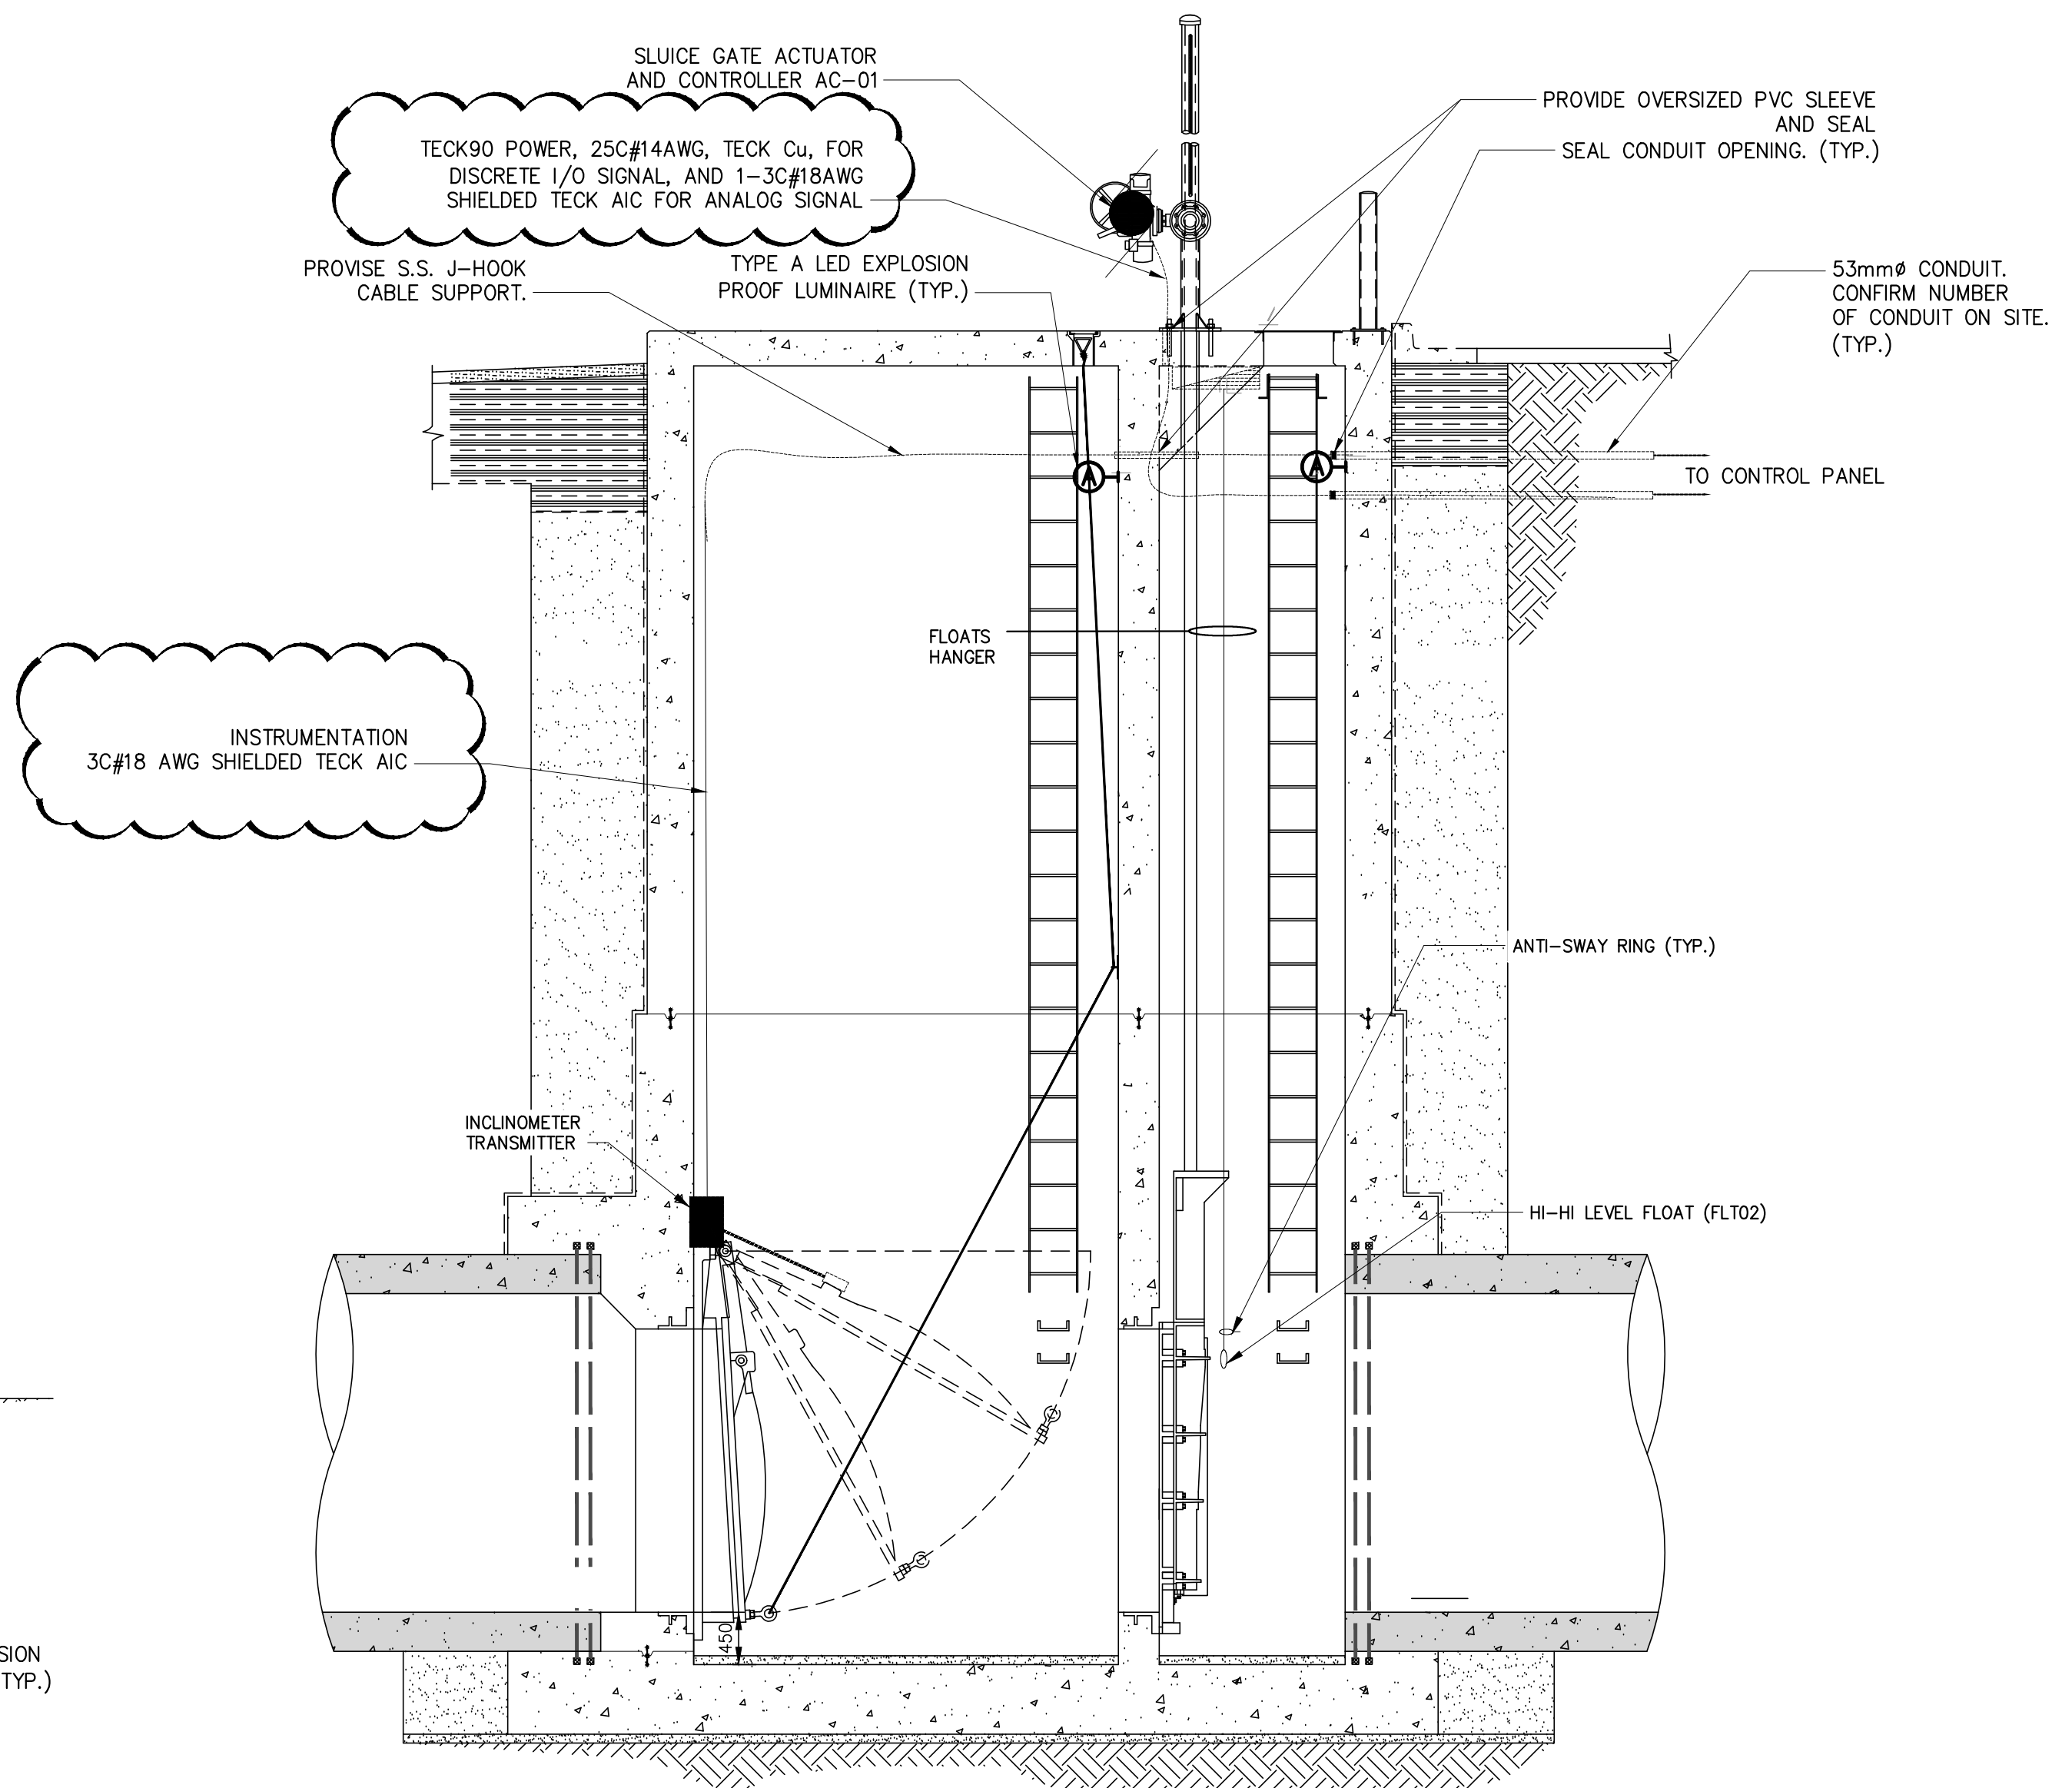

3 GATE CHAMBER
SCALE: NTS

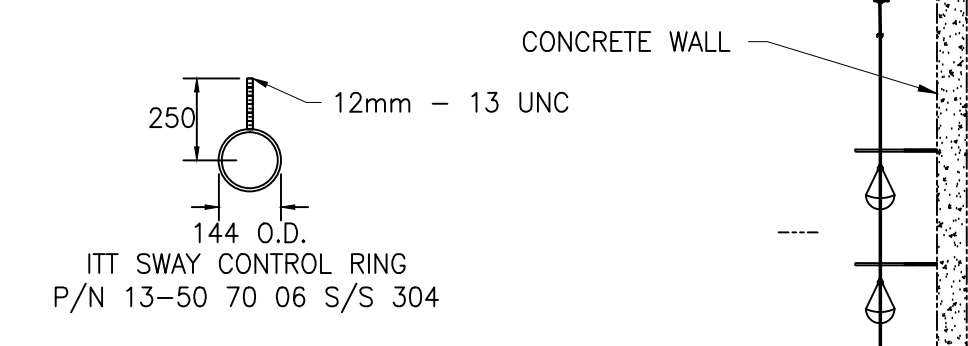

4 FLOAT HANGER (TYP.)
SCALE: NTS

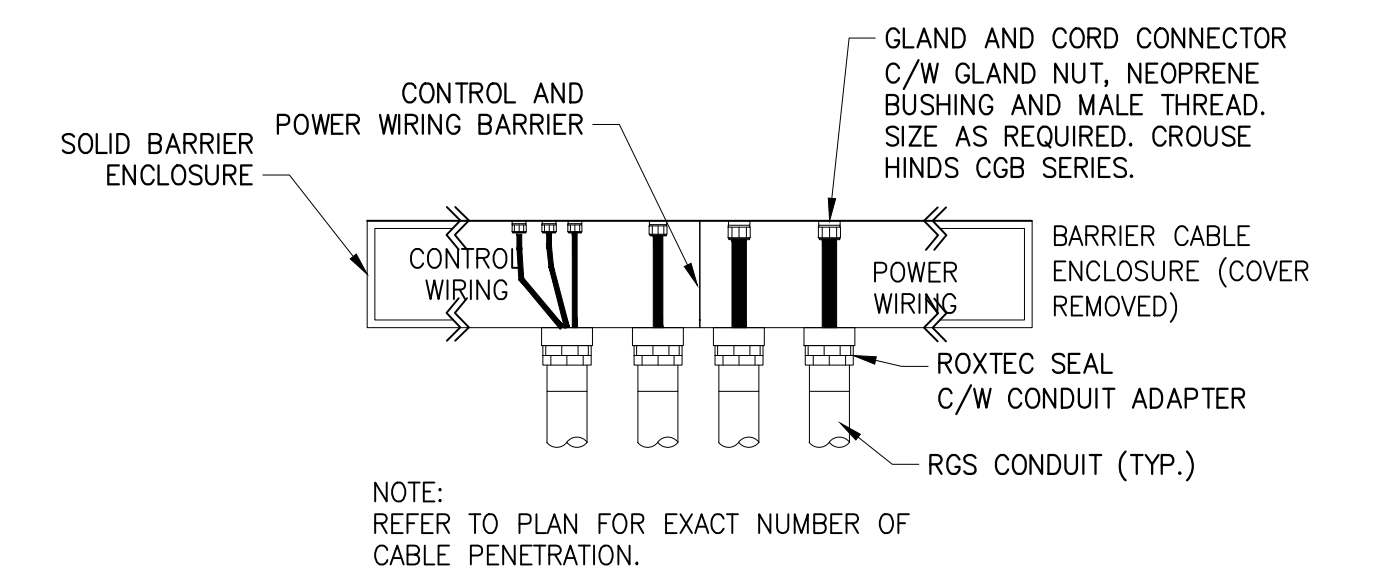

5 WIRING TO CONTROL PANEL (TYP.)
SCALE: NTS

Sep 28, 2016 - 4:26pm
 L:\Projects\2016\Utility\Advisory-MMM-WSP\working\drawing\sheet\sheet1.dwg - tab1-E-2

NOTE: These design documents are prepared solely for the use by the party with whom the design professional has entered into a contract and there are no representations of any kind made by the design professional to any party with whom the design professional has not entered into a contract.

METRIC
WHOLE NUMBERS INDICATE MILLIMETRES
DECIMALIZED NUMBERS INDICATE METRES

APEGM
Certificate of Authorization
WSP Canada Inc.
No. 5750 Date: SEP. 07, 2016

G.M.M. ELEV.			
DESIGNED BY	DG	CHECKED BY	HP
DRAWN BY	DG	APPROVED BY	HP
HOR. SCALE	AS NOTED	RELEASED FOR CONSTRUCTION	
VERTICAL SCALE	AS NOTED		
DATE	2016/09/07	DATE	
NO.	REVISIONS	DATE	BY
2	ISSUED FOR ADDENDUM 1	09/28/16	HP
1	ISSUED FOR TENDER	09/07/16	HP

WSP | MMM GROUP

1600 BUFFALO PLACE, WINNIPEG, MANITOBA CANADA R3T 8B8
PHONE: 204-477-6650 FAX: 204-474-2864 WWW.WSPGROUP.COM

DESIGNED BY: DG CHECKED BY: HP
DRAWN BY: DG APPROVED BY: HP

PROVINCE OF MANITOBA
REGISTERED PROFESSIONAL ENGINEER
P/NO. 4055
PROCYSHYN

BID OPPORTUNITY: 789-2016
PLOT DATE: 2016/09/07

THE CITY OF WINNIPEG
WATER AND WASTE DEPARTMENT

OUTFALL GATE CHAMBER UPGRADES
RUBY STREET
SRS OUTFALL GATE CHAMBER
ELECTRICAL SITE PLAN AND CHAMBER DETAILS

CONSULTANT DRAWING NUMBER: 5516047 - E02
SHEET 14 OF 34
CITY DRAWING NUMBER: LD-7935