


1 DEMOLITION - BUILDING FLOOR PLAN
M1 1:50

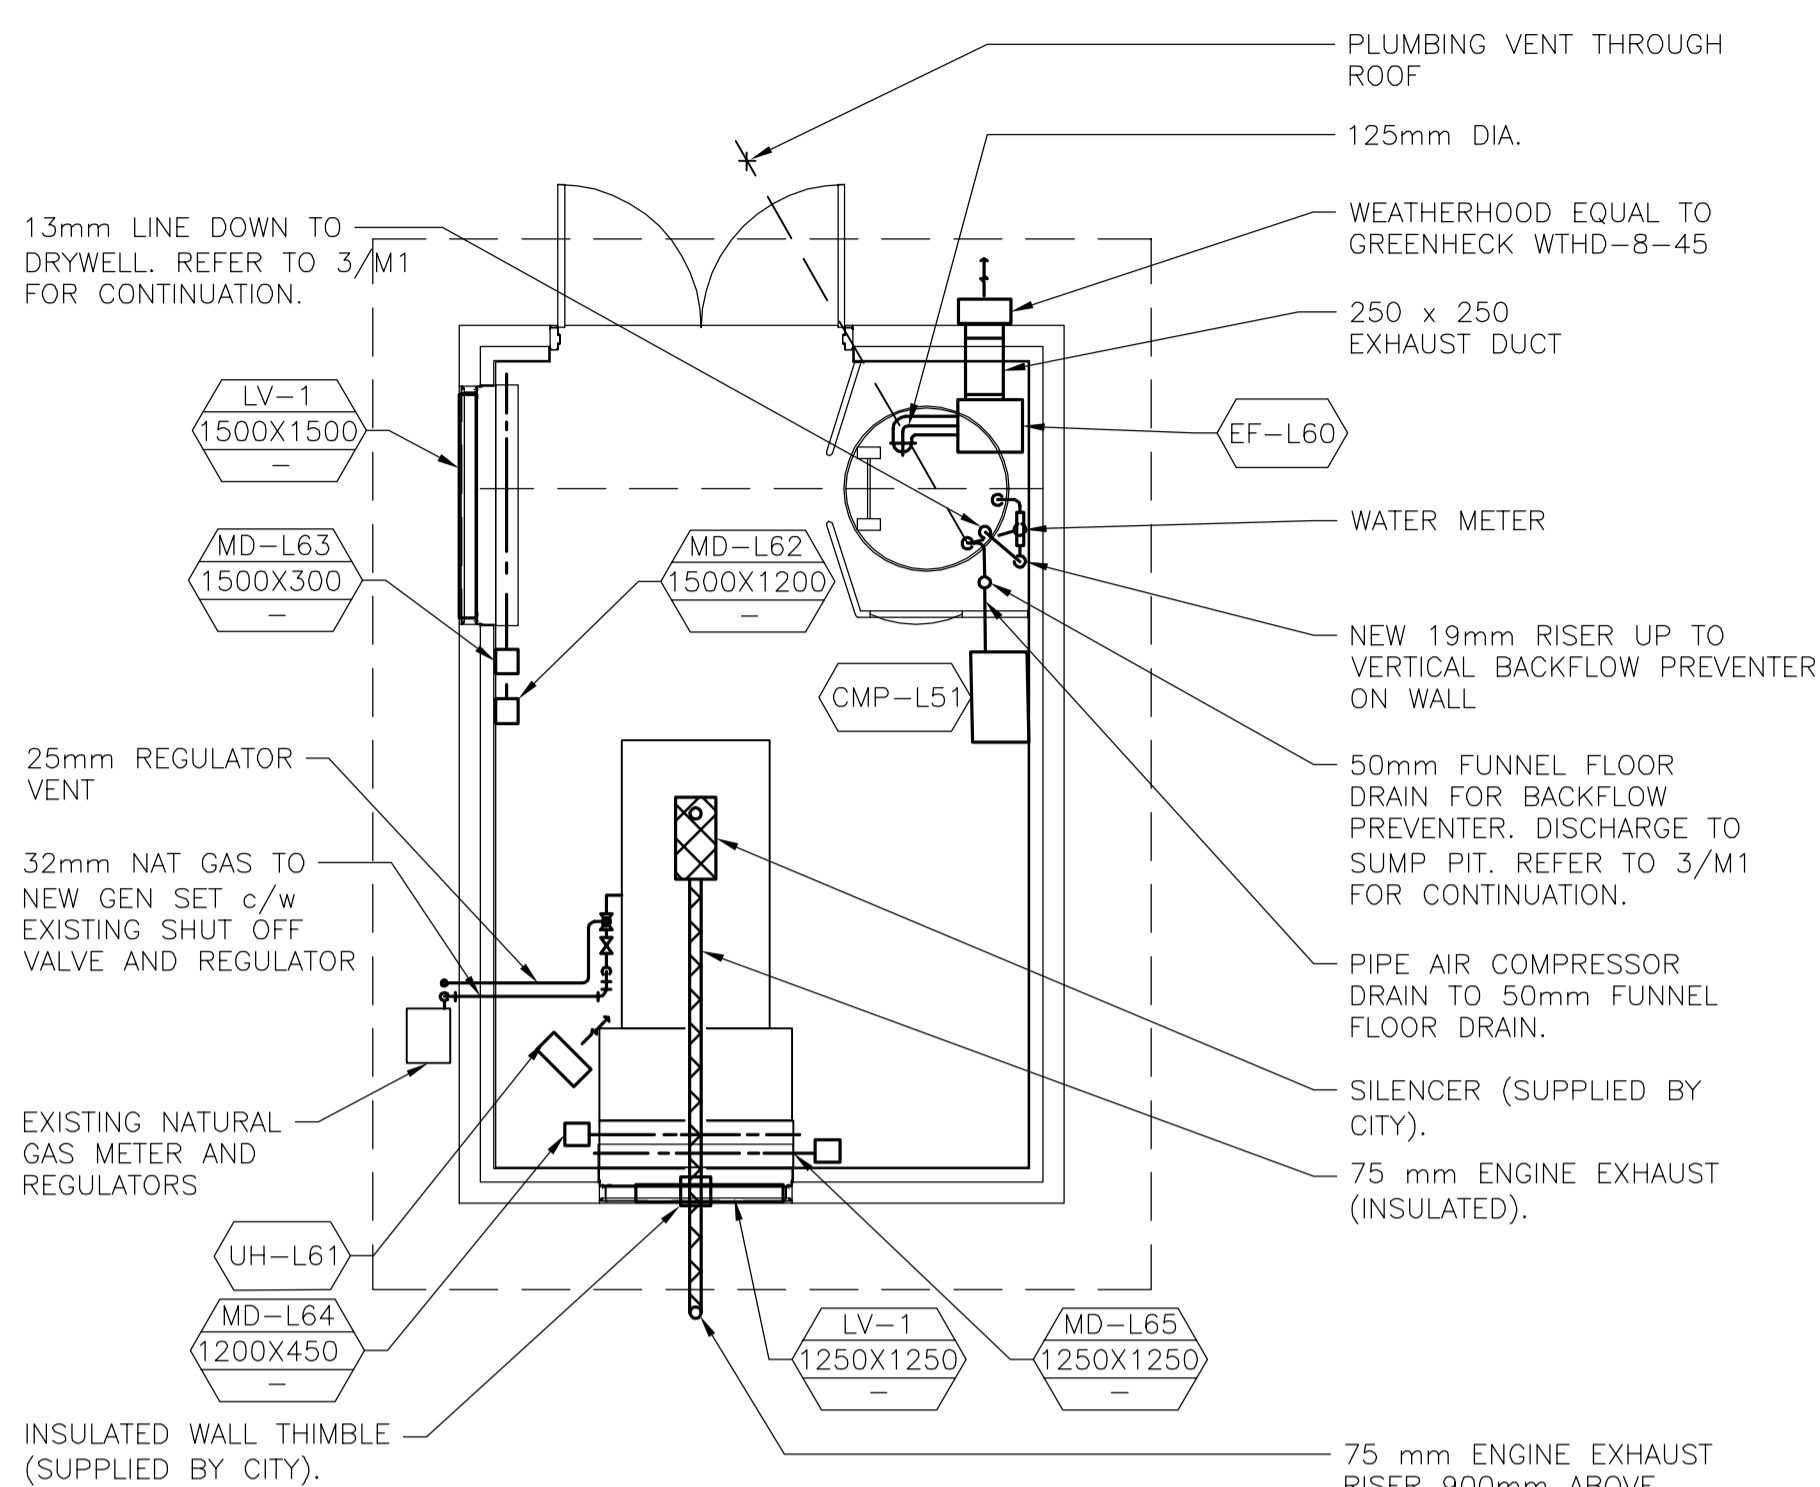

2 NEW WORK - BUILDING FLOOR PLAN
M1 1:50

UNIT HEATER, UH-L61

EQUAL TO OUELLET MODEL OAS05036, CAPACITY: 5Kw, 600v/3PH, 1/2 HP MOTOR c/w BRACKETS FOR CEILING MOUNTING AND BUILT-IN THERMOSTAT.

EXHAUST FAN, EF-L60

EQUAL TO GREENHECK MODEL SQ-60-VG, CAPACITY: 80cfm @ 0.25" S.P., 120V/1PH, 1/2 HP MOTOR c/w 2-SPEED OPERATION.

SUMP PUMP, P-L04


EQUAL TO LITTLE GIANT MODEL TENH-CIA-SFS, CAPACITY: 25gpm @ 35' HEAD, 120V/1PH, 1/2 HP MOTOR

AIR COMPRESSOR, CMP-L51

EQUAL TO ATLAS COPCO MODEL Lfx 0.7 TANK MOUNTED. CAPACITY: 1.35 l/s(2.86cfm) @ 10BAR(145psig), 120V/1PH, c/w SOLENOID VALVE AND ELECTRONIC TIMER DRAIN.

LOUVERS, LV-1

EQUAL TO PRICE DE439 c/w BIRD SCREEN.

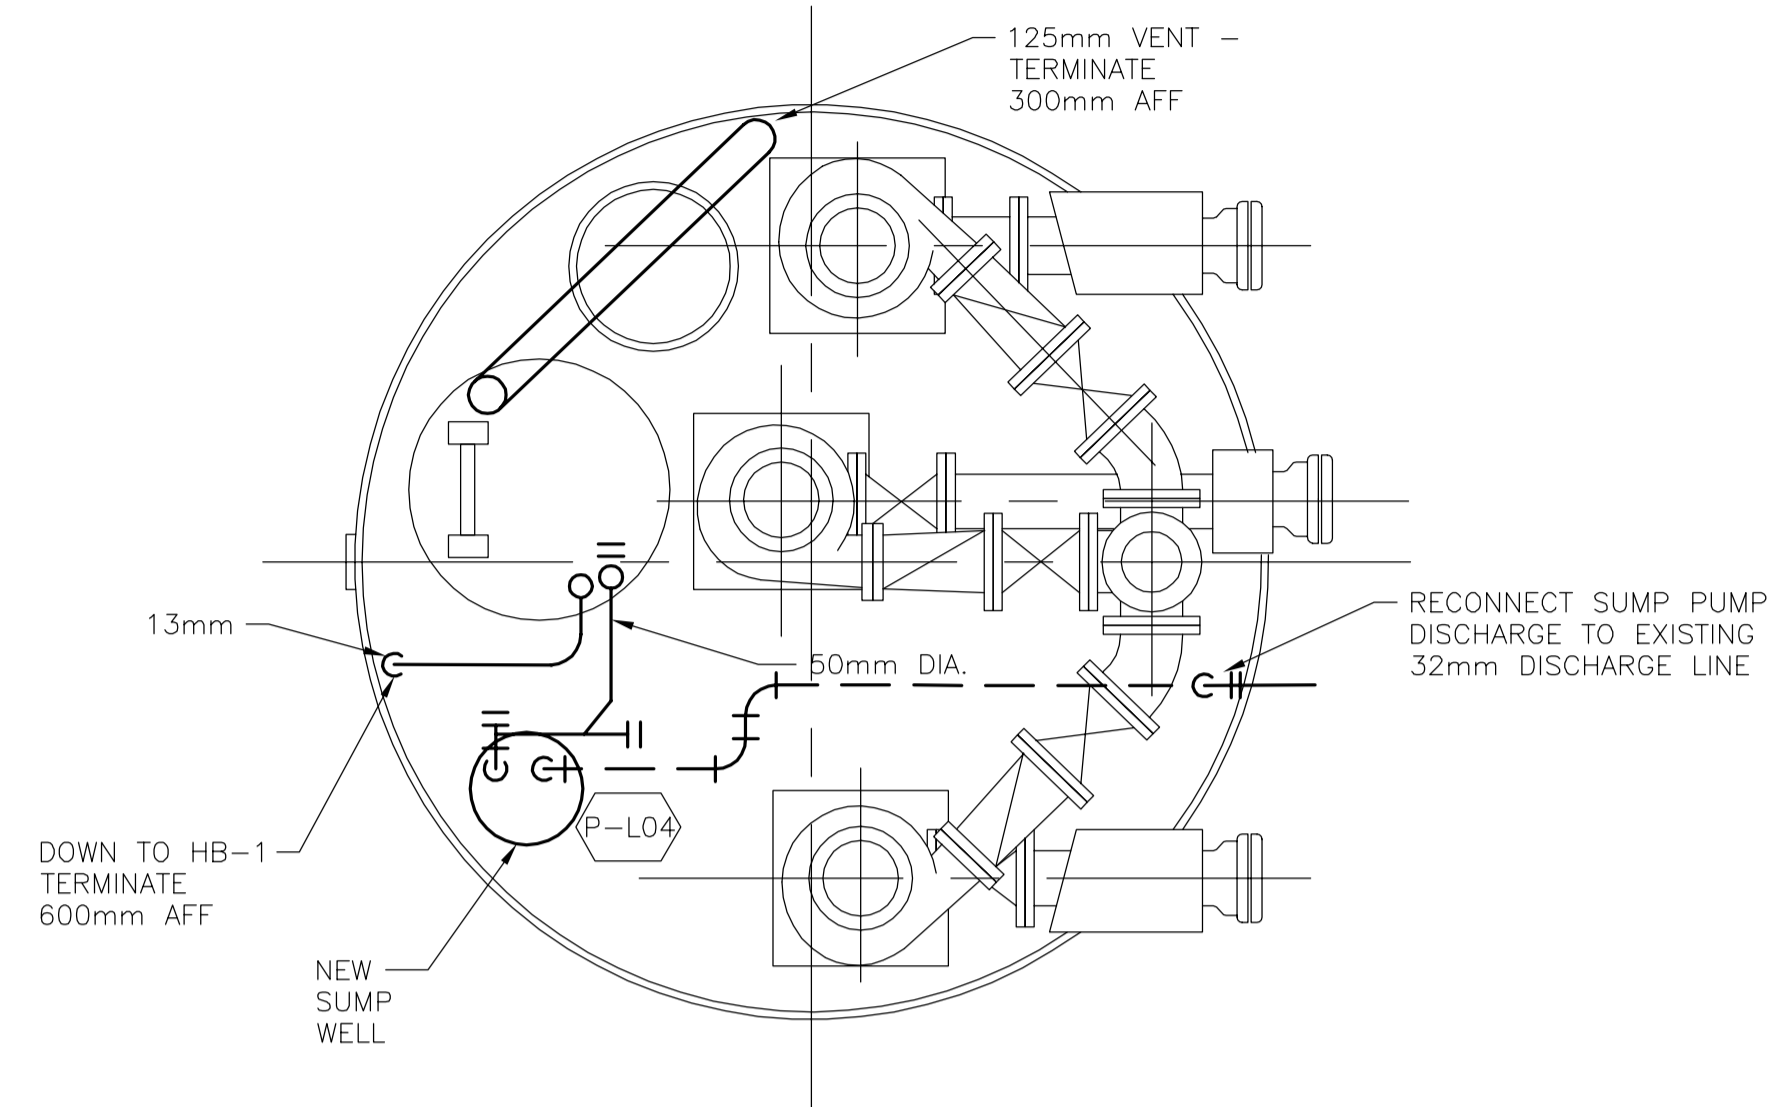

3 STATION FLOOR PLAN
M1 1:25



LEGEND	
SYMBOL	DESCRIPTION
DCW-13	DOMESTIC COLD WATER
---	SANITARY
⊗	GATE VALVE
▭	REDUCER
⊙	PUMP
⊖	PRESSURE SWITCH
⊕	T&P VALVE
⊗	FIRE EXTINGUISHER
EQ-??	EQUIPMENT LABEL
▨	EXTERNALLY INSULATED
MD	MOTORIZED DAMPER
→	AIRFLOW DIRECTION
WM	WATER METER
BFP	BACKFLOW PREVENTER
MARK SIZE L/s	LOUVER LABEL

GENERAL NOTES:

1. MOUNT MD-L64 IN 1200x450 OPENING ON TOP OF GENSET EXHAUST PLENUM. NEW GENSET EXHAUST PLENUM TO MATCH EXISTING, ALSO REFER TO GIVEN GENSET SHOP DRAWINGS.



B.M. ELEV.	DESIGNED BY	PT
	DRAWN BY	JV
	CHECKED BY	PT
	APPROVED BY	
B	ISSUED FOR BID OP. 803-2016	16-09-14 PT
A	ISSUED FOR 75% REVIEW	16-06-17 PT
NO.	REVISIONS	DATE BY DATE

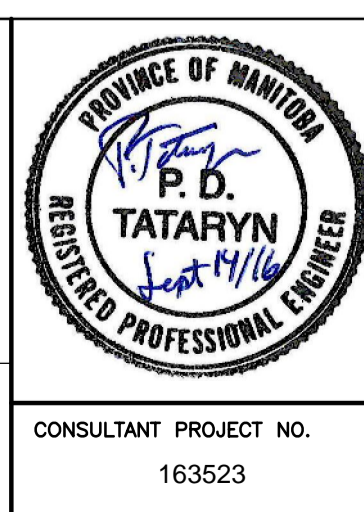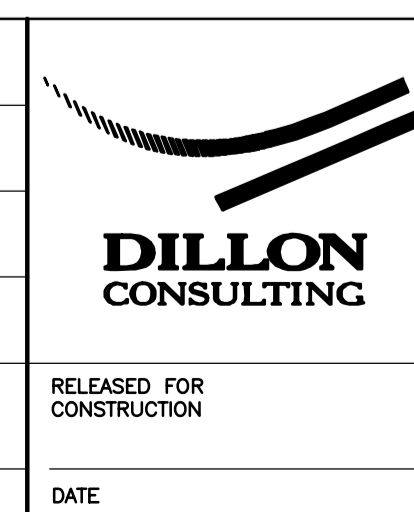

THE CITY OF WINNIPEG
WATER AND WASTE DEPARTMENT

BURROWS WASTEWATER PUMPING STATION UPGRADES
PLUMBING AND HVAC PLANS AND SECTIONS

CITY DRAWING NUMBER: 1-0121L-M0001-001
SHEET 6 OF 16

CONSULTANT PROJECT NO. 163523

M-1