


SECOND FLOOR POWER & MISC. LAYOUT
 1:100

NOTE:
 CONTROL PANEL M1HV16 WAS SUPPLIED BY MECHANICAL TRADES, INSTALLED BY ELECTRICAL CONTRACTOR

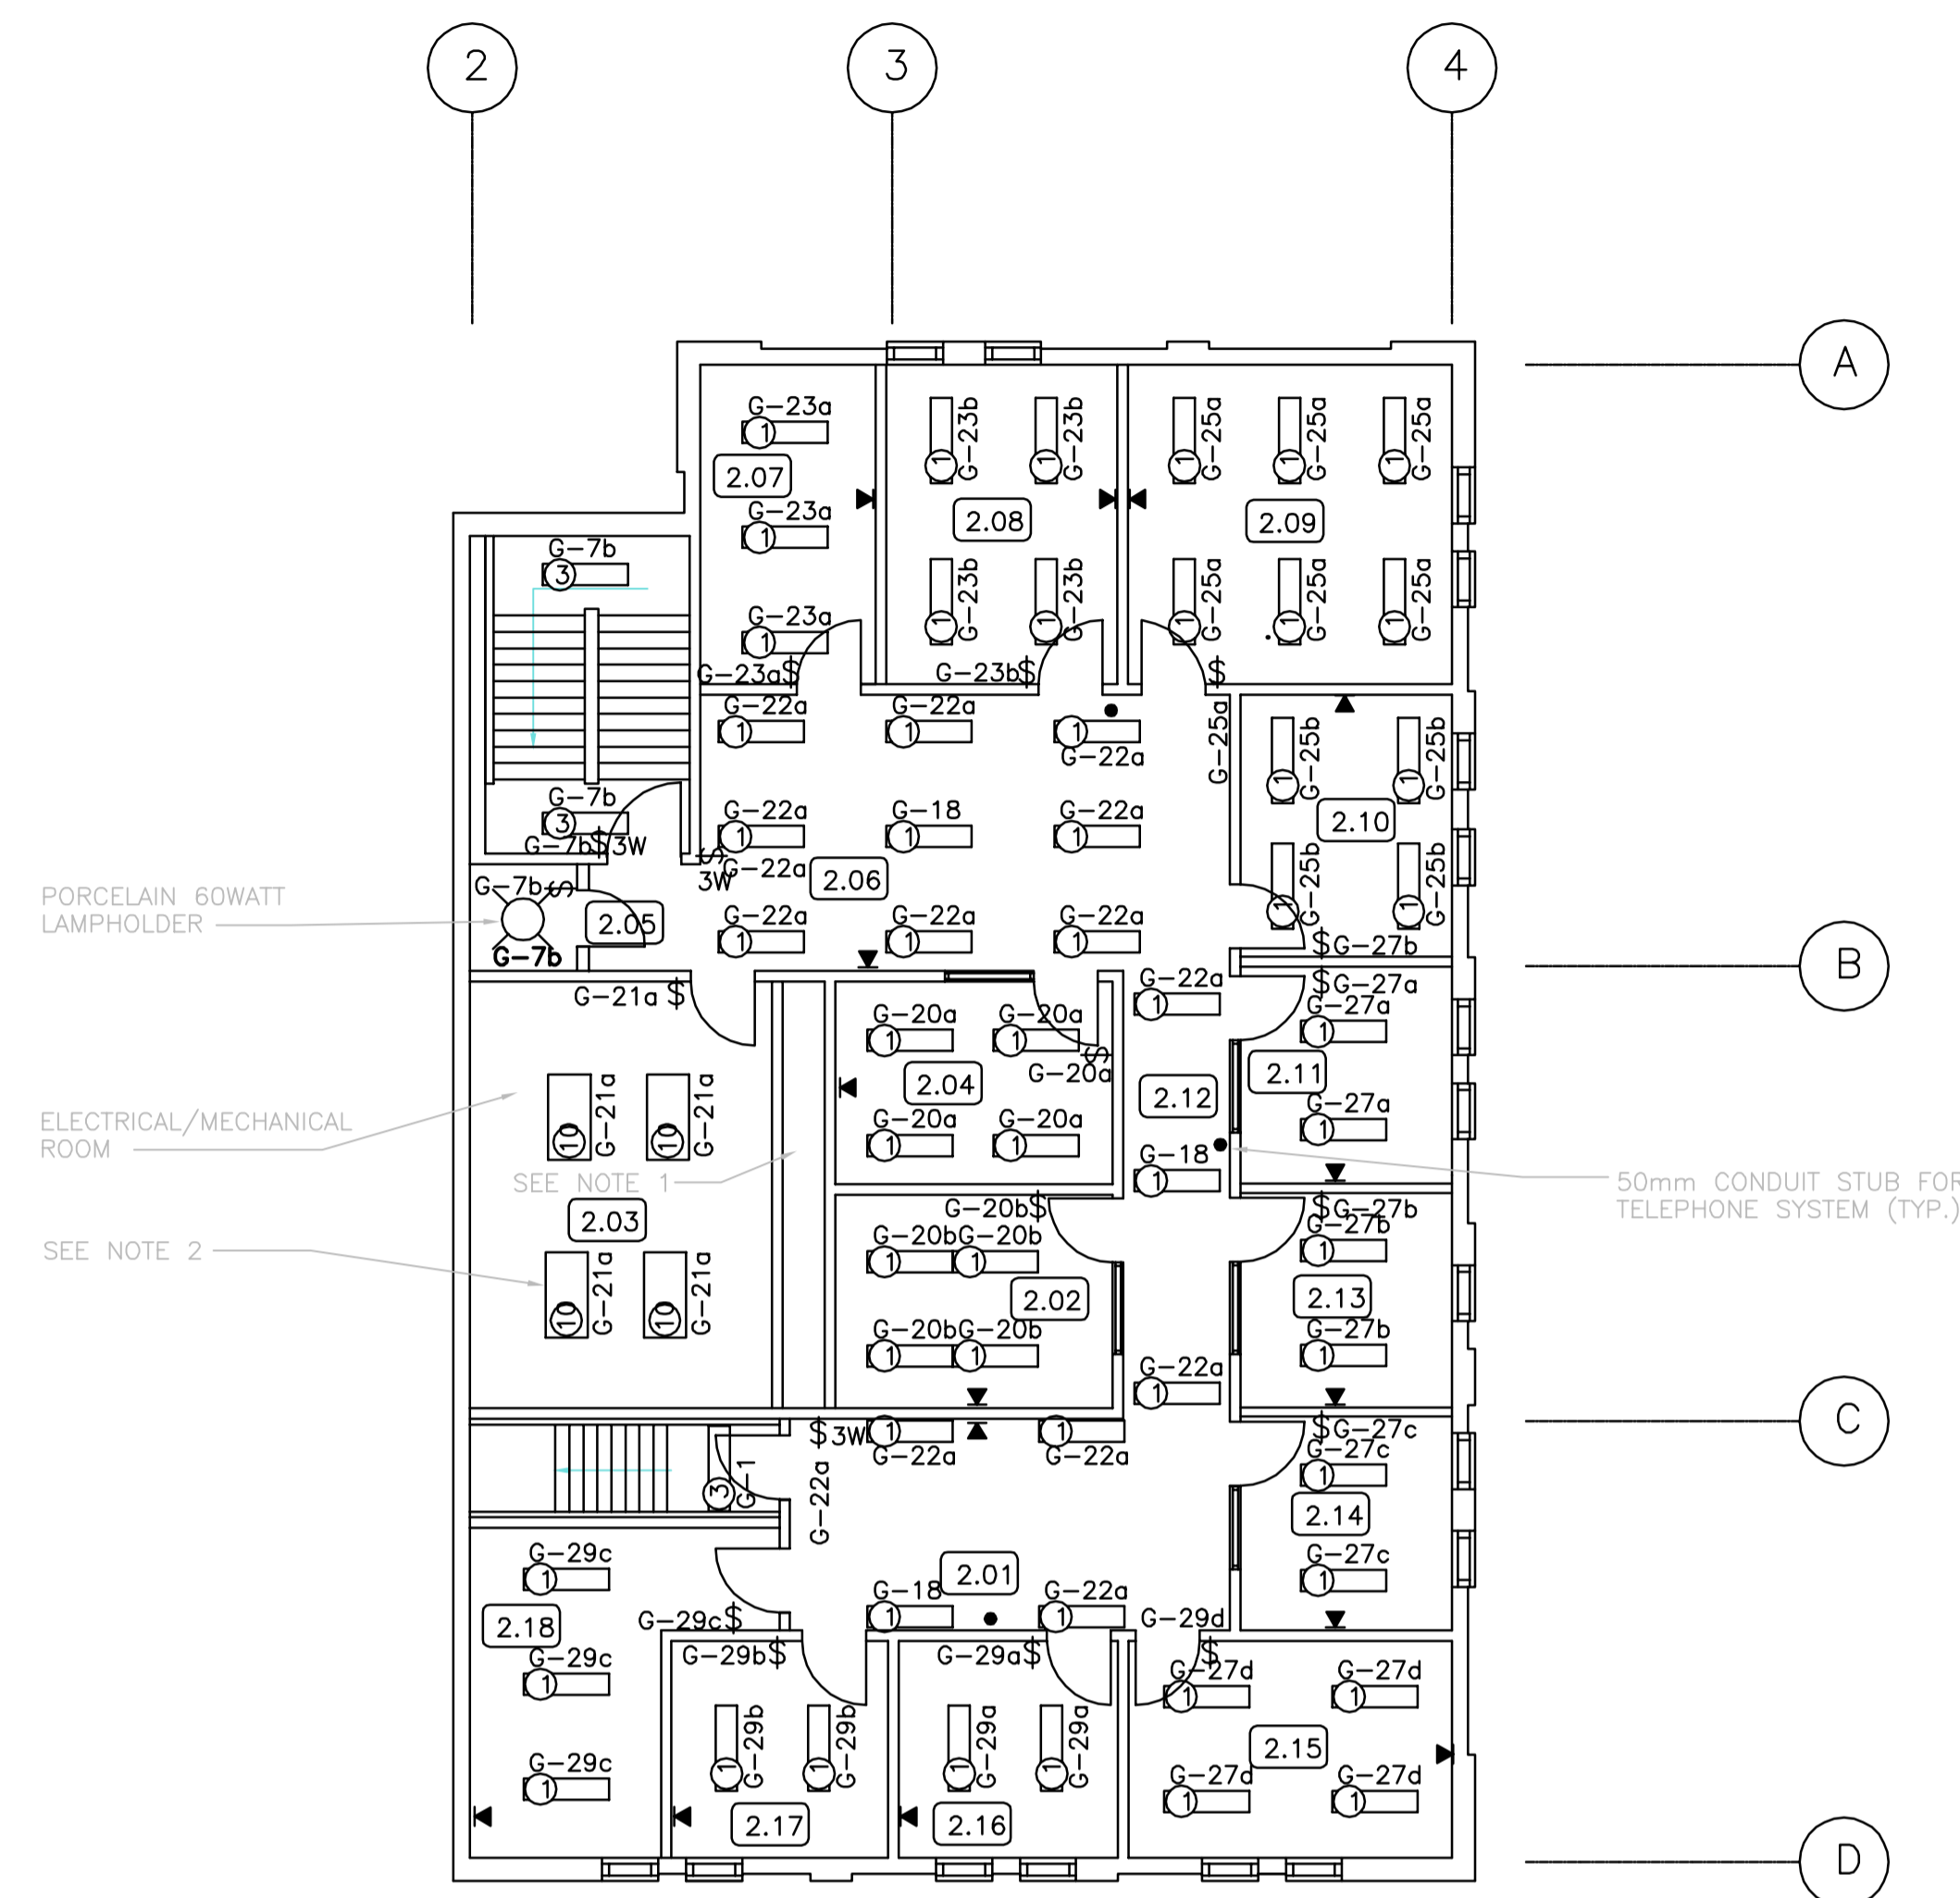

SECOND FLOOR LIGHTING & TELEPHONE LAYOUT
 1:100

NOTE:
 1. CONTRACTOR UTILIZED PIPE CHASE FOR RUNNING CONDUITS BETWEEN MAIN & SECOND FLOOR.
 2. FIXTURES TYPE 10 ARE SYLVANIA 2314

AS-BUILT
 DATE JULY/91 BY R.A.H.
 CHECKED BY _____

B.M. ELEV.	Wardrop MacLaren ENGINEERING CONSULTANTS		ENGINEER'S SEAL	THE CITY OF WINNIPEG WORKS AND OPERATIONS DIVISION WATERWORKS, WASTE & DISPOSAL DEPARTMENT	
DESIGNED BY R.A.H.	CHECKED BY	NORTH END WATER POLLUTION CONTROL CENTRE		CITY DRAWING NUMBER	
DRAWN BY N.B.	APPROVED BY	MAIN BUILDING RENOVATIONS-ELECTRICAL		SHEET OF	
1 ISSUED FOR BID OP#895-2016 16/10	HOR. SCALE: 1:100	SECOND FLOOR PLAN		NEP-1539A	
0 AS CONSTRUCTED 91/07 R.A.H.	VERTICAL: 1:100	LIGHTING & POWER LAYOUT			
NO. REVISIONS	DATE BY	DATE JUNE/91	RELEASED FOR CONSTRUCTION: DATE	CONSULTANT DRAWING NO. 880012-01-03	