


LAB BUILDING PARTIAL ROOF PLAN
1:100


NOTES:

1. AREA OF EXISTING STRENGTHENED PRECAST HAYDITE PANELS.
2. SNOW PILE UP ON SHEET S-01.
3. CONFIRM AHU DIMENSION PRIOR TO COMMENCING WORK.


- DENOTES EXISTING PLATFORM FRAMING
- ===== DENOTES NEW STEEL AS DETAILED
- - - - - OUTLINE OF PROPOSED AHU CURB

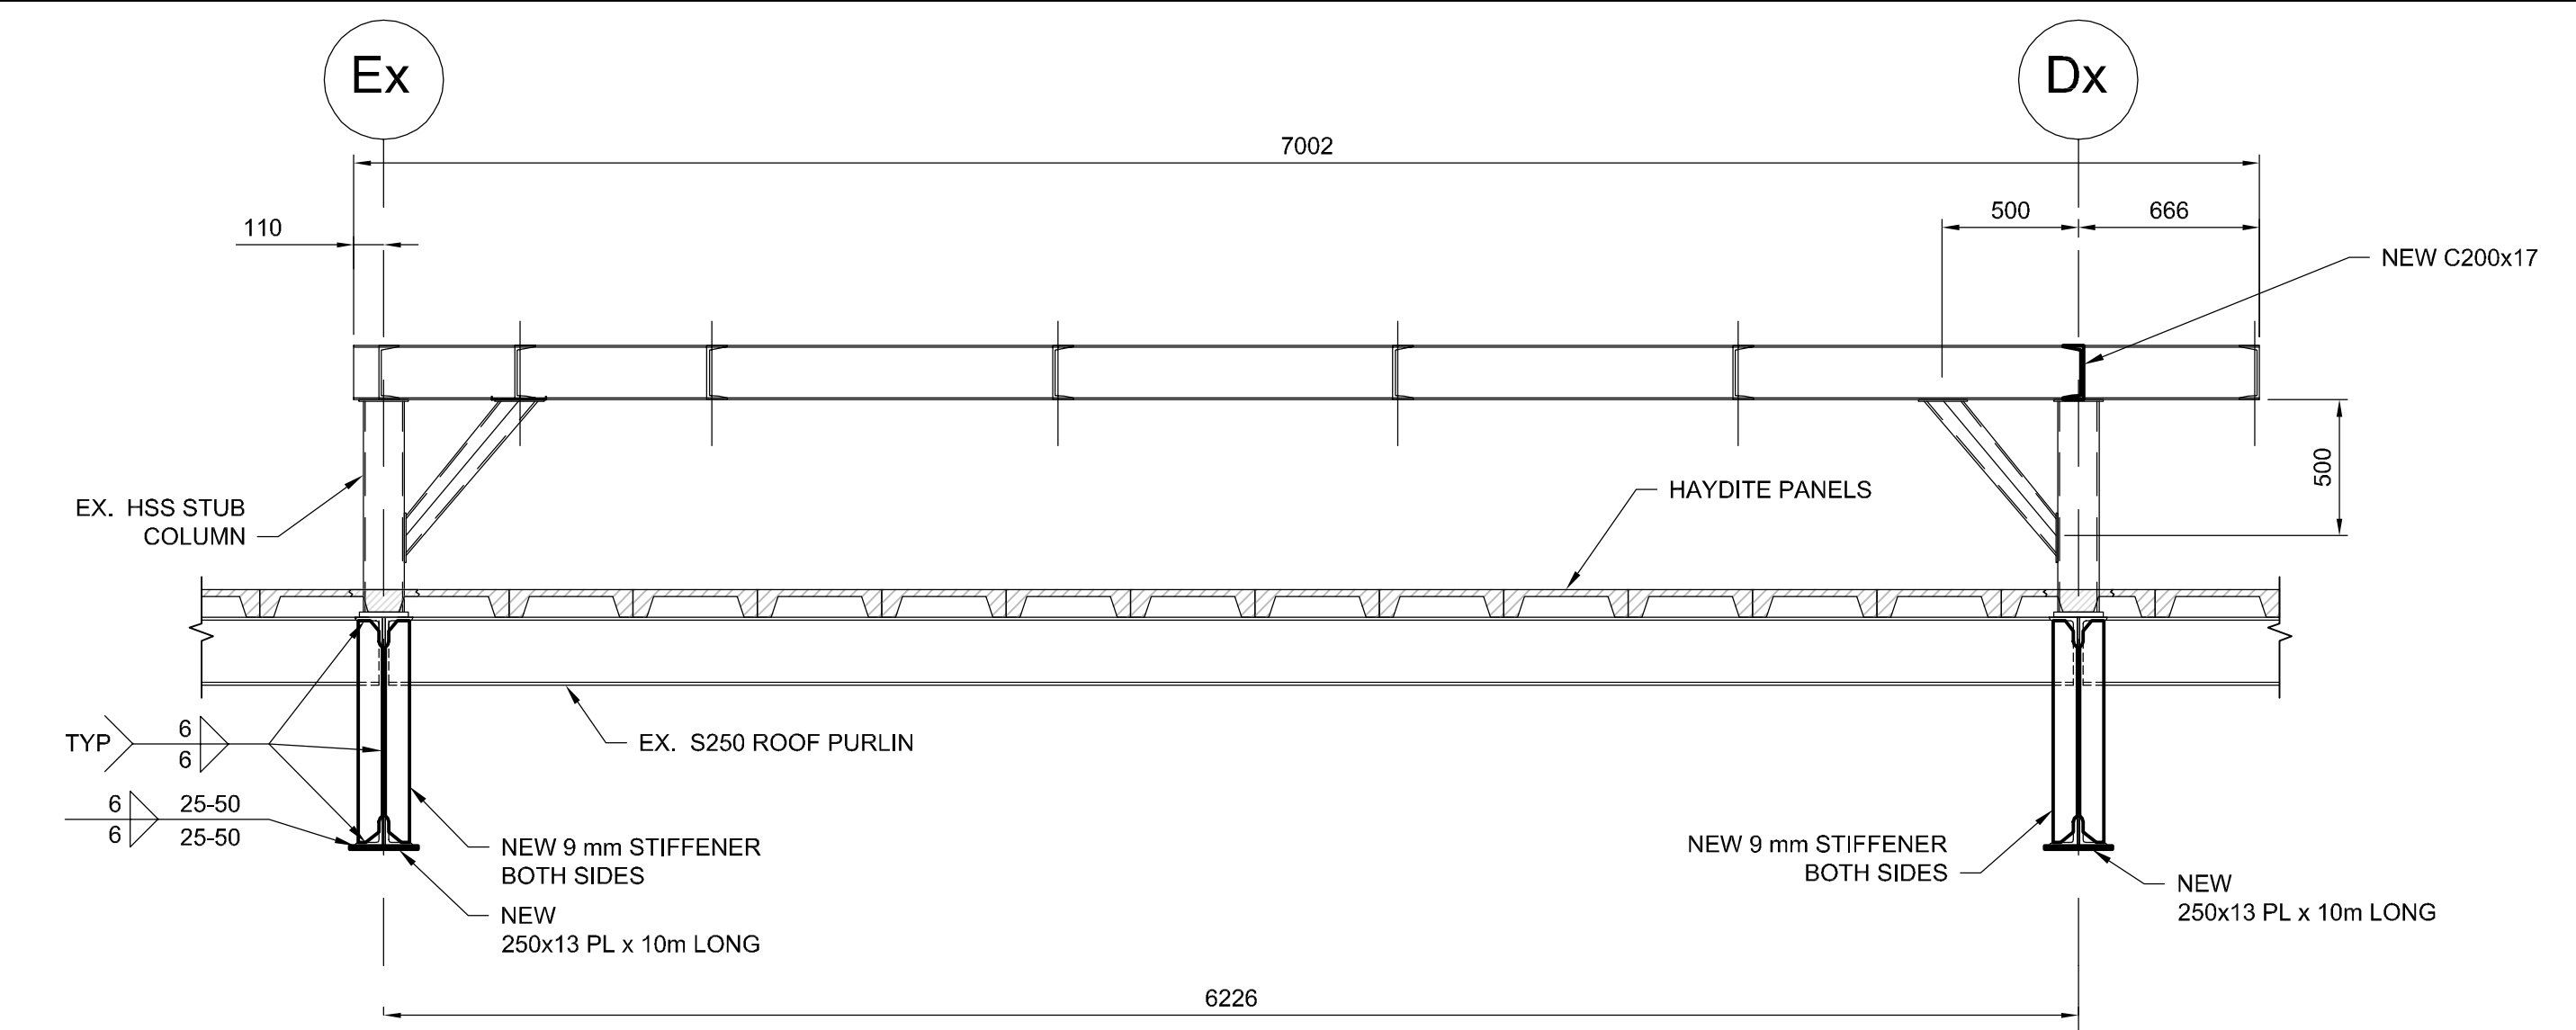

F SECTION
1:25

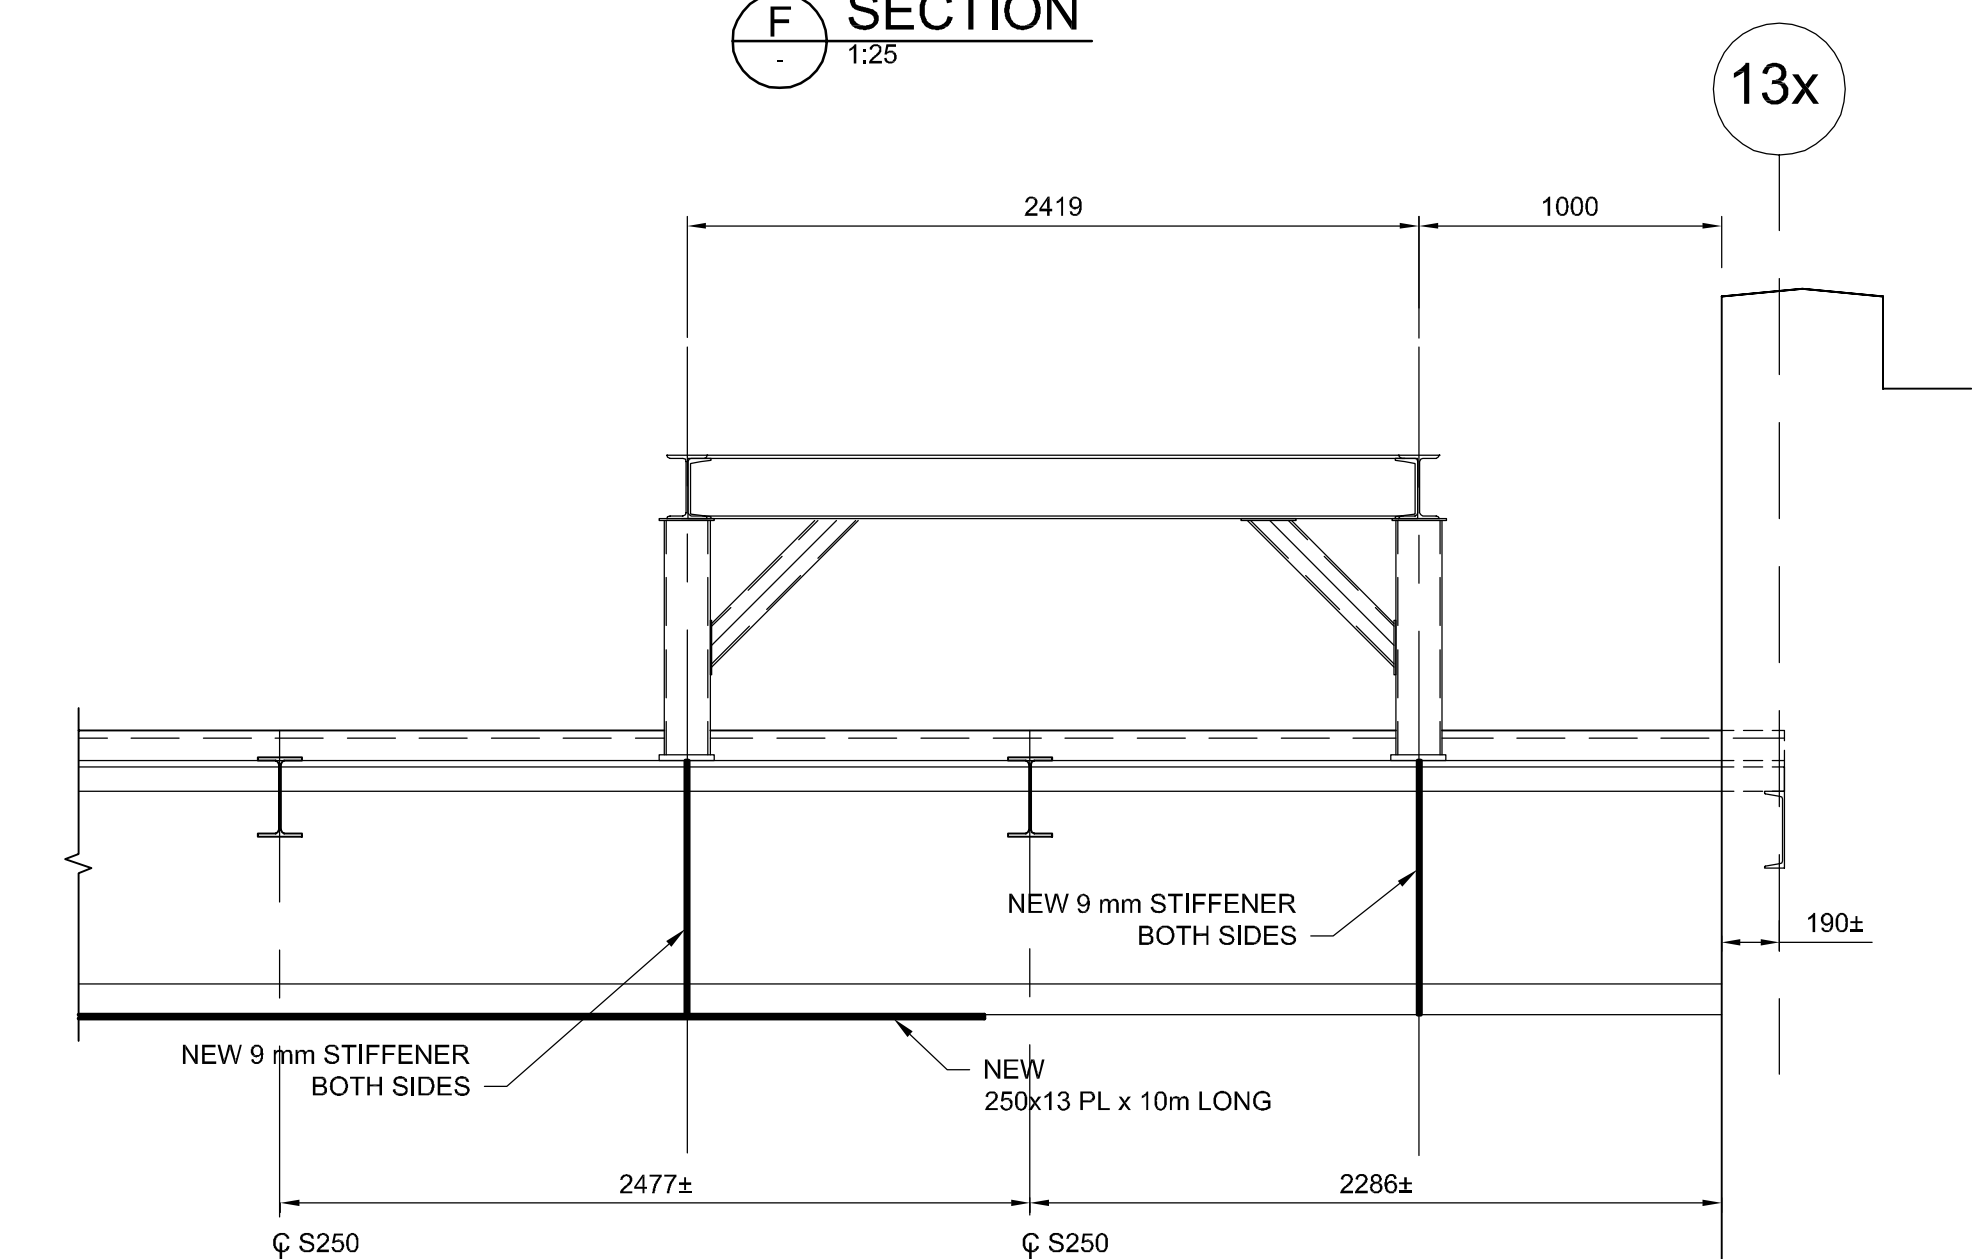

G SECTION
1:25

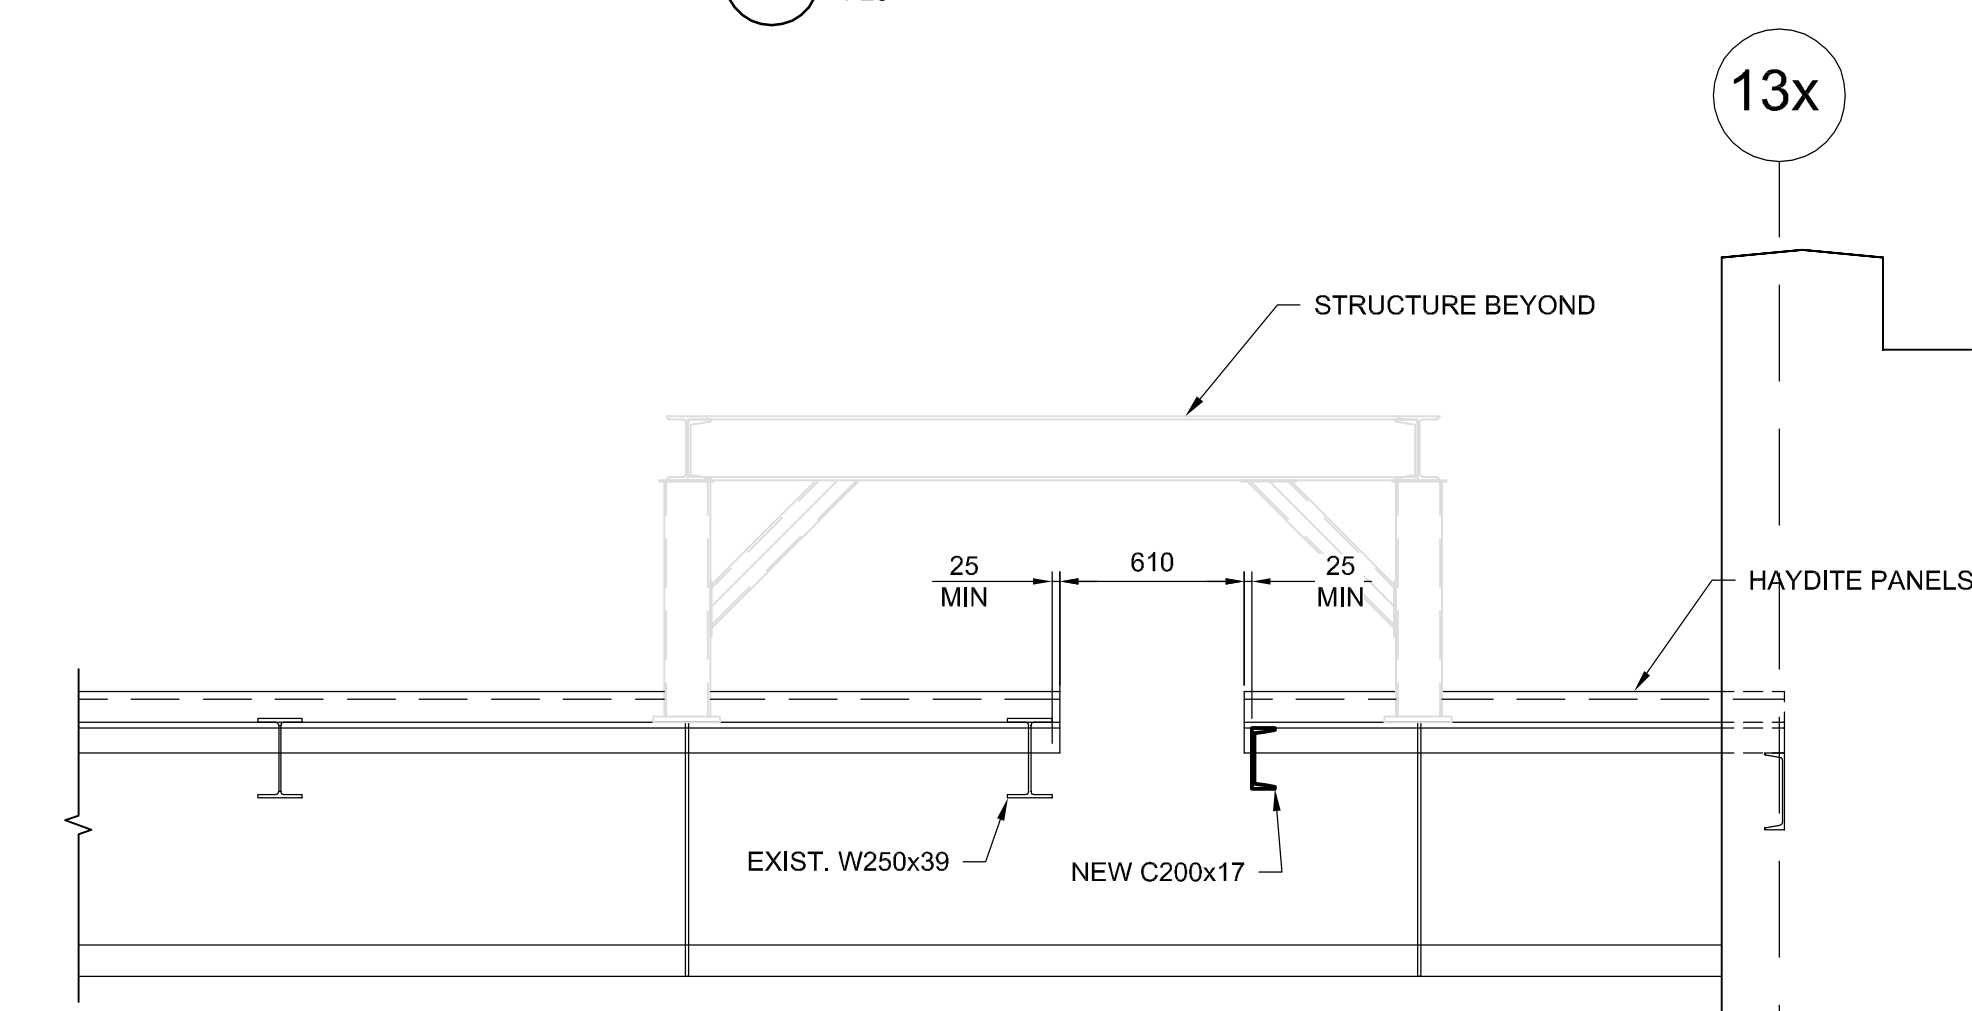

H SECTION
1:25

B.M. ELEV.		DESIGNED BY: NR				NORTH END SEWAGE TREATMENT PLANT NEWPCC MAIN BUILDING - HVAC REPLACEMENT FRAMING DETAILS FOR MECHANICAL MAU M639	CITY DRAWING NUMBER 1-0101M-S0021-001
		DRAWN BY: DJB					SHEET 4 OF 21
		CHECKED BY: -					
		APPROVED BY: -					
		HOR. SCALE	RELEASED FOR CONSTRUCTION	CONSULTANT PROJECT NO. 163526			S-03
0 Issued for Tender		16/10/27	NR	VERTICAL	DATE		
NO.	REVISIONS	DATE	BY	DATE			