




FLOOR PLAN

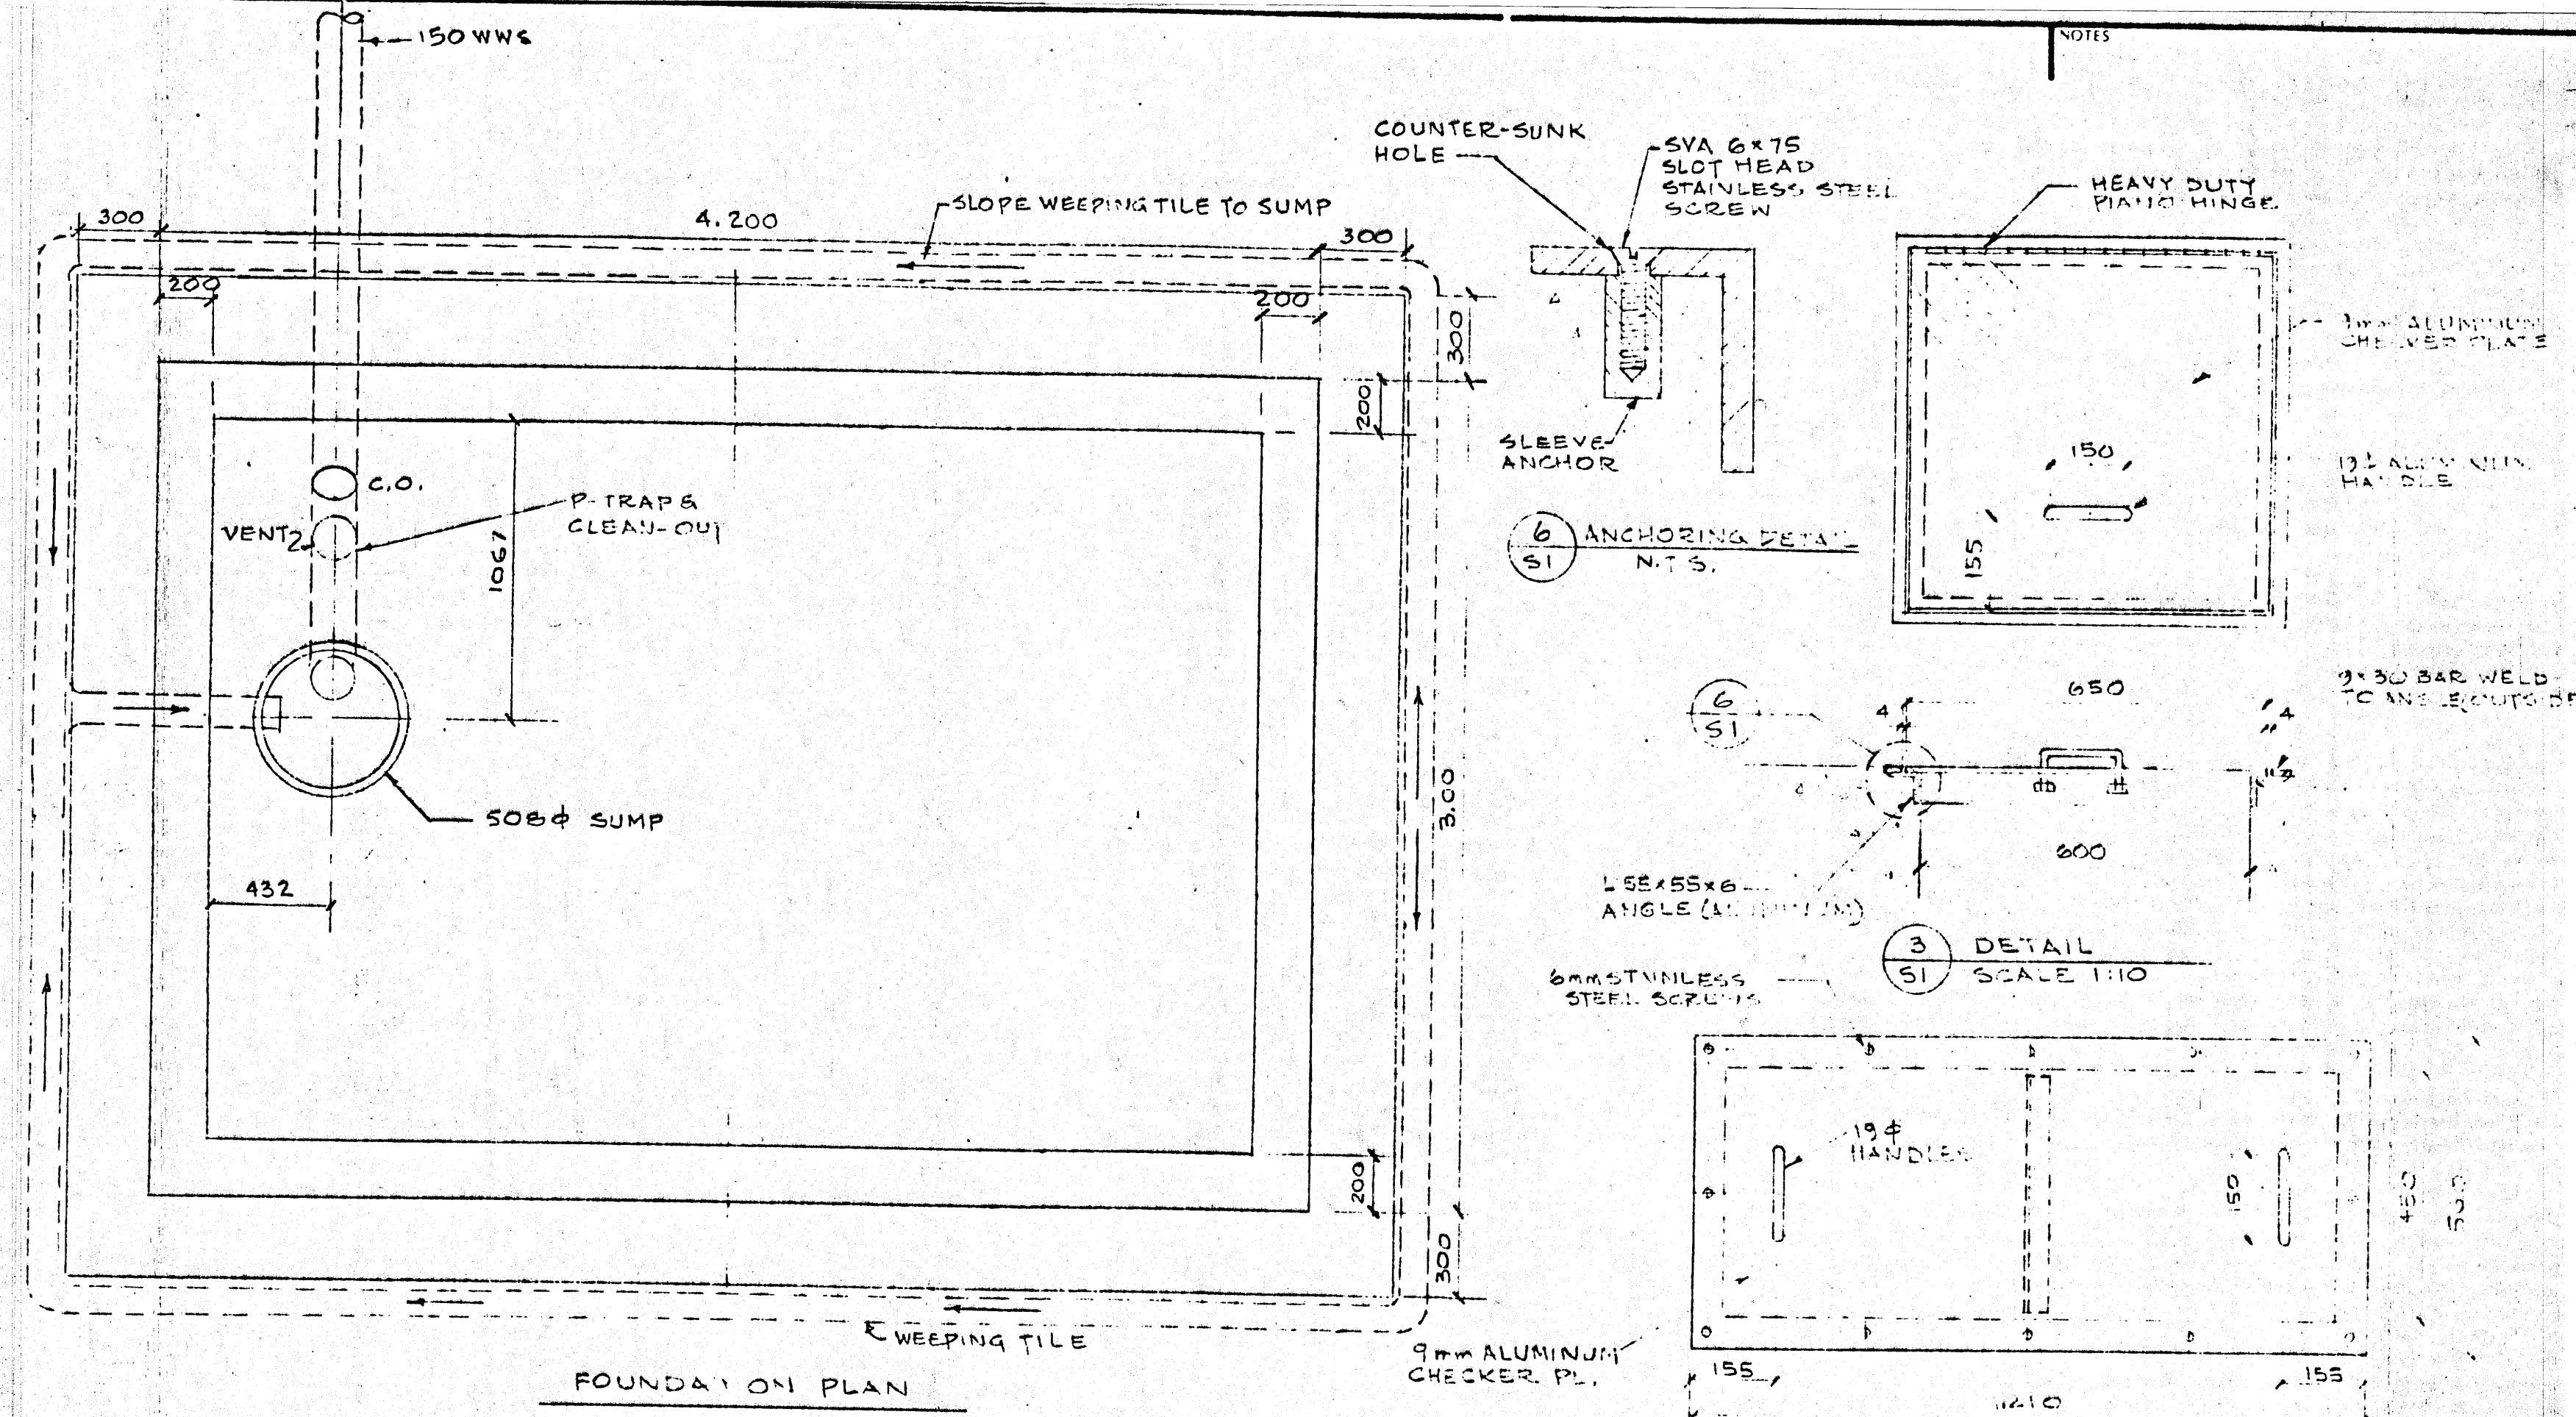


FOUNDATION PLAN

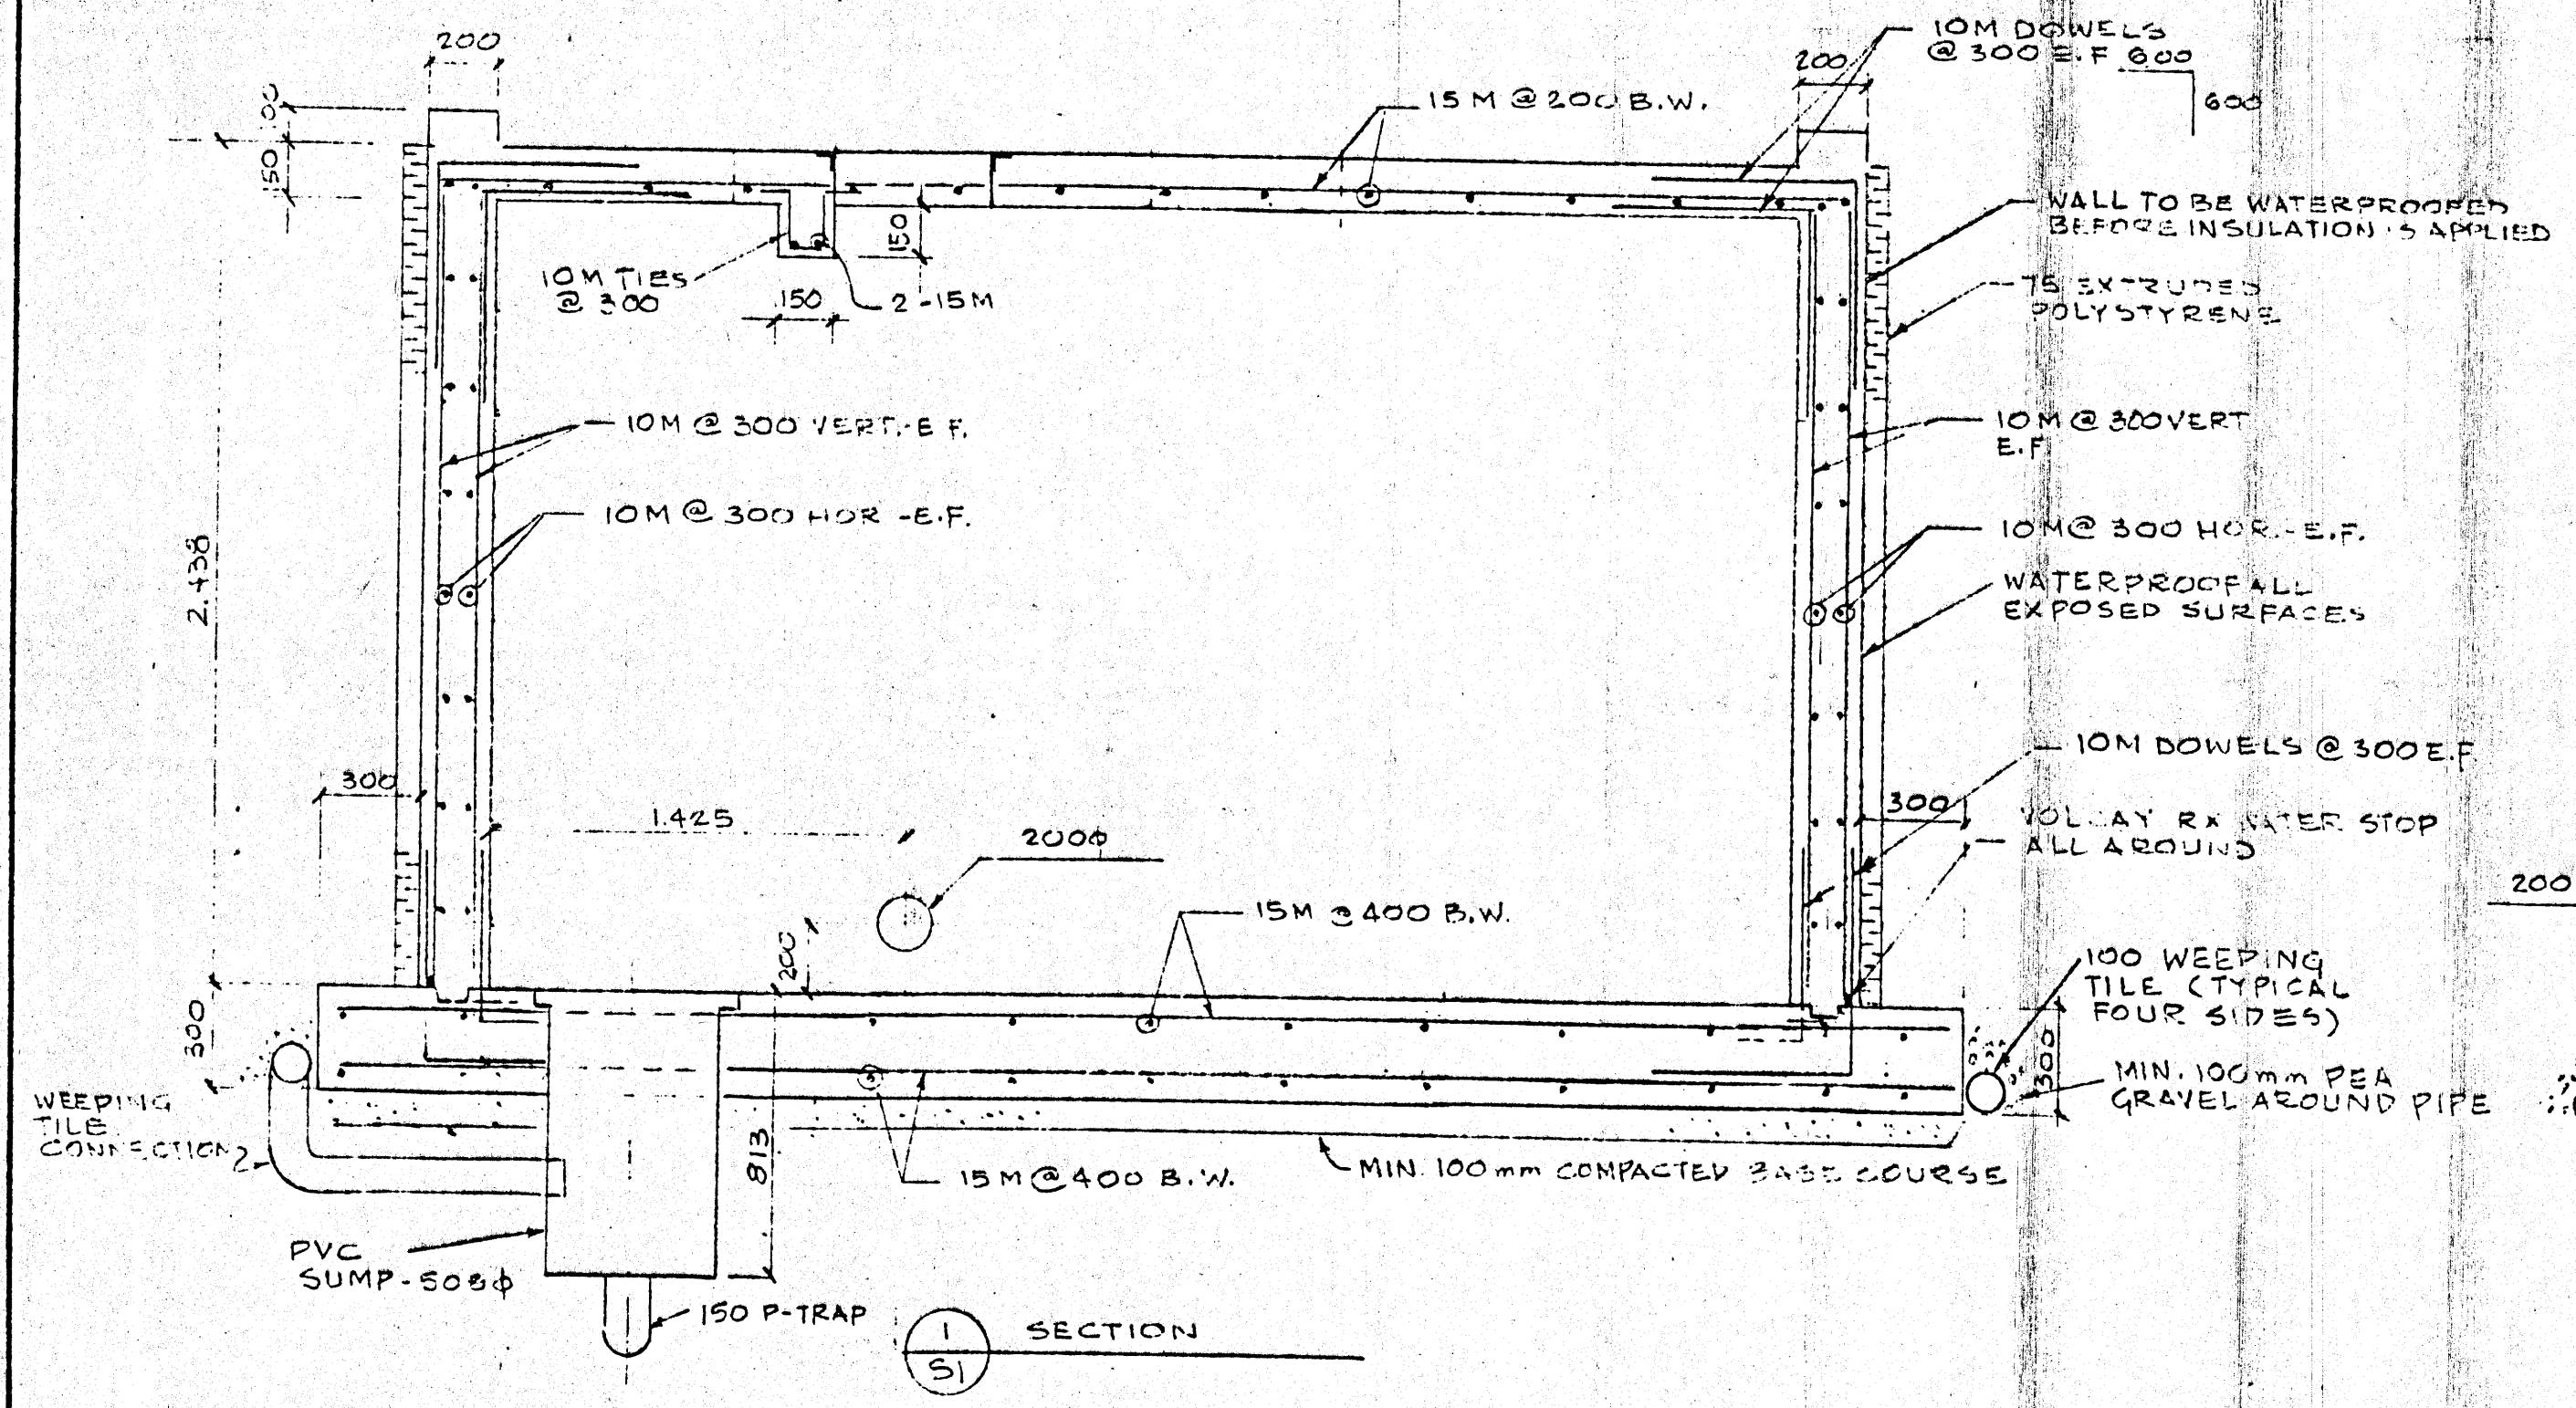

SECTION 1-S1

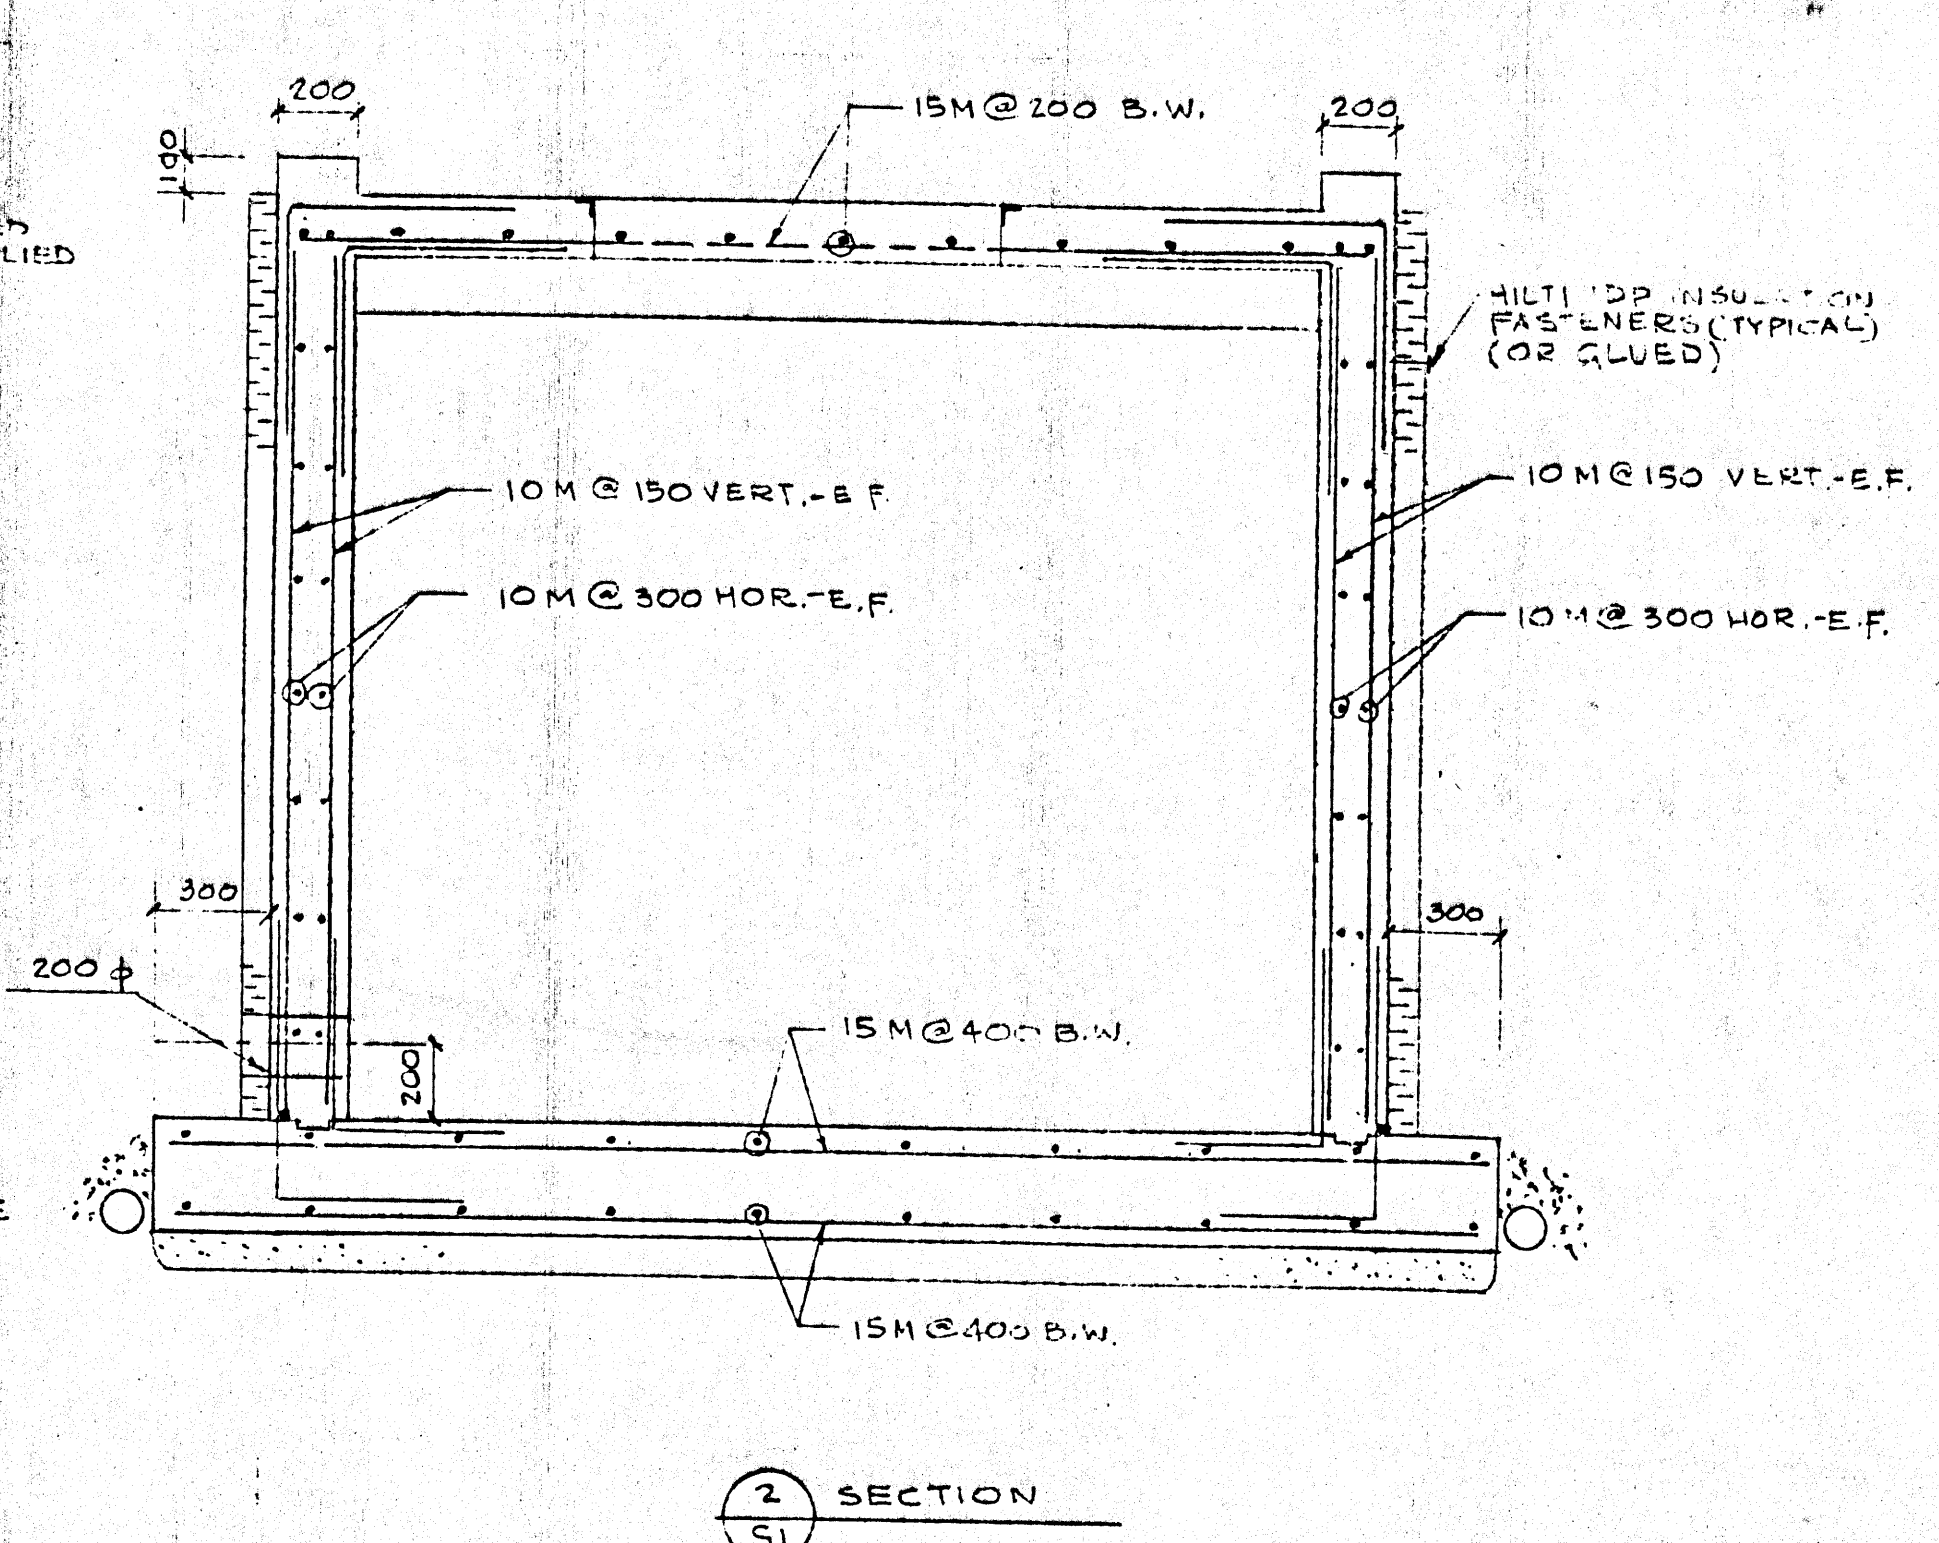

SECTION 2-S1

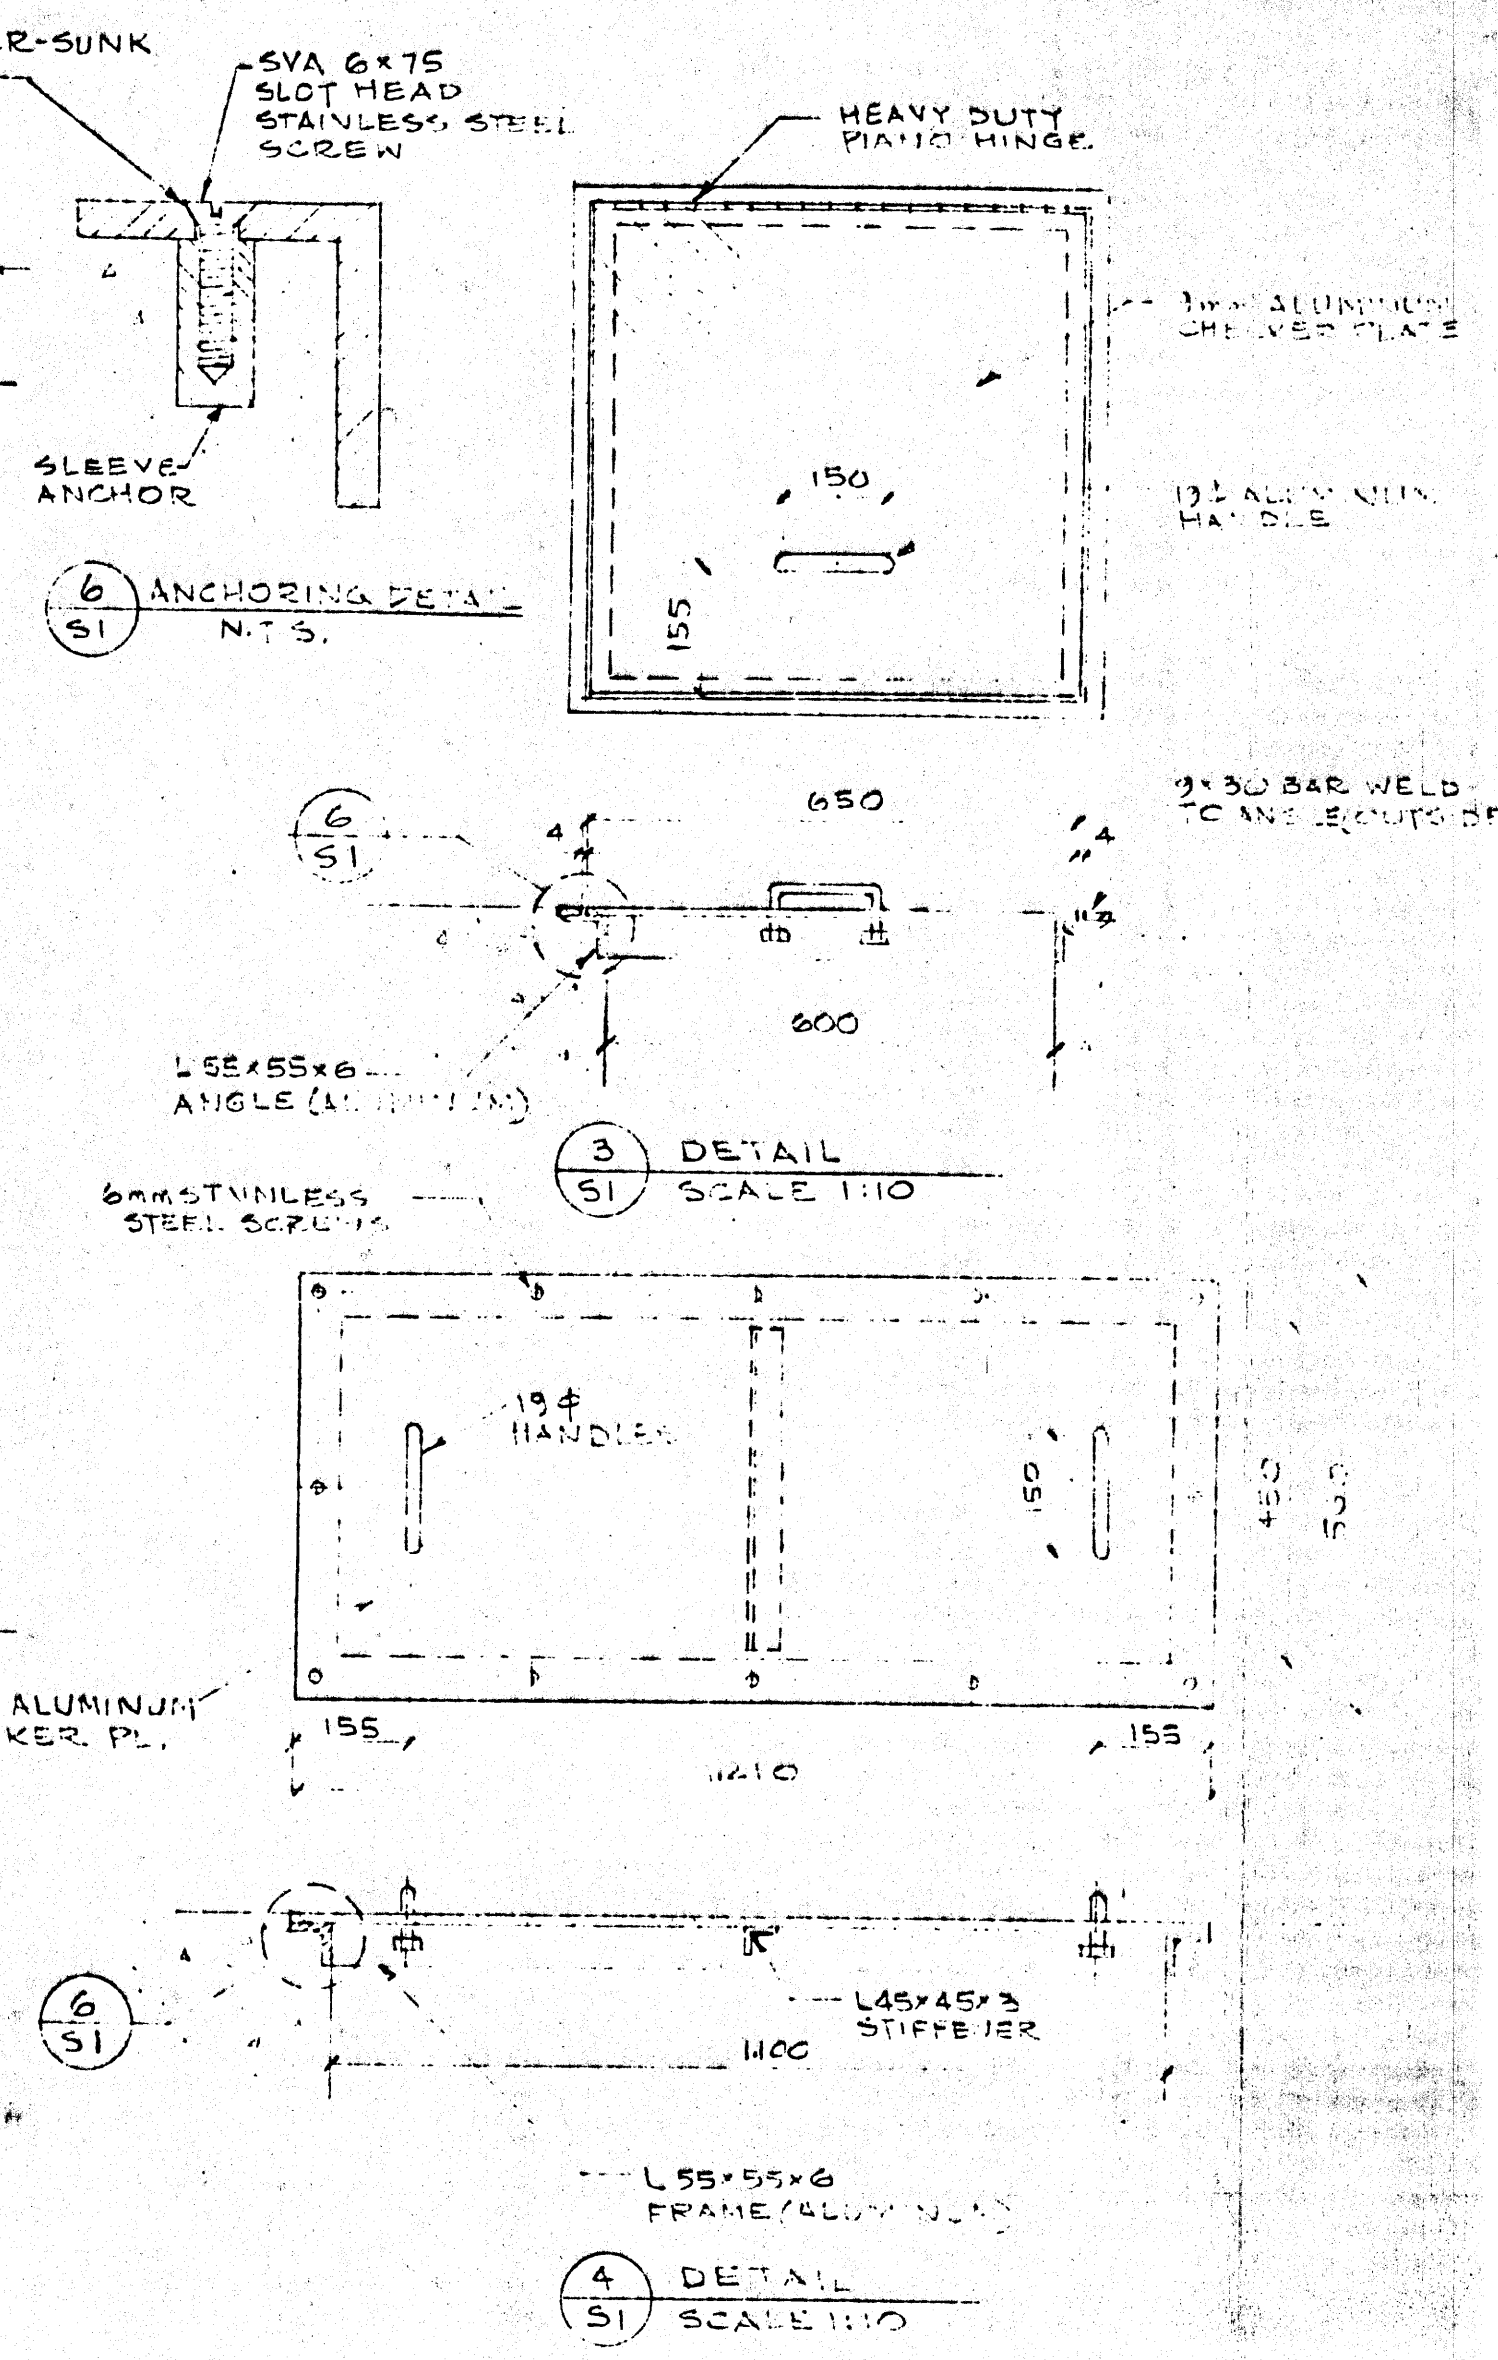

NO	REVISION DESCRIPTION	BY	DATE
2	AS CONSTRUCTED	SS	5/10
1	GENERAL		
NO			

THE CITY OF WINNIPEG
CIVIC PROPERTIES DEPARTMENT
4-180 KING ST. R3B3G8

PUBLIC WATER SERVICE OUTLET
1539 WAVERLEY STREET
(DISTRICT NO.6 YARD)

WATER SALES BUILDING
WET WELL & FOUNDATION

MANENGO ENGINEERING
Telephone 885-7251 Winnipeg, Manitoba

SCALE	PROJECT NO	SHEET NO
1:20		

(87036-S1)

SW-3748

SW-3748