


POWER, DATA & COMMUNICATION DEMOLITION NOTES: "X"

ALSO SEE NOTES & SPECIFICATIONS.
REFER TO APPLICABLE RENOVATION DRAWING FOR RELOCATED COMPONENTS.
ALL ABANDONED WIRING & CABLES TO BE REMOVED FROM PLENUM SPACES AS REQUIRED BY LATEST CANADIAN ELECTRICAL CODE.
PLEASE DO NOT DISTURB OR DISCONNECT ANY WIRING & CABLING IN AREA OF WORK REQUIRED FOR OTHER AREAS.

- 1. RELOCATE DUPLEX RECEPTACLES, SEE RENO DWG.
- 2. RELOCATE SPEAKER, SEE RENO DWG.
- 3. RELOCATE SHAW WI-FI DEMARCATION, SEE RENO DWG.

NOTES:
REFER TO ELECTRICAL SPECIFICATIONS & DRAWING E1.

1	ISSUED FOR ADDENDUM No:1	DTA	2016.12.09
0	ISSUED FOR CONSTRUCTION.	DTA	2016.11.28
No.	REVISION/DESCRIPTION	BY	DATE

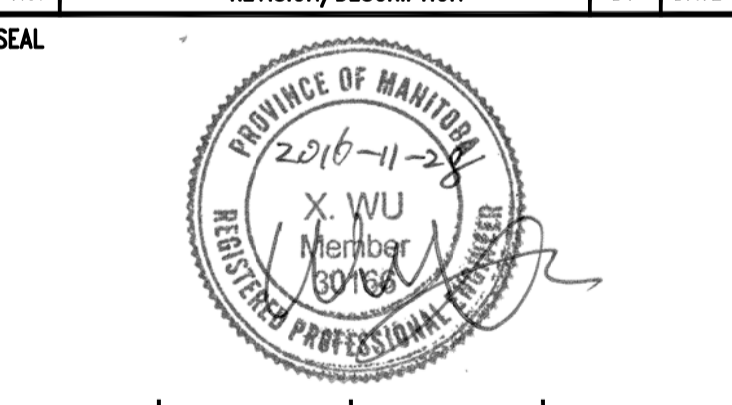

DRAWN	DTA	CHECKED	DESIGNED	DTA	APPROVED
DATE	2016.11.18	USER	APPROVAL		

THE CITY OF WINNIPEG
PLANNING, PROPERTY AND
DEVELOPMENT DEPARTMENT
MUNICIPAL ACCOMMODATIONS DIVISION
3-65 GARRY STREET, R3C 4K4

PROJECT
AQUATIC HALL OF FAME MUSEUM
ROYAL GALLERY SPACE RESTORATION

25 POSEIDON BAY
SHEET TITLE

FLOOR PLAN
ELECTRICAL - DEMOLITION
POWER, DATA, COMMUNICATION

SCALE	PROJECT No:	SHEET No:
AS SHOWN	2014-148	E2R1

FLOOR PLAN - DEMOLITION
SCALE: 1/8"=1'-0"