

KEY PLAN
SCALE: N.T.S.

THESE DRAWINGS SHALL NOT BE SCALED. CONSULT WITH CONTRACT ADMINISTRATOR ON ANY CONCERNS.

SUBMISSION OF SITE MARKUPS, AS-BUILTS, OPERATING & MAINTENANCE MANUALS AND OTHER SUPPORTING DOCUMENTS TO CONTRACT ADMINISTRATOR ARE MANDATORY AT THE COMPLETION OF THIS PROJECT.

THE CONTRACTOR SHALL VISIT THE SITE AND SATISFY ONESELF ALL DIMENSIONS, DATUM, AND DETAILED INFORMATION SHOWN ARE CORRECT.

THE CONTRACTOR IS TO REVIEW AND COORDINATE ALL ARCHITECTURAL, STRUCTURAL, MECHANICAL AND ELECTRICAL DRAWINGS FOR ADDITIONAL OPENINGS THROUGH FLOORS, WALLS, AND CEILINGS FOR DUCTS, PIPES & ELECTRICAL RISERS AND ALL OPENINGS NOT SHOWN ON DRAWINGS.

ALL OPENINGS THROUGH FIRE ASSEMBLIES INCLUDING FLOORS AND CEILINGS ARE TO BE FIRE STOPPED AND SEALED WITH ULC APPROVED FIRE STOPPING TO MAINTAIN THE INTEGRITY OF THE FIRE SEPARATION, AND PROVIDE A SMOKE-TIGHT BARRIER.

ALL PRODUCTS AND MATERIALS TO BE USED AND INSTALLED SHALL CONFORM WITH MANUFACTURER'S SPECIFICATIONS, APPLICABLE CODES AND AUTHORITY HAVING JURISDICTION.

THE CONTRACTOR SHALL BE RESPONSIBLE TO PATCH AND MAKE GOOD ALL EXISTING CONSTRUCTION AFFECTED BY THE REMOVAL OF ALL ITEMS FORMING PART OF THE RENOVATION WORK.

WHERE NEW FLOORING AND BASE IS TO BE INSTALLED IN EXISTING AREAS (REFER TO FLOOR PLAN AND ROOM SCHEDULE) THE EXISTING FLOORING SURFACE AND BASE MUST BE REMOVED, UNLESS OTHERWISE NOTED. ALL FLOOR SURFACES SHALL BE PREPARED IN ACCORDANCE TO MANUFACTURER'S RECOMMENDATIONS FOR INSTALLATION OF NEW FLOOR.

WHERE PAINTING OF EXISTING WALLS IS INDICATED ON THE ROOM SCHEDULE, THESE WALLS MUST BE CLEANED OF ANY EXISTING WALL COVERING, PATCHED & PREPARED TO ACCEPT NEW MATERIAL, UNLESS OTHERWISE NOTED.

ALL NEW LIGHTING FIXTURES & NEW RECEPTACLES TO BE CONNECTED TO APPROPRIATE PANELS.

THERMOSTATS, FIRE ALARM PULL STATIONS & OCCUPANCY LIGHT SWITCHES SHALL BE MOUNTED 47" ABOVE FINISHED FLOOR UNLESS OTHERWISE NOTED.

ALL ABANDONED ELECTRICAL FIXTURES, COMPONENTS, RECEPTACLE & DATA WIRING SHALL BE REMOVED BACK TO SOURCE & TERMINATED AS PER APPLICABLE CODES. IF APPLICABLE, THIS INCLUDES WIRING CONTAINED IN HEADER DUCTS IN-FLOOR.

REFER TO CITY OF WINNIPEG, MATERIALS MANAGEMENT GENERAL TERMS & CONDITIONS FOR PROJECT: [HTTP://WINNIPEG.CA/WATMGTGEN_COND.STM](http://WINNIPEG.CA/WATMGTGEN_COND.STM)

1	ISSUED FOR CLIENT SIGN OFF	NOV.18/16
No.	REVISION/DESCRIPTION	BY DATE

SEAL

DRAWN	K/JN	CHECKED	DESIGNED	K/JN	APPROVED
DATE	2016.08.24	USER	APPROVAL		

**THE CITY OF WINNIPEG
PLANNING, PROPERTY AND
DEVELOPMENT DEPARTMENT
MUNICIPAL ACCOMMODATIONS DIVISION**
 3-65 GARRY STREET, R3C 4K4

PROJECT
 AQUATIC HALL OF FAME MUSEUM
 ROYAL GALLERY SPACE RESTORATION

25 POSEIDON BAY
 SHEET TITLE


REFLECTED CEILING PLAN

SCALE	PROJECT No:	SHEET No:
AS SHOWN	2014-148	A1.3

CEILING LEGEND	
	CEILING HEIGHTS, FINISHES & TYPES (VARIES)
	NEW RECESSED 2" DIA. POT LIGHTS
	NEW RECESSED LED 6" DIA. POT LIGHTS
	NEW 24" x 24" RECESSED LED LUMINAIRE
	NEW LED BLACK TRACK LIGHTS AND HEADS MOUNTED AT APPROX. 12'-0" AFF.
	NEW 4 FT LED WHITE SPOT LIGHT FIXTURE.
	4" x 96" LED STRIP LIGHT FIXTURE SURFACE MOUNTED TO DRYWALL CEILING.
	4" x 96" LED STRIP LIGHT FIXTURE CHAIN MOUNTED TO UIS OF STRUCTURE. HEIGHT TO BE DETERMINED.
	EXISTING PENDANT SPRINKLER HEAD. LOCATED AT 12" OFF CEILING DECK.
	CONCEALED SPRINKLER HEAD
	CGC TRANSLUCENT CANOPIES. "WAVE" 2 PANEL KIT. 2x6" NOMINAL SIZE. PANEL COLOR: SANTORINI COMPLETE WITH ALL MOUNTING HARDWARE NECESSARY FOR MOUNTING AT STRUCTURE; PANEL JOINERS AND CABLE PANEL ATTACHMENTS REQ'D. TO BE MOUNTED AT APPROX 12'-6" AFF. SITE CONFIRM WITH CONTRACT ADMINISTRATOR.
	EXISTING CEILING FAN TO REMAIN.
	NEW AIR RETURN
	CEILING NOTE SYMBOL

CEILING NOTES

- 1 ALL EXISTING CEILING TRUSSES, HVAC DUCTWORK AND VENTS, AND PIPES TO BE PAINTED BLACK; PT-2.
- 2 CEILING DECK TO BE PAINTED BLACK- PT-2, EXCEPT FOR RAISED LOBBY CEILING DECK.
- 3 ALL NEW SUSPENDED TRACK FIXTURES TO BE BLACK IN FINISH . REFER TO ELECTRICAL DRAWINGS.
- 4 EXISTING BULKHEAD POT LIGHTS TO BE REPLACED WITH LED POTLIGHTS. REFER TO ELECTRICAL DRAWINGS FOR SPECIFICATIONS.
- 5 EXISTING BULKHEAD COLOR TO BE PAINTED PT-7. PATCH AND REPAIR ANY CRACKS IN DRYWALL.
- 6 EXISTING LOBBY HIGH CEILING METAL DECK PORTION TO REMAIN EXISTING .
- 7 REFLECTED CEILING PLAN FOR FINISHES AND CEILING HEIGHTS ONLY. CONTRACTOR TO REFER TO MECHANICAL AND ELECTRICAL DRAWINGS FOR EXACT FIXTURE LAYOUTS AND SPECIFICATIONS.
- 8 ELECTRICAL AND MECHANICAL DRAWINGS TO SUPERCEDE REFLECTED CEILING PLAN FIXTURE LOCATIONS.
- 9 LED DIRECTIONAL LIGHT FIXTURES TO BE LOCATED IN DISPLAY CABINETS. REFER TO MILLWORK AND ELECTRICAL DRAWINGS. POWER PROVIDED BY ELECTRICAL SUBCONTRACTOR.

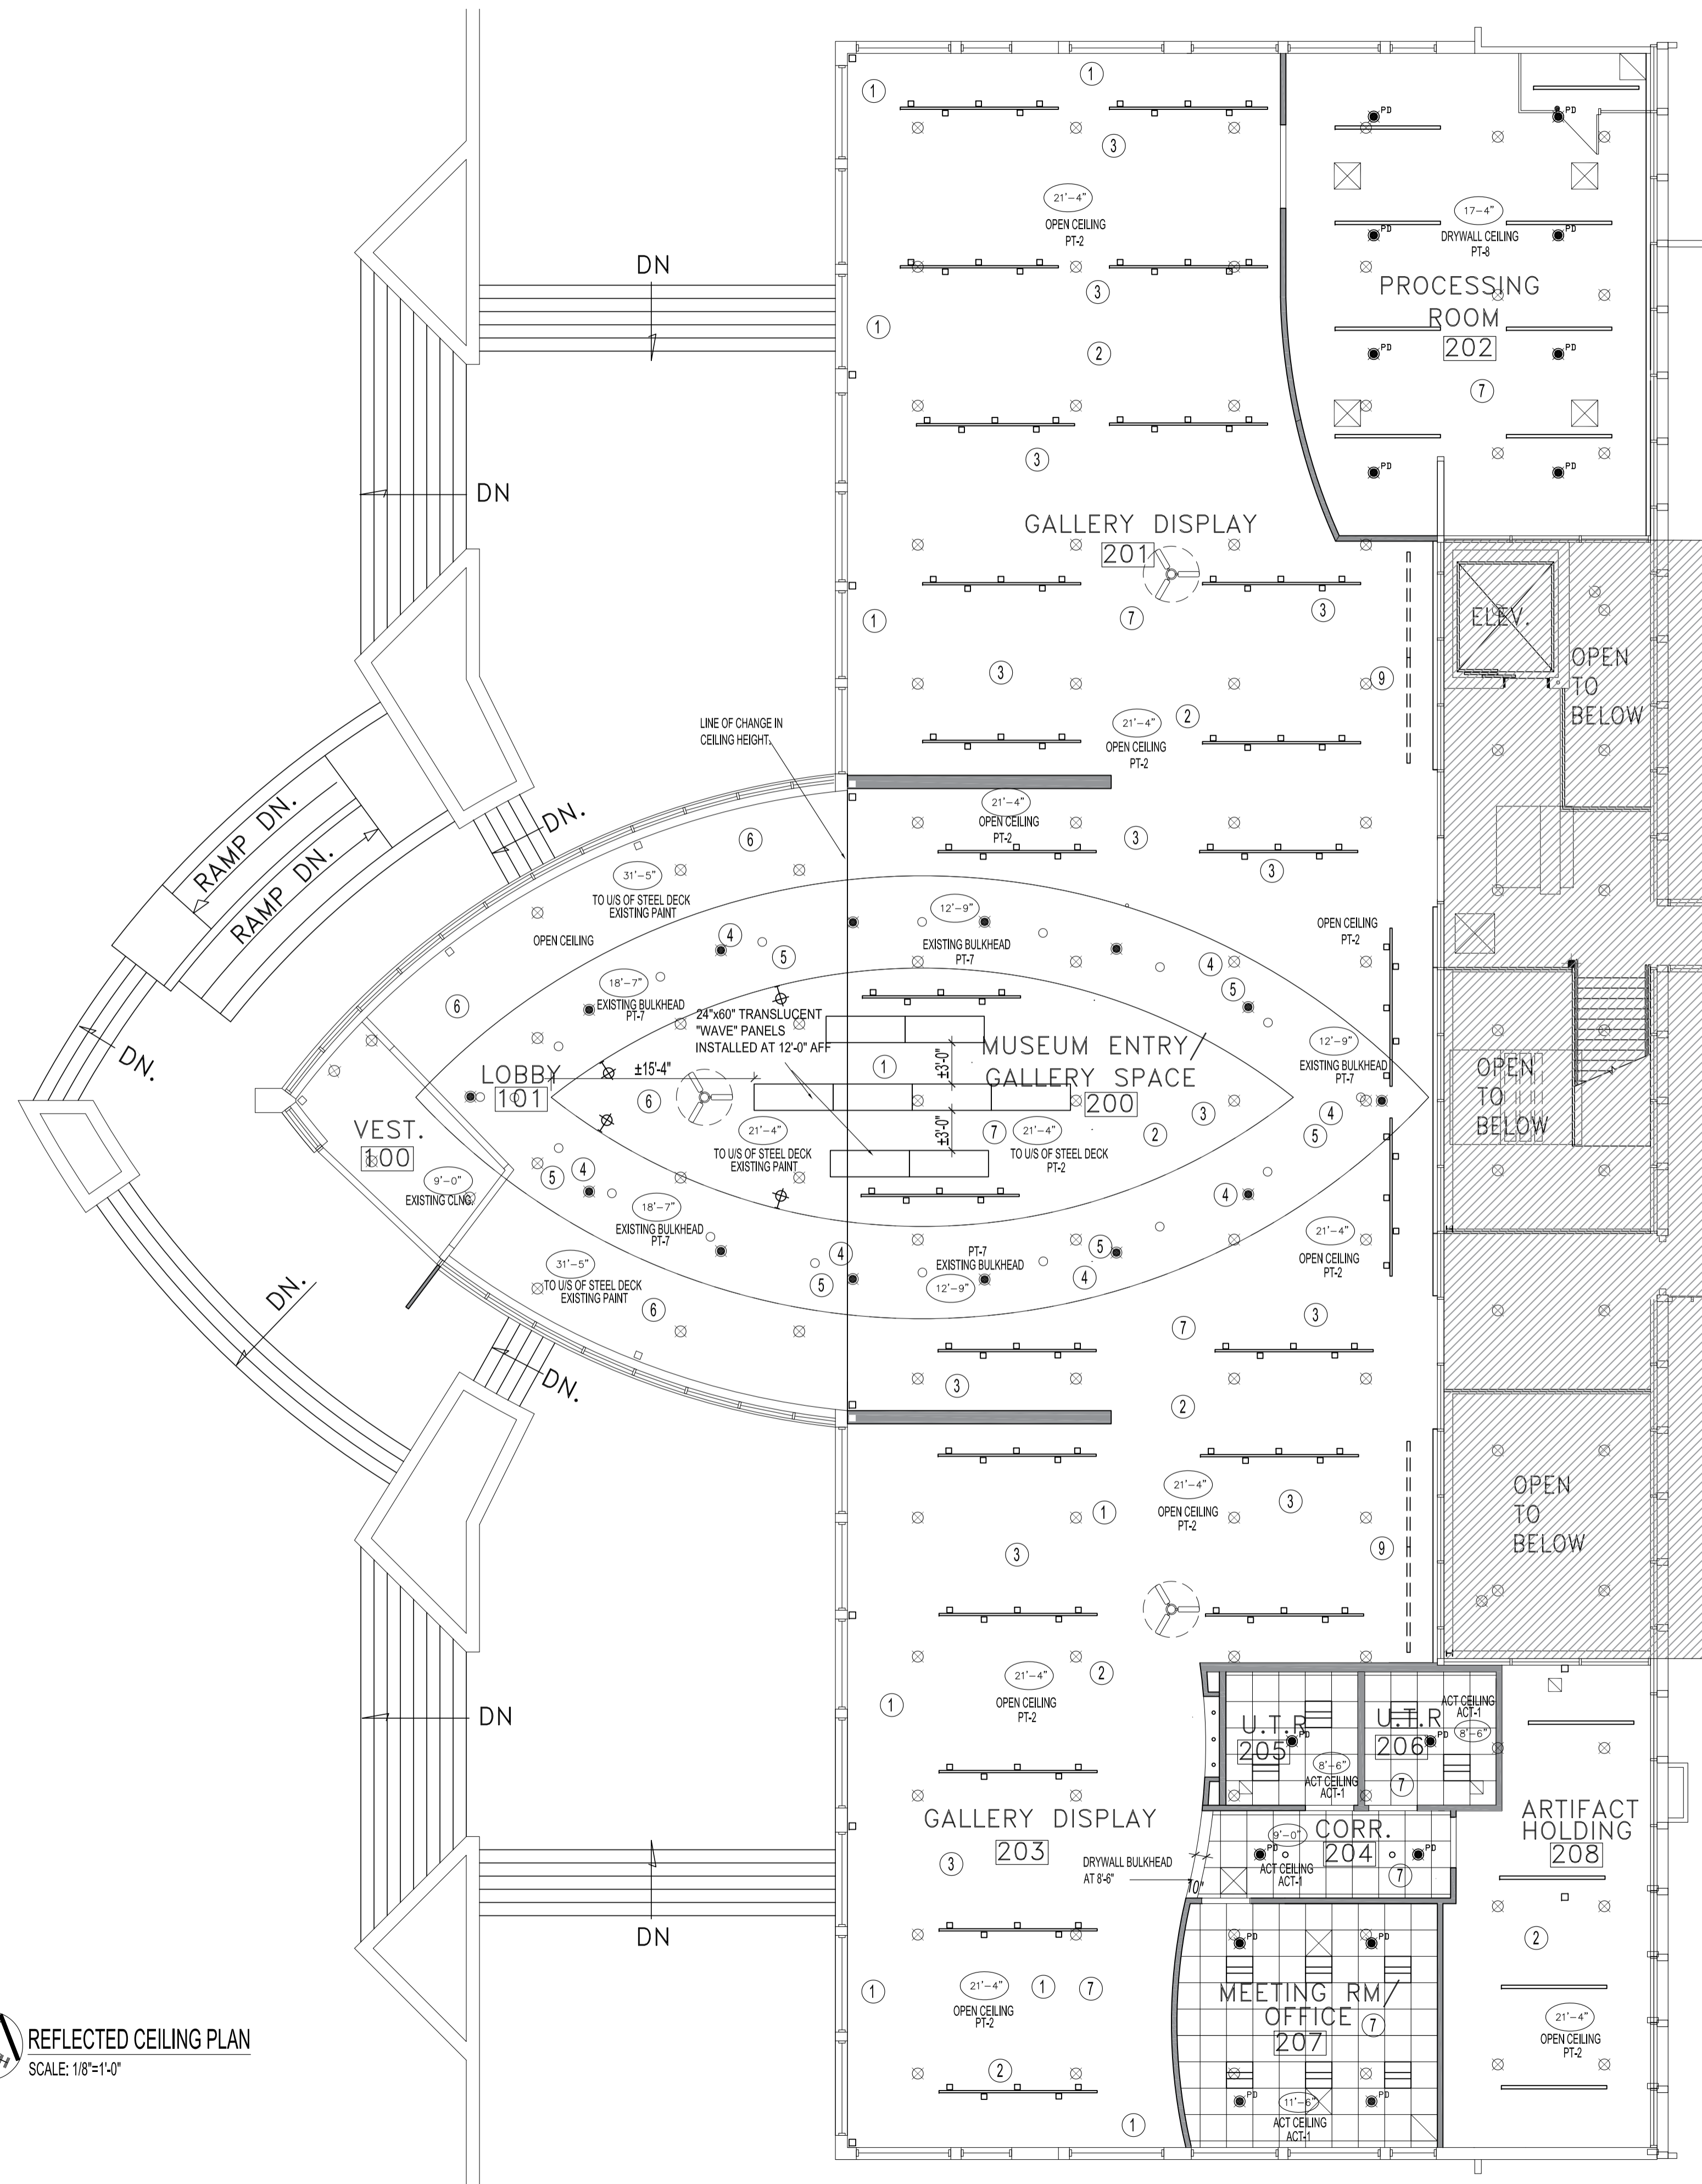

REFLECTED CEILING PLAN
SCALE: 1/8"=1'-0"