
 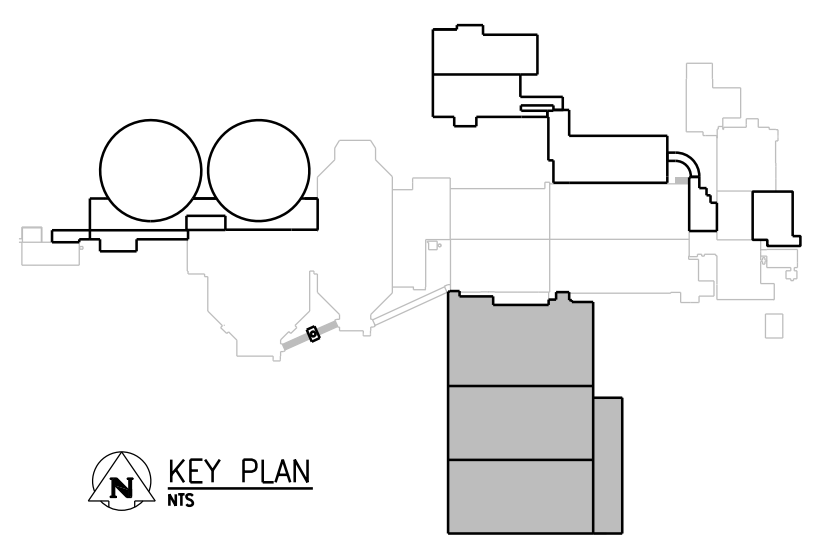


OVERALL GROUND FLOOR PLAN

1:200



APEGM
Certificate of Authorization
CH2M HILL Canada Ltd.
No. 1441

NO.	REVISIONS	DATE	DESIGN	CHECK
03	ISSUED FOR ADDENDUM 1 - 976-2016	2017/05/26	A.B.	J.C.
02	ISSUED FOR CONSTRUCTION - 976-2016	2017/04/05	A.B.	J.C.
01	ISSUED FOR CONSTR - B.O. 899-2015	04/2016	A.B.	J.C.
00	ISSUED FOR TENDER - B.O. 899-2015	01/2016	A.B.	J.C.

CH2MHILL
SNC-LAVALIN

DESIGNED BY: S. BEGG
DRAWN BY: A. BERSHTEIN
SCALE: 1:200
DATE: 2017/04/05
CONSULTANT NO.: 474248

CHECKED BY: T. TRAN
APPROVED BY: H.T. FREIHAMMER
ISSUED FOR CONSTRUCTION BY: J. SHUMKA
DATE: 2017/04/05

ENGINEER'S SEAL

May 26, 2017

THE CITY OF WINNIPEG
Winnipeg WATER AND WASTE DEPARTMENT

SOUTH END WATER POLLUTION CONTROL CENTRE
SEWPCC UPGRADING/EXPANSION PROJECT
MECHANICAL
BIOREACTOR/BLOWER BUILDING
HVAC - OVERALL GROUND FLOOR PLAN

CITY DRAWING NUMBER: 1-0102-MGAD-R607
SHEET: 001
REV.: 03
SIZE: A1