
 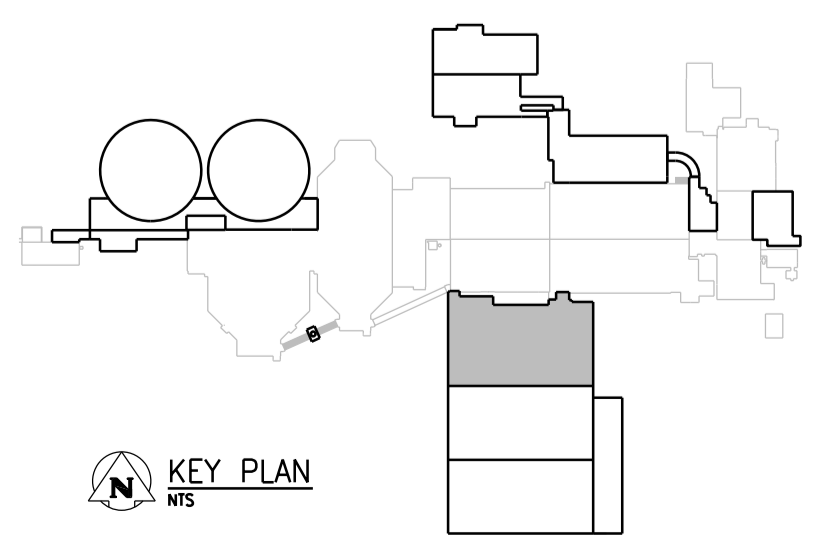


- NOTES:
- REFER TO ARCHITECTURAL DETAILS FOR GAS PIPE SUPPORT OF THE WALL

GROUND FLOOR PLAN - PART A
1:50



APEGM
Certificate of Authorization
CH2M HILL Canada Ltd.
No. 1441


NO.	REVISIONS	DATE	DESIGN	CHECK
03	ISSUED FOR ADDENDUM 1 - 976-2016	2017/05/26	A.B.	J.C.
02	ISSUED FOR CONSTRUCTION - 976-2016	2017/04/05	A.B.	J.C.
01	ISSUED FOR CONSTR - B.O. 899-2015	04/2016	A.B.	J.C.
00	ISSUED FOR TENDER - B.O. 899-2015	01/2016	A.B.	J.C.

CH2MHILL
SNC-LAVALIN

DESIGNED BY: S. BEGG
DRAWN BY: A. BERSHTEIN

CHECKED BY: T. TRAN
APPROVED BY: H.T. FREIHAMMER

SCALE: 1:50
DATE: 2017/04/05
CONSULTANT NO.: 474248

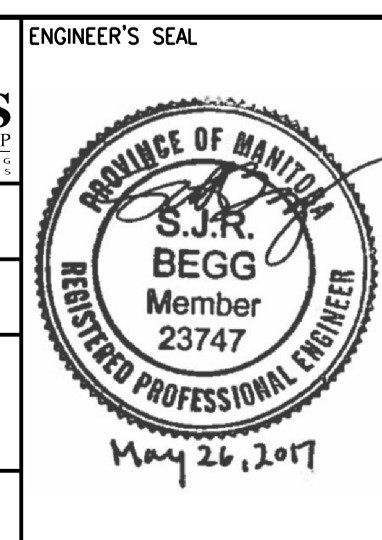

THE CITY OF WINNIPEG
Winnipeg WATER AND WASTE DEPARTMENT

SOUTH END WATER POLLUTION CONTROL CENTRE
SEWPC UPGRADING/EXPANSION PROJECT
MECHANICAL
BIOREACTOR/BLOWER BUILDING
HVAC - GROUND FLOOR PLAN - PART A

CITY DRAWING NUMBER: 1-0102-MGAD-R608
SHEET: 001
REV.: 03
SIZE: A1