


ROOF PLAN

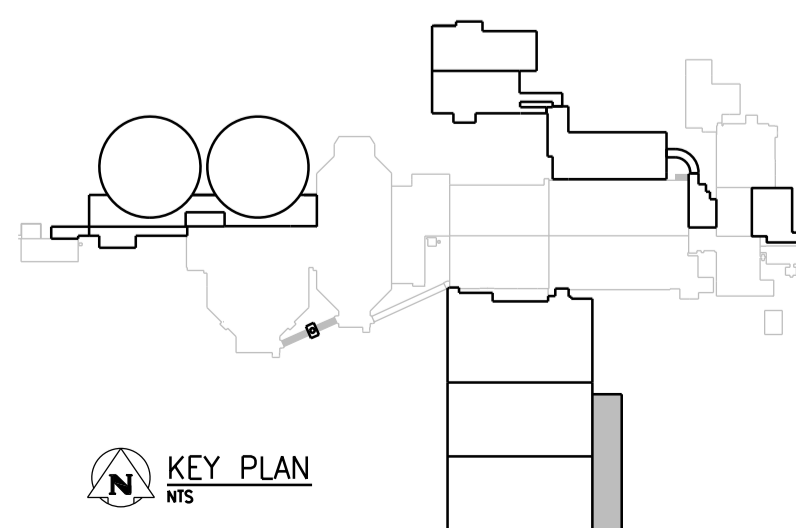


KEY PLAN
NTS

APEGM
Certificate of Authorization
CH2M HILL Canada Ltd.
No. 1441

NO.	REVISIONS	DATE	DESIGN	CHECK
03	ISSUED FOR ADDENDUM 3 - 976-2016	2017/06/21	K.F.	J.C.
02	ISSUED FOR CONSTRUCTION - 976-2016	2017/04/05	K.F.	J.C.
01	ISSUED FOR CONSTR - B.O. 899-2015	04/2016	P.K.	J.C.
00	ISSUED FOR TENDER - B.O. 899-2015	01/2016	P.K.	J.C.

CH2MHILL		KGS GROUP	
SNC-LAVALIN		ENGINEERING CONSULTANTS	
DESIGNED BY: T. TRAN	CHECKED BY: D. CUDDINGTON	SCALE: 1:100	
DRAWN BY: P. KWONG	APPROVED BY: H.T. FREIHAMMER	ISSUED FOR CONSTRUCTION	
DATE: 2017/04/05		BY: J. SHUMKA	
DATE: 2017/04/05		DATE: 2017/04/05	
CONSULTANT NO.: 474248			

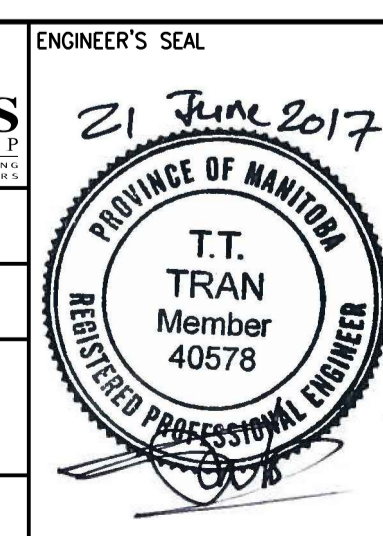

THE CITY OF WINNIPEG
Winnipeg WATER AND WASTE DEPARTMENT

SOUTH END WATER POLLUTION CONTROL CENTRE
SEWPCC UPGRADING/EXPANSION PROJECT
MECHANICAL
BIOREACTOR/BLOWER BUILDING
PLUMBING - ROOF PLAN

CITY DRAWING NUMBER: 1-0102-MGAD-R509
SHEET: 001
REV.: 03
SIZE: A1