



1 WALL SECTION
1:10
BGAD-S015

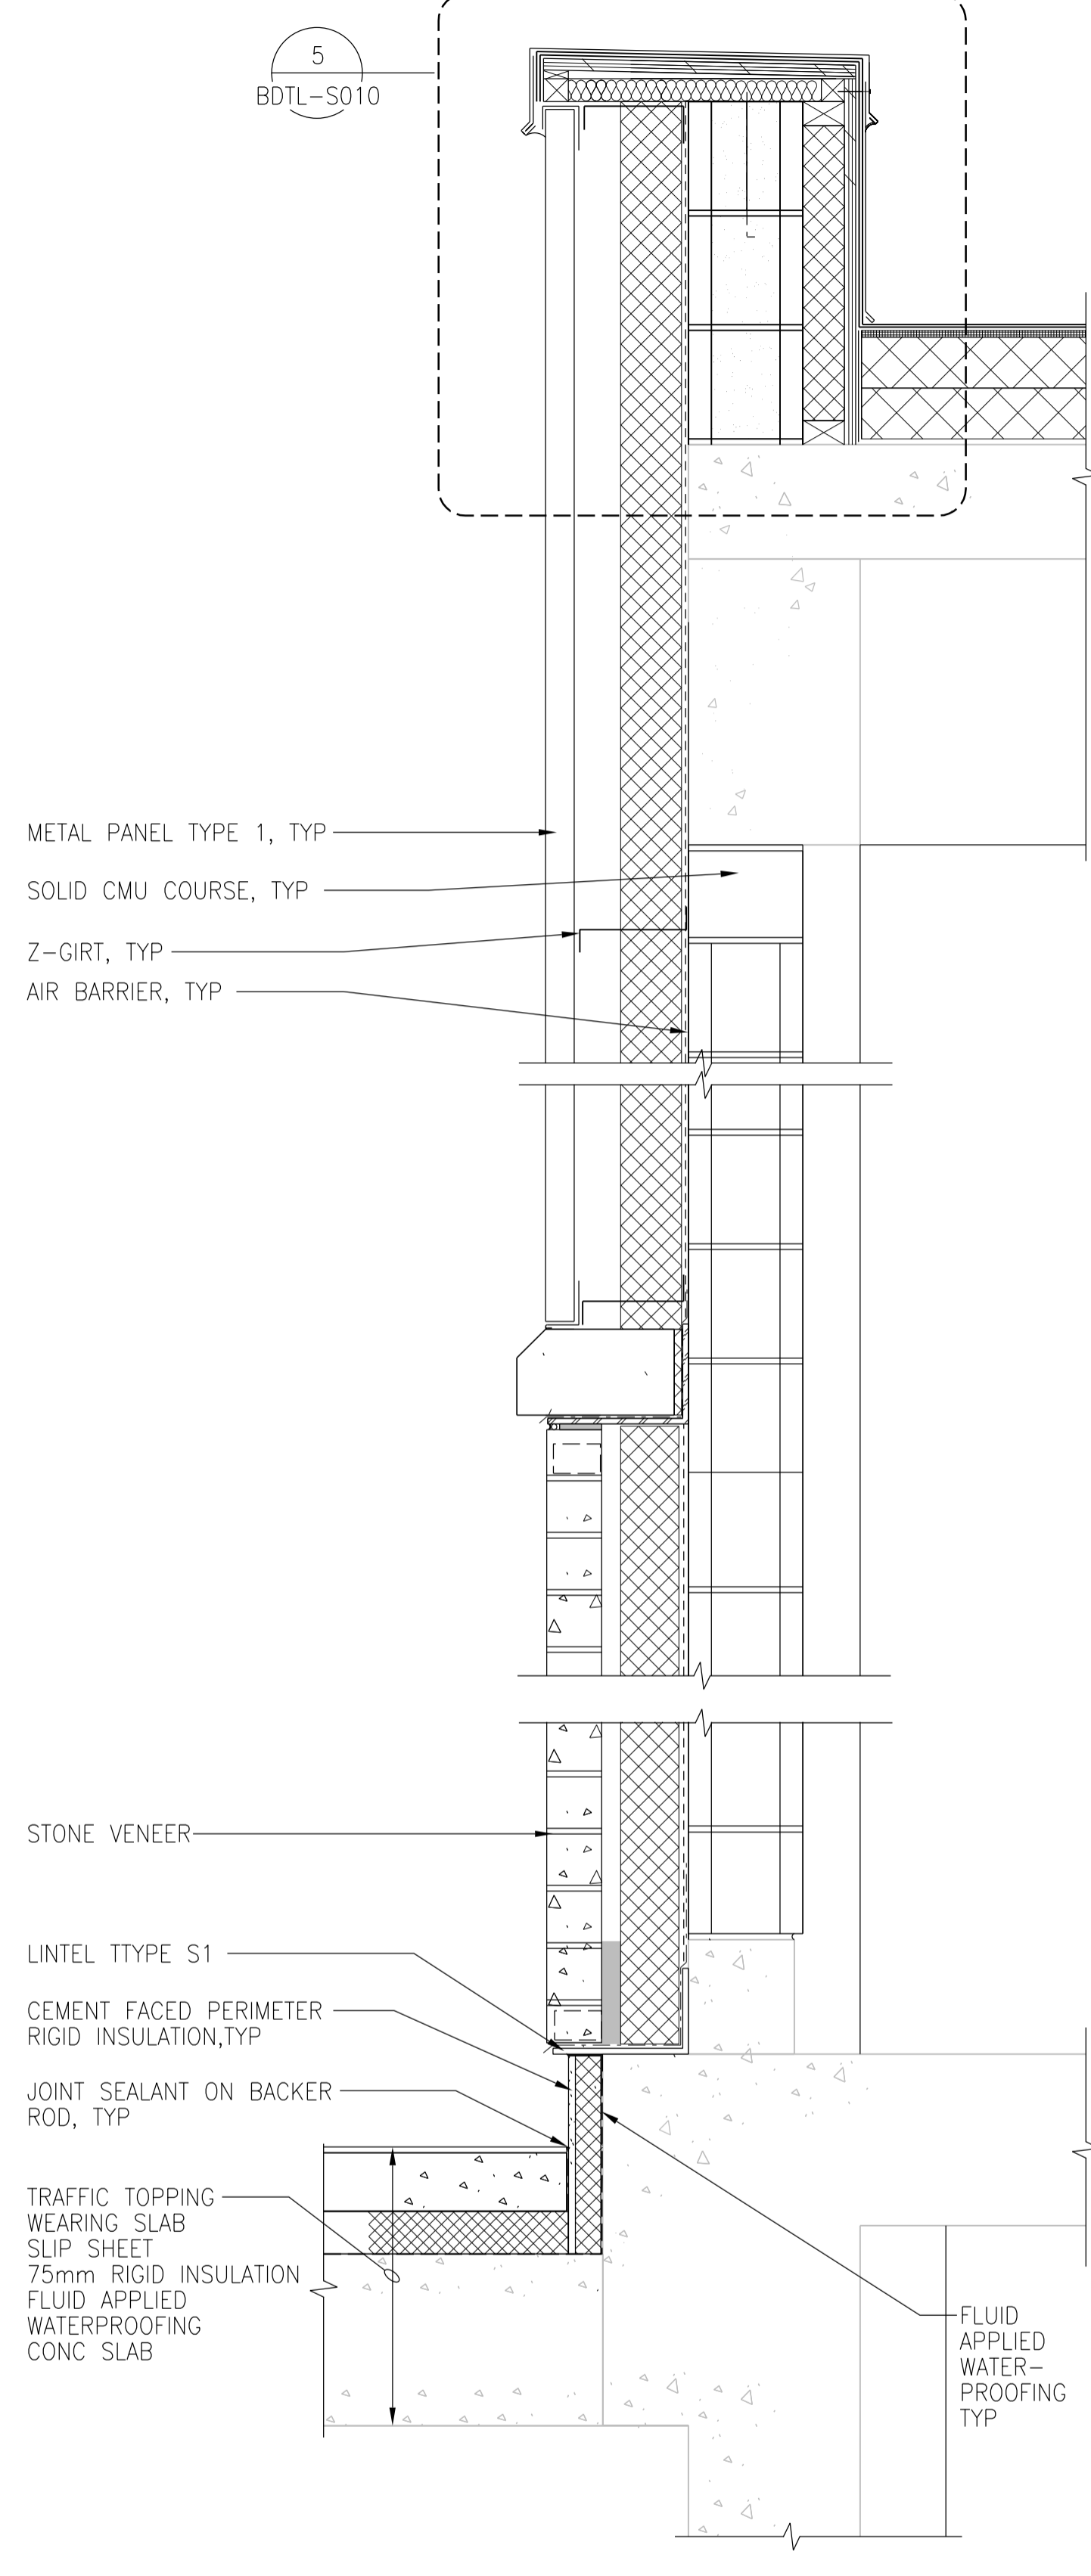

2 WALL SECTION
1:10
BGAD-S015

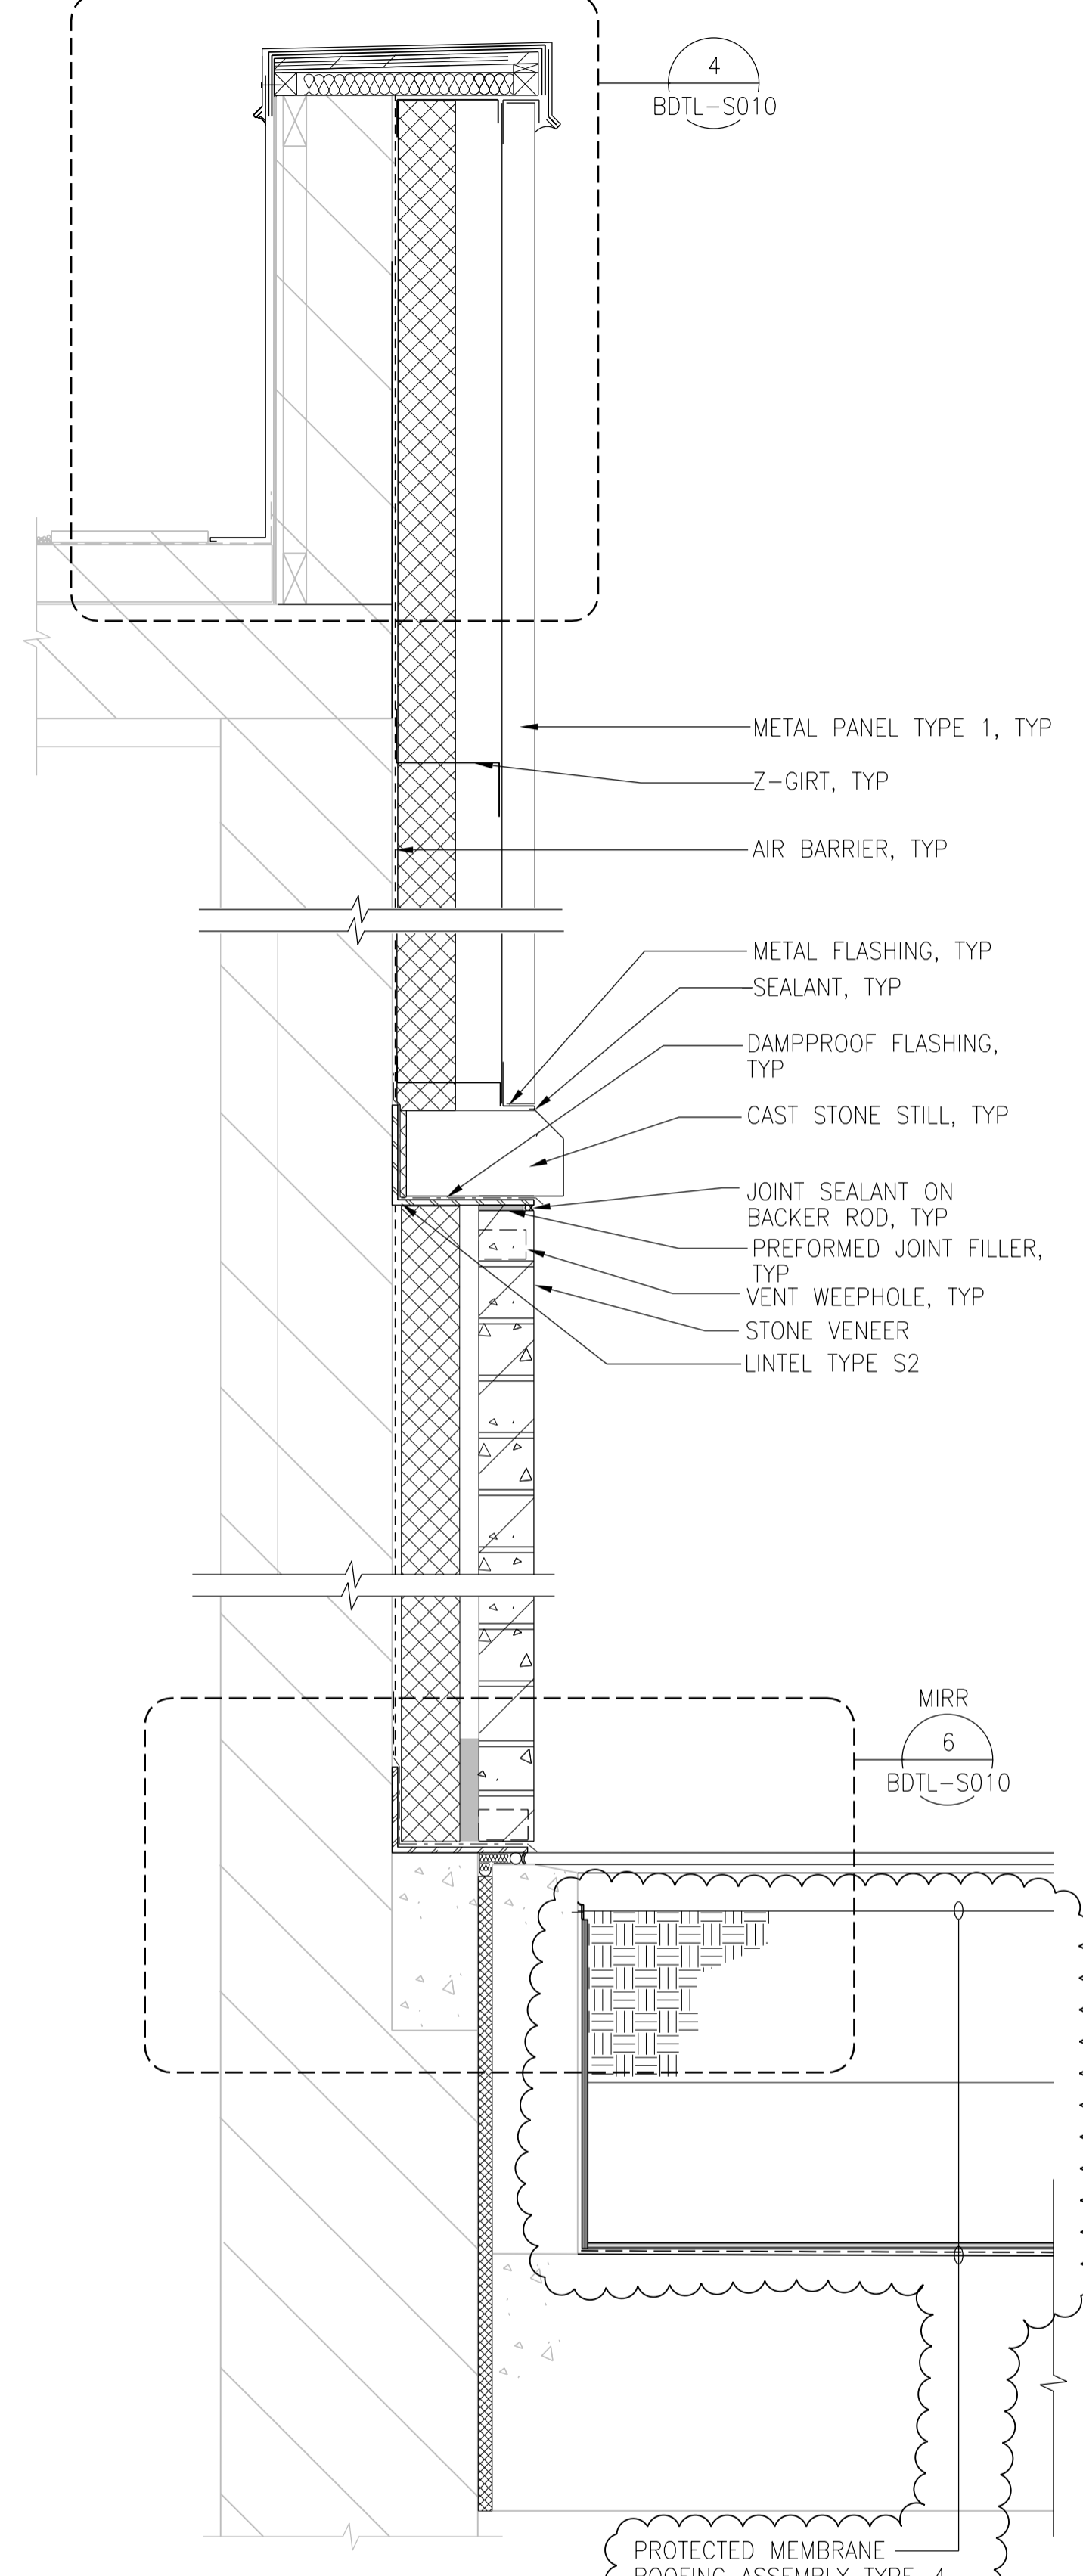


3 WALL SECTION
1:10
BGAD-S011

PROTECTED MEMBRANE ROOFING ASSEMBLY TYPE-4 (SEE ROOF PLAN FOR LISTING OF ASSEMBLIES)



| NO. | REVISIONS | DATE | DESIGN | CHECK |
|-----|------------------------------------|------------|--------|-------|
| 01 | ISSUED FOR ADDENDUM 5 - 976-2016 | 2017/07/14 | R.B. | J.C. |
| 00 | ISSUED FOR CONSTRUCTION - 976-2016 | 2017/04/05 | N.B. | J.C. |

| | | | |
|---------------------------------|--|-----------------|--|
| CH2MHILL CANADA Architects Inc. | | ENGINEER'S SEAL | |
| DESIGNED BY: R. ZAKKO | CHECKED BY: B. KOLIS-HUPA | | |
| DRAWN BY: N. BOYCHUK | APPROVED BY: H.T. FREIHAMMER | | |
| SCALE: AS SHOWN | ISSUED FOR CONSTRUCTION BY: J. SHUMKA | | |
| DATE: 2017/04/05 | DATE: 2017/04/05 | | |
| CONSULTANT NO.: 474248 | | | |

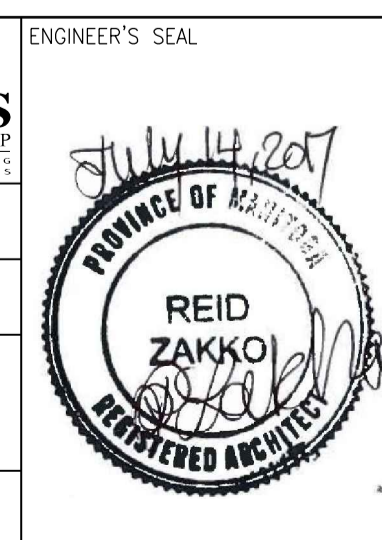

THE CITY OF WINNIPEG
WATER AND WASTE DEPARTMENT

SOUTH END WATER POLLUTION CONTROL CENTRE
SEWPC UPGRADING/EXPANSION PROJECT
BUILDING
SECONDARY CLARIFIERS 4 AND 5
WALL SECTIONS - PART 5

CITY DRAWING NUMBER: 1-0102-BDTL-S007 | SHEET: 001 | REV: 01 | SIZE: A1