


1 DETAILED PLAN
1:50
BCAD-R004


NOTES:
 1 HR - DENOTES 1 HOUR FIRE RATED SEPARATION
 - DENOTES EXTENTS OF FIRE WALLS - - - - - 1HR
 - PATTERN/HATCHING OF WATER/LIQUID IS FOR CLARIFICATION PURPOSES ONLY TO INDICATE AND DIFFERENTIATE WATER/LIQUID CONTAINING STRUCTURES FROM REMAINDER OF BUILDING AREAS. IT DOES NOT REPRESENT ACTUAL LEVEL, VOLUME OR EXTENT OF WATER/LIQUID IN THESE AREAS. REFER TO PROCESS MECHANICAL FOR SUCH REQUIREMENTS.

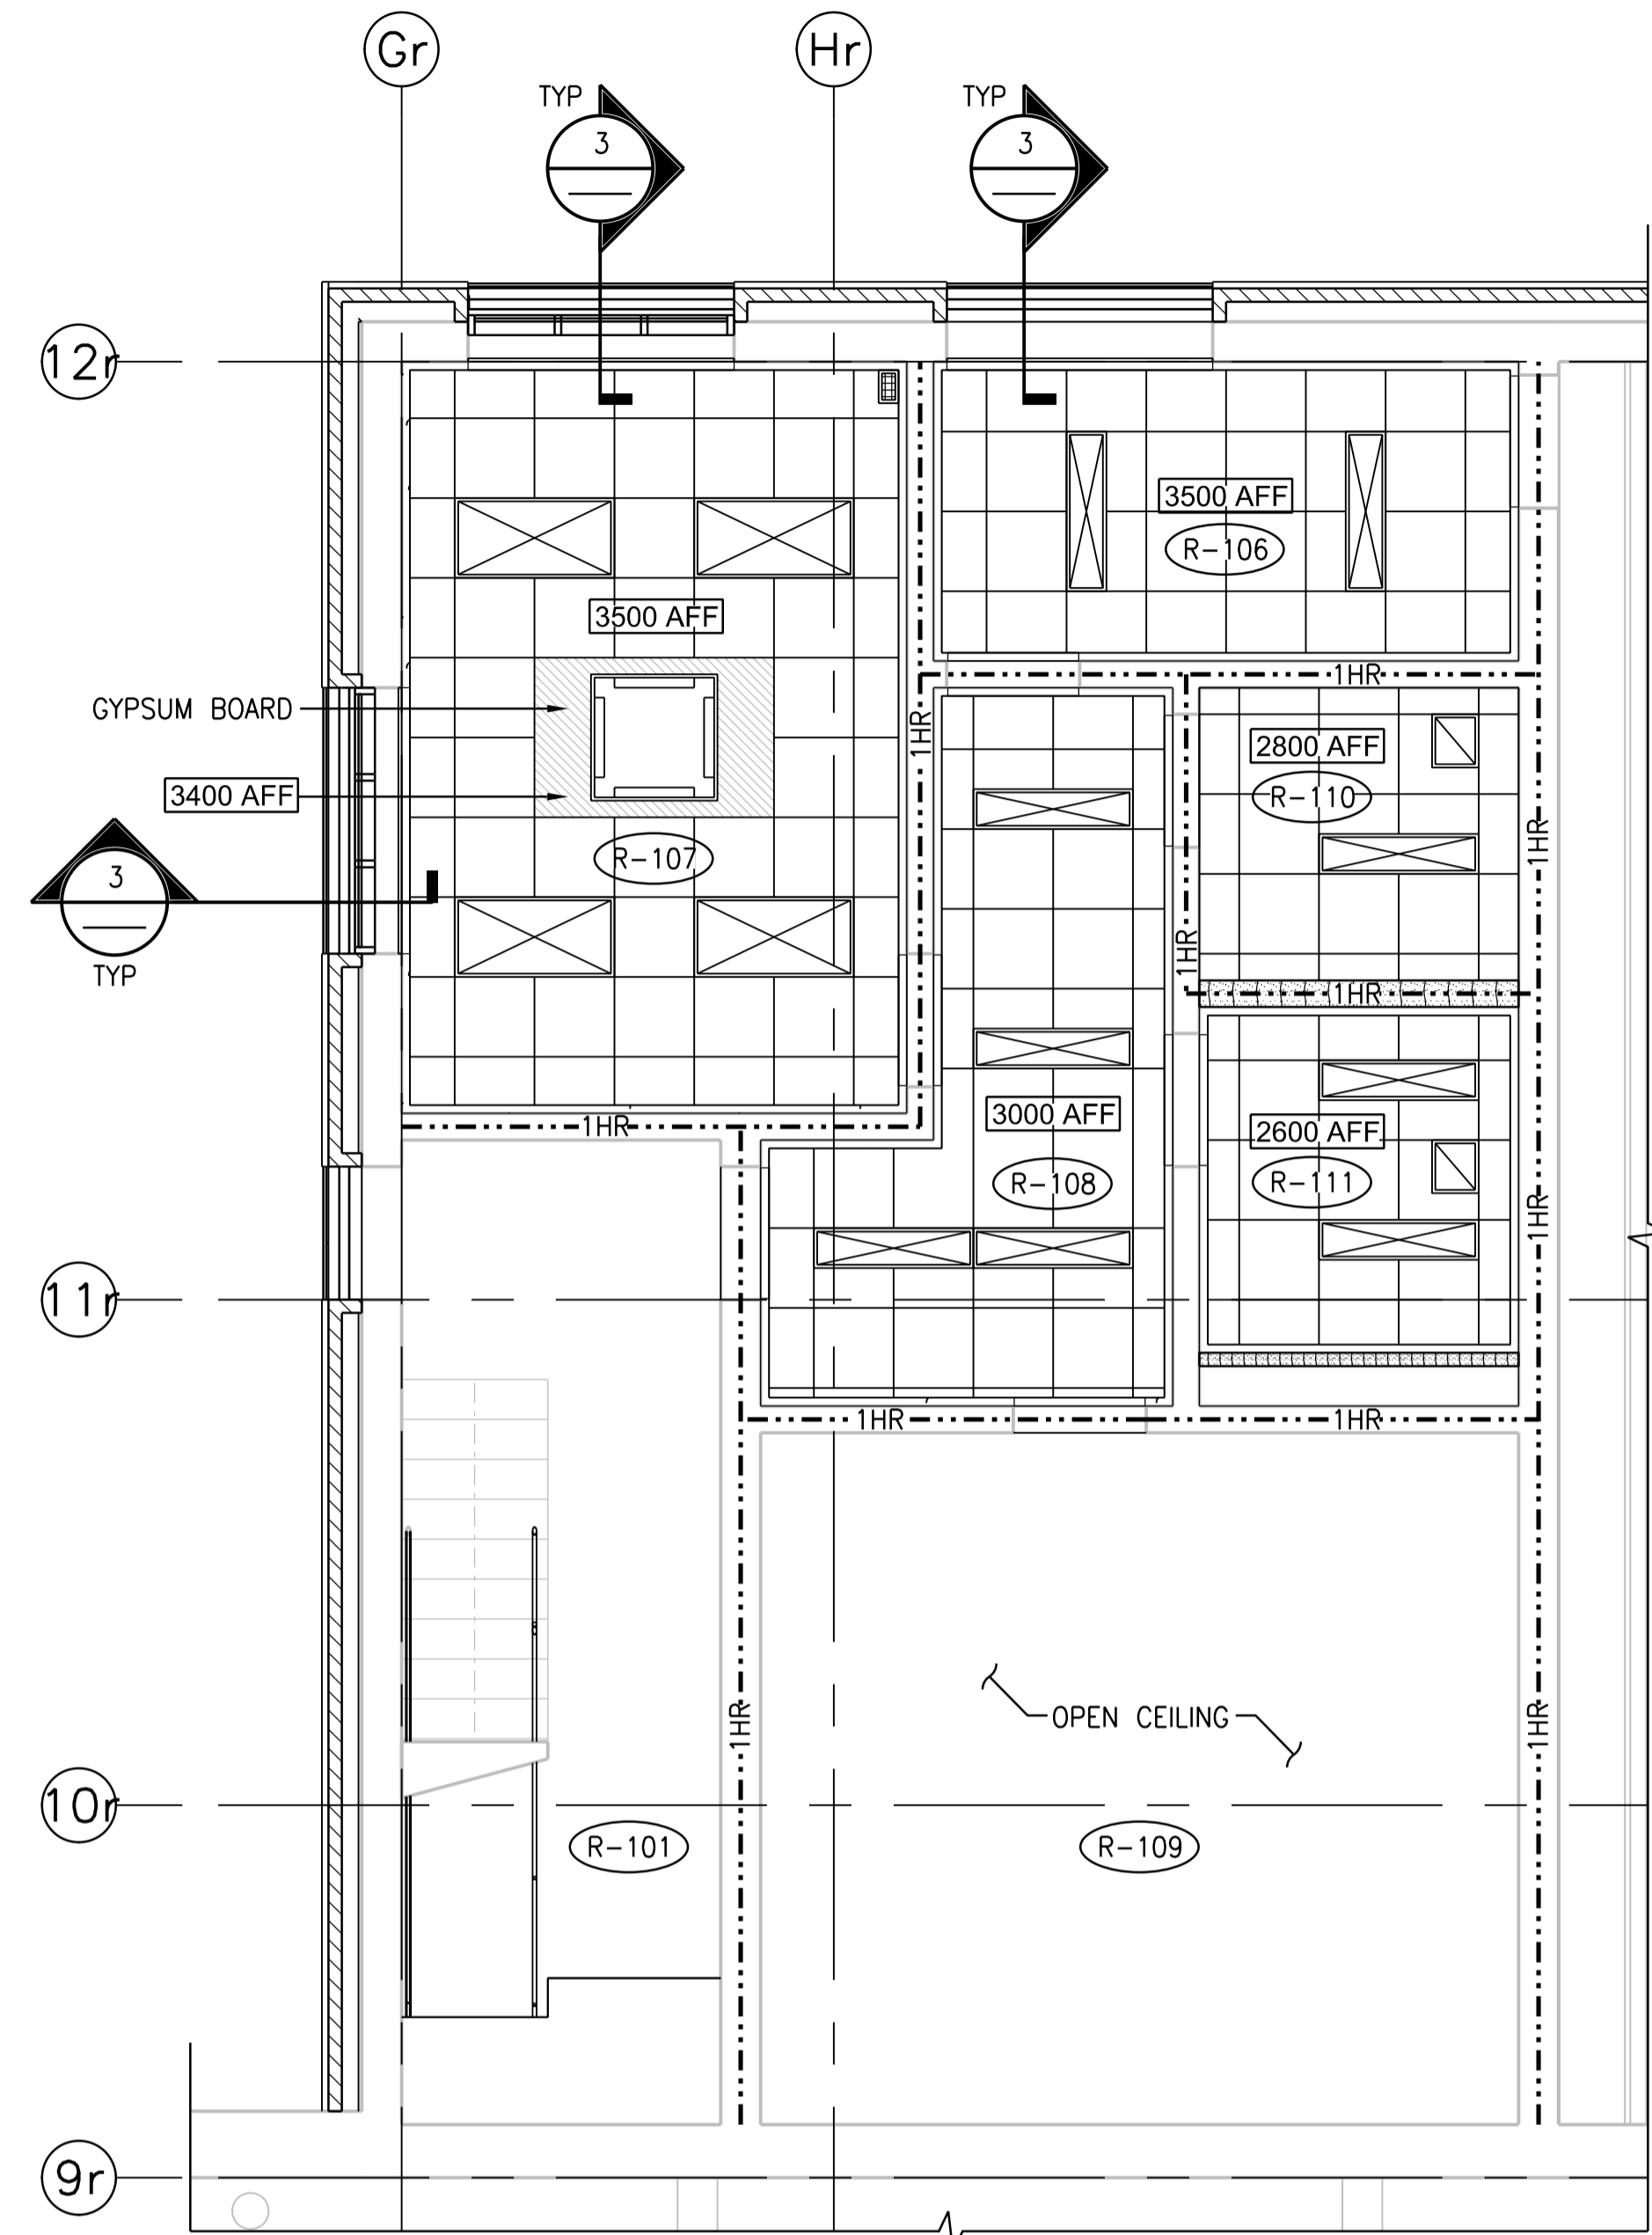


2 REFLECTED CEILING PLAN
1:50

LEGEND

	GYPSUM BOARD		AC SUPPLY
	SUSPENDED ACOUSTICAL TILE CEILING SYSTEM		FRESH AIR GRILL
	RECESSED LIGHTING FIXTURES. SEE ELECTRICAL DRAWINGS.		EXHAUST GRILL
		AFF	ABOVE FLOOR FINISH

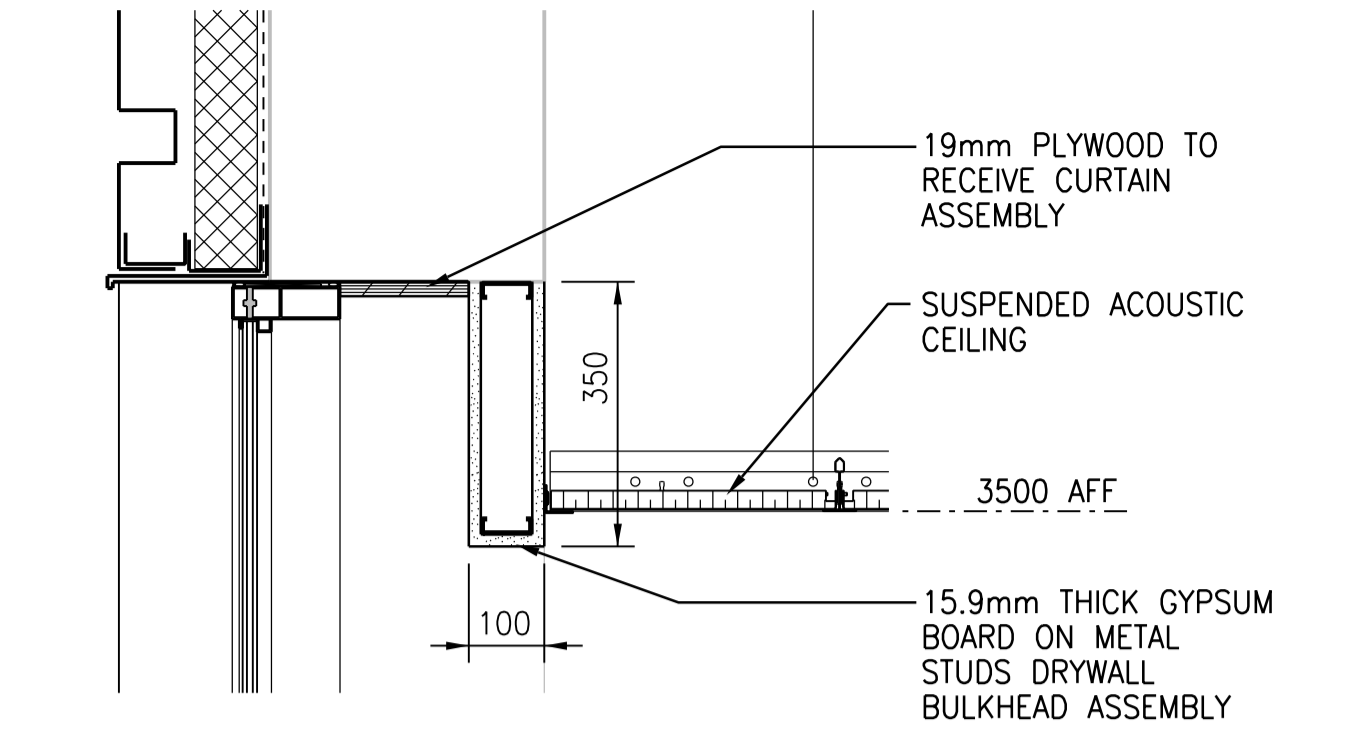


3 SECTION DETAIL
NTS

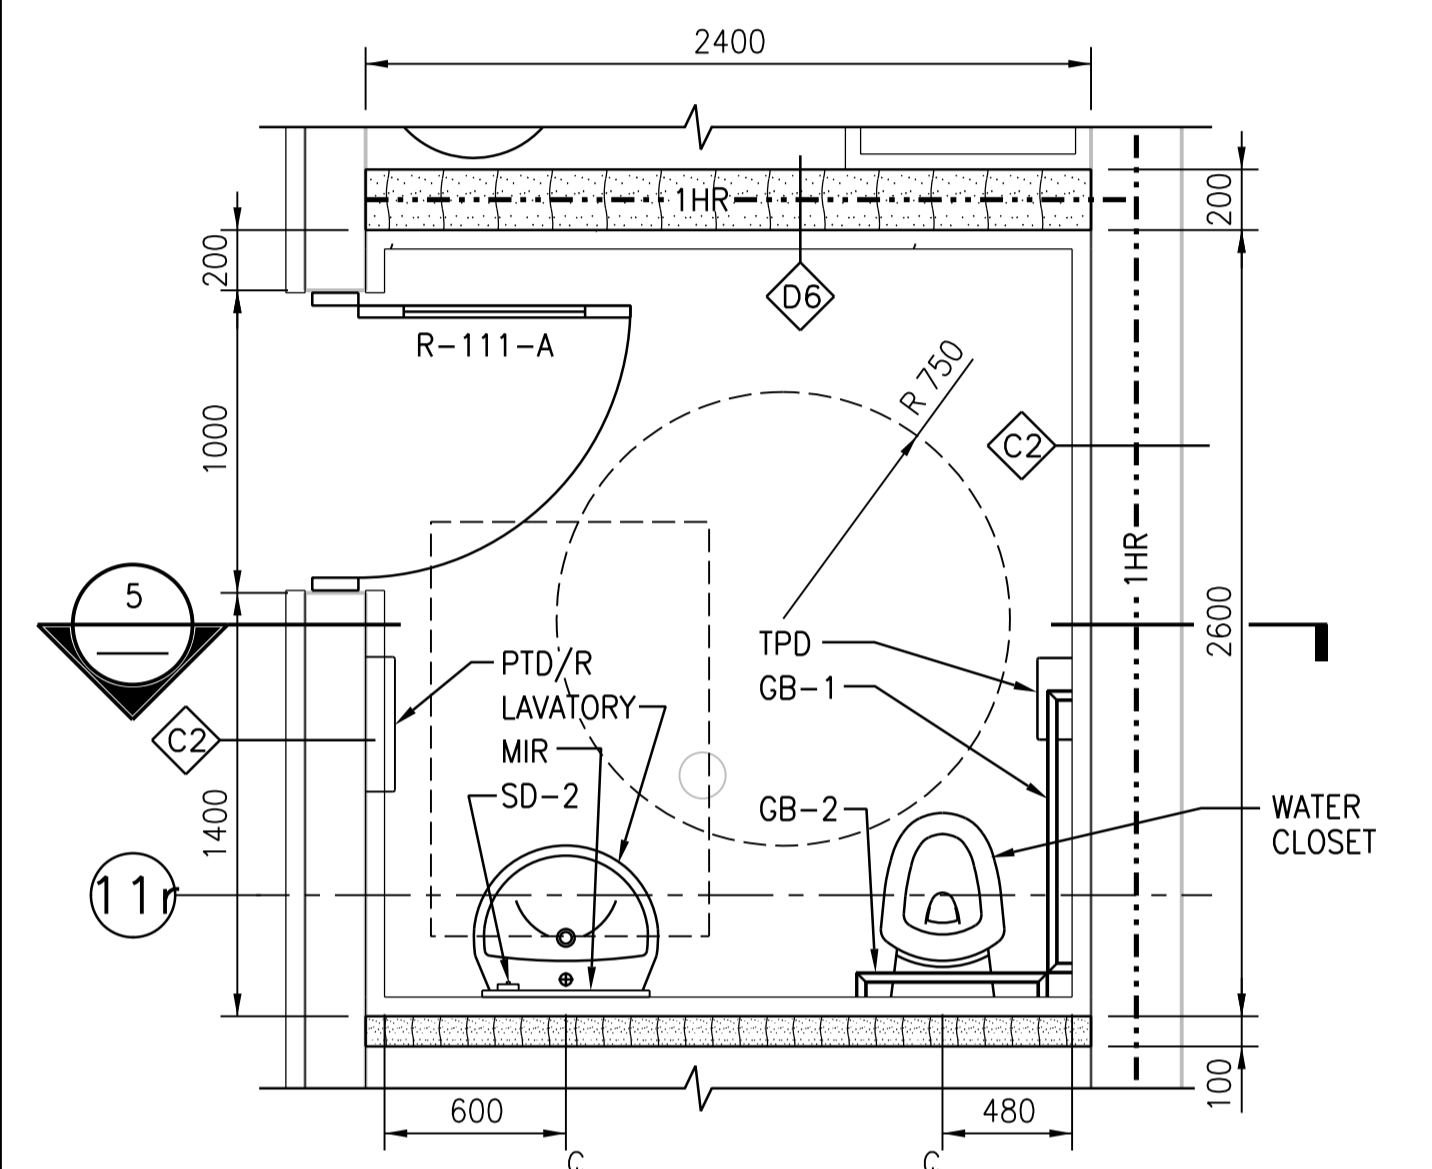


4 WASHROOM DETAILED PLAN
1:25

WASHROOM ACCESSORIES:
 MIR - MIRROR (457mm(W) X 914mm(H))
 PTD/R - PAPER TOWEL DISPENSER AND RECEPTACLE
 SD-2 - WALL MOUNTED SOAP DISPENSER
 TP - TOILET PAPER DISPENSER
 GB-1 - GRAB BAR (915mm 45-DEGREES)
 GB-2 - GRAB BAR (610mm)

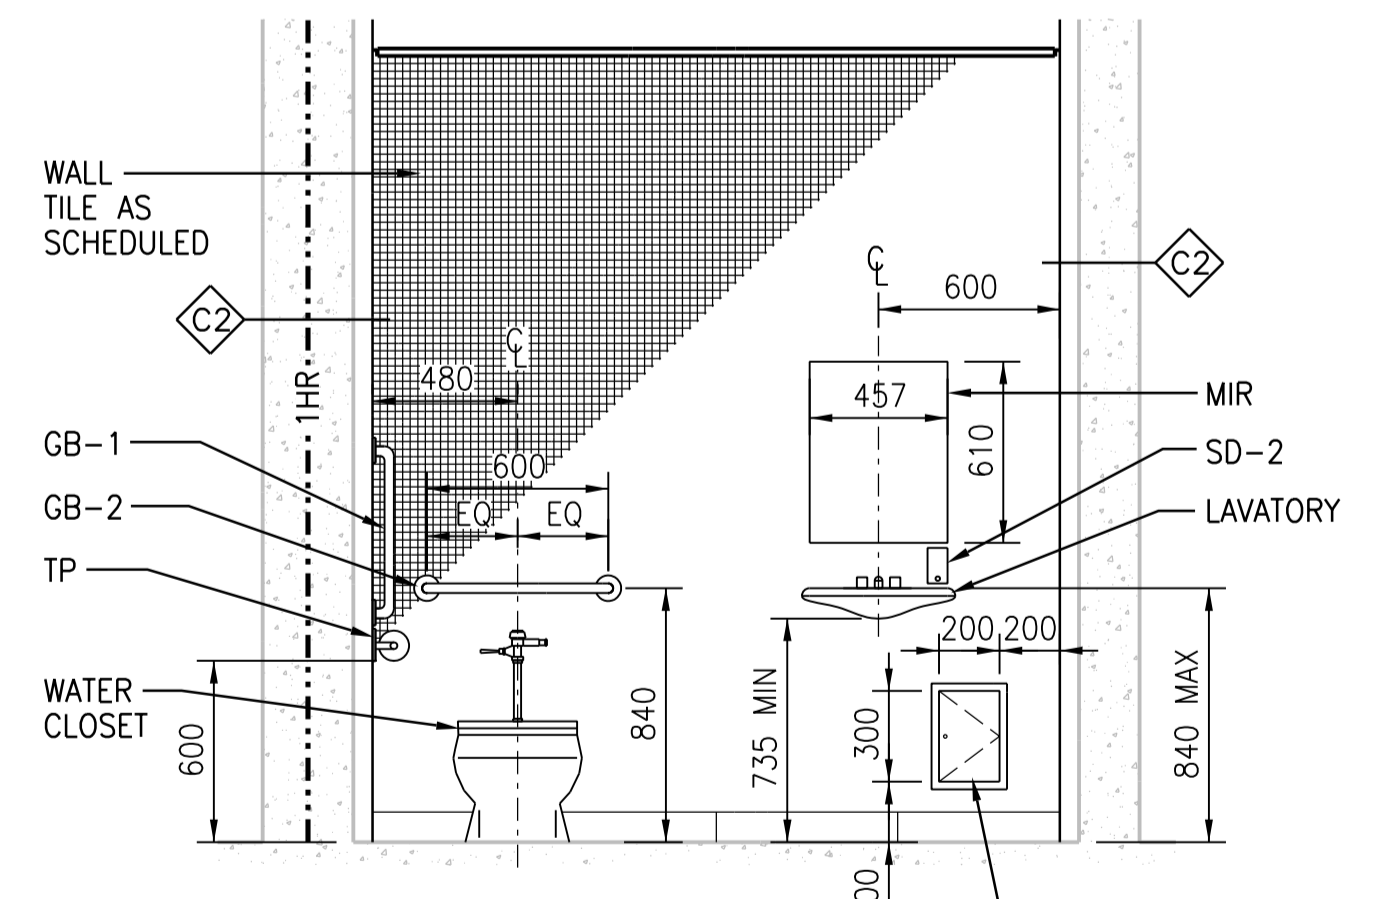

5 WASHROOM DETAILED SECTION
1:25

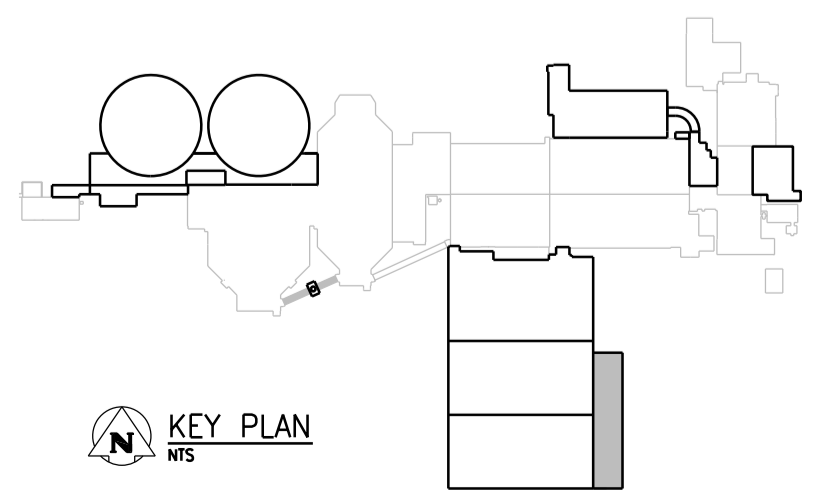

APEGM
 Certificate of Authorization
 CH2M HILL Canada Ltd.
 No. 1441

01	ISSUED FOR ADDENDUM 6 - 976-2016	2017/07/19	R.B.	J.C.
00	ISSUED FOR CONSTRUCTION - 976-2016	2017/04/05	R.B.	J.C.
NO.	REVISIONS	DATE	DESIGN	CHECK

CH2MHILL CANADA
 Architects Inc.
 SNC-LAVALIN
 DESIGNED BY: R. ZAKKO
 DRAWN BY: R. BATHAN
 SCALE: AS SHOWN
 DATE: 2017/04/05
 CONSULTANT NO.: 474248

ENGINEER'S SEAL
 REID ZAKKO
 REGISTERED ARCHITECT

THE CITY OF WINNIPEG
 WATER AND WASTE DEPARTMENT
 SOUTH END WATER POLLUTION CONTROL CENTRE
 SEWPCC UPGRADING/EXPANSION PROJECT
 BUILDING
 BIOREACTORS/BLOWER BUILDING
 PLAN DETAILS
 CITY DRAWING NUMBER: 1-0102-BGAD-R017
 SHEET: 01
 REV: A1
 SIZE: A1