


A1 SIZE (594 mm x 841 mm)  
 Plotted: December 8, 2017 at 12:23:36 PM | Last saved by: Patresenc  
 File: P:\2017\17M-00806-00 - Truro Creek Culvert Replacements\MM Drawings\17M-00806-00 Truro Creek Culvert Replacements DD Winchester 04 site plan.dwg | Layout: 4 Existing Site Plan



**EXISTING SITE PLAN**

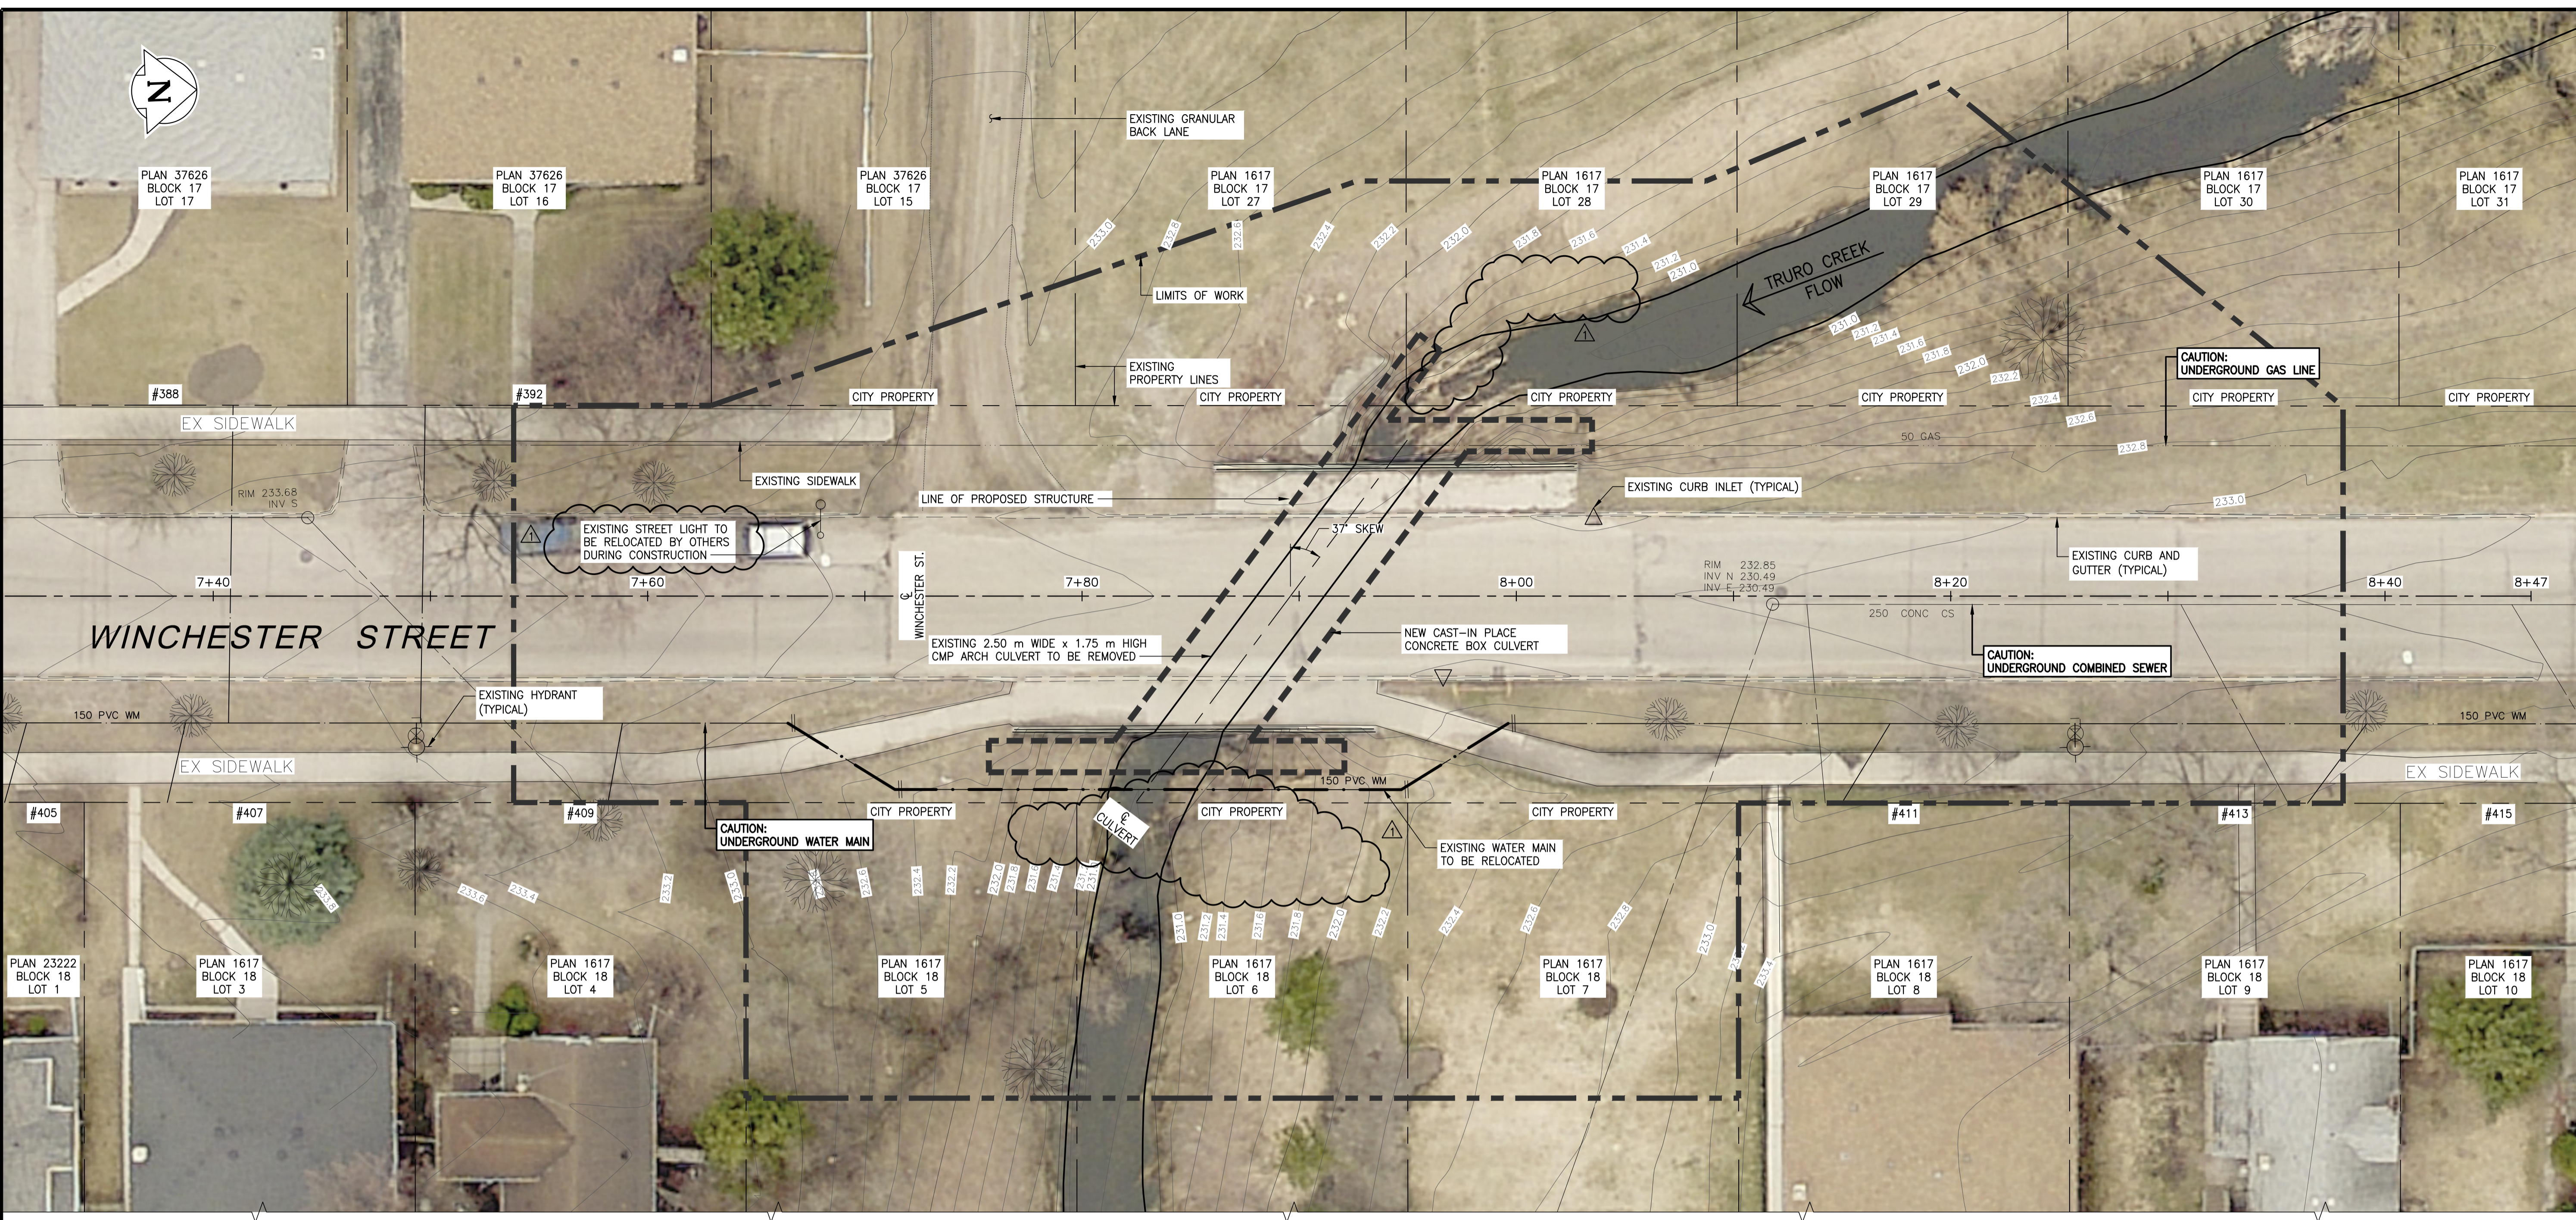

**NOTE:**  
 These design documents are prepared solely for the use by the party with whom the design professional has entered into a contract and there are no representations of any kind made by the design professional to any party with whom the design professional has not entered into a contract.

**NOTE**  
 1. FOR SYMBOLS NOT SHOWN IN LEGEND SEE SHEET 24.

**METRIC**  
 WHOLE NUMBERS INDICATE MILLIMETRES  
 DECIMALIZED NUMBERS INDICATE METRES



EXISTING	LEGEND-PLAN	PROPOSED	EXISTING	LEGEND-PLAN	PROPOSED
	EXISTING WATER MAIN LINE			LIGHT STANDARD	
	EXISTING COMBINED SEWER			CURB INLET	
	EXISTING GAS LINE			PLUG	
	ROADWAY CENTRELINE			HYDRANT	
	PROPERTY LINE			VALVE	
	EDGE OF SIDEWALK			GROUND GRADE	
	EXISTING CURB AND GUTTER			CIVIC ADDRESS	
	EXISTING TREE				
	EXISTING TREE TO BE REMOVED				


**LOCATIONS APPROVED UNDERGROUND STRUCTURES**

SIGNED BY: \_\_\_\_\_ DATE: \_\_\_\_\_  
 SUPV U/G STRUCTURES

LOCATION OF UNDERGROUND STRUCTURES AS SHOWN ARE BASED ON THE BEST INFORMATION AVAILABLE BUT NO GUARANTEE IS GIVEN THAT ALL EXISTING UTILITIES ARE SHOWN OR THAT THE GIVEN LOCATIONS ARE EXACT CONFIRMATION OF EXISTANCE AND EXACT LOCATION OF ALL SERVICES MUST BE OBTAINED FROM THE INDIVIDUAL UTILITIES BEFORE PROCEEDING

No.	REVISIONS	DATE	BY
1	ISSUED FOR ADDENDUM No. 2	17.12.08	JL
0	ISSUED FOR TENDER	17.11.23	JL

		WSP Canada Group Limited 93 Lombard Avenue, Suite 111 Winnipeg MB R3B 3B1 T+ 1 204-943-3178 F+ 1 204-943-4948 www.wsp.com	
DESIGNED BY	MLW	CHECKED BY	WC
DRAWN BY	FD	APPROVED BY	JL
HOR. SCALE	1:150	RELEASED FOR CONSTRUCTION	
VERTICAL	1:150		
DATE	17.11.23	DATE	

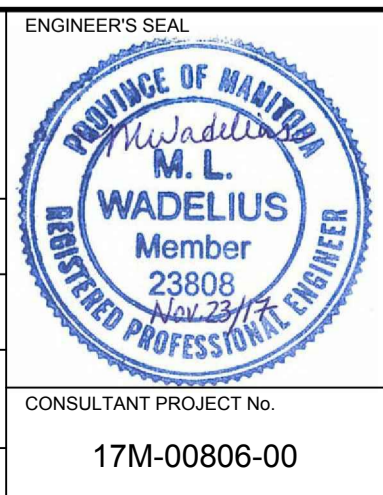

**THE CITY OF WINNIPEG**  
 PUBLIC WORKS DEPARTMENT  
 ENGINEERING DIVISION

**TRURO CREEK CULVERT REPLACEMENT AT WINCHESTER STREET**

CONSULTANT PROJECT No. 17M-00806-00

EXISTING SITE PLAN

CITY DRAWING NUMBER	C322-17-04
BID OPPORTUNITY NUMBER	1014-2017
SHEET OF	4 OF 25
REV	1