



FILE NAME: DATE: DF SHEET TITLE: KEY PLAN PROJECT No: 2017-055 ADDRESS: 185 KING 03

NOTES:

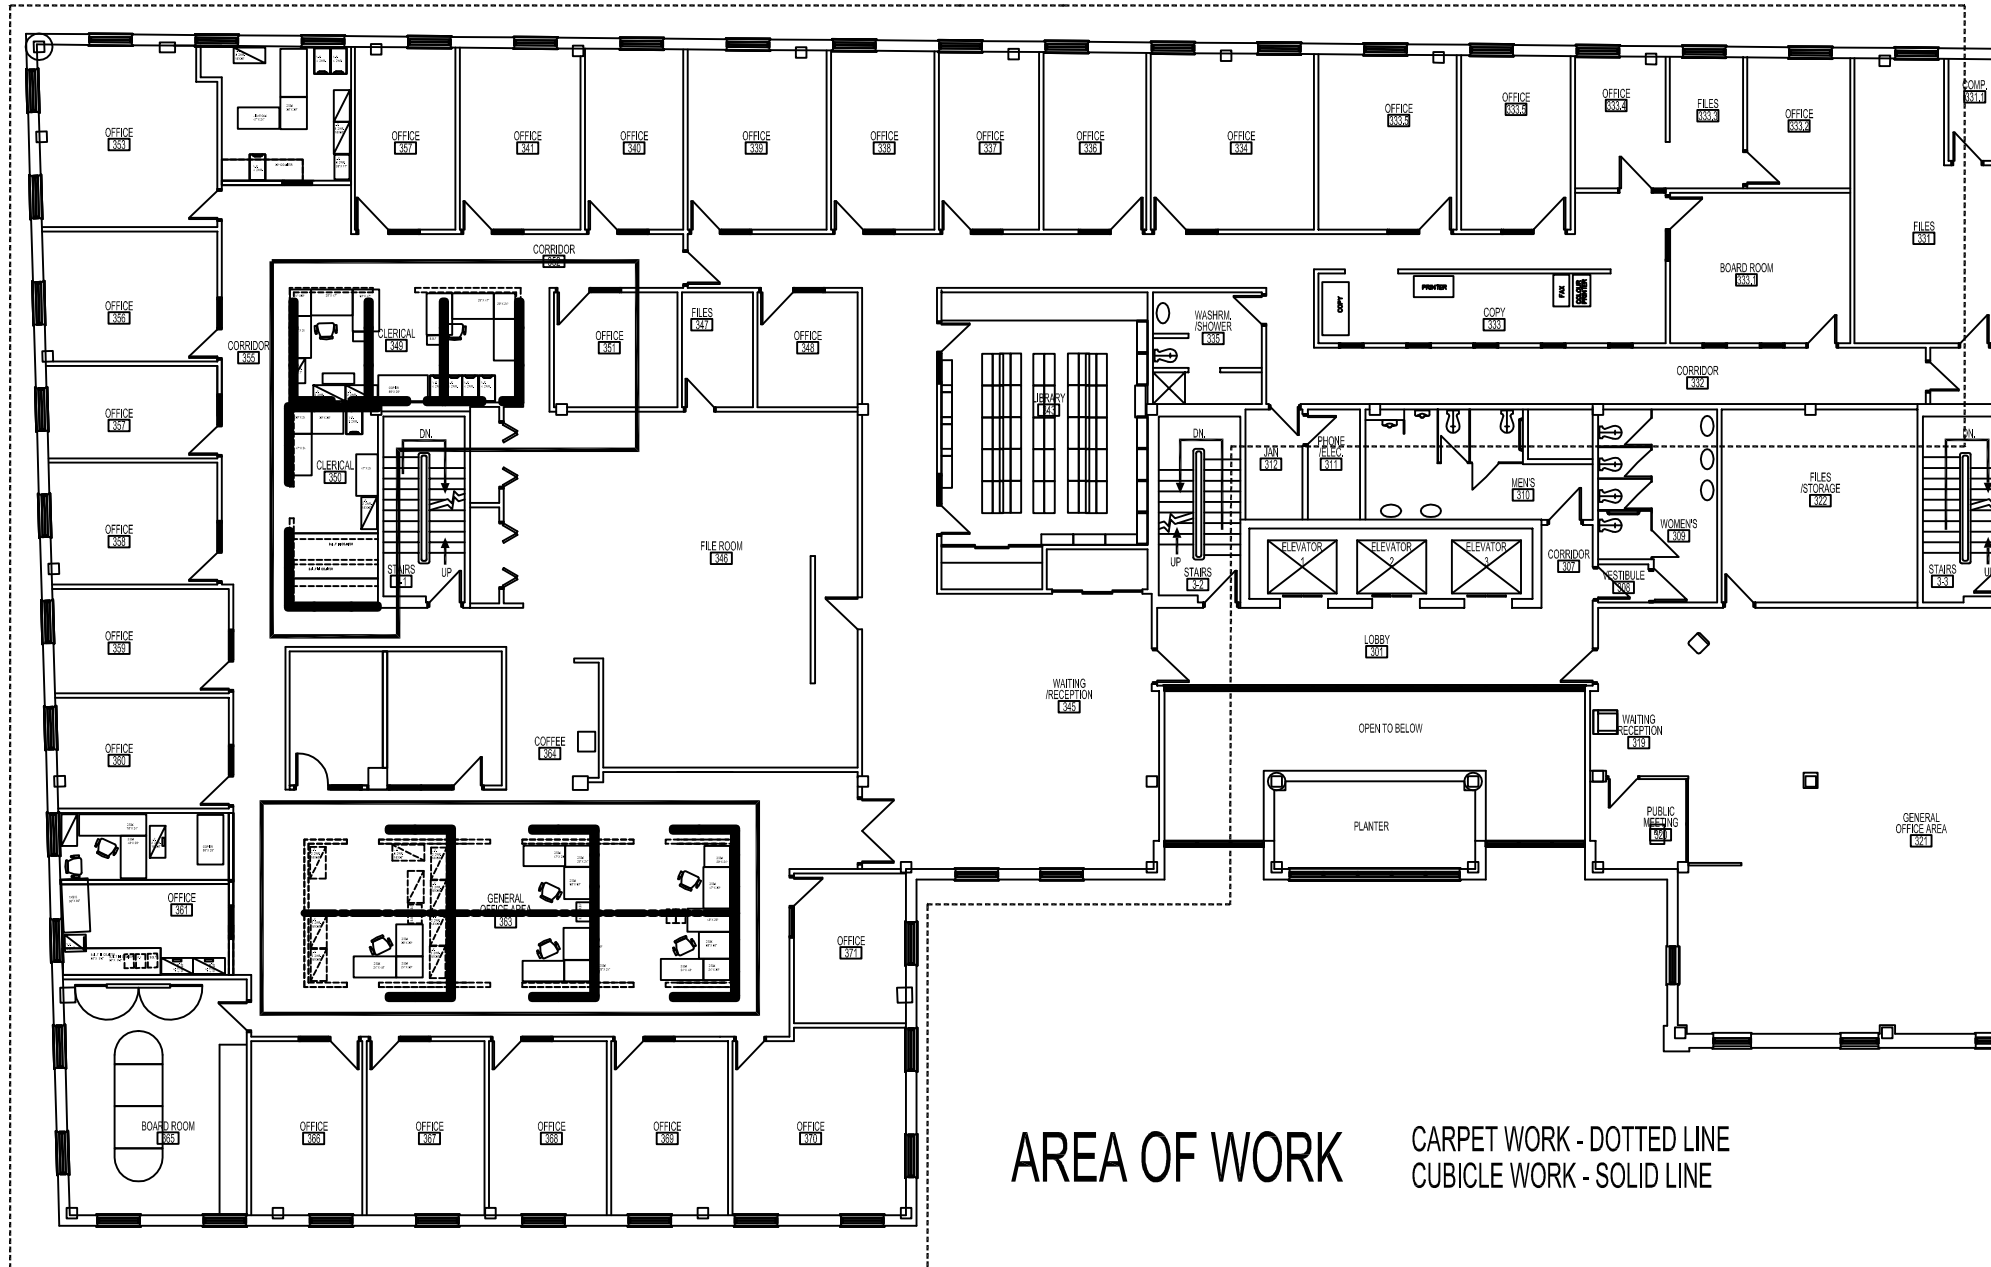

AREA OF WORK
 CARPET WORK - DOTTED LINE
 CUBICLE WORK - SOLID LINE

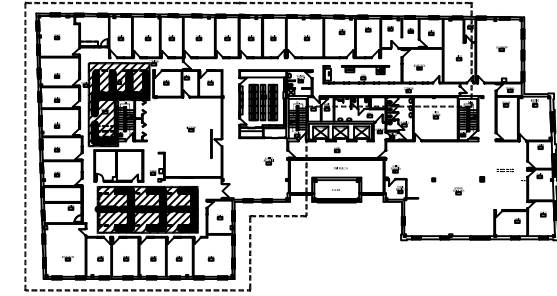

KEY PLAN
 SCALE: N.T.S.

AREA OF WORK
 CARPET WORK - DOTTED LINE
 CUBICLE WORK - SOLID LINE

PARTIAL THIRD FLOOR PLAN -
 SCALE: 1/8"=1'-0"

DRAWING LIST	
SHEET No:	SHEET TITLE
A0	KEY PLAN: DRAWING LIST
A1	DEMOLITION PLAN
A2	NEW CONSTRUCTION : MATERIAL LIST; ELEVATION
A3	NEW FURNITURE PLAN
A4	
F1	FIRE PROTECTION PLAN: DEMOLITION & RENOVATION
E1	
E2	

No.	REVISION/DESCRIPTION	BY	DATE
SEAL			

DRAWN DATE	CHECKED USER	DESIGNED USER	APPROVED USER

THE CITY OF WINNIPEG
 PLANNING, PROPERTY AND
 DEVELOPMENT DEPARTMENT
 MUNICIPAL ACCOMMODATIONS DIVISION
 3-65 GARRY STREET, R3C 4K4

PROJECT
 185 KING STREET
 LEGAL SERVICES CARPET AND CUBICLE
 RENOVATION
 185 KING THIRD FLOOR

SHEET TITLE
 PARTIAL THIRD FLOOR PLAN
 KEY PLAN / PHASE DESCRIPTION

SCALE AS SHOWN PROJECT No: 2017-055 SHEET No: A0

DRAWING SHEET SIZE: A1 (841mm x 594mm) PLOT 1:1