


D SIZE 22" x 34" (559mm x 864mm)

PLOT: 3/29/2017 3:16:06 PM

AECOM REVIEW DRAFT CHK

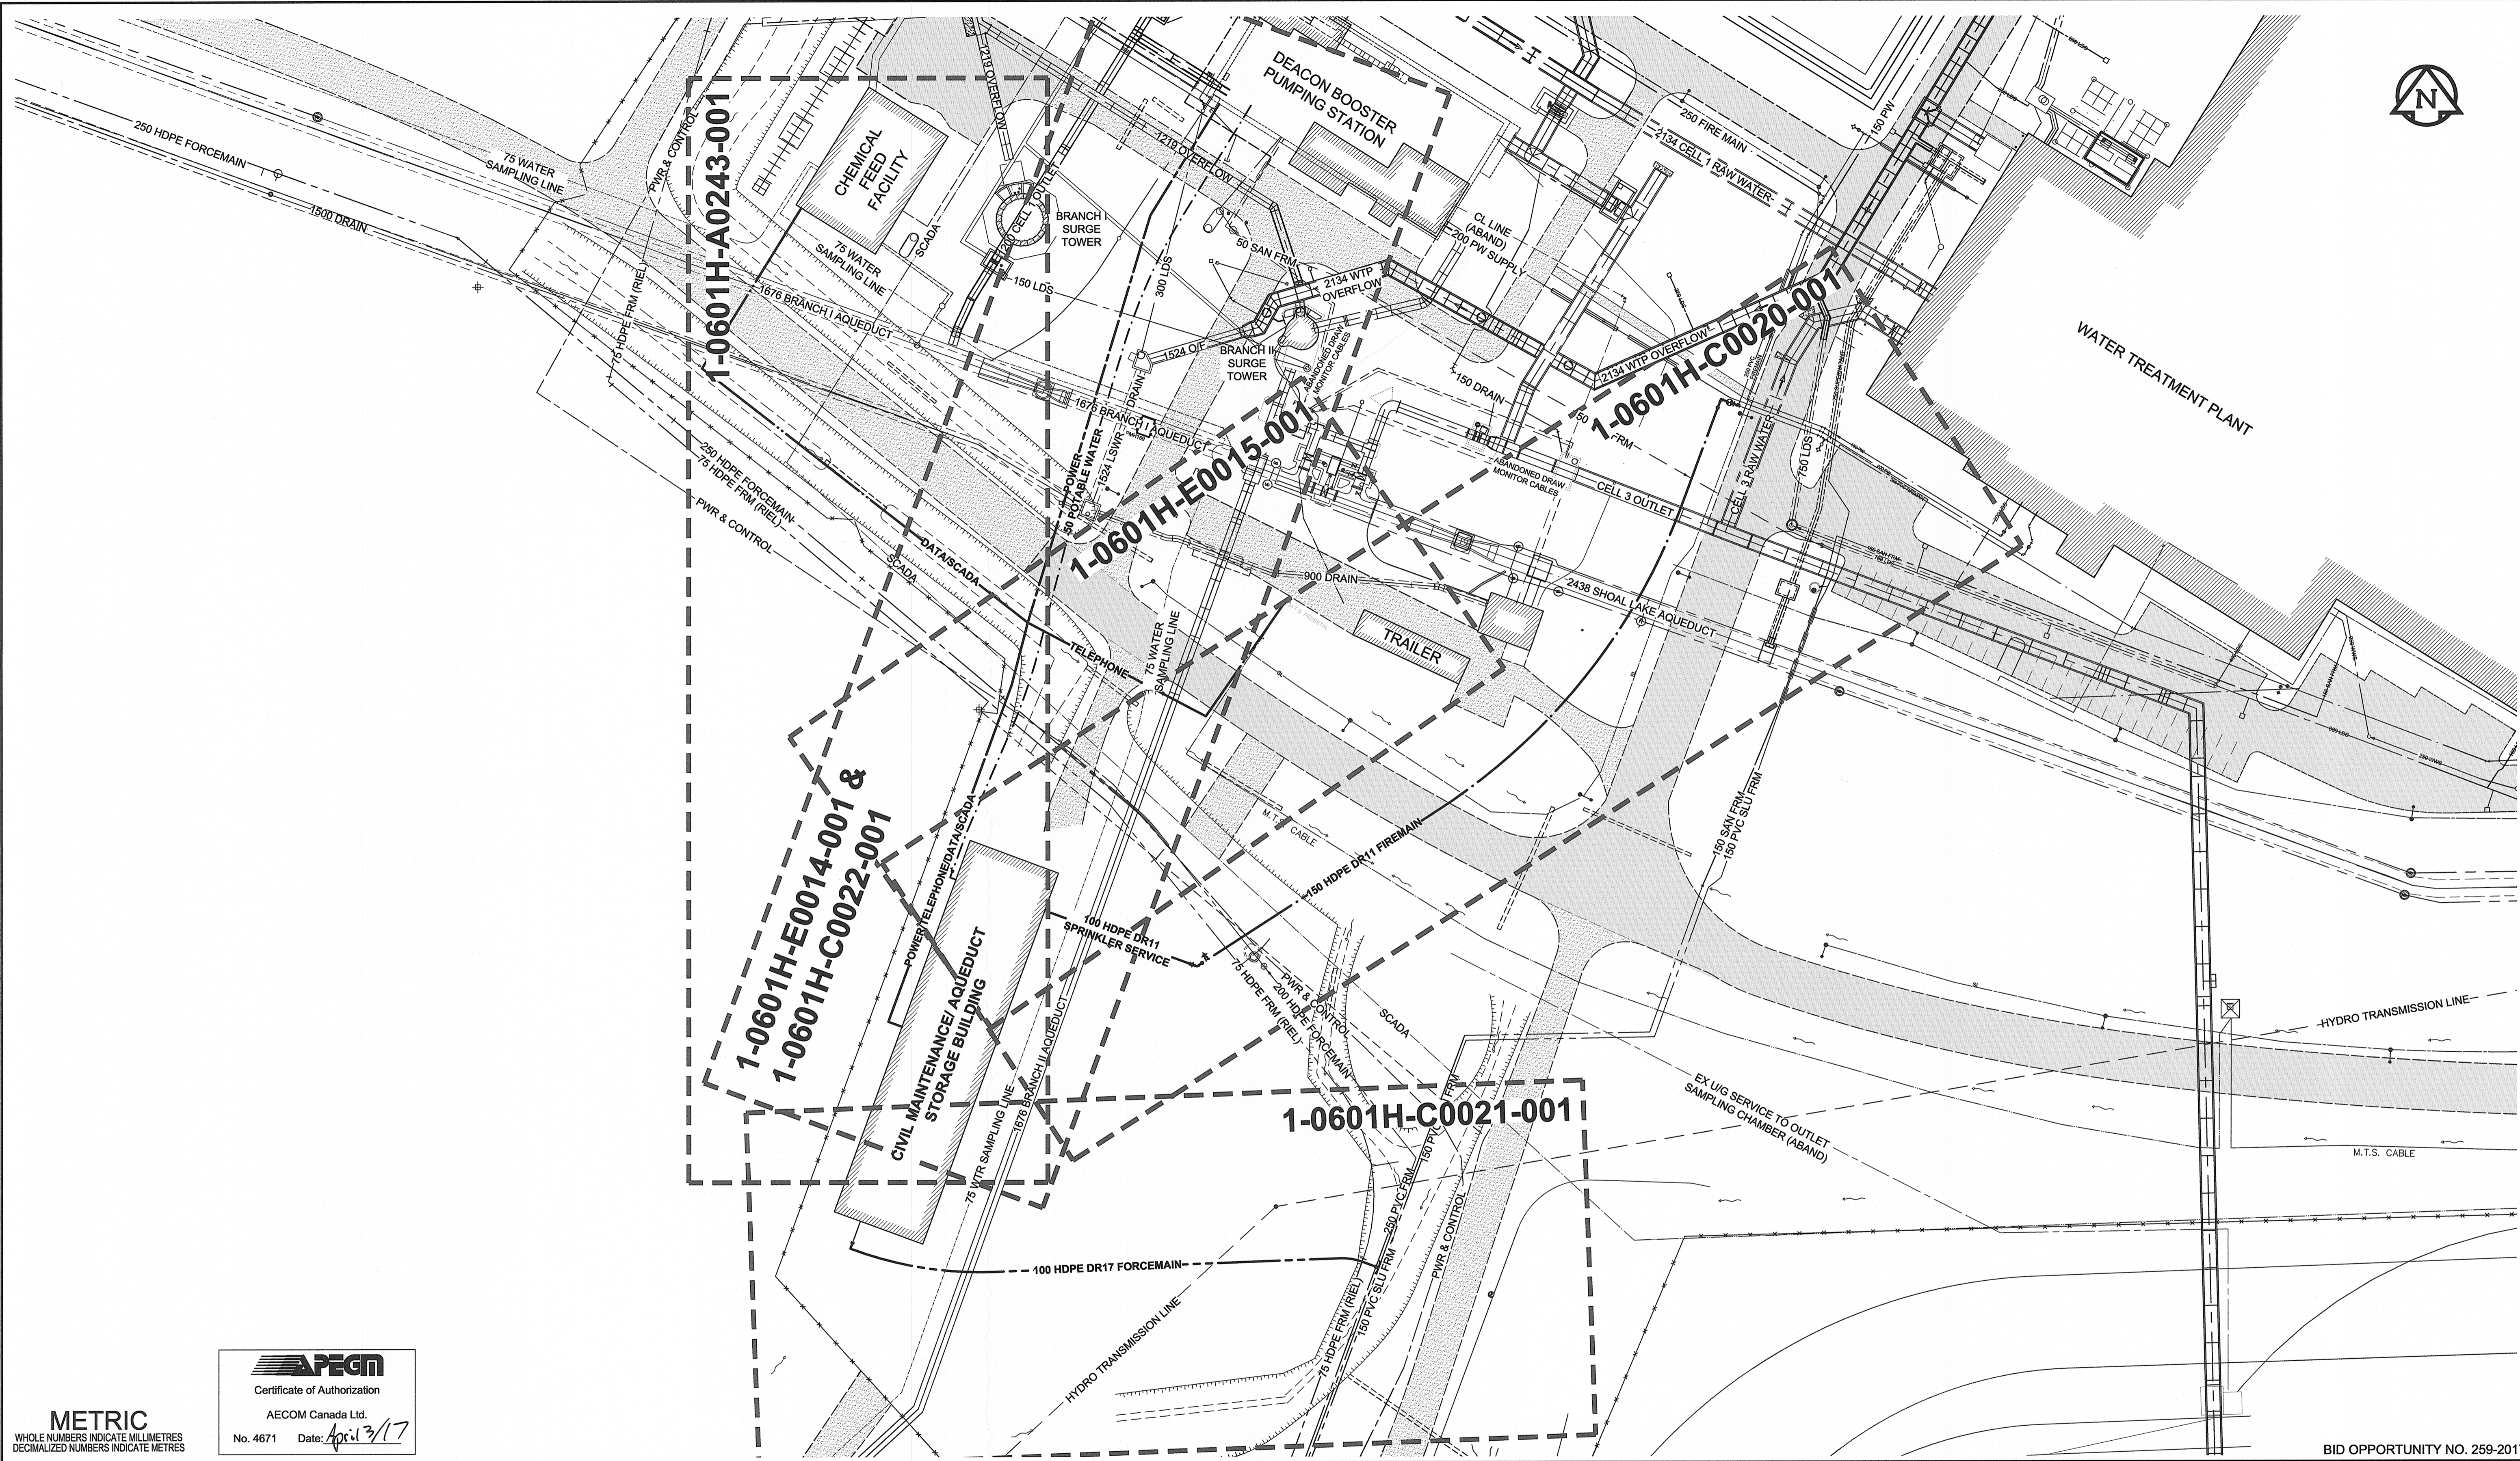

BID OPPORTUNITY NO. 259-2017

**APEGN**  
 Certificate of Authorization  
 AECOM Canada Ltd.  
 No. 4671 Date: April 13/17

**METRIC**  
 WHOLE NUMBERS INDICATE MILLIMETRES  
 DECIMALIZED NUMBERS INDICATE METRES

150 WM	WATERMAIN	150 WM	150 WM	CURB STOP	150 WM	WATERMAIN	150 WM	LOCATION APPROVED
Hydrant symbol	HYDRANT	Valve symbol	VALVE	Reducer symbol	Hydrant symbol	HYDRANT	Valve symbol	UNDERGROUND STRUCTURES
300 LDS	LAND DRAINAGE SEWER	300 LDS	LAND DRAINAGE SEWER	Coupling symbol	300 LDS	LAND DRAINAGE SEWER	300 LDS	SUPR. U/G STRUCTURES DATE COMMITTEE
250 WWS	WASTE WATER SEWER	250 WWS	WASTE WATER SEWER	Anode symbol	250 WWS	WASTE WATER SEWER	250 WWS	NOTE:
Manhole symbol	MANHOLE	Manhole symbol	MANHOLE	MTS symbol	250 WWS	WASTE WATER SEWER	250 WWS	LOCATION OF UNDERGROUND STRUCTURES AS SHOWN ARE BASED ON THE BEST INFORMATION AVAILABLE. BUT NO GUARANTEE IS GIVEN THAT ALL EXISTING UTILITIES ARE SHOWN OR THAT THE GIVEN LOCATIONS ARE EXACT. CONFIRMATION OF EXISTENCE AND EXACT LOCATION OF ALL SERVICES MUST BE OBTAINED FROM THE INDIVIDUAL UTILITIES BEFORE PROCEEDING WITH CONSTRUCTION.
Catch basin symbol	CATCH BASIN	Gas symbol	GAS	Testhole symbol	300 LDS	LAND DRAINAGE SEWER	300 LDS	
Curb inlet symbol	CURB INLET	Testhole symbol	TESTHOLE	Lamp standard symbol	250 WWS	WASTE WATER SEWER	250 WWS	
Culvert symbol	CULVERT	Lamp standard symbol	LAMP STANDARD	Tree symbol	150 WM	WATERMAIN	150 WM	
Pipe abandonment symbol	PIPE ABANDONMENTS	Tree symbol	TREE		300 LDS	LAND DRAINAGE SEWER	300 LDS	
Survey bar symbol	SURVEY BAR				250 WWS	WASTE WATER SEWER	250 WWS	
Existing symbol	EXISTING	New symbol	NEW	Legend - Plan	150 WM	WATERMAIN	150 WM	
Legend - Plan	LEGEND - PLAN	Legend - Profile	LEGEND - PROFILE		300 LDS	LAND DRAINAGE SEWER	300 LDS	

0	ISSUED FOR CONSTRUCTION	17/03/29	KLC
NO.	REVISIONS	YYMMDD	BY

**AECOM**

DESIGNED BY: GSK  
 CHECKED BY: P.W.I.  
 DRAWN BY: W.J.d.  
 APPROVED BY: [Signature]  
 RELEASED FOR CONSTRUCTION: April 13/17  
 DATE: [Signature]

PROFESSIONAL'S SEAL  
**BRAUN**  
 Member  
 24455  
 CONSULTANT DRAWING NO.  
 60516883-SHT-30-0000-C-1001

**THE CITY OF WINNIPEG**  
 WATER AND WASTE DEPARTMENT

**CIVIL MAINTENANCE/ AQUEDUCT STORAGE BUILDING**  
 INSTALLATION OF ELECTRICAL AND COMMUNICATION UTILITIES AND SEWER AND WATER SERVICING

GENERAL SITE PLAN  
 WINNIPEG WATER TREATMENT PLANT

SHEET 1 OF 8  
 CITY DRAWING NUMBER  
 1-0601H-G0001-001  
 REV 0