
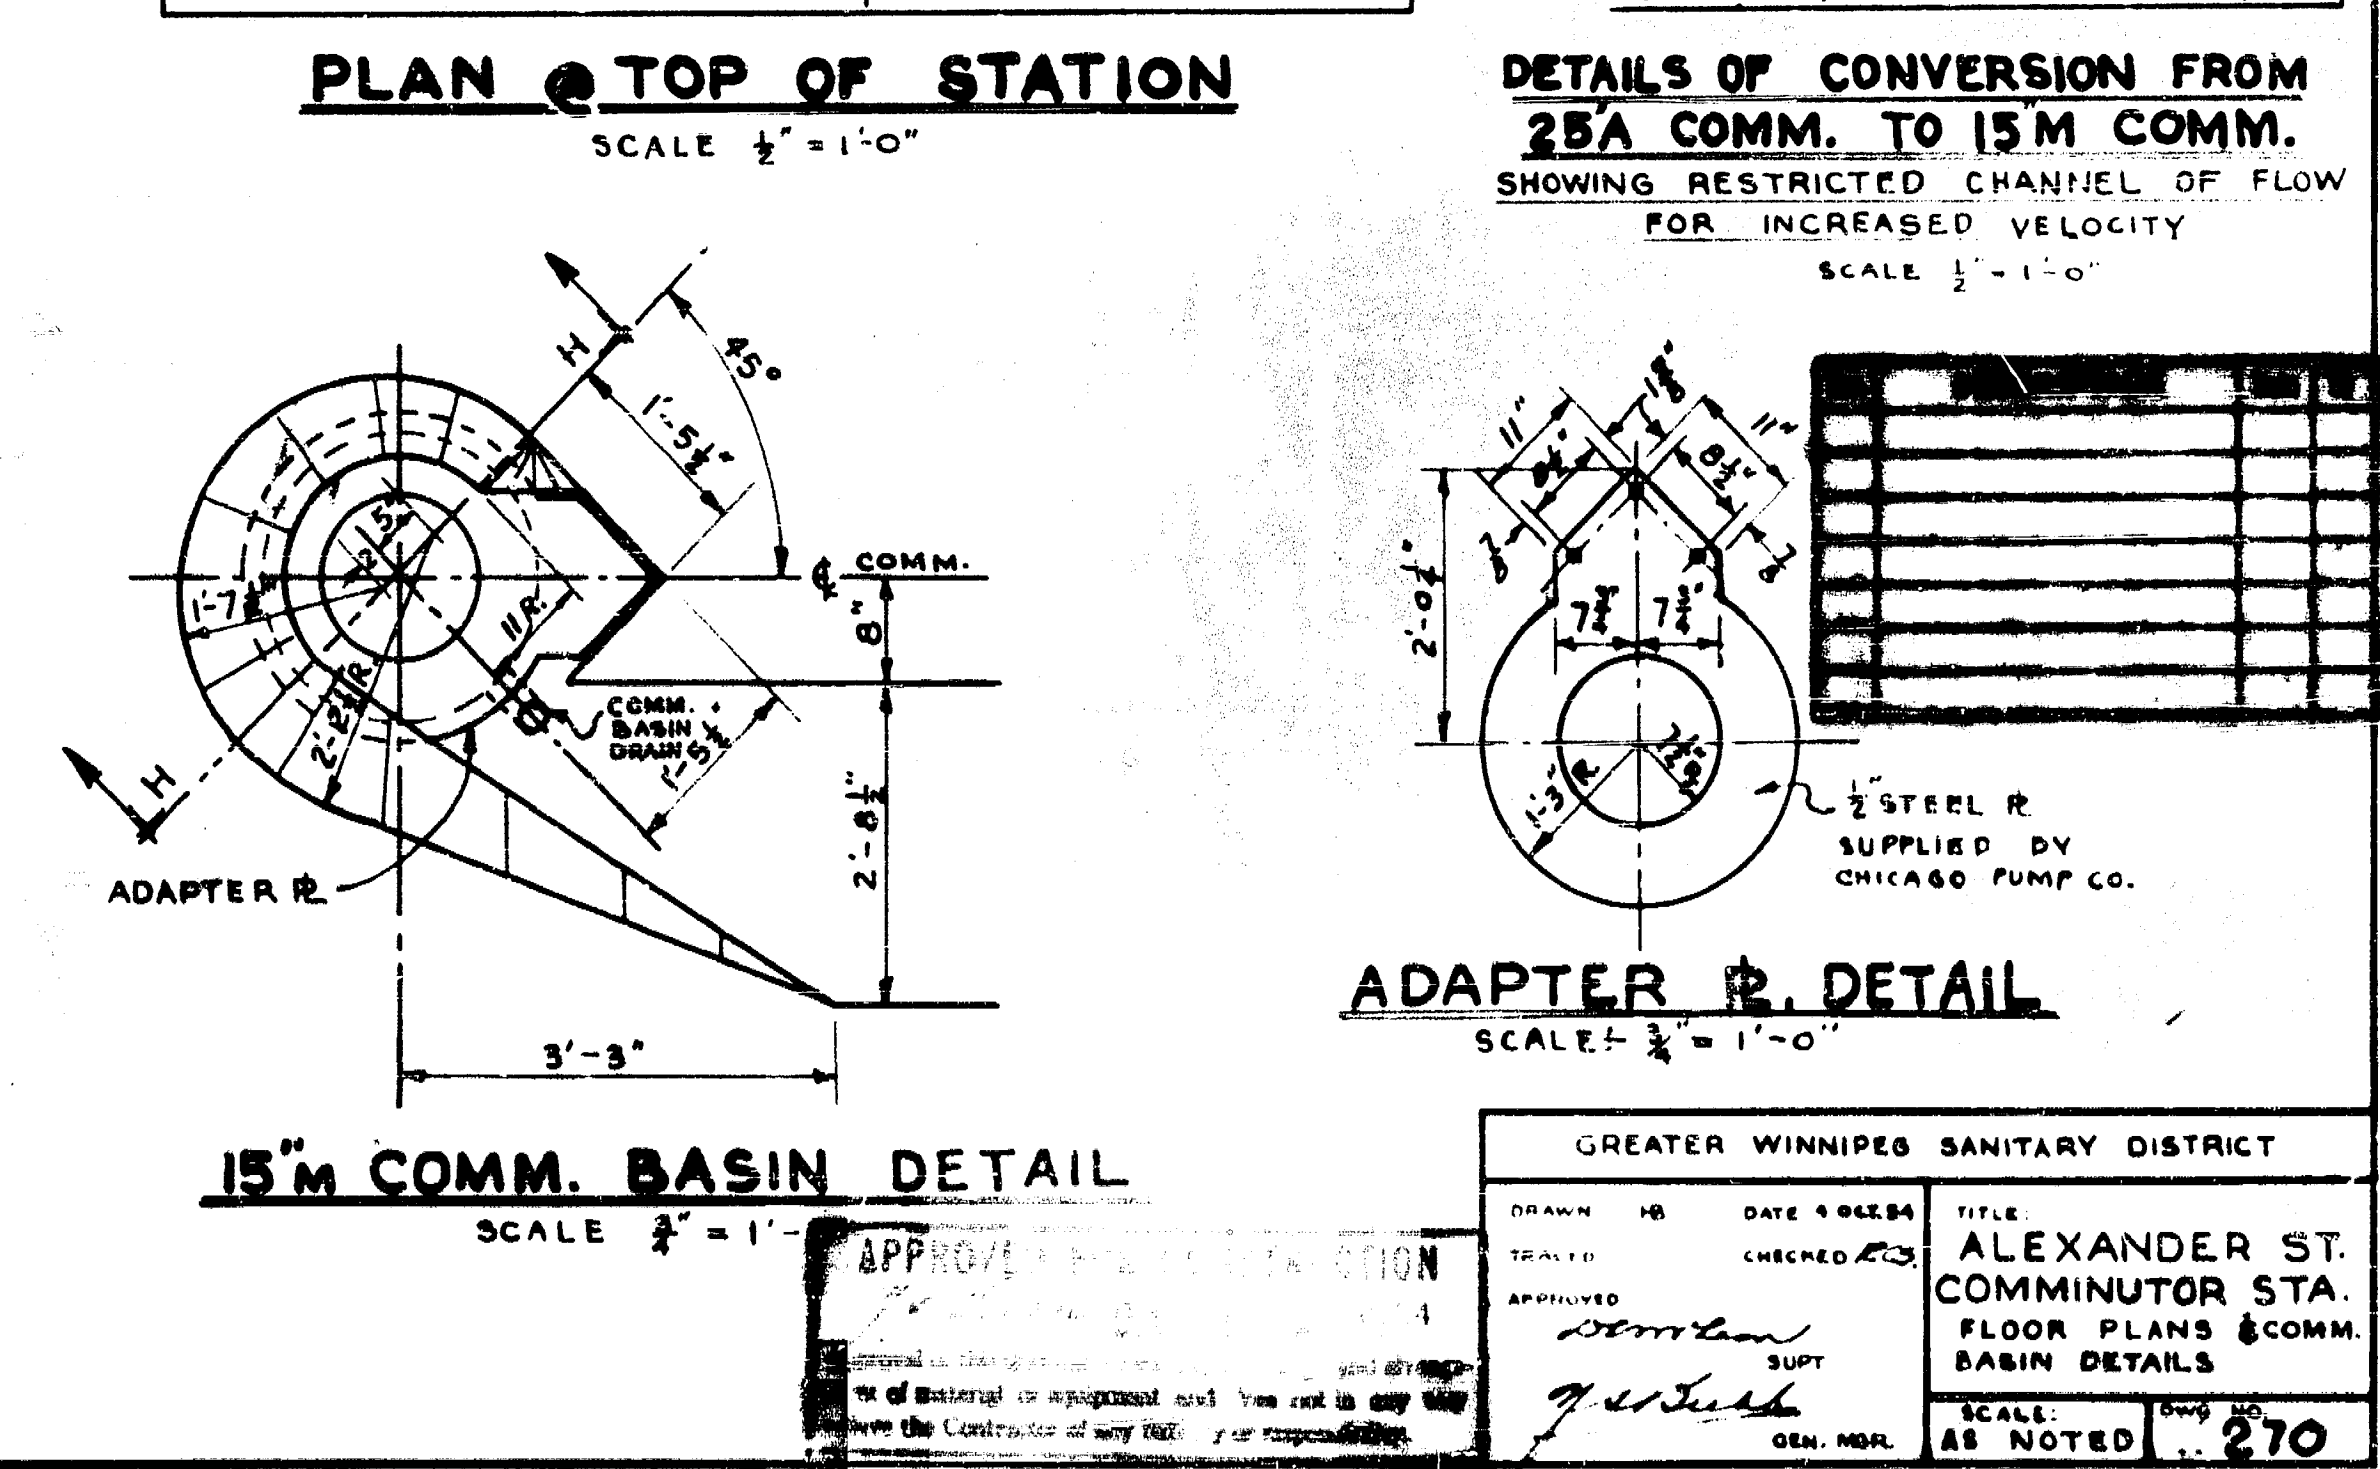
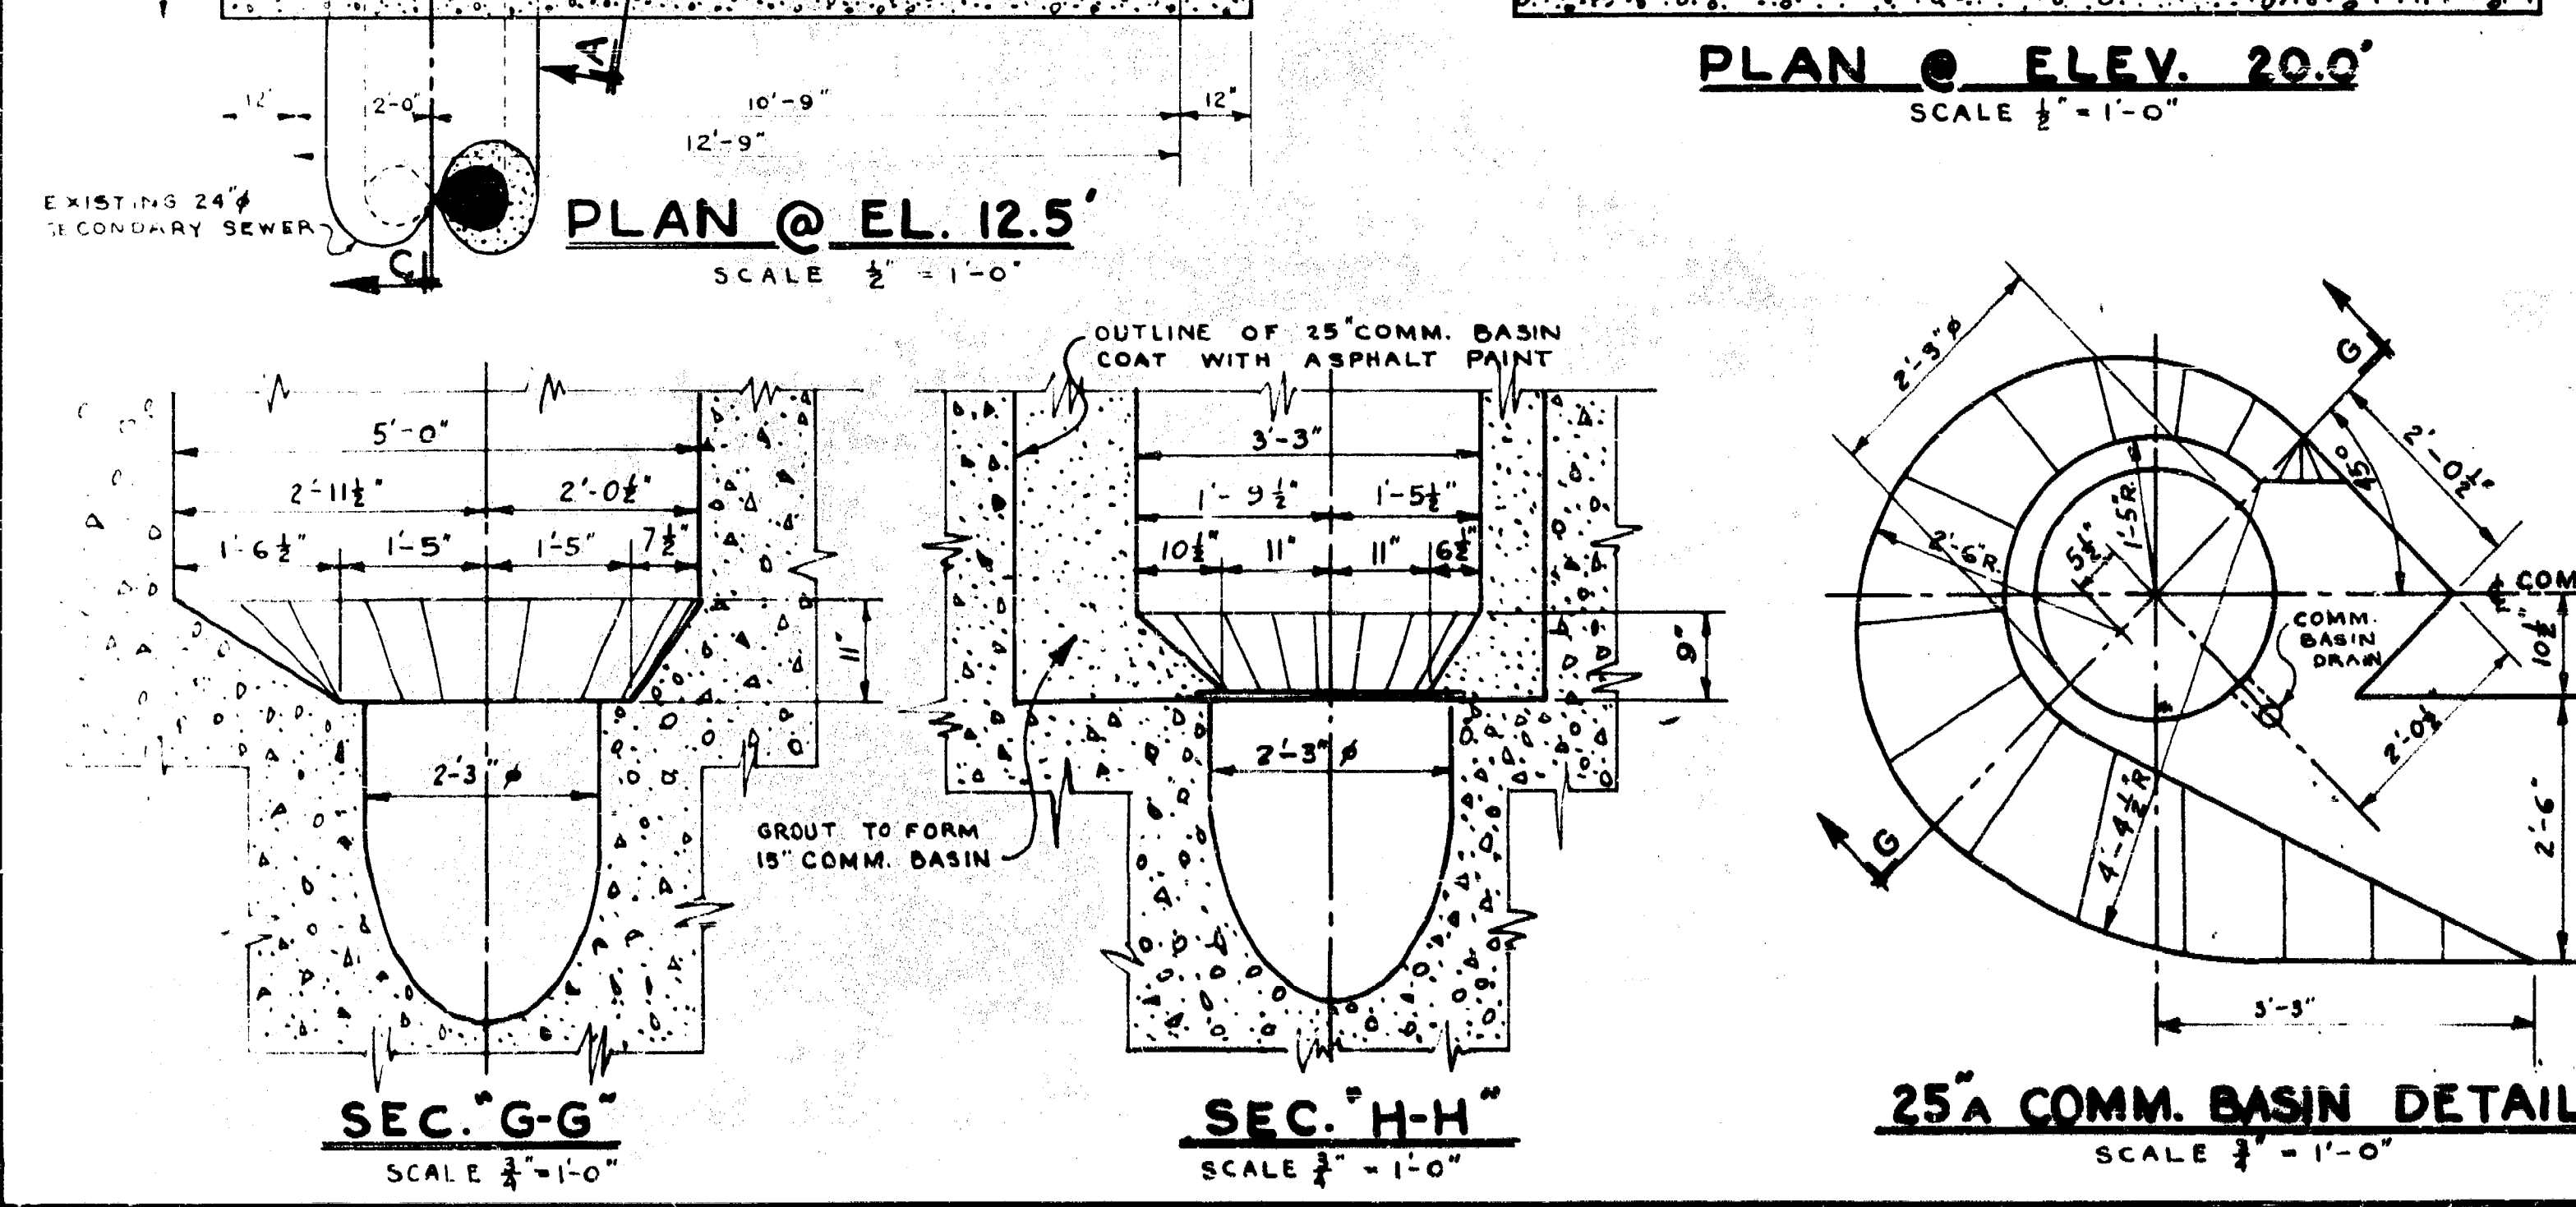
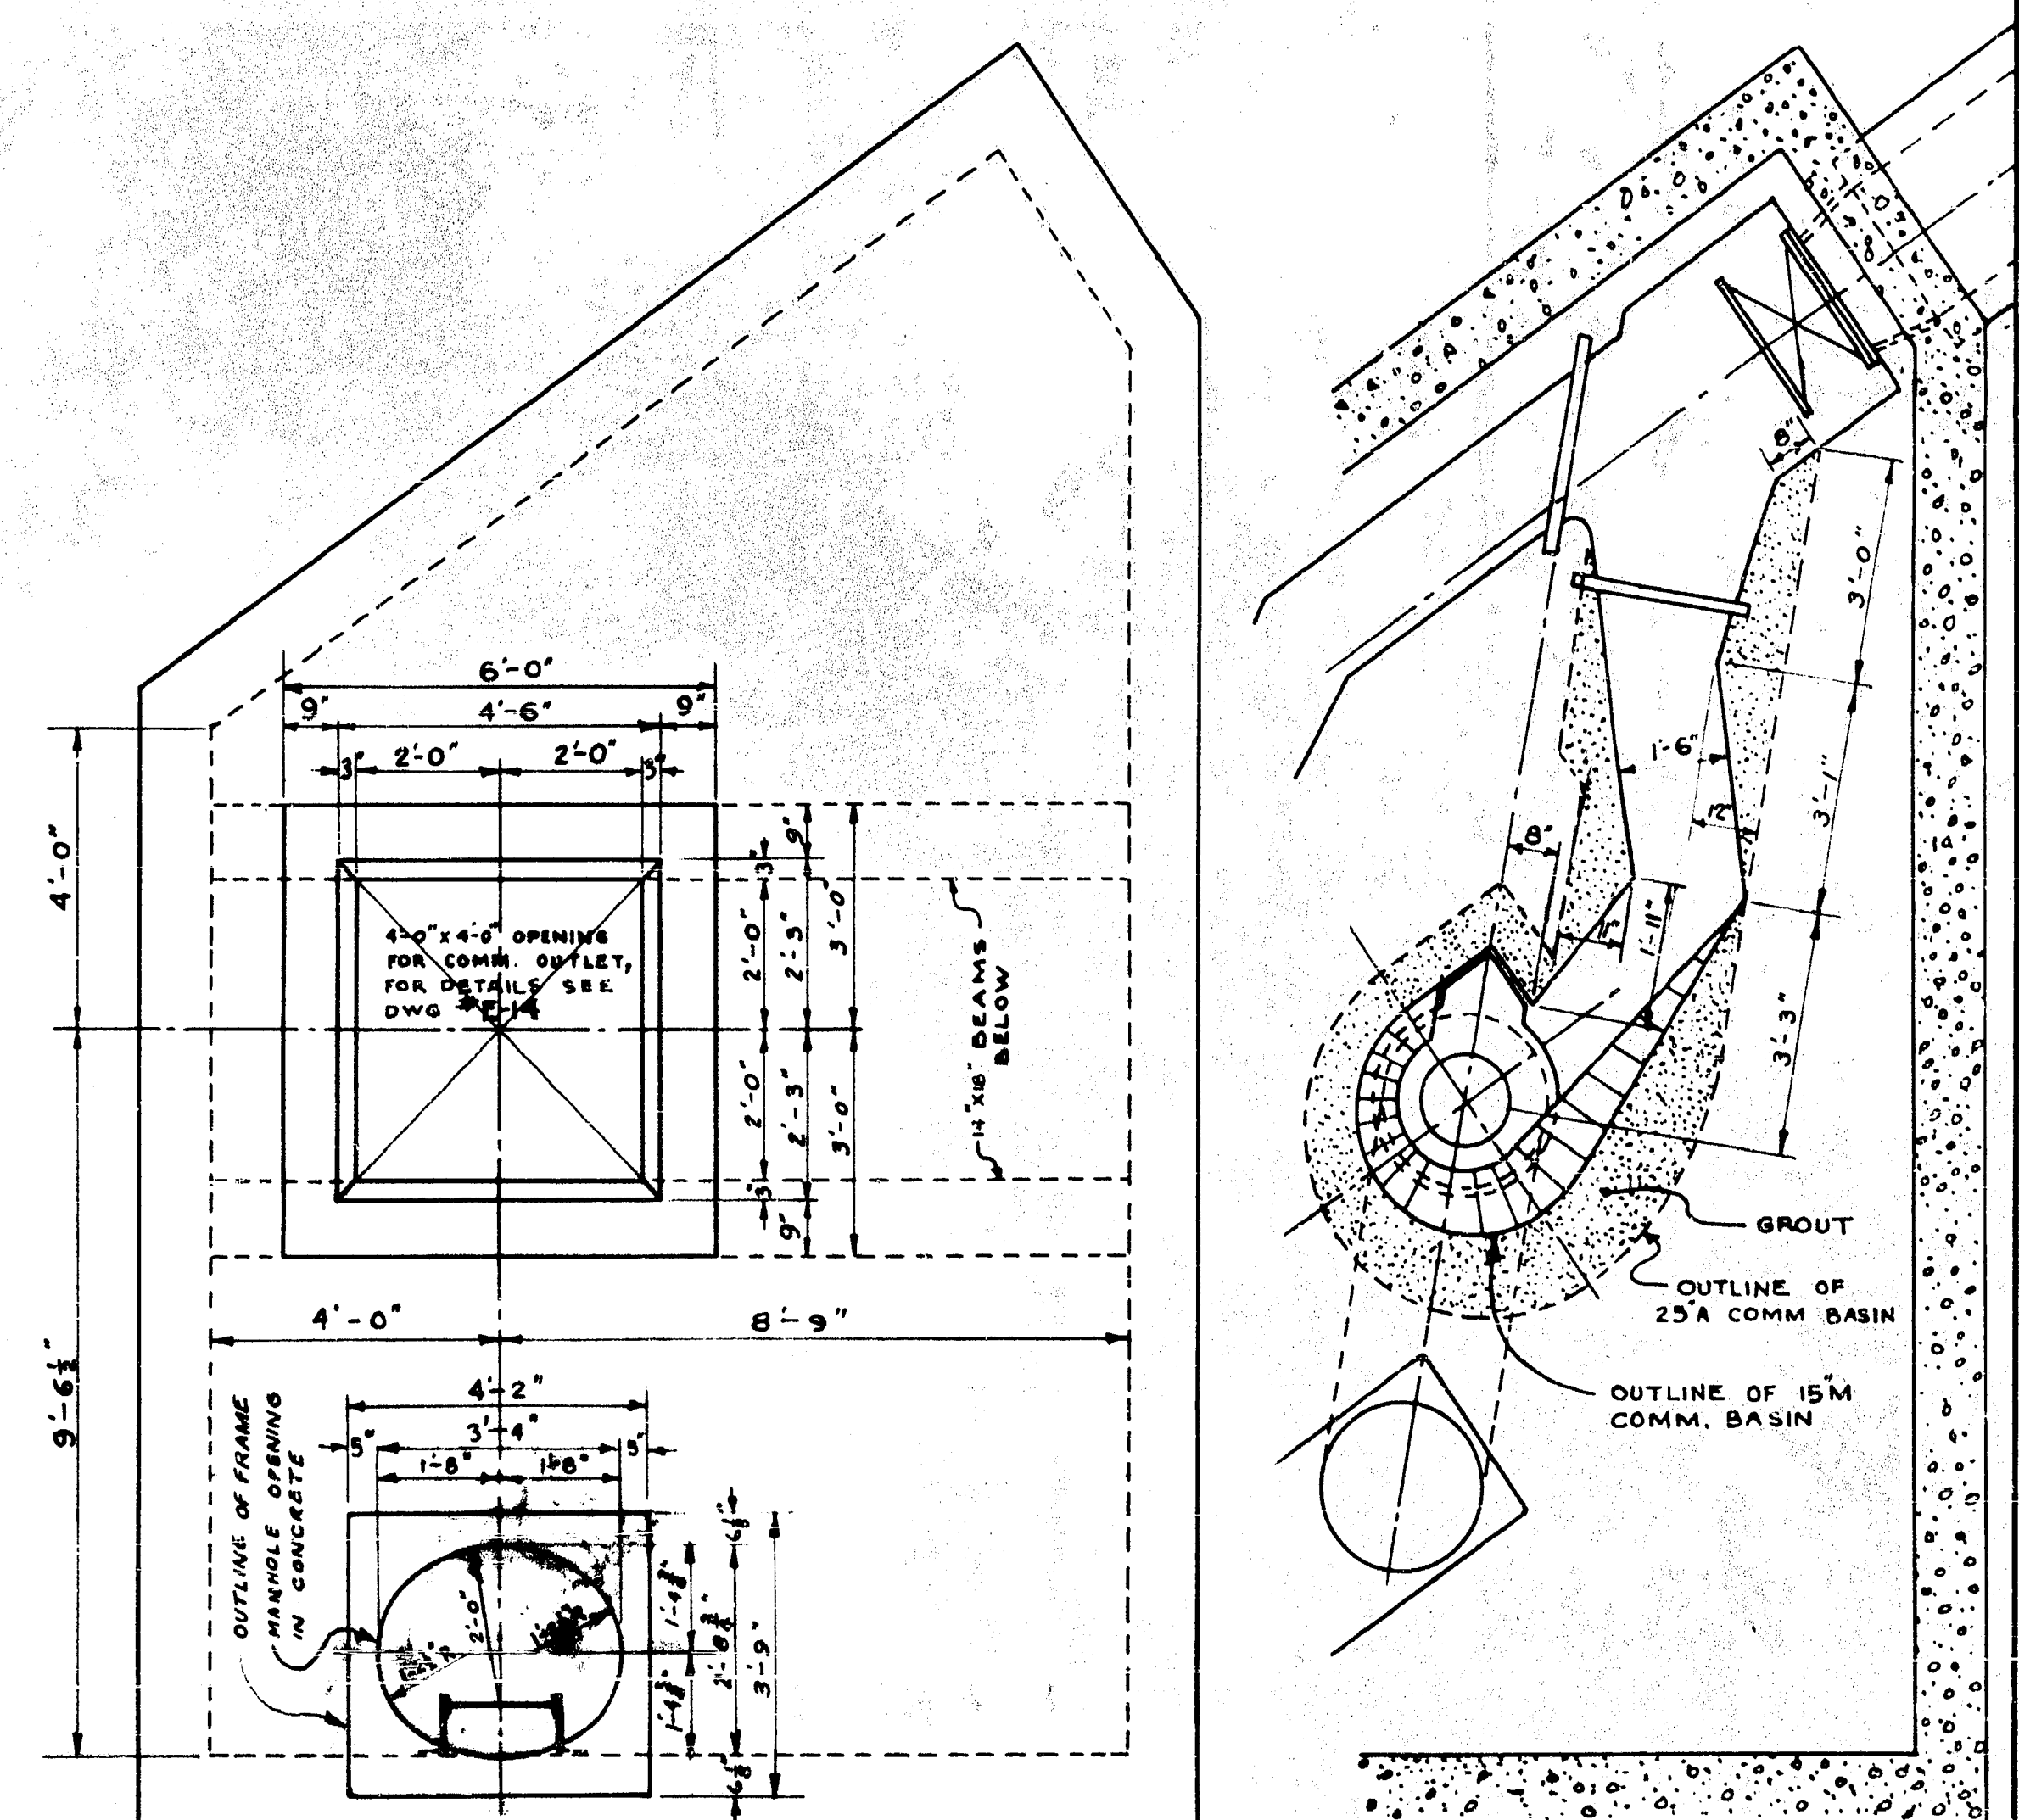
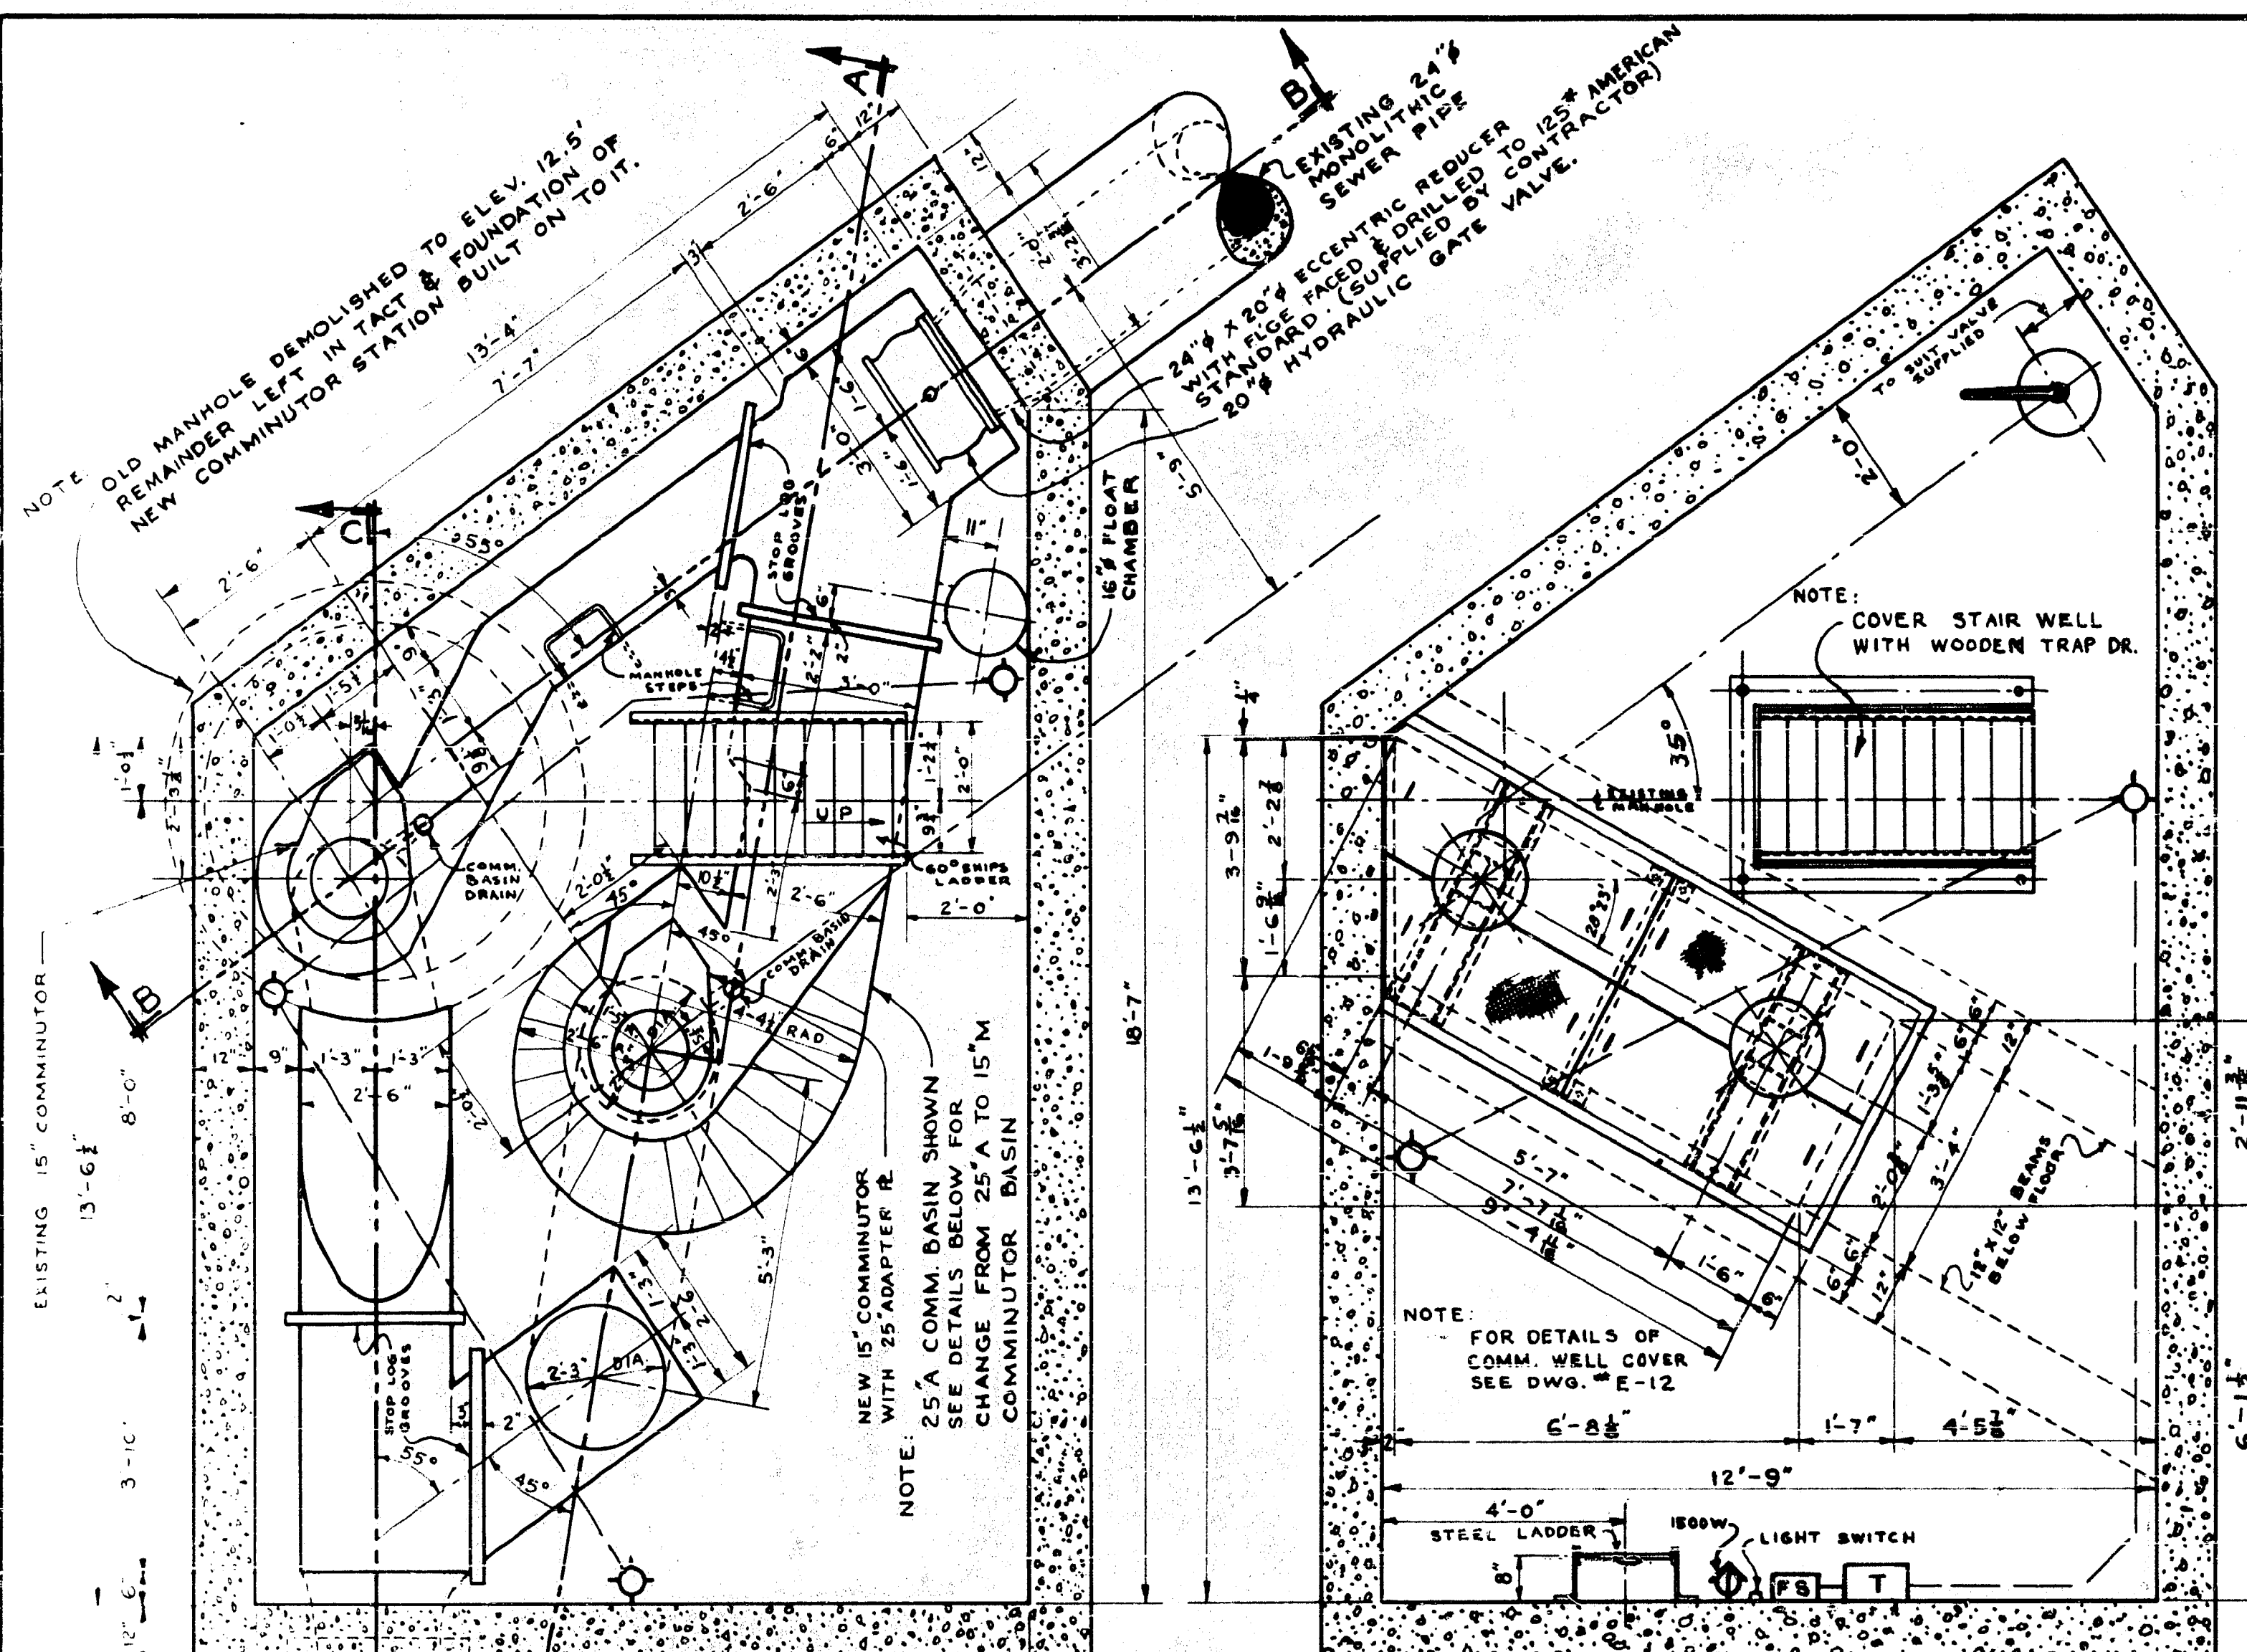
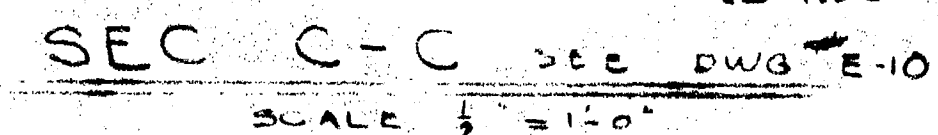
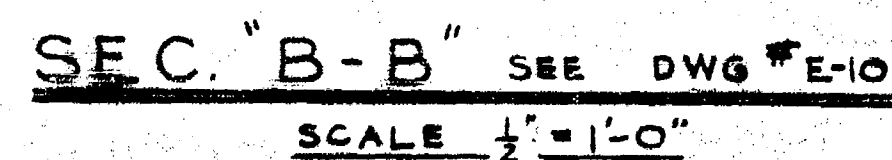



APPENDIX 'D'

GALT CHAMBER AS-BUILTS

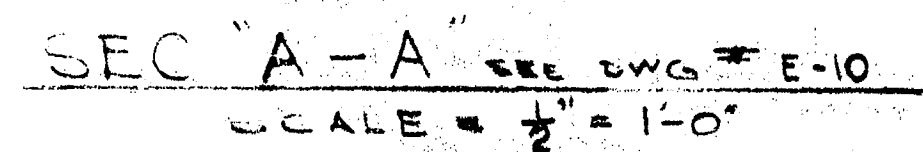

GREATER WINNIPEG SANITARY DISTRICT			
DRAWN: HB	DATE: 9.04.84	TITLE: ALEXANDER ST. COMMUNITOR STA. FLOOR PLANS & COMM. BASIN DETAILS	
TRACED	CHECKED: [Signature]	SCALE: AS NOTED	
APPROVED: [Signature]	SUPT: [Signature]	270	



[illegible]

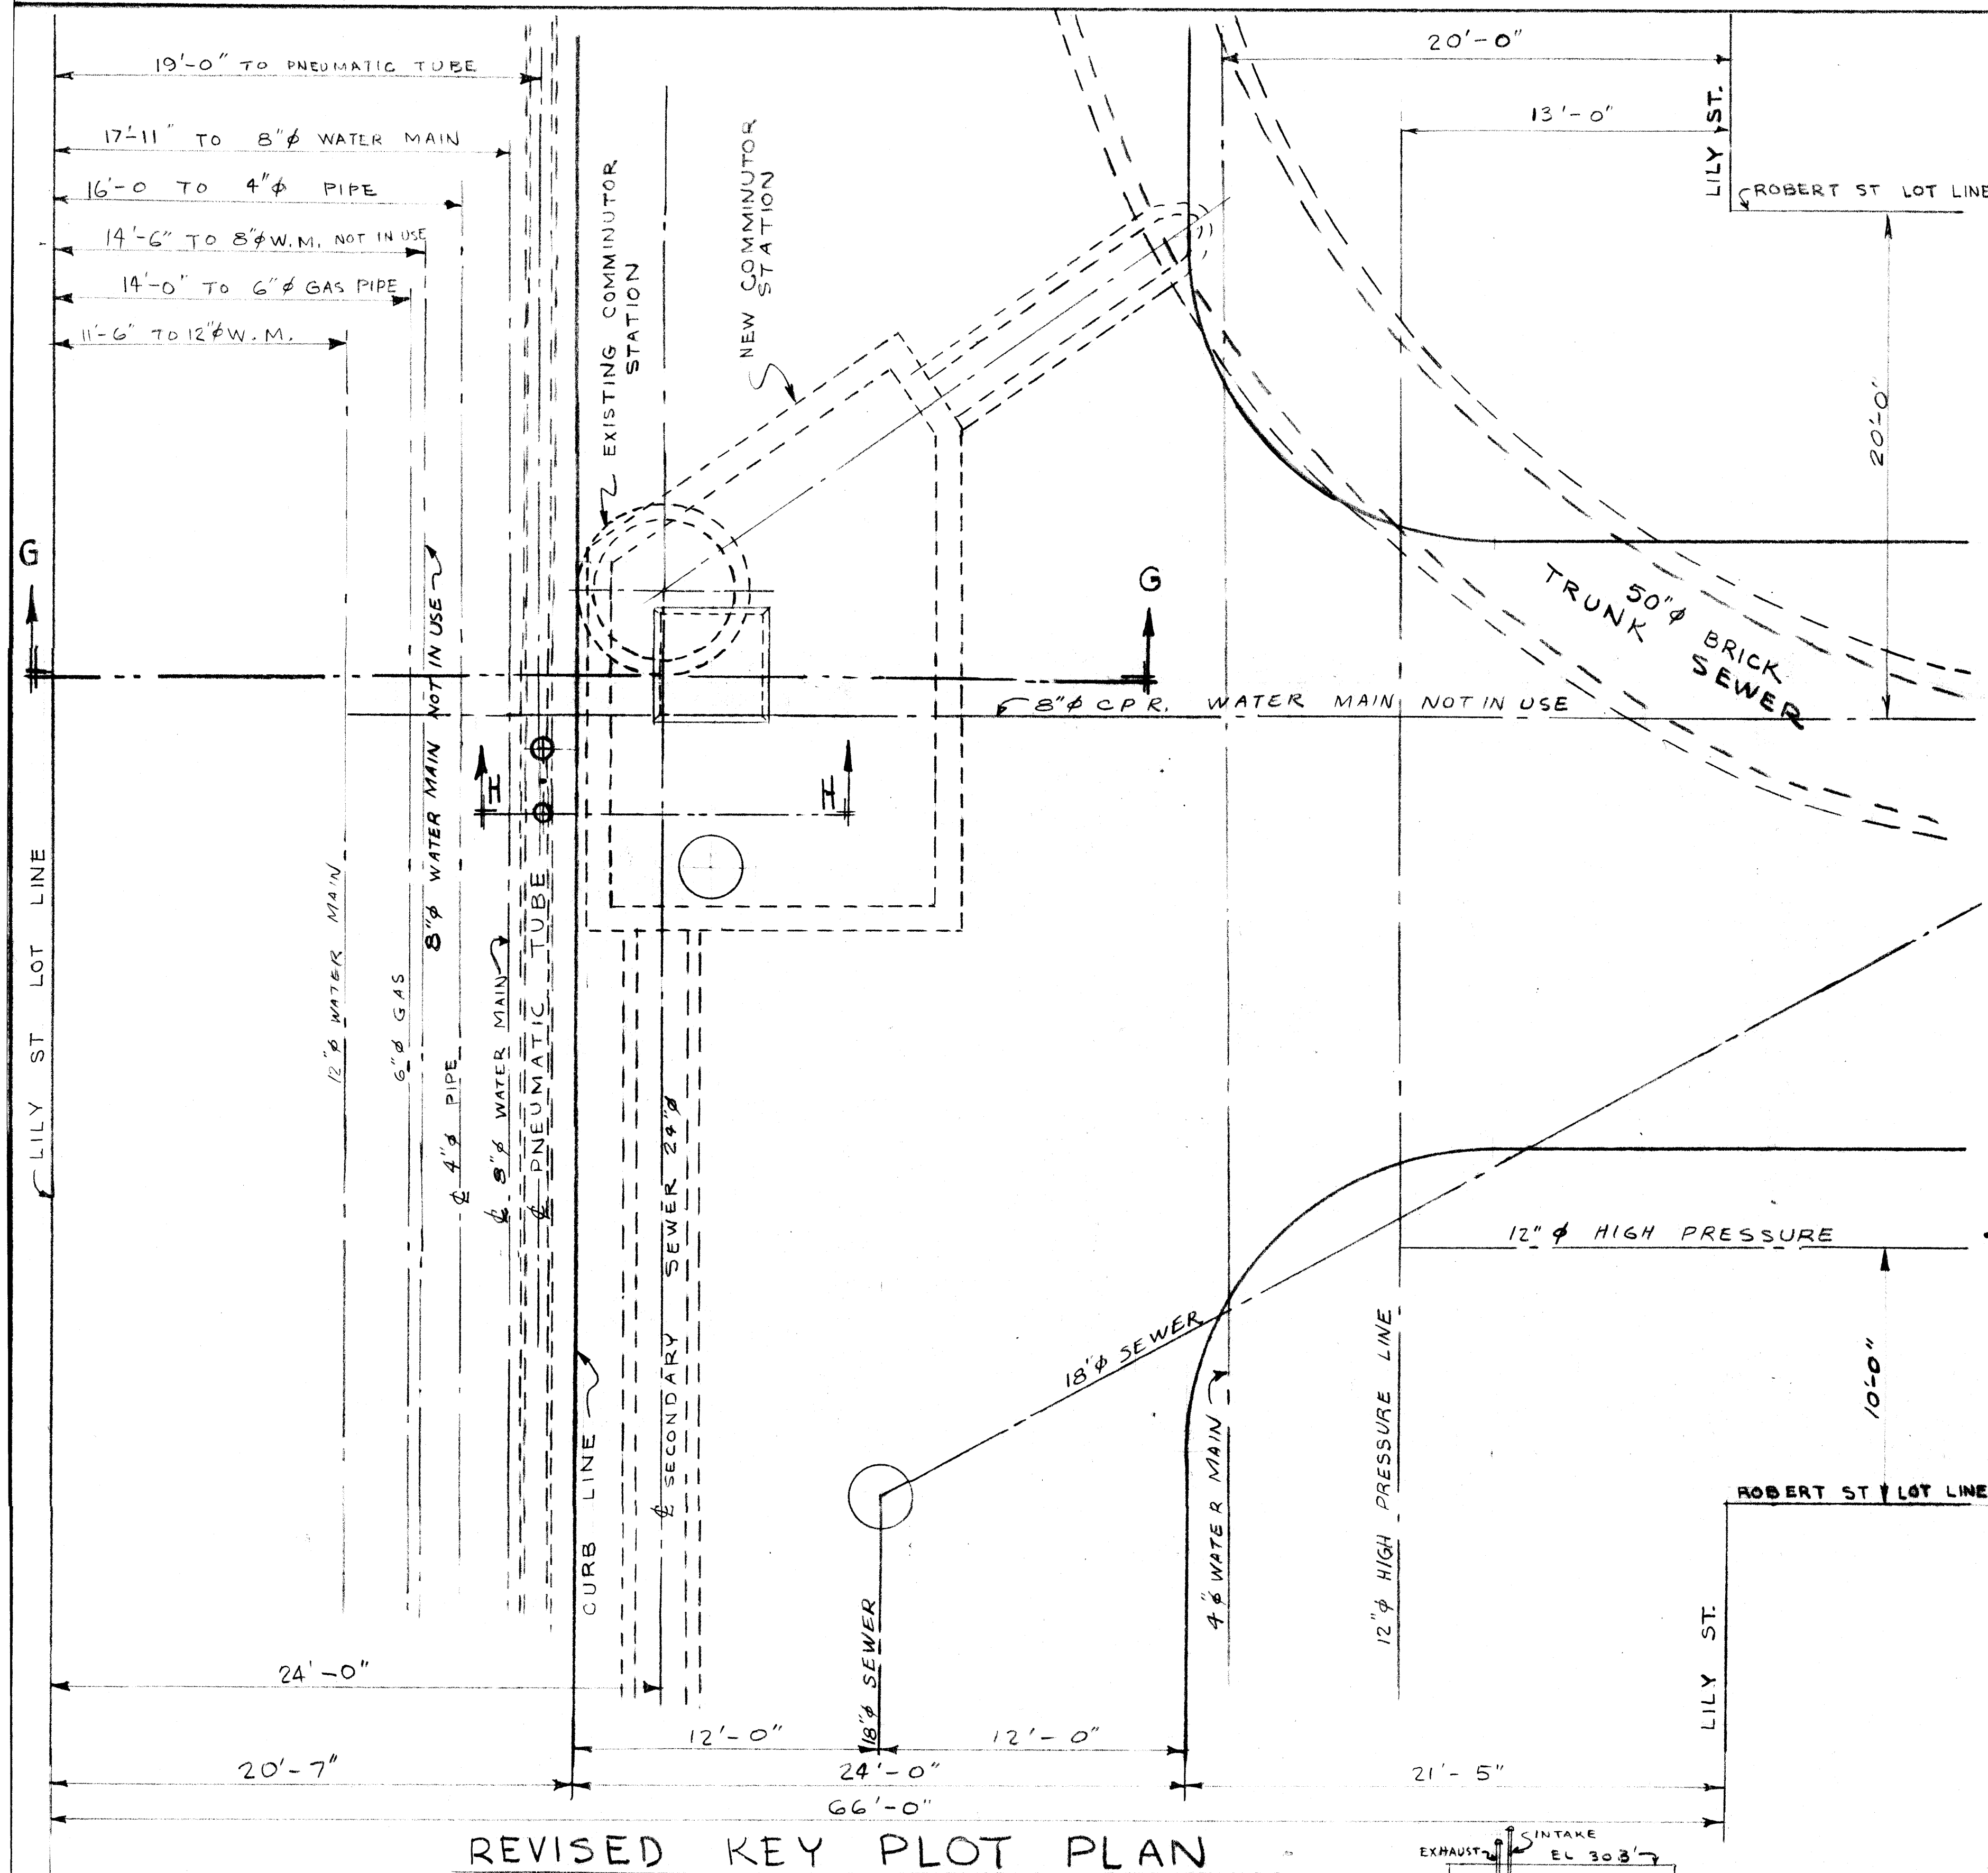

REVISED KEY PLOT PLAN

SCALE $\frac{1}{4}" = 1'-0"$

ALPHA 900 MC DESIGN 8H
PULLEY DRIVEN FRESH AIR
BLOWER OR EQUAL, 1316 CFM.
½ S.P. ½" H.P. MOTOR.

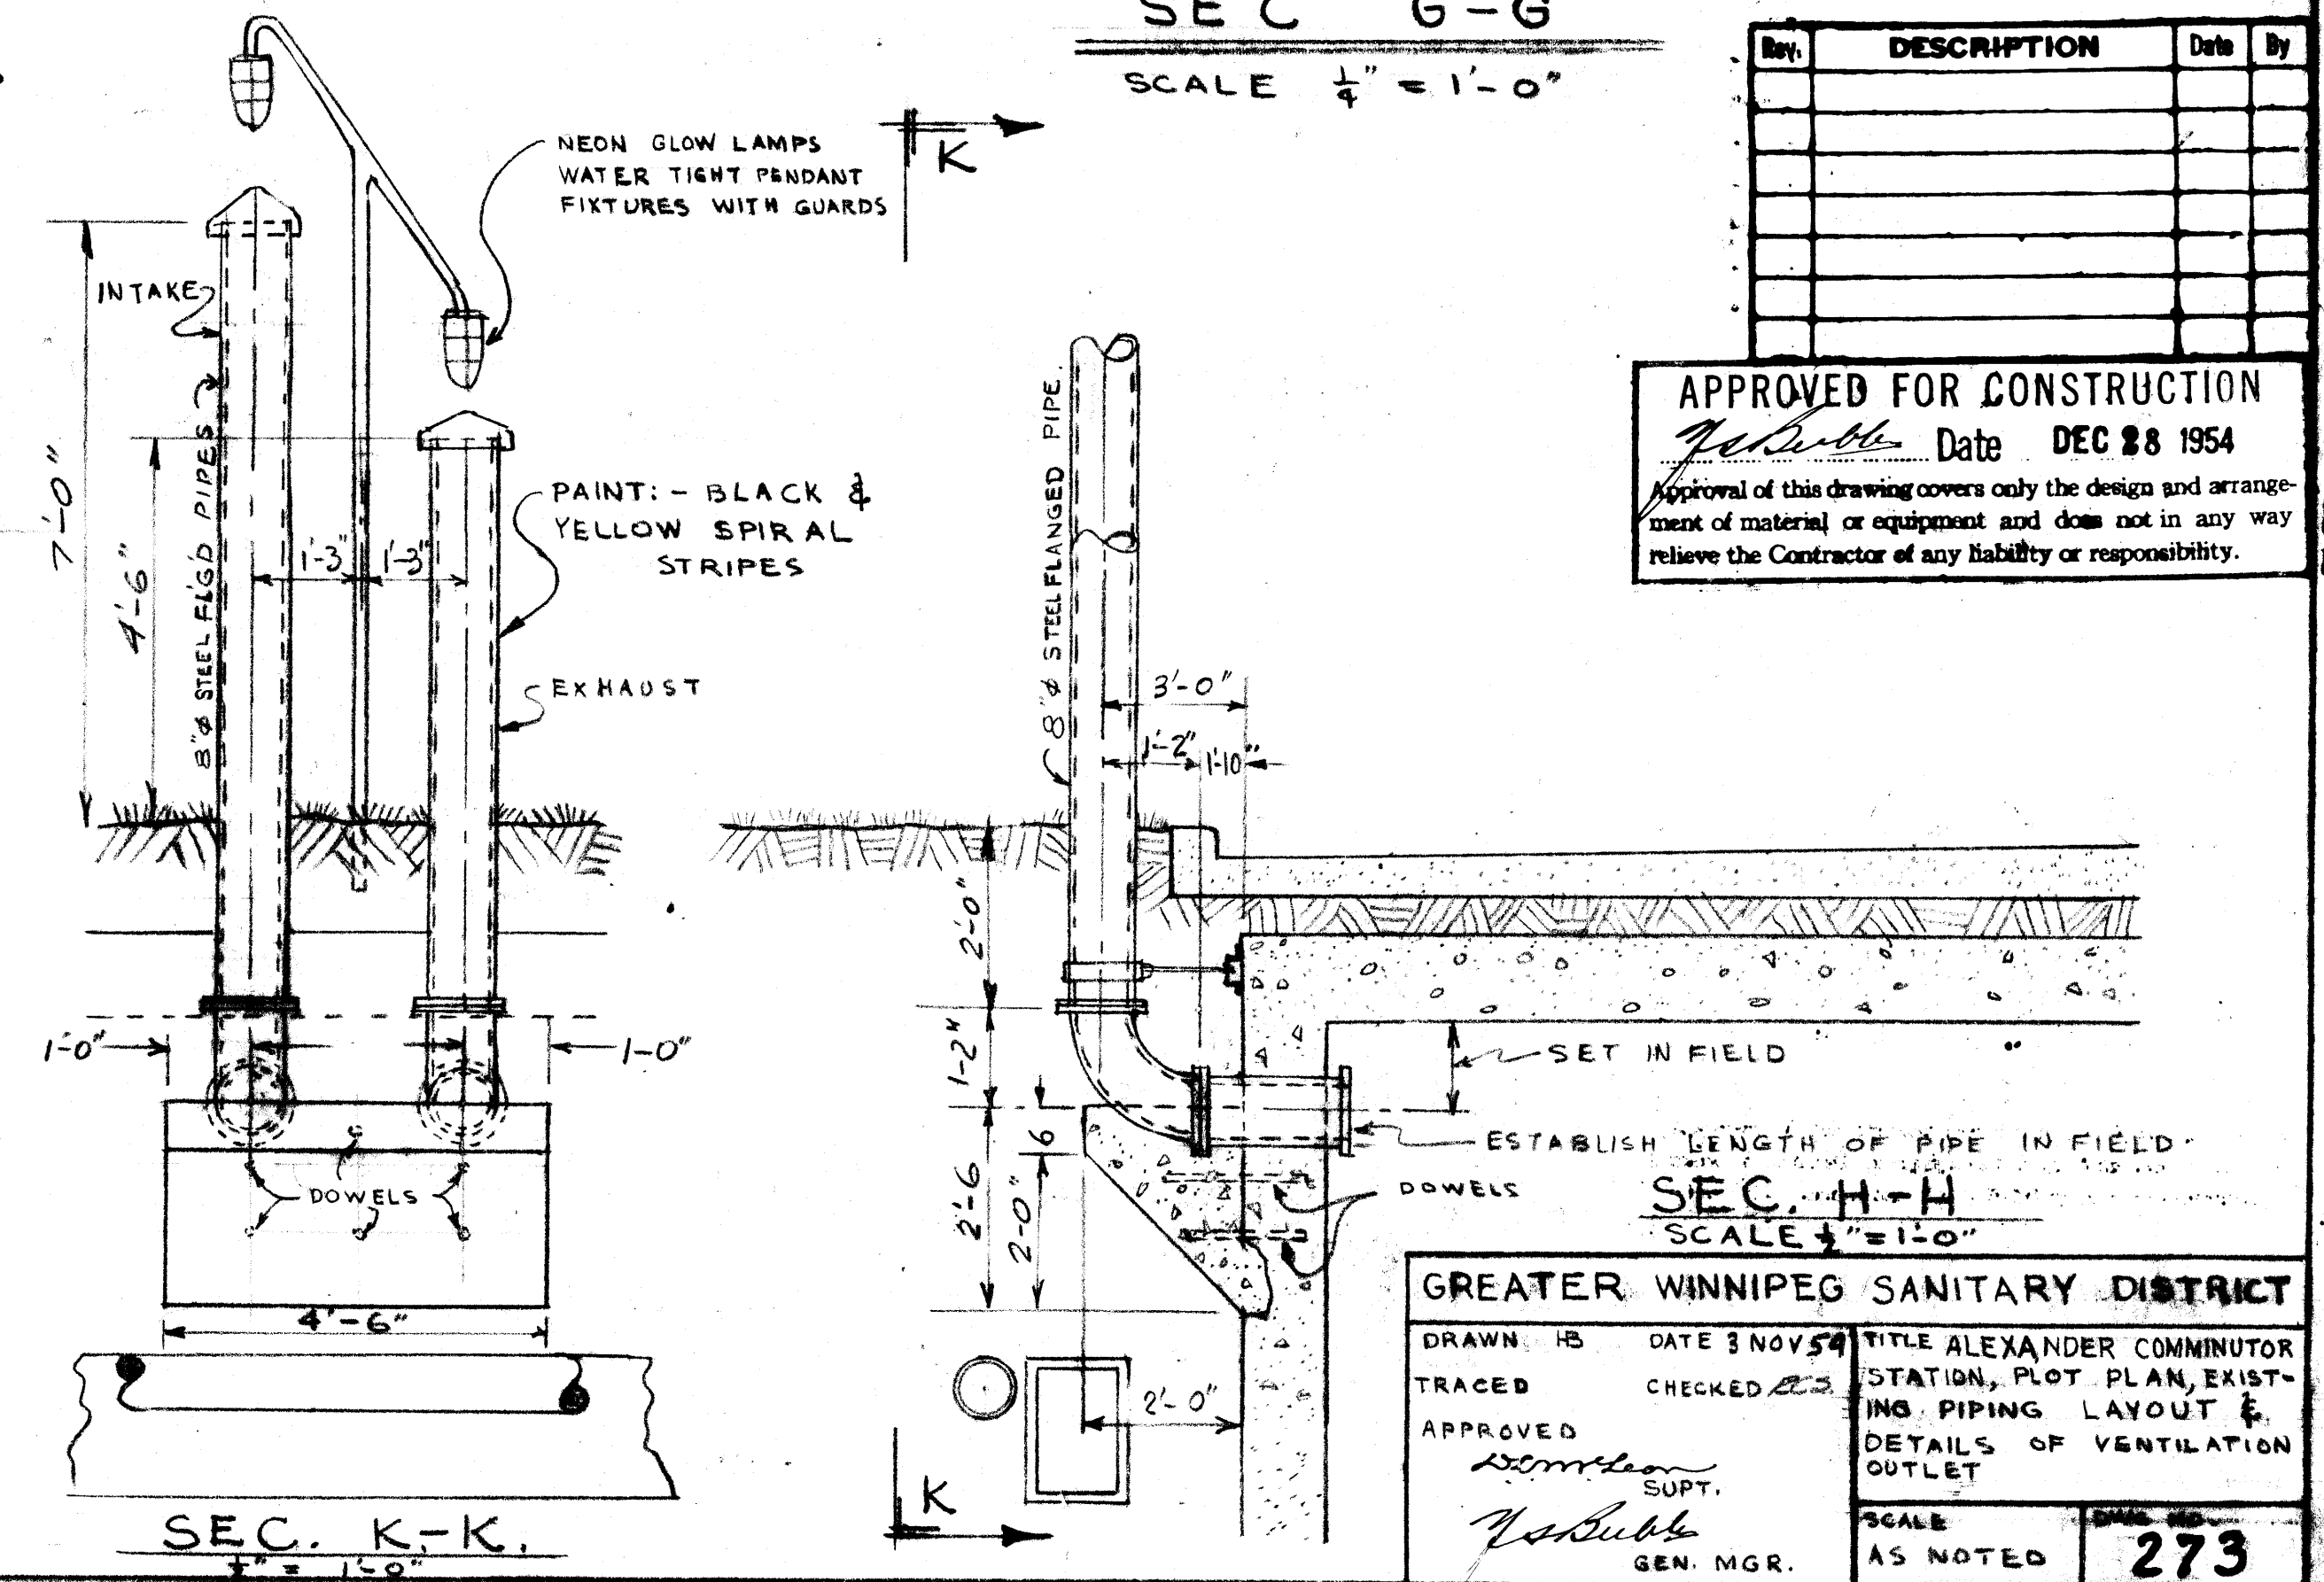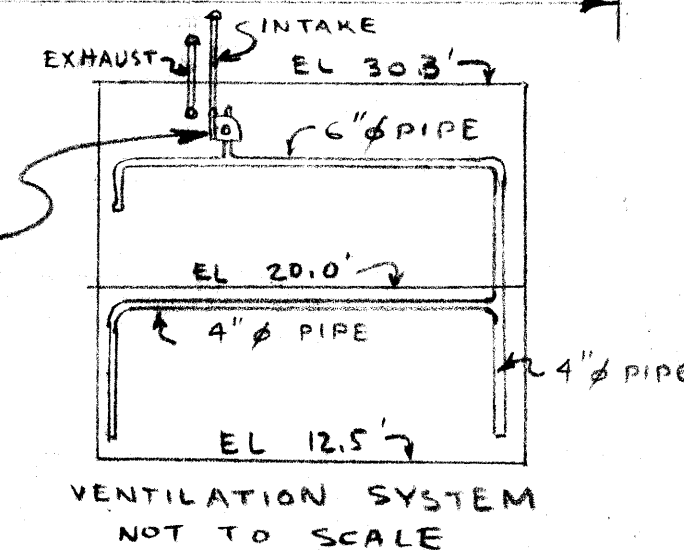

APPROVED FOR CONSTRUCTION
[Signature] Date DEC 28 1954
 Approval of this drawing covers only the design and arrange-
 ment of material or equipment and does not in any way
 relieve the Contractor of any liability or responsibility.

GREATER WINNIPEG		SANITARY DISTRICT	
DRAWN BY	DATE NOV 5 1954	TITLE ALEXANDER COMMUNITOR STATION, PLOT PLAN, EXISTING PIPING LAYOUT & DETAILS OF VENTILATION OUTLET	
TRACED	CHECKED <i>EC</i>		
APPROVED			
<i>W. H. Sullivan</i> Supt.			
<i>W. H. Sullivan</i> Gen. Mgr.		SCALE	DATE
		AS NOTED	273