


NOTE:
CONTROL PANEL M1HV16 WAS SUPPLIED BY MECHANICAL TRADES, INSTALLED BY ELECTRICAL CONTRACTOR

SECOND FLOOR POWER & MISC. LAYOUT
1:100

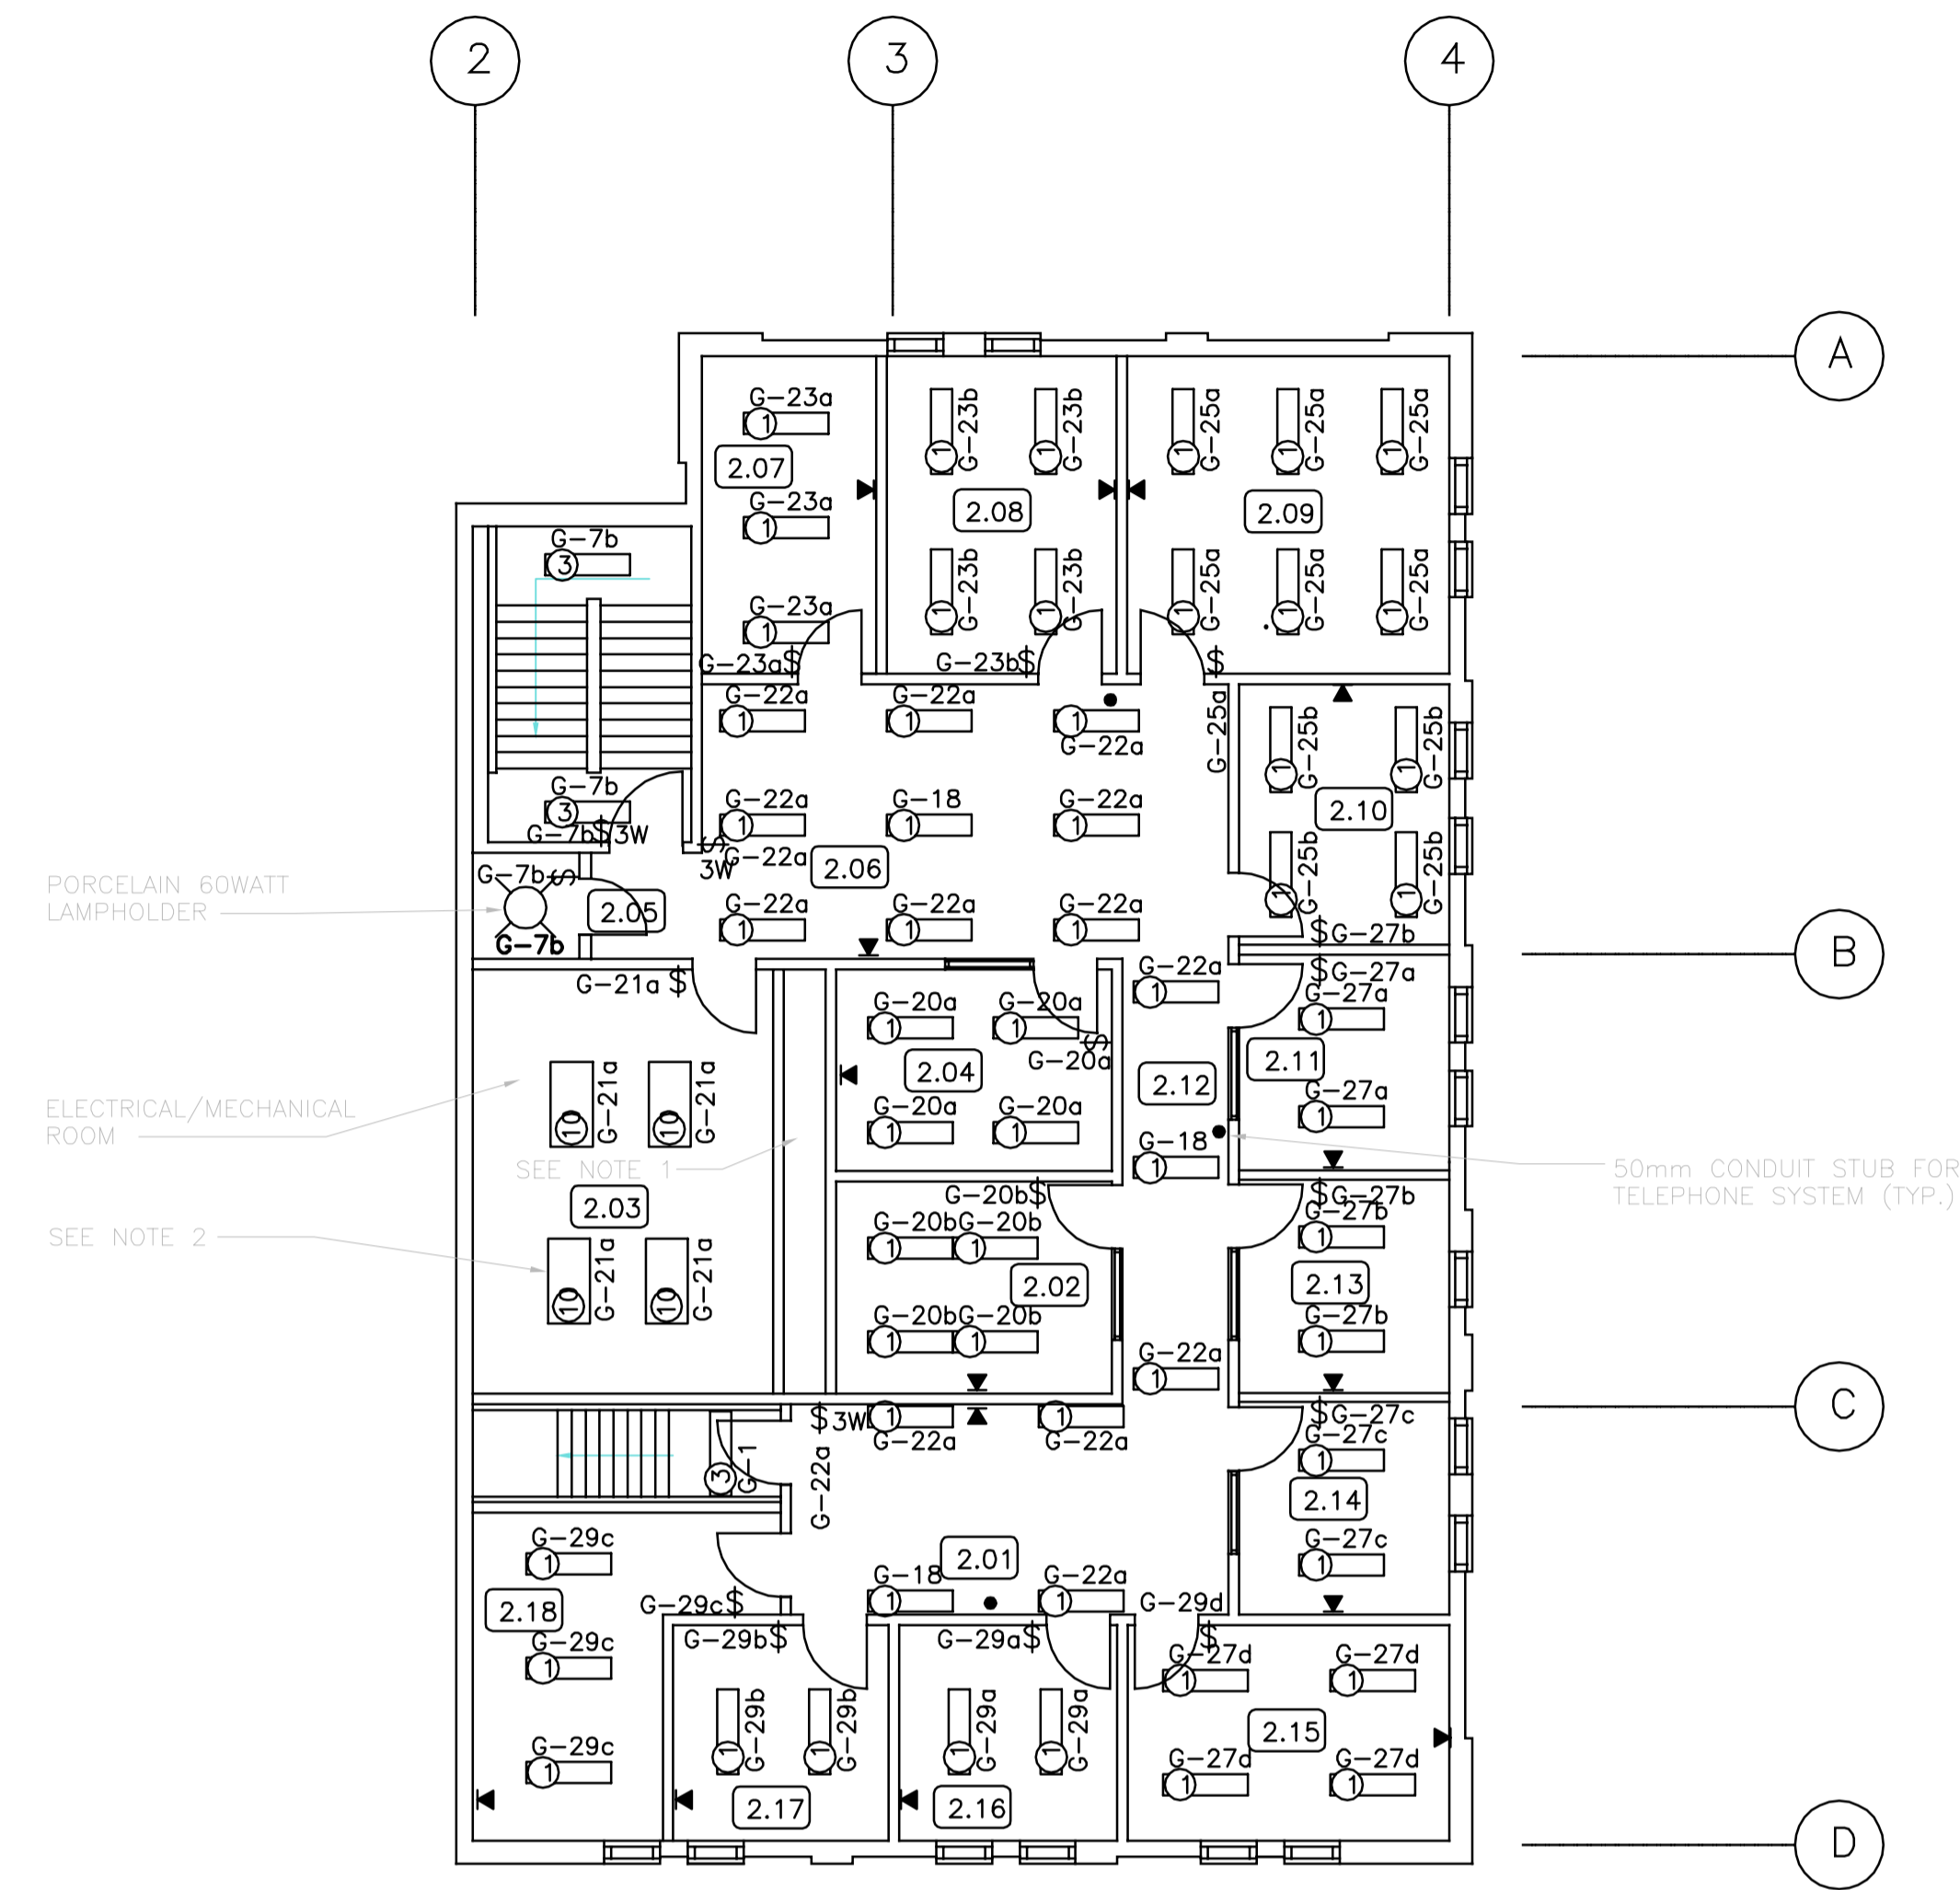

NOTE:
1. CONTRACTOR UTILIZED PIPE CHASE FOR RUNNING CONDUITS BETWEEN MAIN & SECOND FLOOR.
2. FIXTURES TYPE 10 ARE SYLVANIA 2314

SECOND FLOOR LIGHTING & TELEPHONE LAYOUT
1:100

AS-BUILT
DATE JULY/91 BY R.A.H.
CHECKED BY _____

B.M. ELEV.	Wardrop MacLaren ENGINEERING CONSULTANTS		ENGINEER'S SEAL	THE CITY OF WINNIPEG WORKS AND OPERATIONS DIVISION WATERWORKS, WASTE & DISPOSAL DEPARTMENT	
	DESIGNED BY R.A.H.	CHECKED BY		NORTH END WATER POLLUTION CONTROL CENTRE	CITY DRAWING NUMBER
	DRAWN BY N.B.	APPROVED BY		MAIN BUILDING RENOVATIONS-ELECTRICAL	SHEET OF
	HOR. SCALE: 1:100 VERTICAL: 1:100			RELEASED FOR CONSTRUCTION:	SECOND FLOOR PLAN LIGHTING & POWER LAYOUT
1 ISSUED FOR BID OP#353-2017 13/04	91/07 R.A.H.	DATE JUNE/91	CONSULTANT DRAWING NO. 880012-01-03	NEP-1539A	