



NOTES:

- 1. ENGINEERING DESIGN AND DRAWINGS OF KIOSK SHALL BE BY KIOSK SUPPLIER.

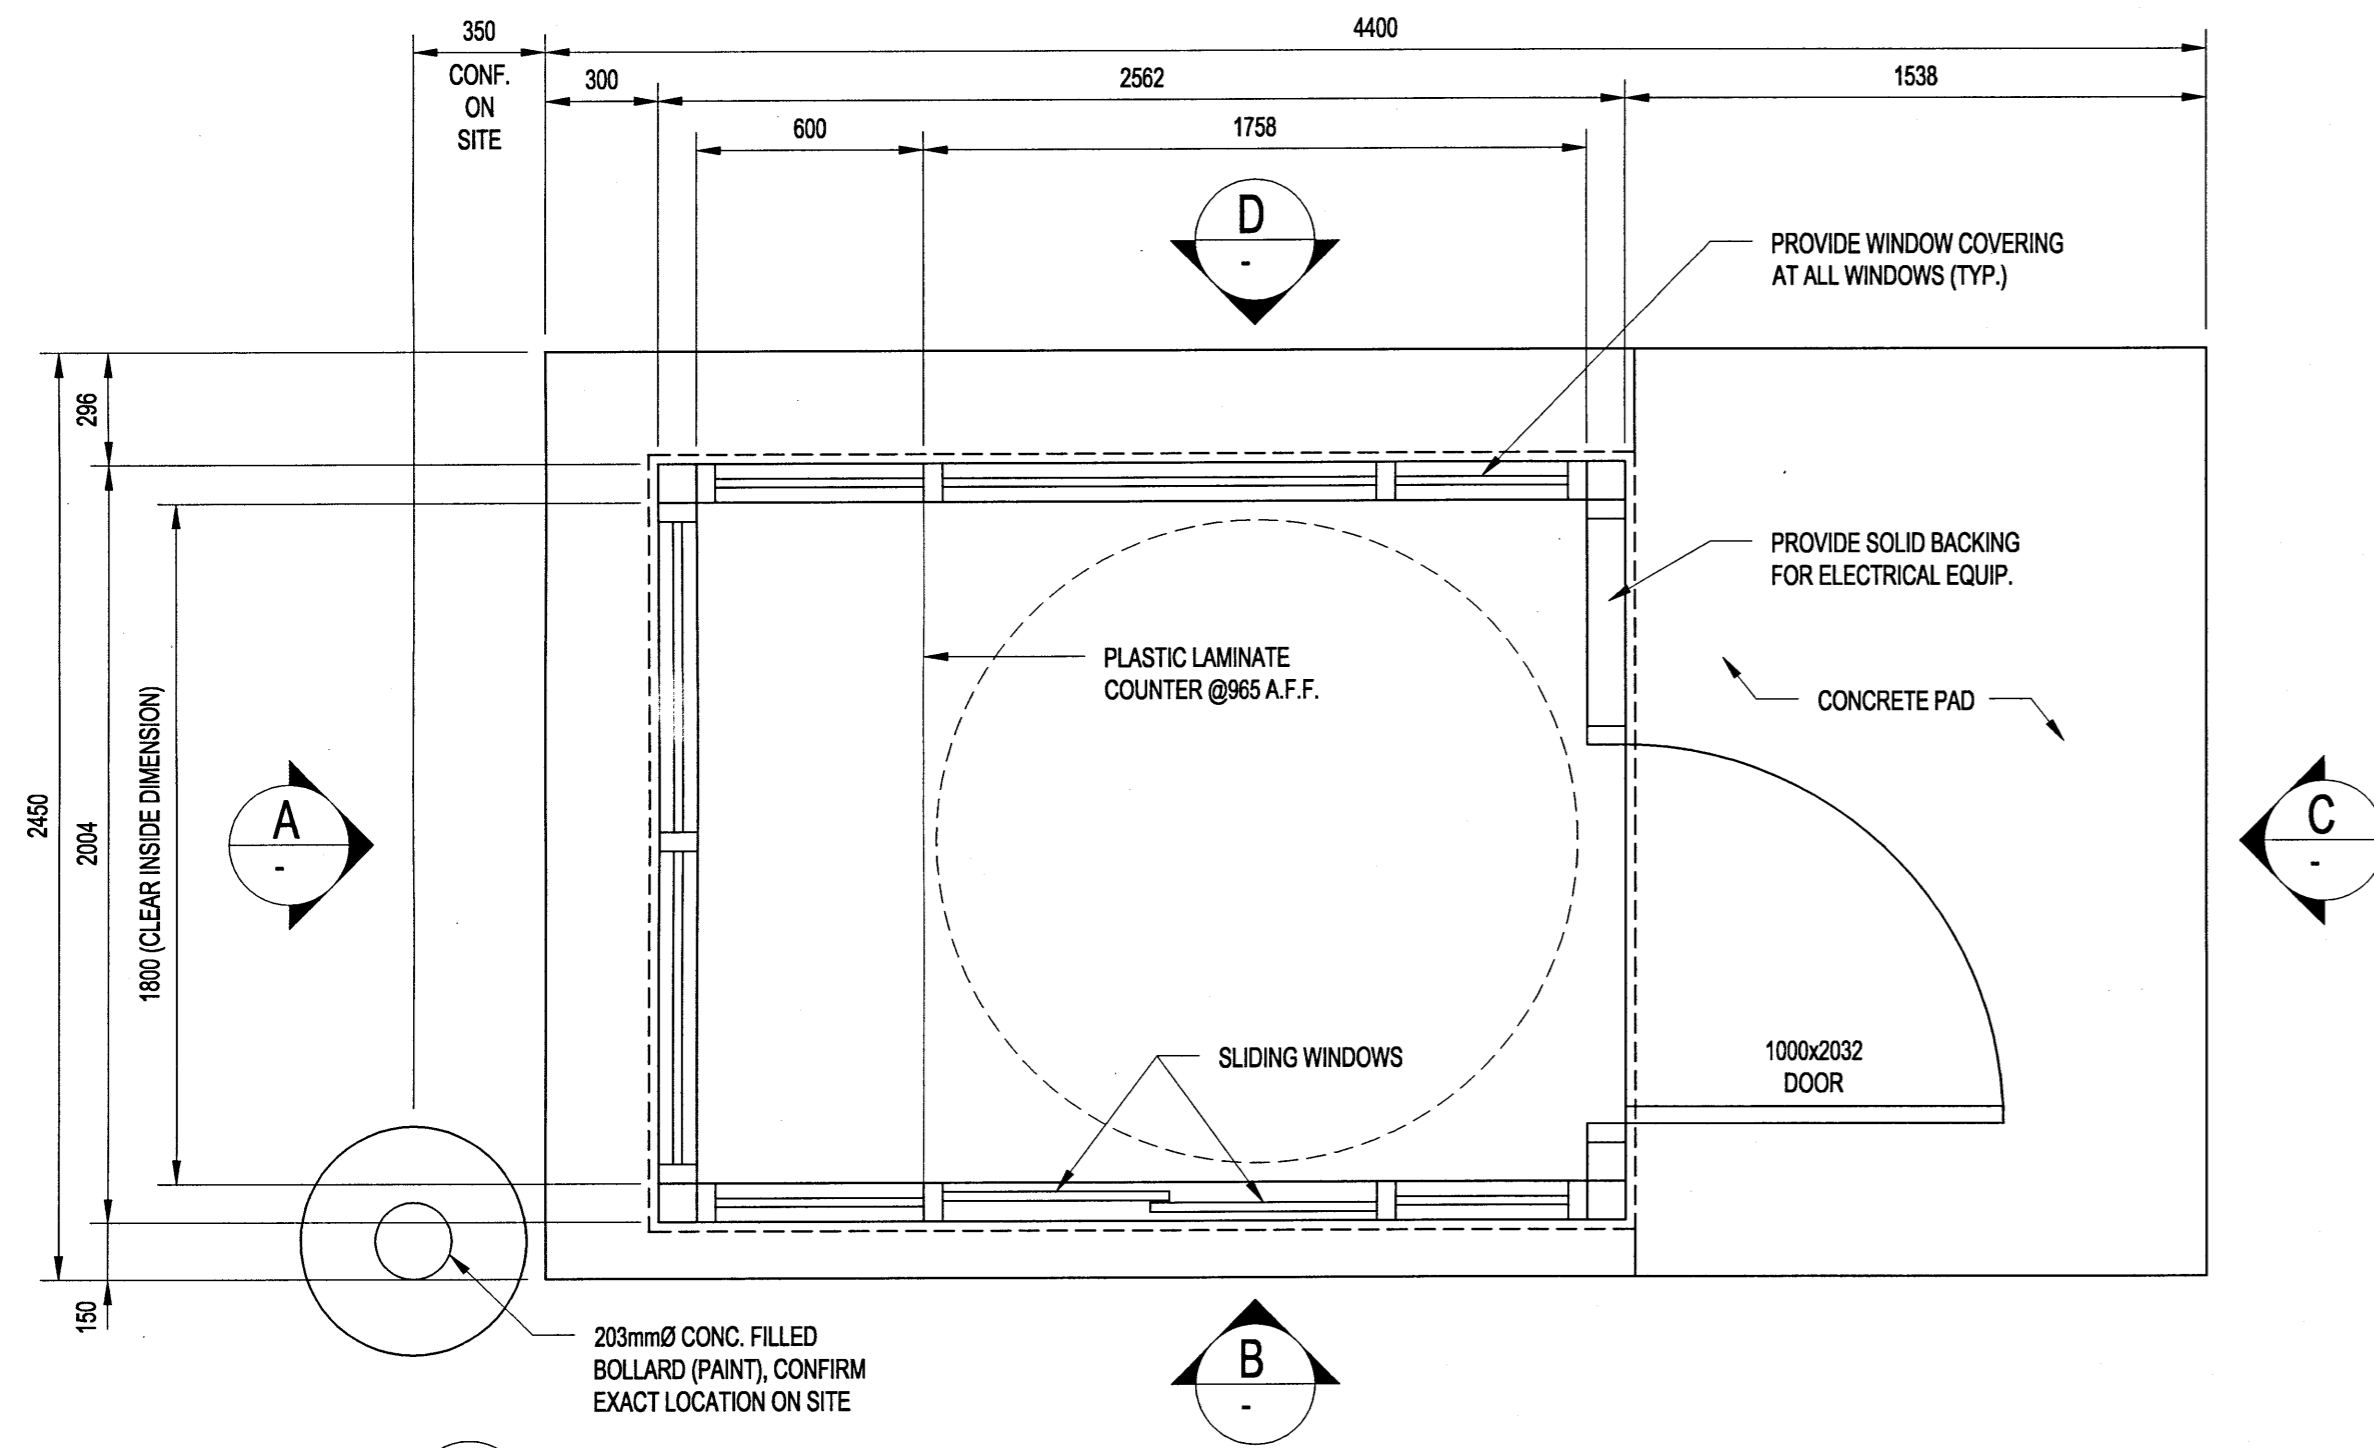


1
B01 KIOSK FLOOR PLAN
SCALE: 1:20

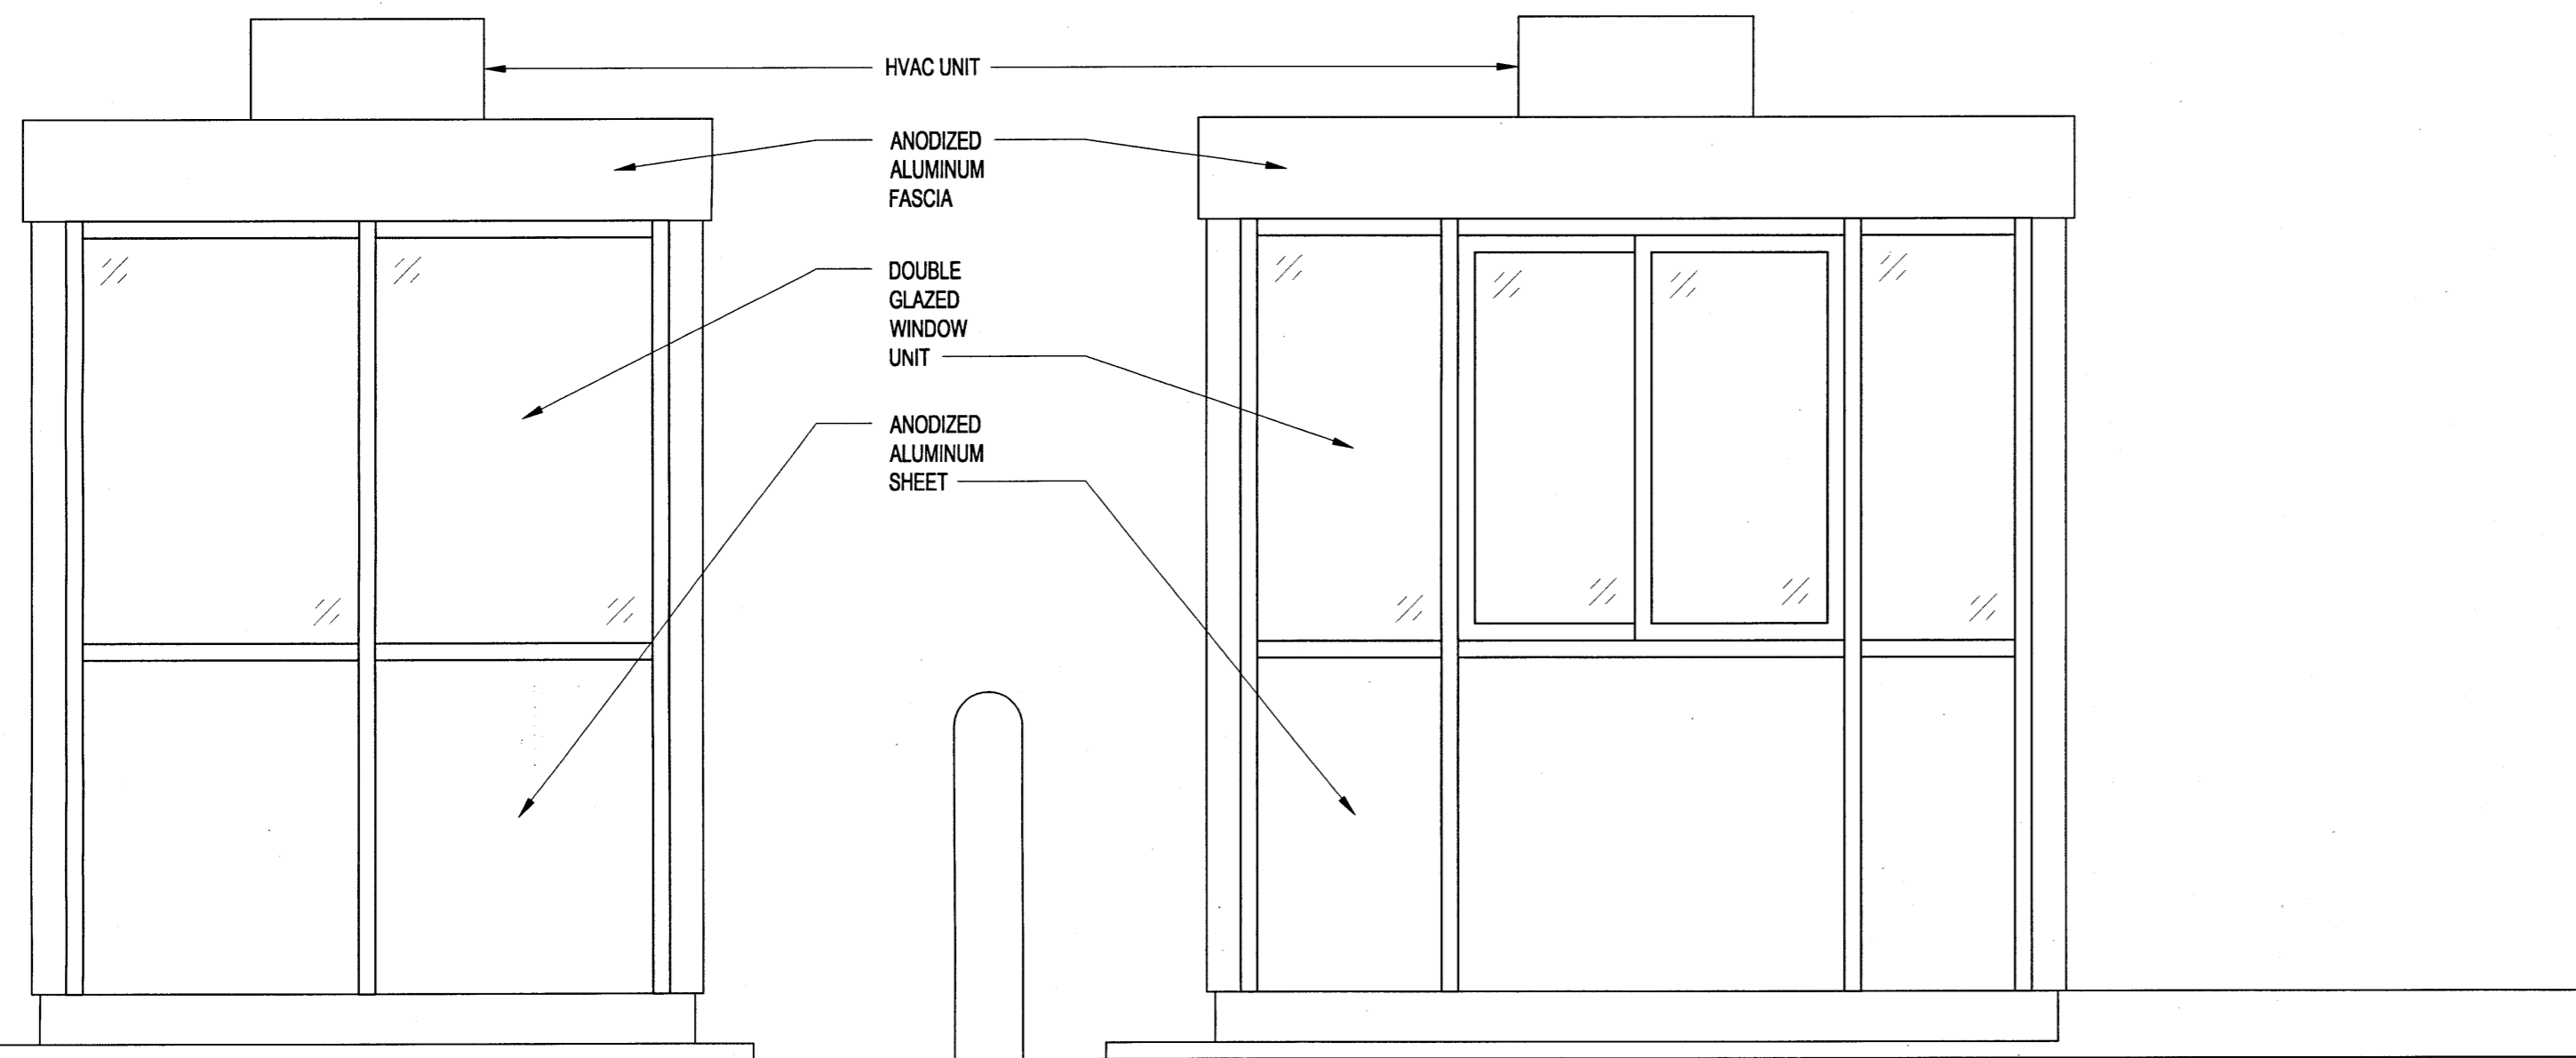

A KIOSK - ELEVATION
SCALE: 1:20

B KIOSK - ELEVATION
SCALE: 1:20

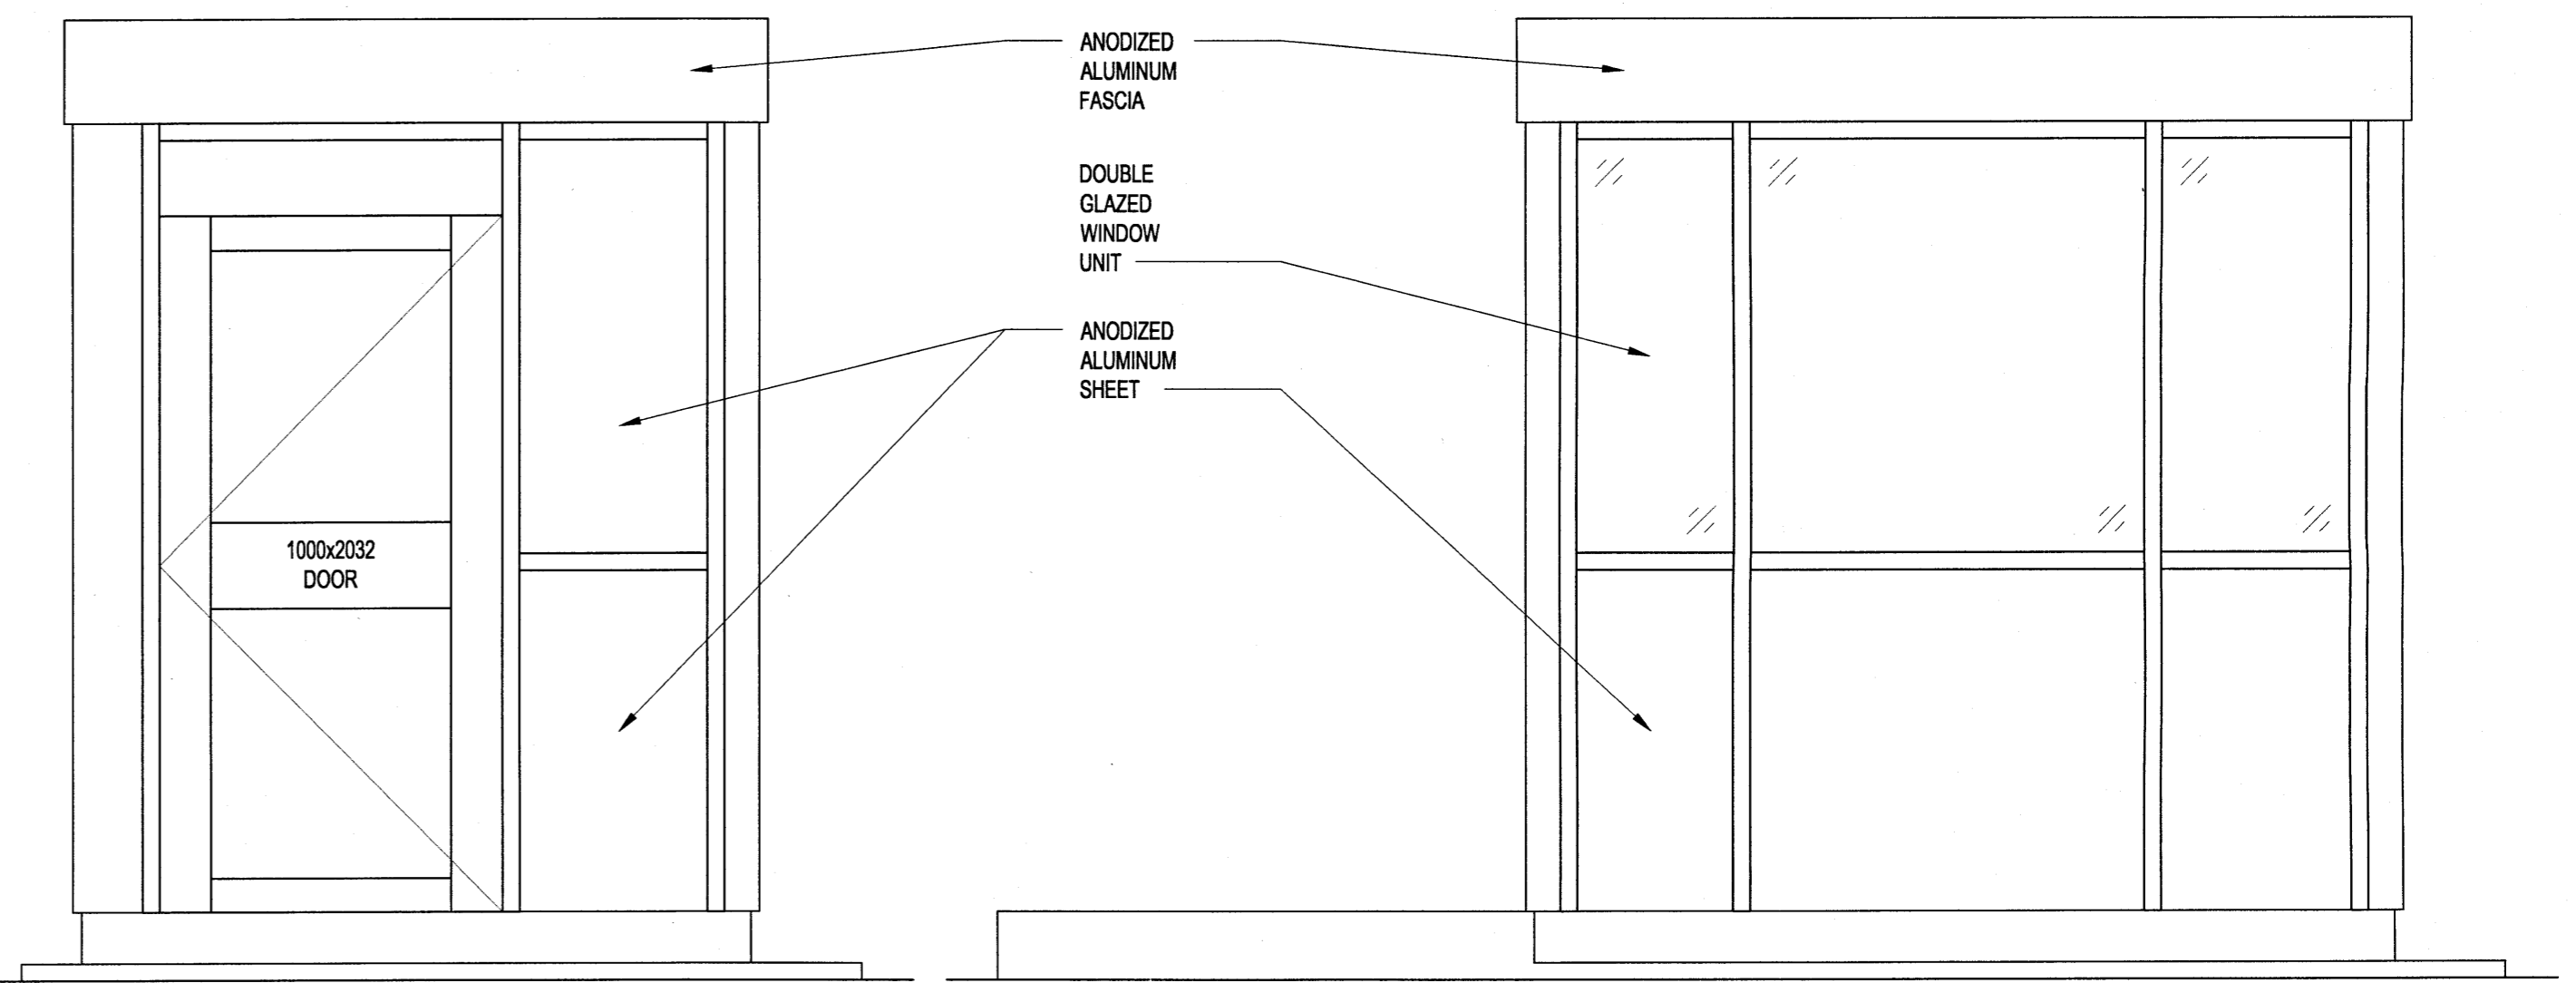

C KIOSK - ELEVATION
SCALE: 1:20

D KIOSK - ELEVATION
SCALE: 1:20

16-0107-010\16-0107-010_B03.dwg

LOCATION APPROVED UNDERGROUND STRUCTURES

SUPV. U/G STRUCTURES COMMITTEE	DATE
NOTE: LOCATION OF UNDERGROUND STRUCTURES AS SHOWN ARE BASED ON THE BEST INFORMATION AVAILABLE BUT NO GUARANTEE IS GIVEN THAT ALL EXISTING UTILITIES ARE SHOWN OR THAT THE GIVEN LOCATIONS ARE EXACT. CONFIRMATION OF EXISTENCE AND EXACT LOCATION OF ALL SERVICES MUST BE OBTAINED FROM THE INDIVIDUAL UTILITIES BEFORE PROCEEDING WITH CONSTRUCTION.	

B.M. ELEV.	
DESIGNED BY	DJP
DRAWN BY	MBB
HOR. SCALE:	AS NOTED
VERTICAL:	AS NOTED
ISSUED FOR TENDER	17/03/29
NO.	REVISIONS
DATE	BY

KGS GROUP
CONSULTING ENGINEERS

CHECKED BY	CMS
APPROVED BY	[Signature]
RELEASED FOR CONSTRUCTION:	
DATE	16/12/16

ENGINEER'S SEAL

CONSULTANT DRAWING NO.
16-0107-010

THE CITY OF WINNIPEG
WATER AND WASTE DEPARTMENT

PROJECT TITLE
4R WINNIPEG DEPOT
EAST WINNIPEG COMMUNITY RESOURCE
RECOVERY CENTRE
KIOSK - FLOOR PLAN, ELEVATIONS,
WALL SECTION & DETAILS

SHEET	OF
16	41
COMPUTER FILE NAME	
16-0107-010	
CONSULTANT DRAWING NUMBER	
B08	