




THE CITY OF WINNIPEG

WATER AND WASTE DEPARTMENT

4R WINNIPEG DEPOT - EAST WINNIPEG COMMUNITY RESOURCE RECOVERY CENTRE (CRRC)

BID OPPORTUNITY: 39-2017

SHEET NO.	DWG. No.	TITLE
1 of 41	C00	COVER SHEET
2 of 41	C01	SITE GEOMETRY
3 of 41	C02	GRADING PLAN
4 of 41	C03	PROFILES
5 of 41	C04	UNDERGROUND UTILITIES AND LAND DRAINAGE SEWER
6 of 41	C05	TYPICAL SECTIONS
7 of 41	C06	POND AND FENCING DETAILS
8 of 41	C07	SITE FENCING AND PAINTING
9 of 41	B01	GENERAL ARRANGEMENT OF STRUCTURES
10 of 41	B02	HHW BUILDING - MAIN FLOOR PLAN AND NOTES
11 of 41	B03	HHW BUILDING - SECTIONS
12 of 41	B04	HHW BUILDING - SECTIONS, ROOM FINISH SCHEDULE & DETAILS
13 of 41	B05	HHW BUILDING - DOOR SCHEDULE & NOTES
14 of 41	B06	HHW BUILDING - WALL SECTIONS
15 of 41	B07	HHW BUILDING - DETAILS
16 OF 41	B08	KIOSK - FLOOR PLAN, ELEVATIONS, WALL SECTION & DETAILS
17 of 41	S01	STRUCTURAL MAIN FLOOR PLANS
18 of 41	S02	HHW BUILDING - ROOF FRAMING PLAN
19 of 41	S03	RETAINING WALL SECTIONS AND DETAILS
20 of 41	S04	RETAINING WALL SECTIONS AND DETAILS
21 of 41	S05	RETAINING WALL STAIR DETAILS
22 of 41	M01	HHW BUILDING - PLUMBING PLAN
23 of 41	M02	HHW BUILDING - HVAC PLAN
24 of 41	M03	HHW BUILDING - SECTIONS, DETAILS AND SCHEDULES
25 of 41	M04	HHW - CONTROLS SCHEMATICS
26 of 41	E01	SYMBOL LEGEND AND DRAWING LIST
27 of 41	E02	ELECTRICAL - SITE PLAN
28 of 41	E03	SINGLE LINE DIAGRAM AND PANEL SCHEDULES
29 of 41	E04	HHW BUILDING - POWER PLAN
30 of 41	E05	HHW BUILDING - LIGHTING PLAN
31 of 41	E06	HHW BUILDING - SYSTEMS PLAN
32 of 41	E07	KIOSK BUILDING
33 of 41	E08	MECHANICAL EQUIPMENT SCHEDULE
34 of 41	E09	LUMINAIRE SCHEDULE
35 of 41	E10	ELECTRICAL - DETAILS
36 of 41	E11	ELECTRICAL - DETAILS
37 of 41	E12	ELECTRICAL - DETAILS
38 of 41	E13	SECURITY CAMERA SYSTEM
39 of 41	E14	SECURITY CAMERA SYSTEM - DETAILS
40 of 41	E15	FIRE ALARM MOUNTING STANDARD
41 of 41	L01	PLANTING PLAN

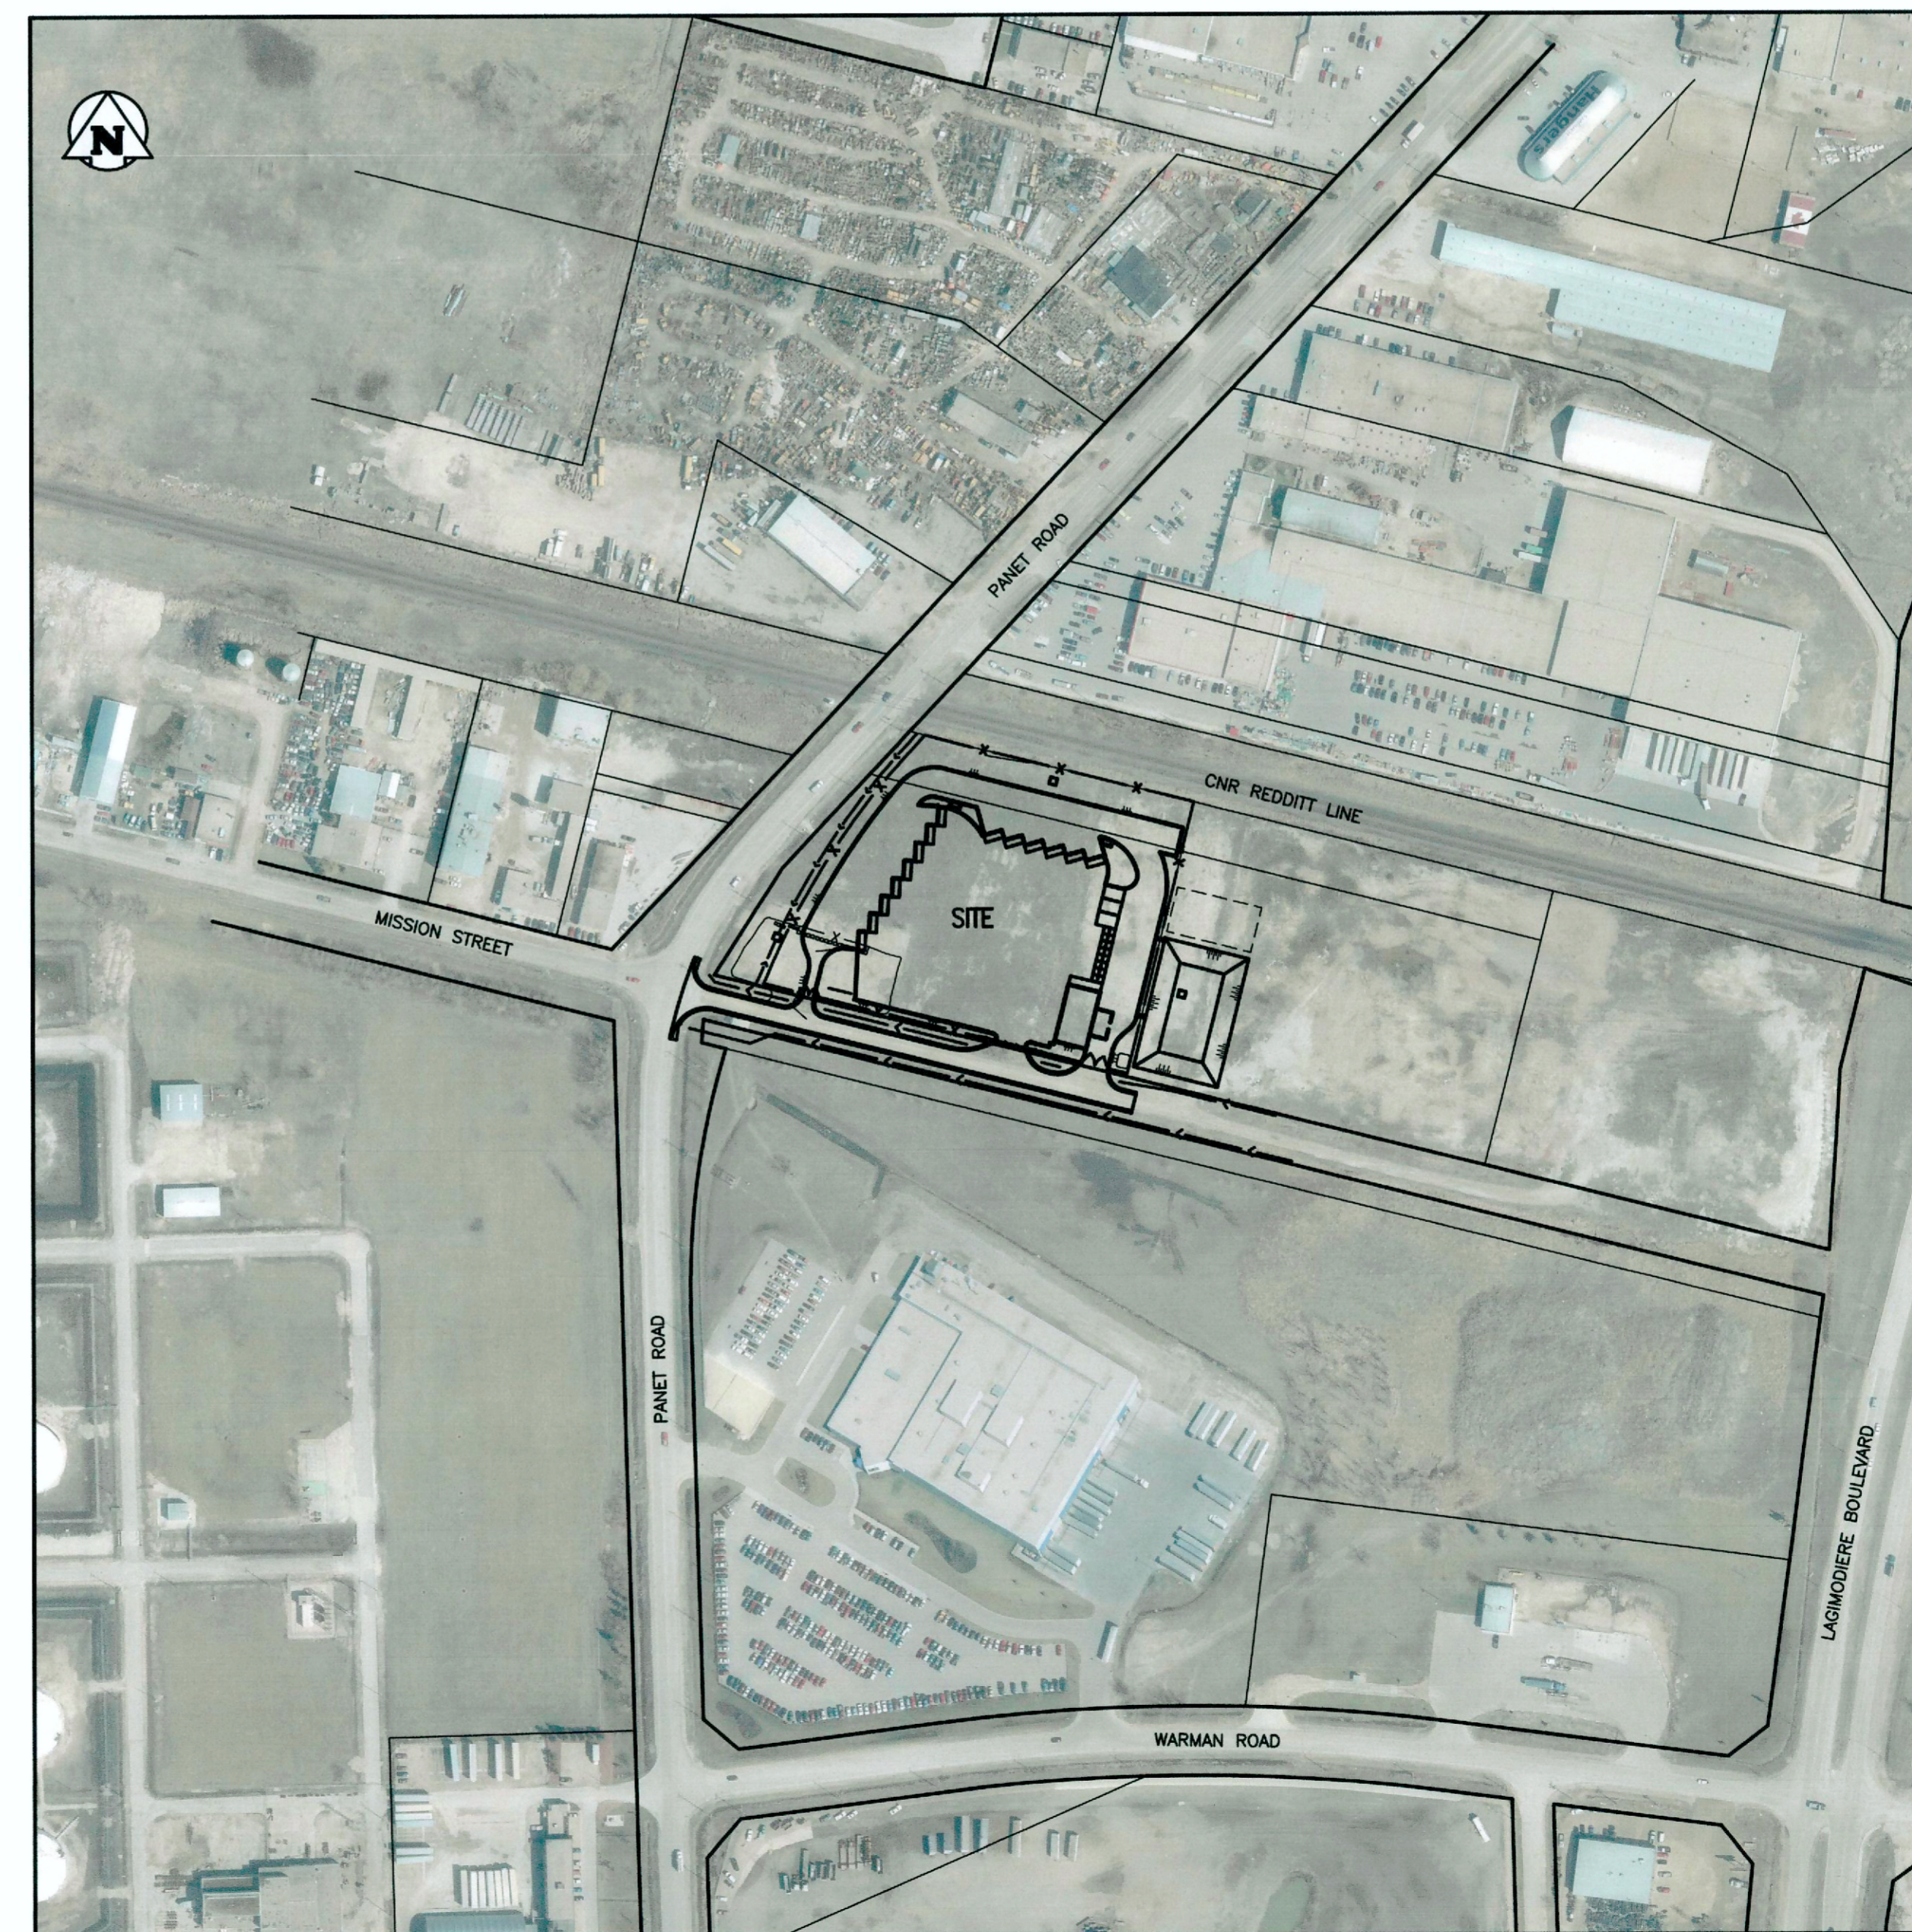

LOCATION PLAN
(NTS)