


No.	Date	Revision Notes
1.	2017.05.02	Issued for Construction
2.	2017.06.01	Issued for Add#01E

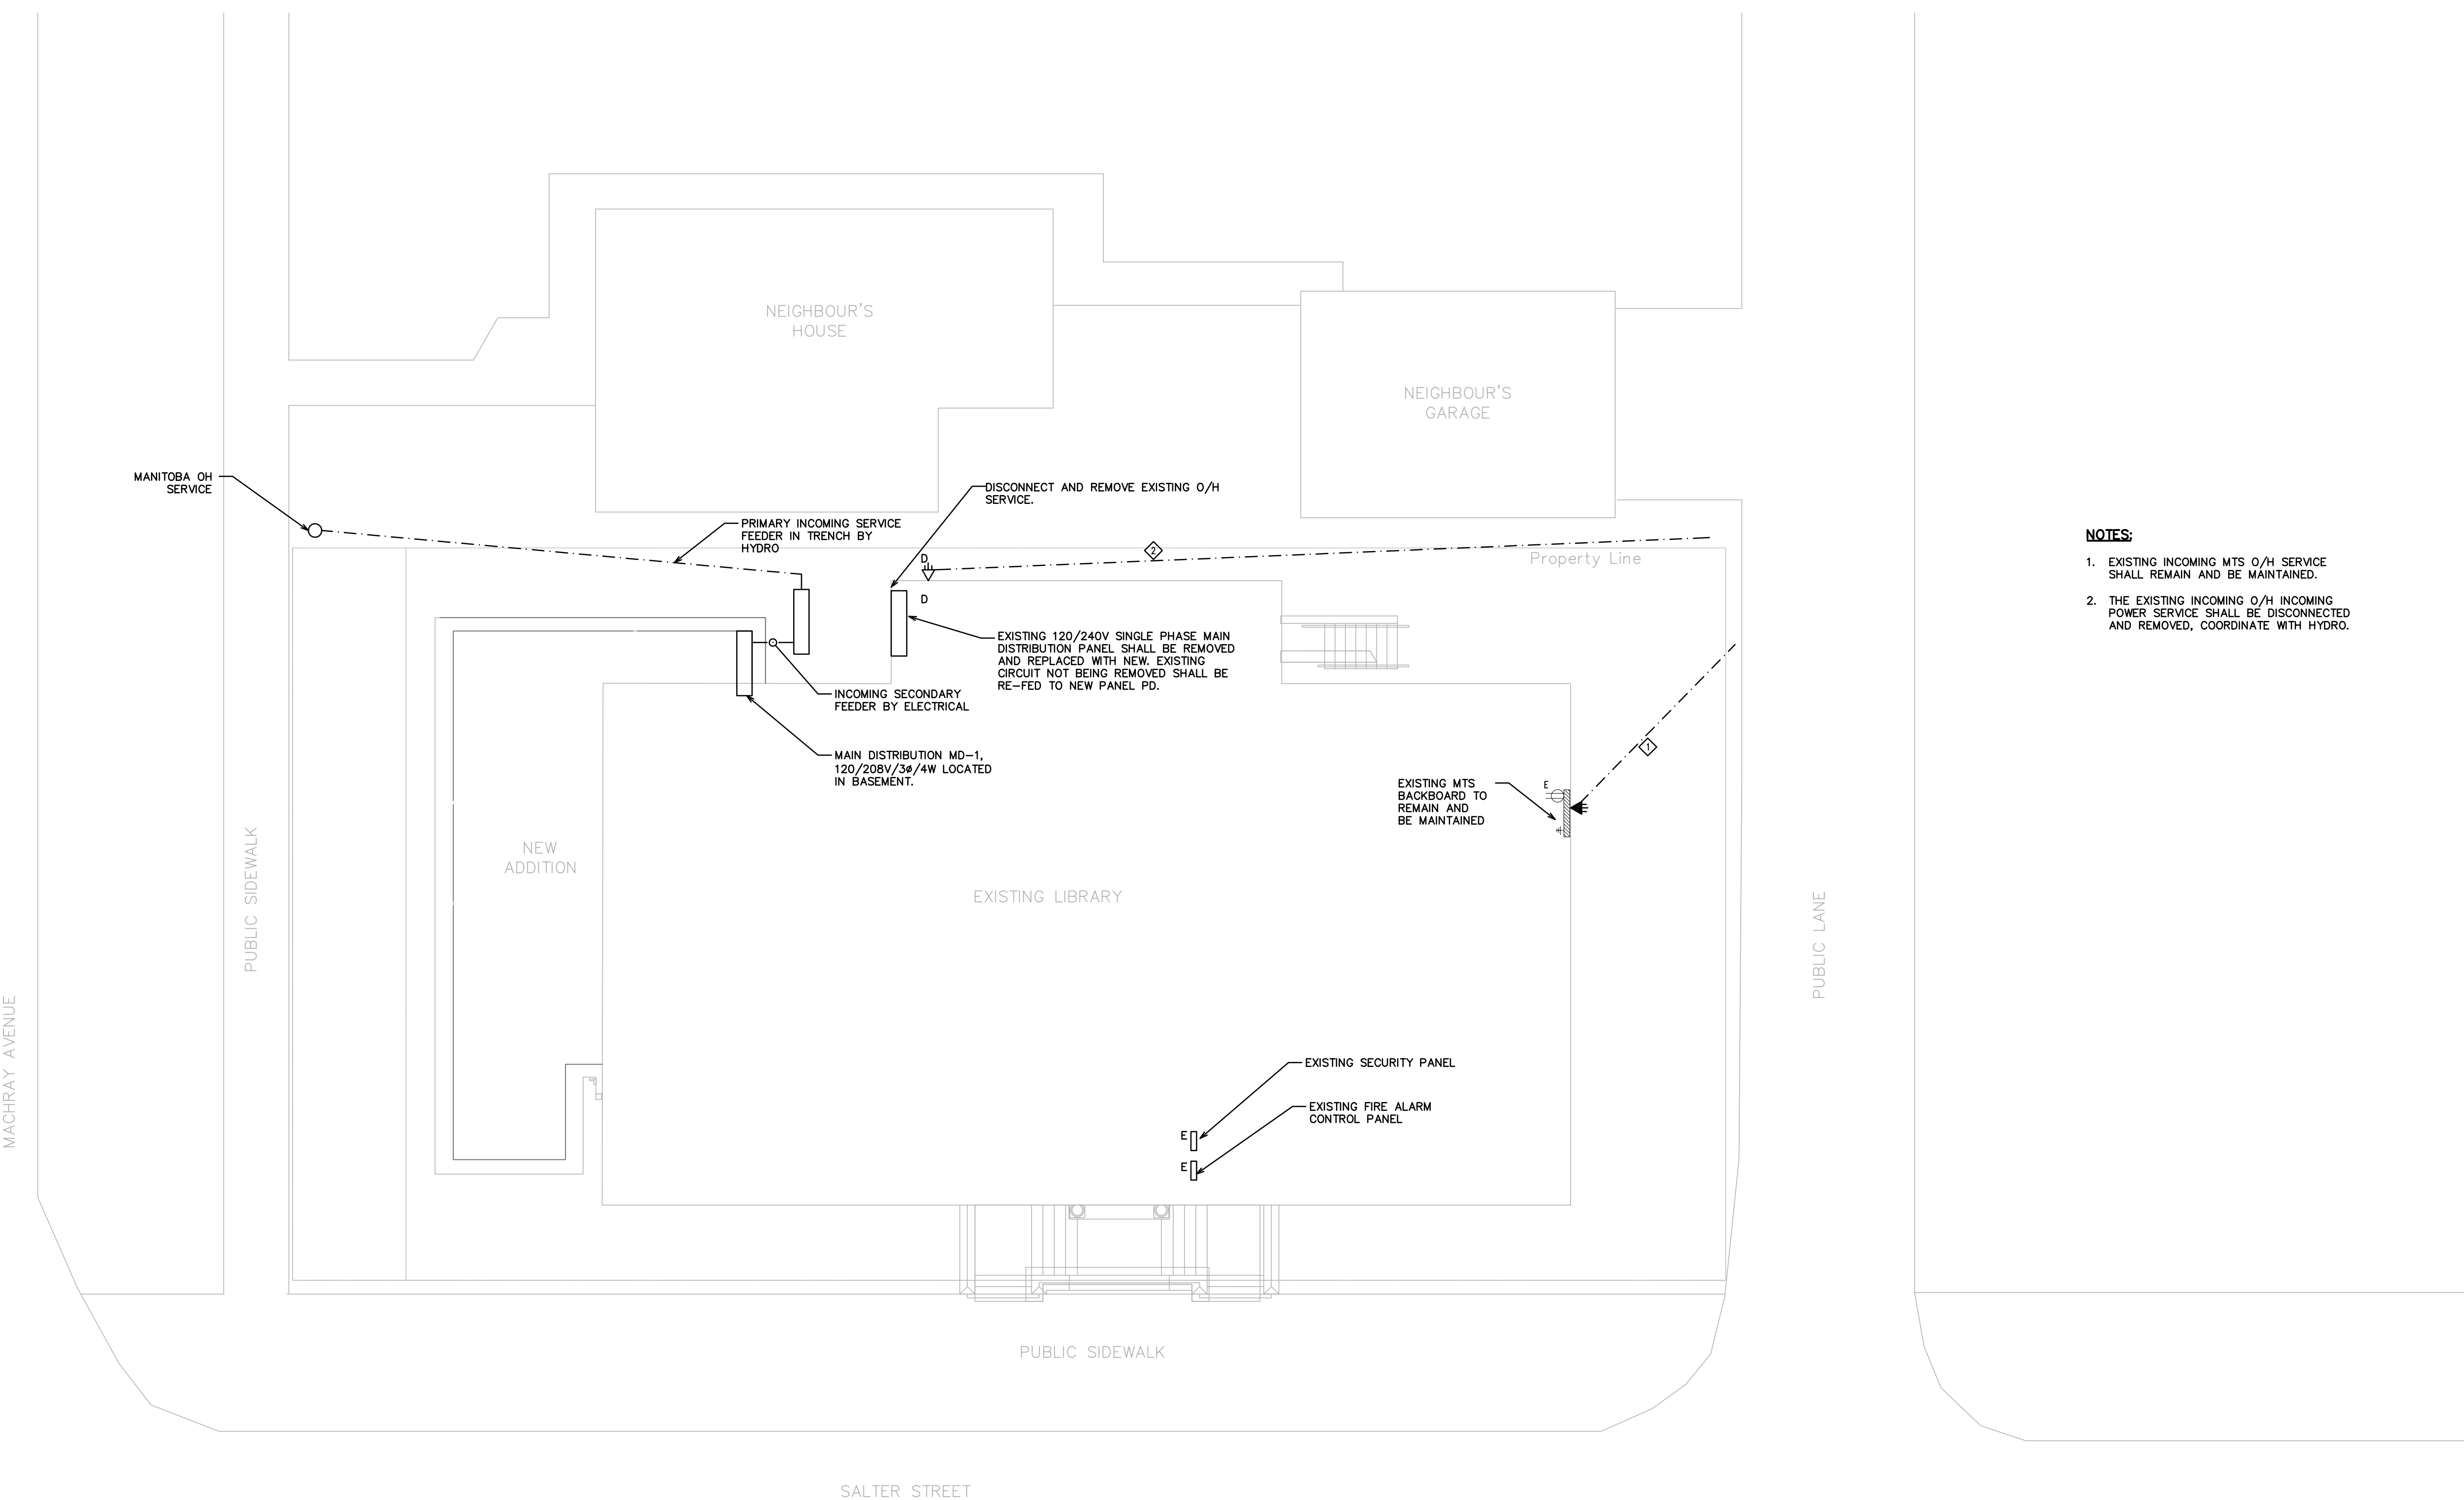

- NOTES:**
- EXISTING INCOMING MTS O/H SERVICE SHALL REMAIN AND BE MAINTAINED.
 - THE EXISTING INCOMING O/H INCOMING POWER SERVICE SHALL BE DISCONNECTED AND REMOVED, COORDINATE WITH HYDRO.



10557
MCW
MCW / AGE
 Consulting Professional Engineers
 210-1871 Wellington Avenue
 Winnipeg, Manitoba, R3W 0G4
 Phone: (204) 778-2800 Fax: (204) 778-1119
 E-Mail: mcw_wpg@mcw.com



This drawing must not be scaled. The contractors shall verify all dimensions and other data on site prior to commencement of work. Discrepancies, errors, and omissions are to be reported to the Architect prior to proceeding with the Work.

Drawings and specifications as instruments of service are the property of the Architect; the copyright in the same being reserved to him.

No reproduction or revision to these drawings may be made without the permission of the Architect, and when made, must bear his name. All prints to be returned to the Architect upon request.

Project
St. John's Library Renovation

Drawing
SITE PLAN - ELECTRICAL LAYOUT

Drawn By
 KLG

Reviewed By
 DG

Scale
 1:100

Drawing No.
E1.1

Date
 2017.05.02

Project No.
 1503b

Revision No.

1 SITE PLAN - ELECTRICAL LAYOUT
 E1.1 SCALE: 1:100