 





DRAWING LIST	
A0	SITE PLAN
A1	OUTDOOR HOCKEY RINK LAYOUT PLAN & RINK BASE CONSTRUCTION
A2	HOCKEY RINK ELEVATION, ACCESS GATE ELEVATION & GATE DETAILS W/ FENCING
A3	VEHICLE ACCESS GATE ELEVATION
A4	RINK BOARD ELEVATIONS W/ FENCING; SECTIONS & DETAILS
A5	PLAYERS /PENALTY BOXES WITH FENCING -PLAN & ELEVATION
A6	PLAYERS /PENALTY BOXES WITH FENCING SECTION, ELEVATION & DETAILS
A7	SPECIFICATIONS

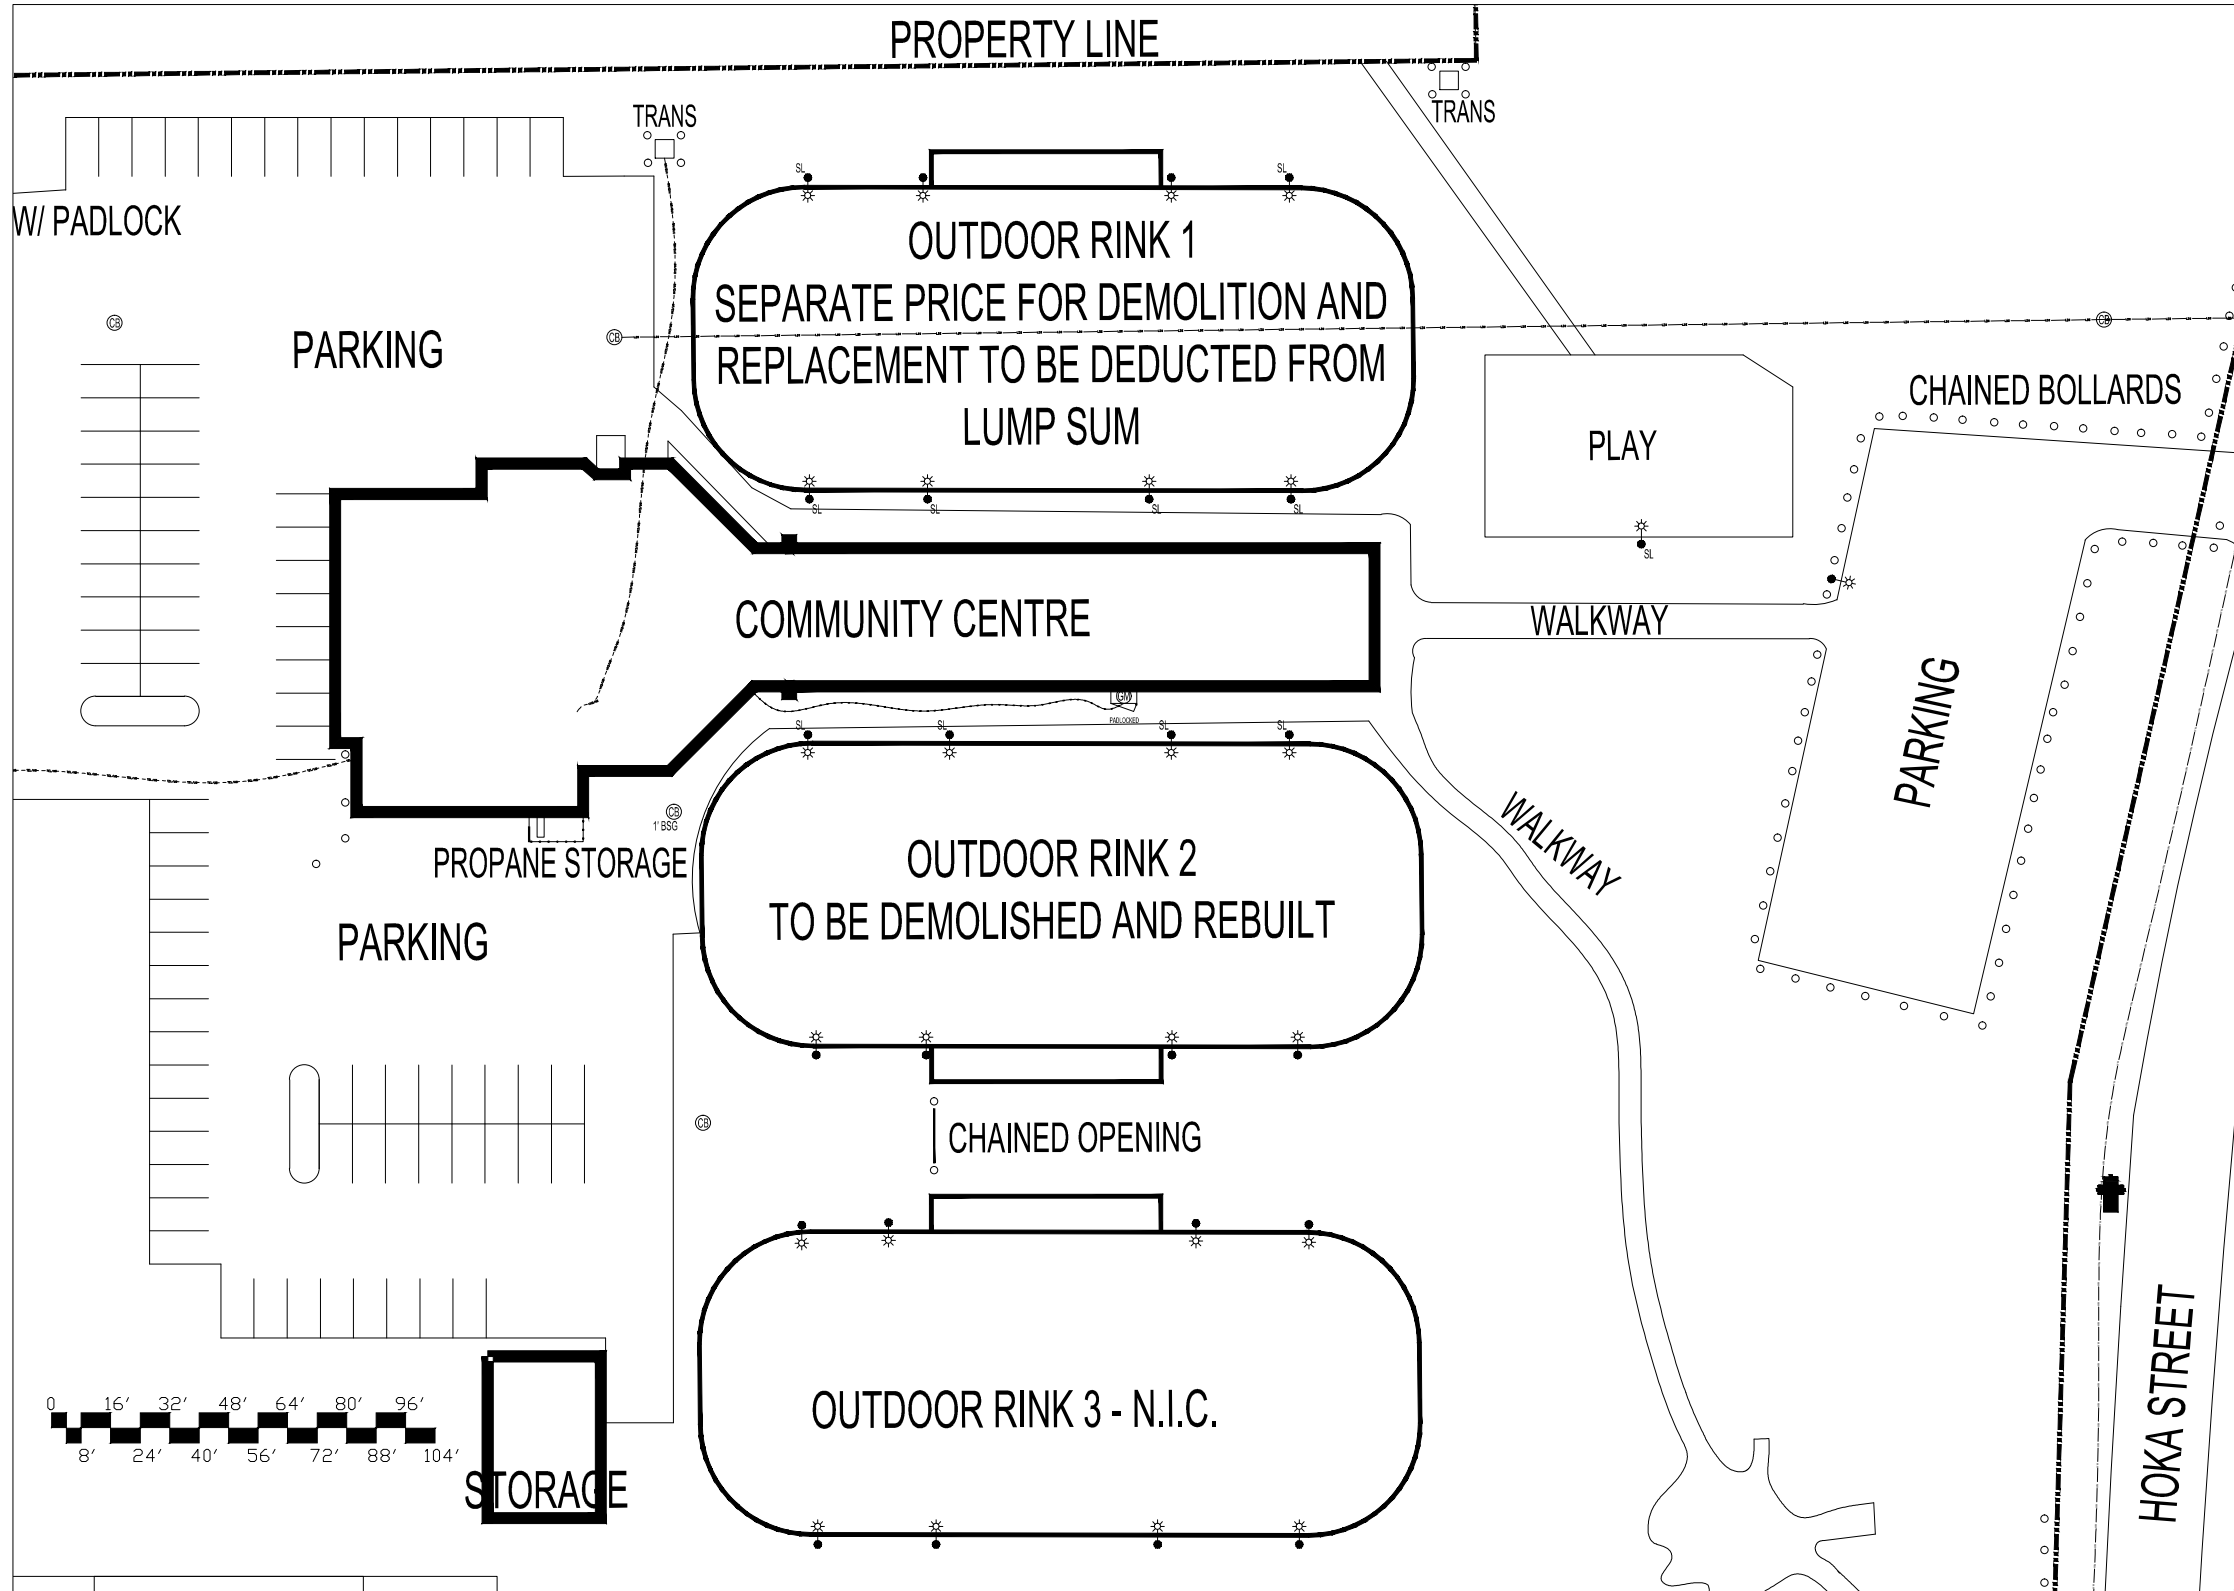

LEGEND	
	WATER VALVE
	MANHOLE
	STREET/PROPERTY LIGHT
	CATCH BASIN INCHES BELOW SURFACE GRADE (BSG)
	HYDRO POLE
	HYDRO POLE W/LIGHT
	FIRE HYDRANT
	GAS METER
	GAS VALVE W/ SHUT-OFF
	WATER METER W/VALVE
	CLEAN-OUT (SEWER)
	ELECTRICITY METER
	ELECTRICAL PANEL
	LIGHTING PANEL
	COMBINED SEWER
	LAND DRAINAGE SEWER
	WASTE WATER SEWER
	SEWER MAIN-STORM RELIEF
	WATERMAIN
	NATURAL GAS LINE
	HYDRO CABLES UNDERGROUND (U/G)
	COMMUNICATION CABLES UNDERGROUND (U/G)
	SECURITY CABLES UNDERGROUND (U/G)
	IRRIGATION LINES UNDERGROUND (U/G)

V:\A-CAD\ARCHIVE\SPEC\HOCKEY RINK

THE CITY OF WINNIPEG PLANNING, PROPERTY AND DEVELOPMENT DEPARTMENT MUNICIPAL ACCOMMODATIONS DIVISION 3-65 GARRY STREET, R3C 4K4		SHEET TITLE SITE PLAN		PROJECT CC-064 PARK CITY WEST COMMUNITY CENTRE OUTDOOR RINK REPLACEMENT 115 SANFORD FLEMING ROAD BID OPP#617-2017	
DRAWN BY: JAW	DESIGNED BY:	CHECKED BY:	APPROVED BY:	DATE: 2017.07.21 eFILE: 2017087V0.dwg	SCALE: N.T.S. PROJECT No: 2017-087
				SHEET No: <b>A0</b>	

DRAWING SHEET SIZE: ANSI "B" (11"x17") PLOT 1:1