


PLAN - DRIVEWAY IMPROVEMENTS AND TEMPORARY ACCESS ROAD
SCALE: 1 : 200

CONSTRUCTION NOTES:

- 1 PROVIDE AND INSTALL NEW CONCRETE DRIVEWAY EXTENSION IN ACCORDANCE WITH CITY OF WINNIPEG STANDARD CONSTRUCTION SPECIFICATIONS - CW 3310-R17, SD-232, SD-237.
- 2 COORDINATE WITH MANITOBA HYDRO FOR INSTALLATION OF A NEW NATURAL GAS SERVICE. CONTRACTOR AND MANITOBA HYDRO TO FIELD-DETERMINE OPTIMAL ROUTING AND LOCATION OF GAS LINE, REGULATOR AND METER.
- 3 REFER TO ELECTRICAL DRAWING 1-0310L-E0002 FOR INSTALLATION OF NEW ELECTRICAL SERVICE EQUIPMENT.
- 4 INSTALL TEMPORARY ACCESS ROADWAY ON THE NORTH SIDE OF THE STATION. CONTRACTOR TO DEMOLISH ACCESS ROADWAY UPON COMPLETION OF THE WORK AND RESTORE THE SITE TO EXISTING CONDITIONS AND TO THE SATISFACTION OF THE CONTRACT ADMINISTRATOR.
- 5 INSTALL PUMPHOUSE ADDITION ACCESS WALKWAY ON THE EAST SIDE OF THE STATION. LANDSCAPE AREA BETWEEN WALKWAY AND BUILDING WITH GRAVEL - CW3325-R5.

LEGEND

- NEW WORK _____
- EXIST. STRUCTURE TO REMAIN _____
- EXIST. GAS SERVICE _____
- NEW GAS SERVICE _____
- EXIST. WATERMAIN _____

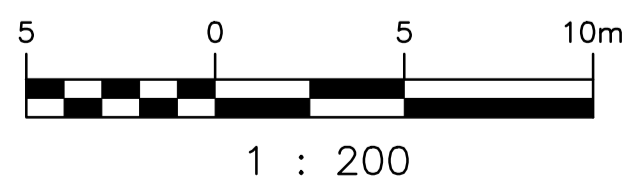

NO.	REVISIONS	DATE	DESIGN	CHECK
00	ISSUED FOR TENDER, BID OPP. 639-2017	2017-07-25	FZ	BJC

		SNC-LAVALIN INC. 148 Nature Park Way Winnipeg, MB, Canada R3P 0X7 204-786-8080	
DESIGNED BY:	F. ZURZOLO	CHECKED BY:	B. CLEVEN
DRAWN BY:	D. CALVERLEY	APPROVED BY:	B. CLEVEN
SCALE:	AS NOTED	ISSUED FOR CONSTRUCTION BY:	
DATE:	2017/04/18	DATE:	
CONSULTANT NO.:			

ENGINEER'S SEAL
PRELIMINARY
NOT TO BE USED FOR CONSTRUCTION

THE CITY OF WINNIPEG
WATER AND WASTE DEPARTMENT

COMMUNITY ROW WASTEWATER PUMPING STATION
2017 UPGRADES
SITE PLAN
CIVIL WORKS

CITY DRAWING NUMBER	SHEET	REV.	SIZE
1-0130L-C0002	001	00	A1