


MAIN FLOOR PLAN
SCALE: 1 : 20

DEMOLITION NOTES

- (A) PROVIDE DEMOLITION OF EXISTING MOTOR CONTROL CENTRE. DEMOLISH ALL ASSOCIATED CONDUIT AND CABLING.
- (B) PROVIDE DEMOLITION OF EXISTING VARIABLE FREQUENCY DRIVE. DEMOLISH ALL ASSOCIATED PULL BOXES, CONDUIT, AND CABLING.
- (C) PROVIDE DEMOLITION OF EXISTING REMOTE TERMINAL UNIT, BACKBOARD, RECEPTACLE, AND ASSOCIATED CONDUIT AND CABLE.
- (D) PROVIDE DEMOLITION OF WET WELL LEVEL TRANSMITTER, BACKBOARD, AND ALL ASSOCIATED CONDUIT, CABLE, AND WIRING. DEMOLISH LEVEL TRANSMITTER PIPING TO THE WETWELL. PIPING IS ROUTED OUTDOORS AND INTO THE WETWELL VIA A DIRECT BURIED TRENCH INTO THE MANHOLE.
- (E) PROVIDE DEMOLITION OF EXISTING UNIT HEATER AND ASSOCIATED CABLING, CONDUIT, AND CONTROLS.
- (F) PROVIDE DEMOLITION OF EXISTING LIGHT FIXTURE AND ALL ASSOCIATED CABLE, CONDUIT, AND CONTROLS.
- (G) PROVIDE DEMOLITION OF EXISTING UTILITY METER ENCLOSURE. COORDINATE WITH MANITOBA HYDRO TO DETERMINE IF METER IS SUITABLE FOR RE-USE. IF METER IS NOT SUITABLE FOR RE-USE THEN TURN OVER TO MANITOBA HYDRO.
- (H) PROVIDE DEMOLITION OF EXISTING SUPPLY FAN AND DUCT HEATER AND ASSOCIATED CABLING, CONDUITS, AND CONTROLS.
- (J) PROVIDE DEMOLITION OF EXISTING DEVICE BOX AND ASSOCIATED CONDUIT AND CABLE.
- (K) PROVIDE DEMOLITION OF EXISTING SERVICE CABLES AND CABLE COVER. IN-FILL EXISTING WALL PENETRATIONS.
- (L) PROVIDE DEMOLITION OF EXISTING CONDUIT, FITTINGS, AND ASSOCIATING CABLING. IN-FILL EXISTING WALL PENETRATION.
- (M) PROVIDE DEMOLITION OF EXISTING TELEPHONE SERVICE BOX AND ASSOCIATED CONDUITS. COORDINATE WITH TELEPHONE SERVICE PROVIDER AS REQUIRED.
- (N) PROVIDE DEMOLITION OF EXISTING TELEPHONE AND ASSOCIATED JUNCTION BOX, CONDUIT, AND CABLING.
- (O) CONTRACTOR TO ALLOW FOR CITY OF WINNIPEG TO SALVAGE ANY EQUIPMENT OR COMPONENTS PRIOR TO REMOVAL AND DISPOSAL.

LEGEND:

- EXISTING
- - - DEMOLISH

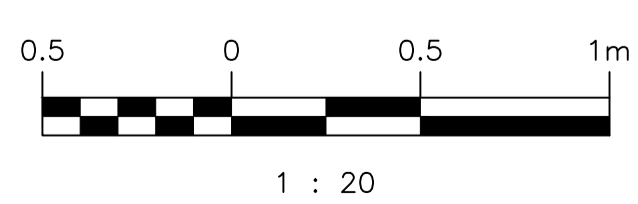

NO.	REVISIONS	DATE	DESIGN	CHECK
00	ISSUED FOR TENDER, BID OPP. 639-2017	2017-07-25	BJC	TMC

		SNC-LAVALIN INC. 148 Nature Park Way Winnipeg, MB, Canada R3P 0X7 204-786-8080	
DESIGNED BY:	B. CLEVEN	CHECKED BY:	T. CHURCH
DRAWN BY:	Y. KONIG	APPROVED BY:	B. CLEVEN
SCALE:	1:20	ISSUED FOR CONSTRUCTION BY:	
DATE:	2017/01/31	DATE:	
CONSULTANT NO.:			

ENGINEER'S SEAL

PRELIMINARY
NOT TO BE
USED FOR
CONSTRUCTION

THE CITY OF WINNIPEG
WATER AND WASTE DEPARTMENT

COMMUNITY ROW WASTEWATER PUMPING STATION
2017 UPGRADES
ELECTRICAL AND LIGHTING PLAN LAYOUT
MAIN FLOOR
DEMOLITION

CITY DRAWING NUMBER	SHEET	REV.	SIZE
1-0130L-E0003	001	00	A1

DRAWING NUMBER	REFERENCE DRAWINGS
----------------	--------------------