




FLOOR PLAN
SCALE: 3/8" = 1'-0"

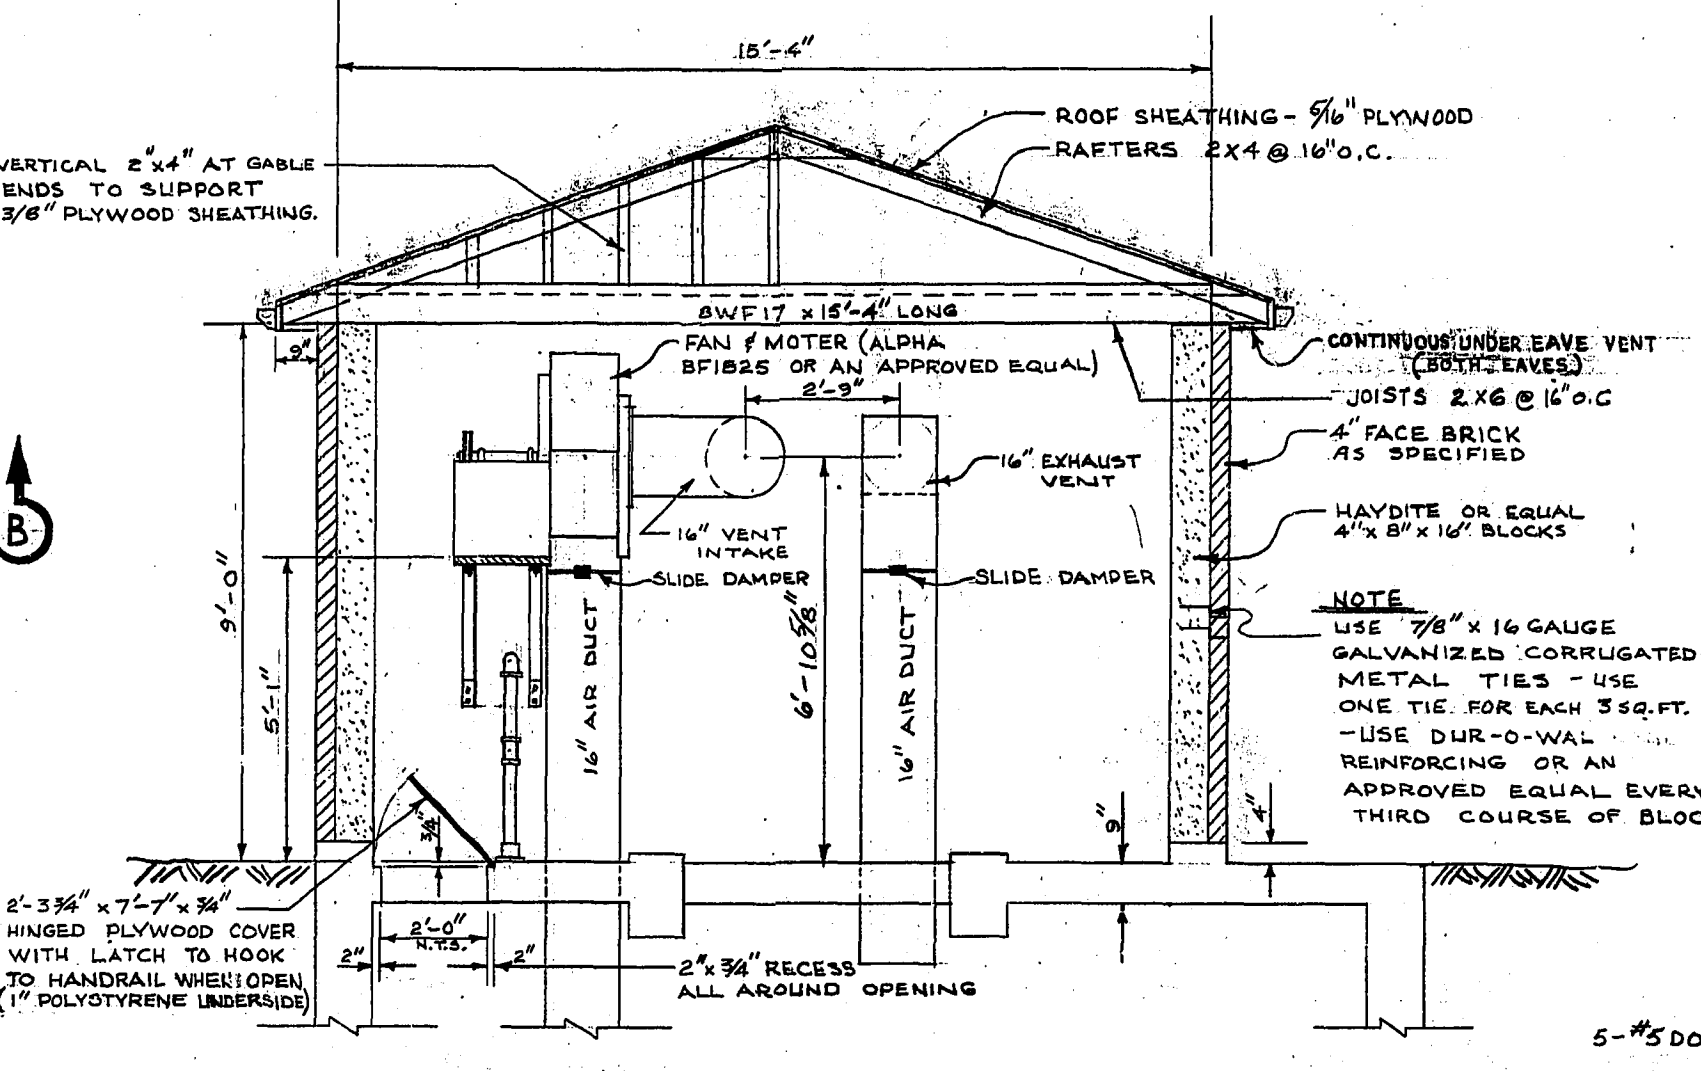


SEC. "A-A"
SCALE: 3/8" = 1'-0"

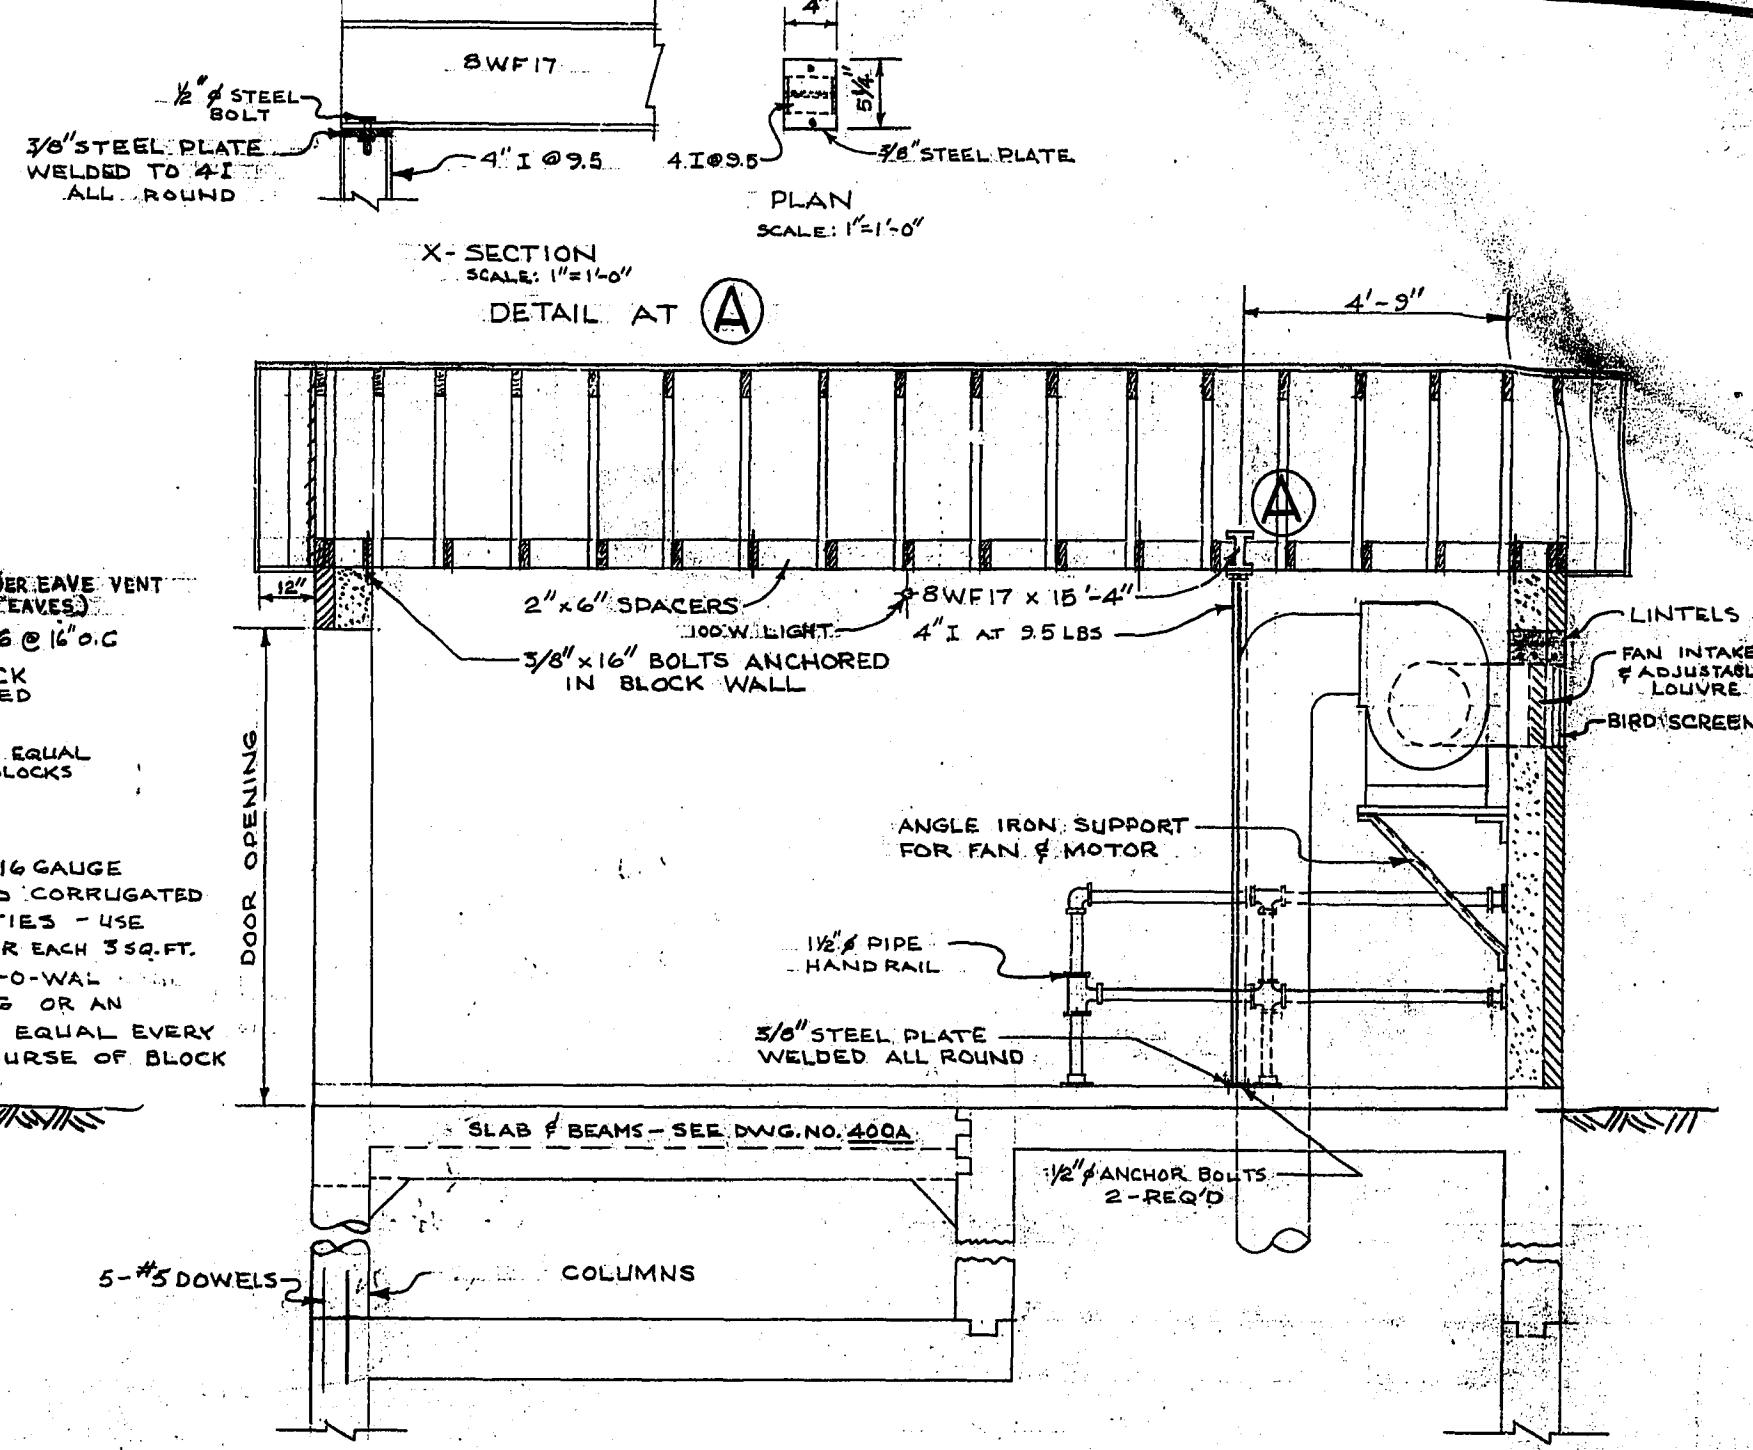


SEC. "B-B"
SCALE: 3/8" = 1'-0"

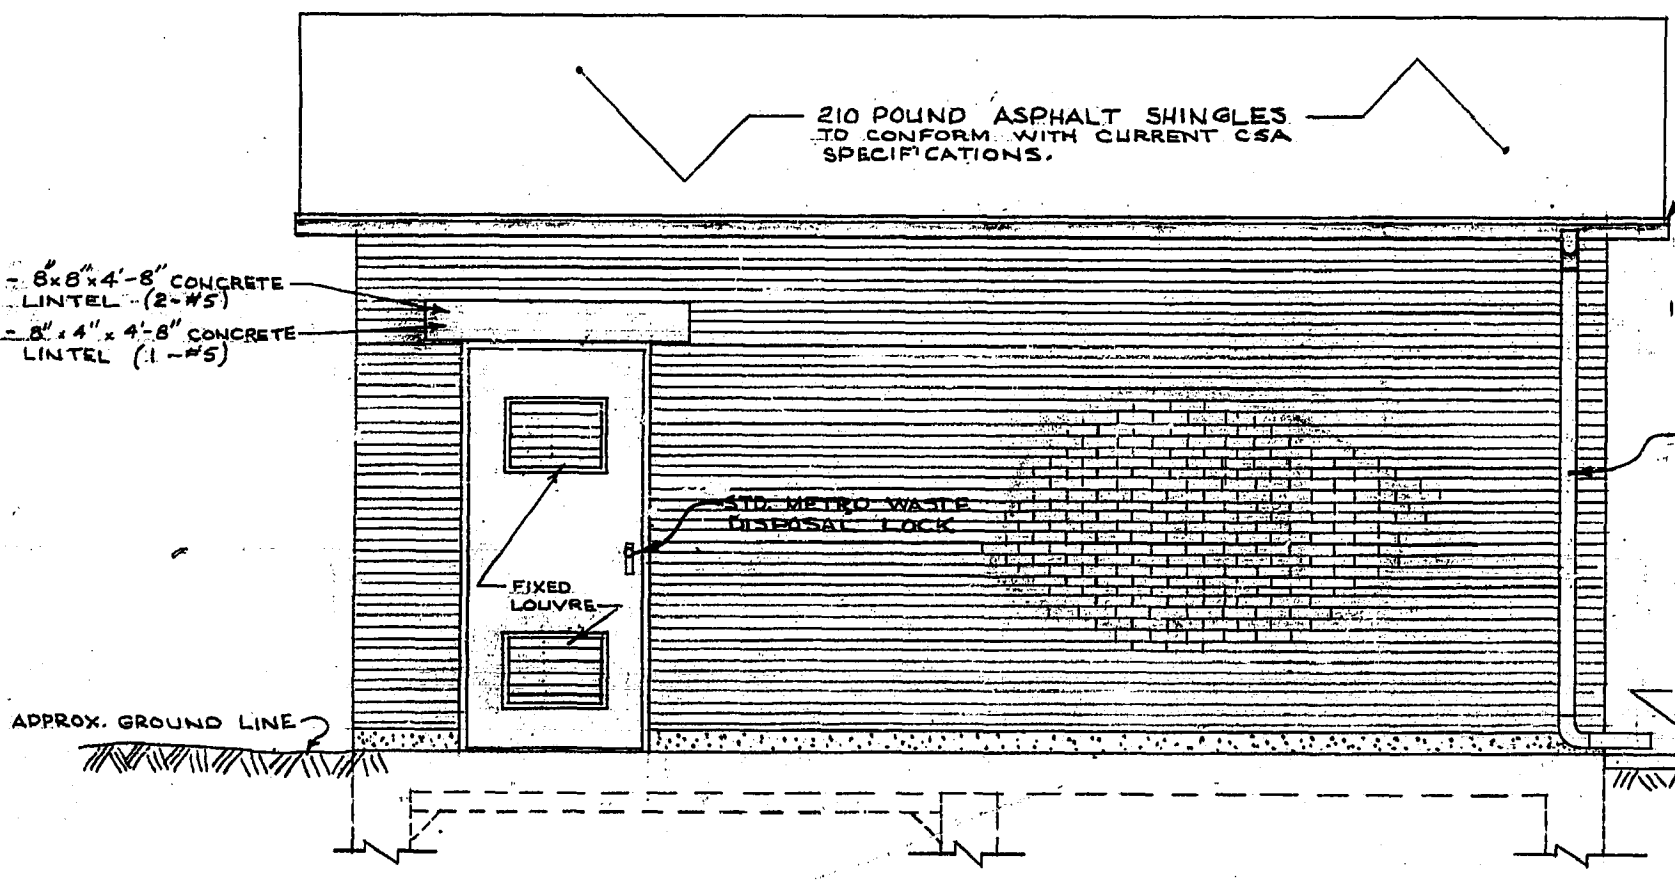


EAST WALL ELEVATION
SCALE: 3/8" = 1'-0"

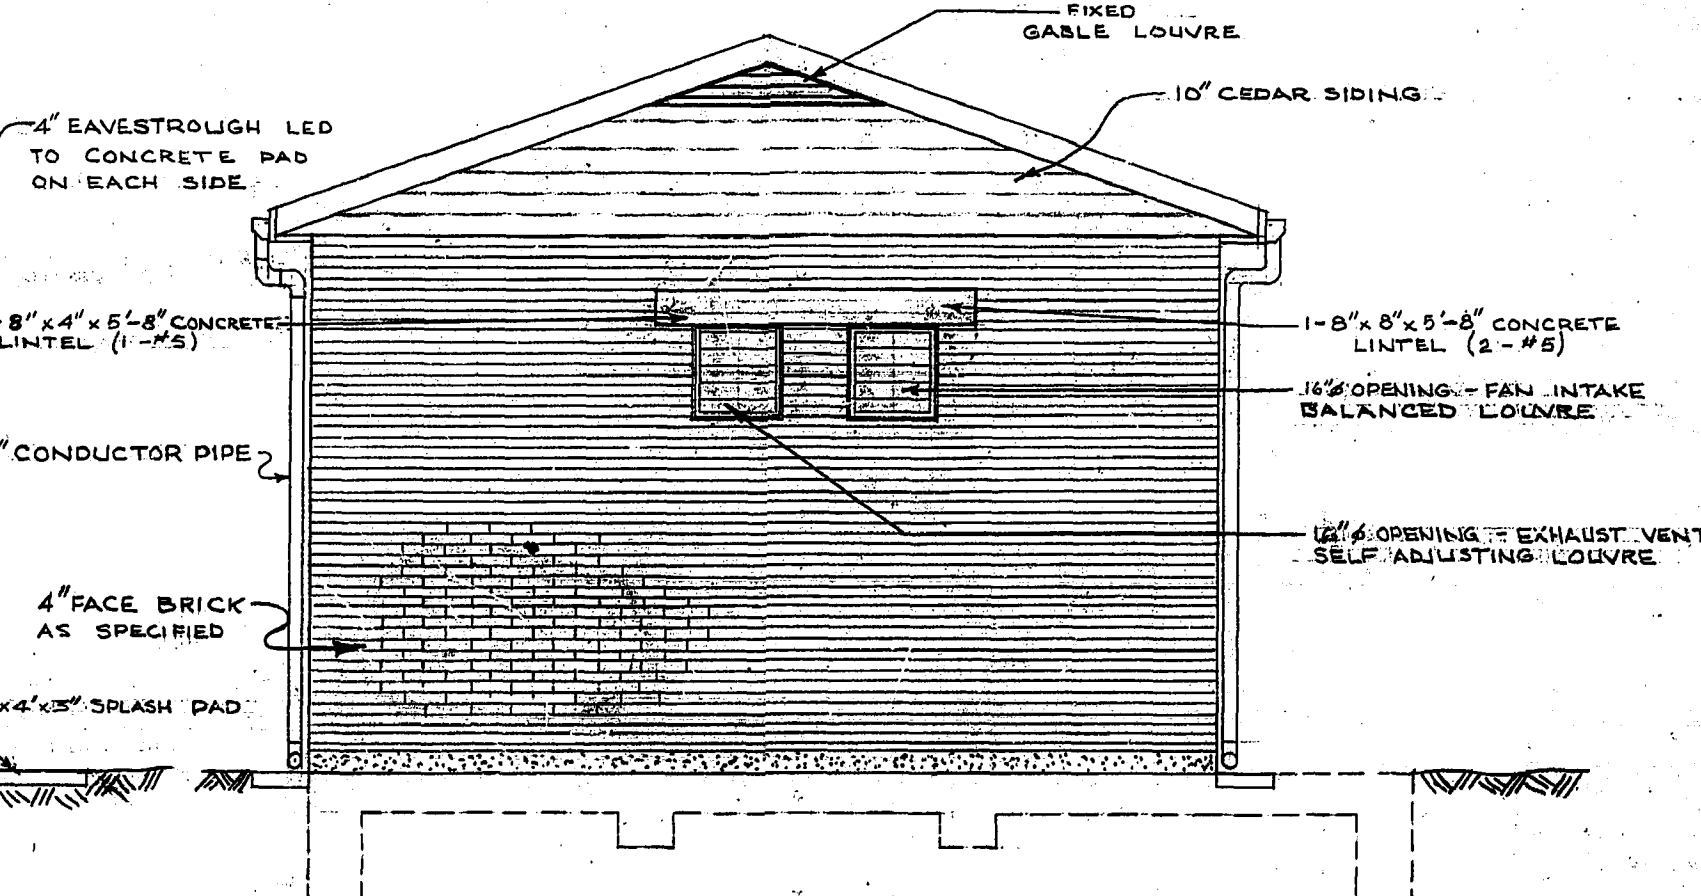

NORTH WALL ELEVATION
SCALE: 3/8" = 1'-0"

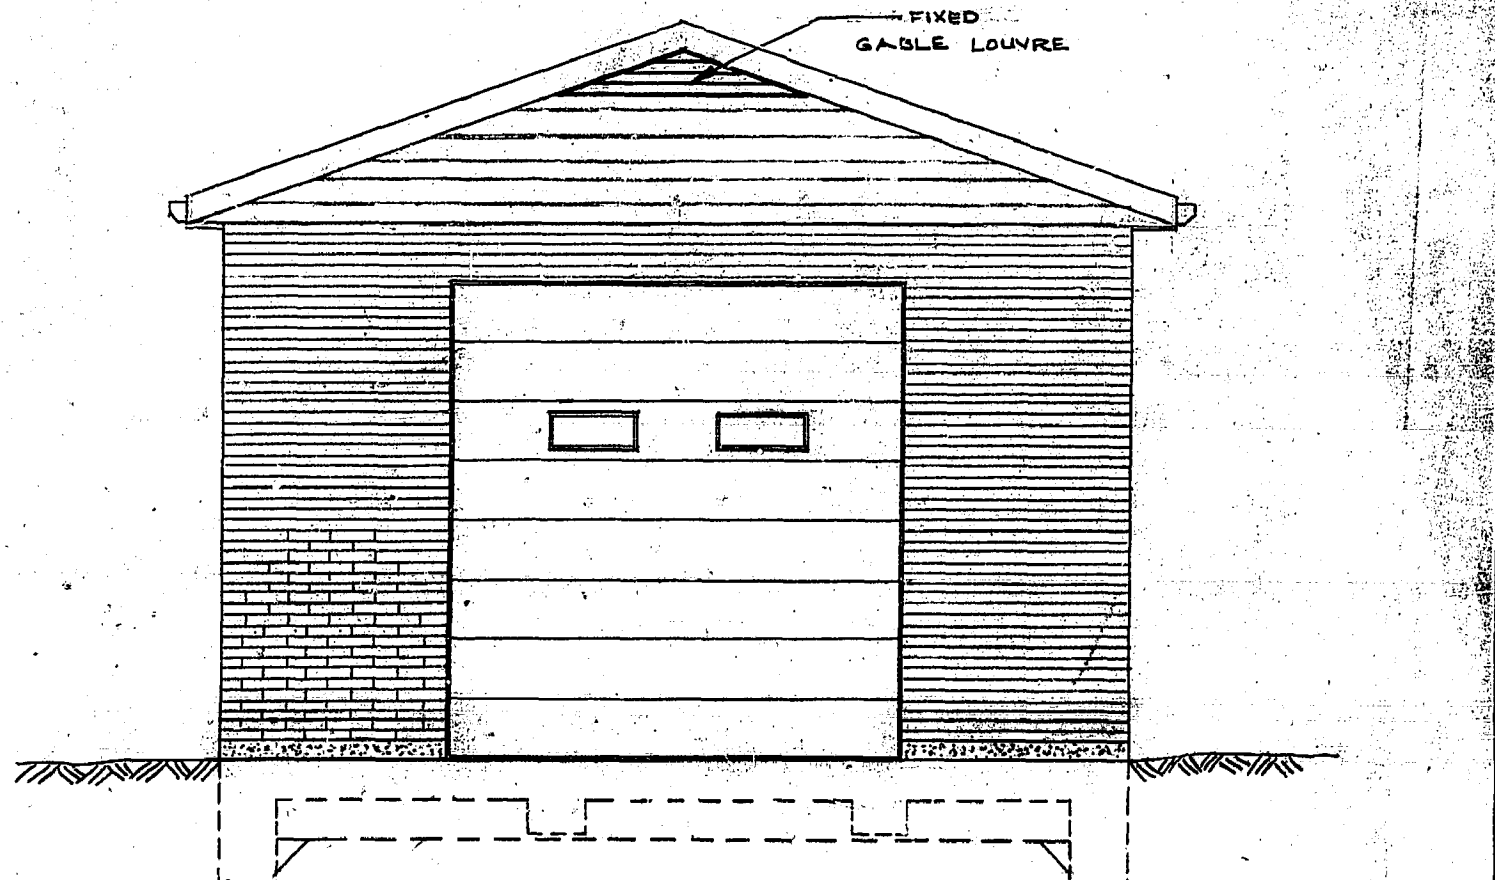

SOUTH WALL ELEVATION
SCALE: 3/8" = 1'-0"

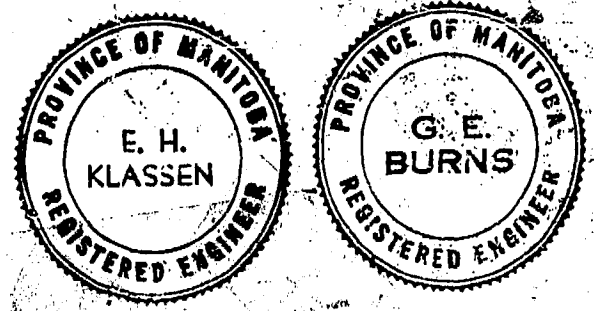

REVISIONS				THE METROPOLITAN CORPORATION OF GREATER WINNIPEG WATERWORKS & WASTE DISPOSAL DIVISION SEWAGE DISPOSAL BRANCH			
NO.	DESCRIPTION	DATE	BY				
1							
2							
3							
4							
5							
6							
7							
8							

APPROVED BY <i>[Signature]</i> CHIEF ENGINEER	DRAWN BY <i>[Signature]</i> SCALE AS SHOWN	CHECKED BY <i>[Signature]</i> DATE MAY 1/1955	DRAWING NO. 401
---	---	--	---------------------------

CHARLESWOOD INTERCEPTOR
SUPERSTRUCTURE DETAILS FOR
PUMPING STA. AT COMM. ROW