


1 MAIN FLOOR PLAN - DEMOLITION - FIRE PROTECTION
 M1.3 SCALE: 1/16" = 1'-0"

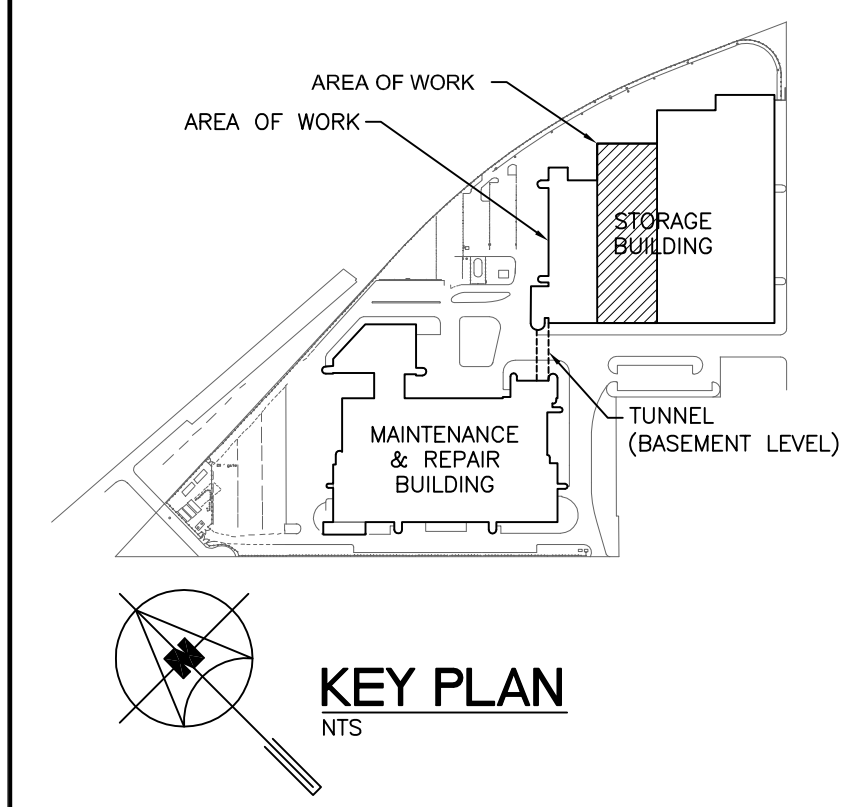

GENERAL NOTES

A. ALL ABANDONED EQUIPMENT AND SERVICES WITHIN AREA OF WORK SHALL BE REMOVED.

B. THIS BUILDING MAY CONTAIN ASBESTOS. REFER TO FRONT END SPECIFICATIONS FOR FURTHER INFORMATION.

DEMOLITION KEY NOTES [##]

1. DEMOLISH AND REMOVE UPRIGHT SPRINKLER HEADS COVERING BELOW MECHANICAL EQUIPMENT AND DUCTWORK BEING REMOVED. CONFIRM EXACT LOCATIONS ON SITE.

2. SPRINKLERS AT HIGH LEVEL (NOT SHOWN) TO REMAIN.

5			
4			
3			
2			
1			
0	ISSUED FOR CONSTRUCTION	JH	21/08/17
NO.	Description	BY	DD/MM/YY

ENGINEERS
 GEOSCIENTISTS
 MANITOBA
 Certificate of Authorization
SMS Engineering Ltd.
 No. 166

PROF. INC. OF MANITOBA
HORROCKS
 Member
 29767
 (1/1/12)
 REGISTERED PROFESSIONAL ENGINEER

770 Bradford Street
 Winnipeg, Canada
 T 204 775-0291
 SMSeng.com

SMS ENGINEERING

Winnipeg Transit

Project Title
**CITY OF WINNIPEG FORT ROUGE
 TRANSIT BASE - STORAGE TRACK
 1-12 VENTILATION UPGRADE**

WINNIPEG MANITOBA

Drawing Title
**MAIN FLOOR PLAN - DEMOLITION
 - FIRE PROTECTION**

Drawn By GB	Checked By XZ	Approved By JH
Scale AS SHOWN	Date AUGUST 2017	Project No. 16-149-02
Revision Number 0	Drawing Number M1.3	Sheet Order 3 OF 9

H:\R\J\PL\PL_1.DWG - AUGUST 15, 2017 - 10PM15ST.GBAAL