


PROPERTY LINE


PROPERTY LINE

KILDONAN DRIVE

NOTE:  
EXISTING GATE CHAMBER DIMENSIONS  
HAVE BEEN FIELD MEASURED WHERE  
ACCESSIBLE BUT MAY VARY SLIGHTLY.  
(NO EXISTING DRAWINGS ARE AVAILABLE)

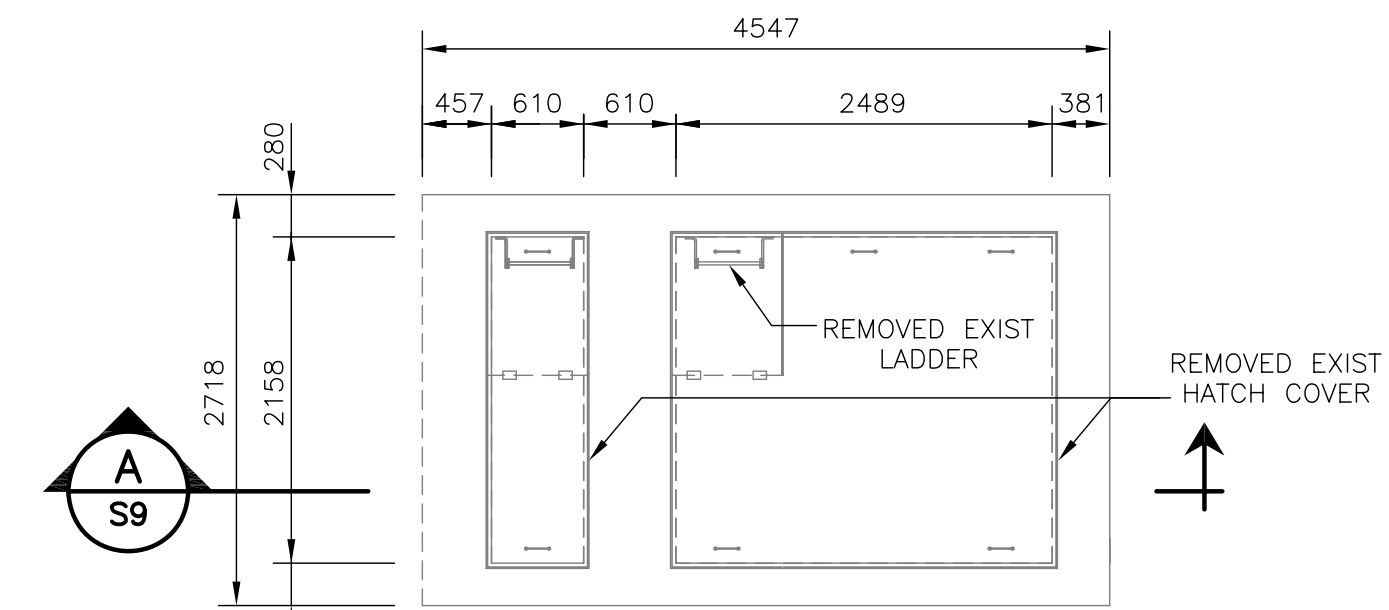

PLAN - EXISTING CHAMBER  
TOP LEVEL  
SCALE: 1:50

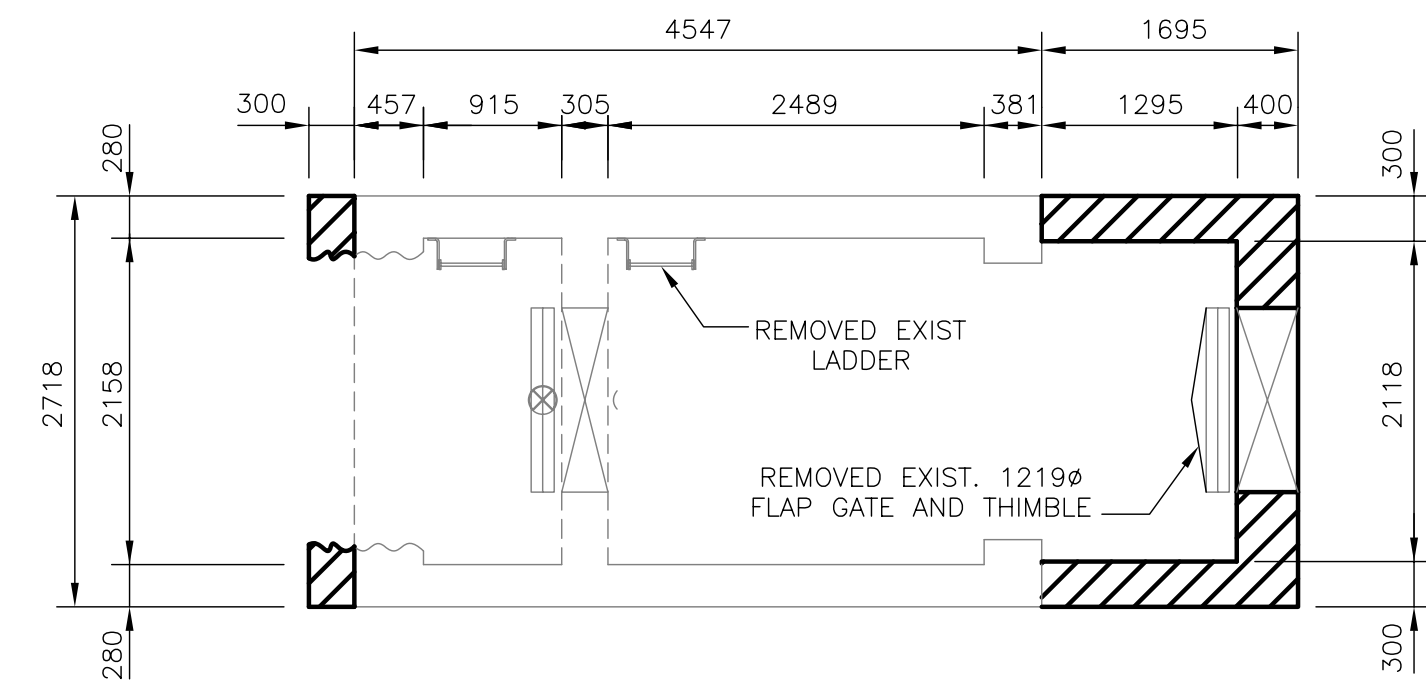

PLAN - EXISTING CHAMBER  
BOTTOM LEVEL  
SCALE: 1:50

LEGEND:

 WALL DEMOLISHED

METRIC


WHOLE NUMBERS INDICATE MILLIMETRES  
DECIMALIZED NUMBERS INDICATE METRES



SCALE: 1:250 METRIC A1  
1:500 METRIC A3

AS-CONSTRUCTED  
WATER & WASTE DEPARTMENT

PROJECT COMPLETION DATE : 20 JULY 06

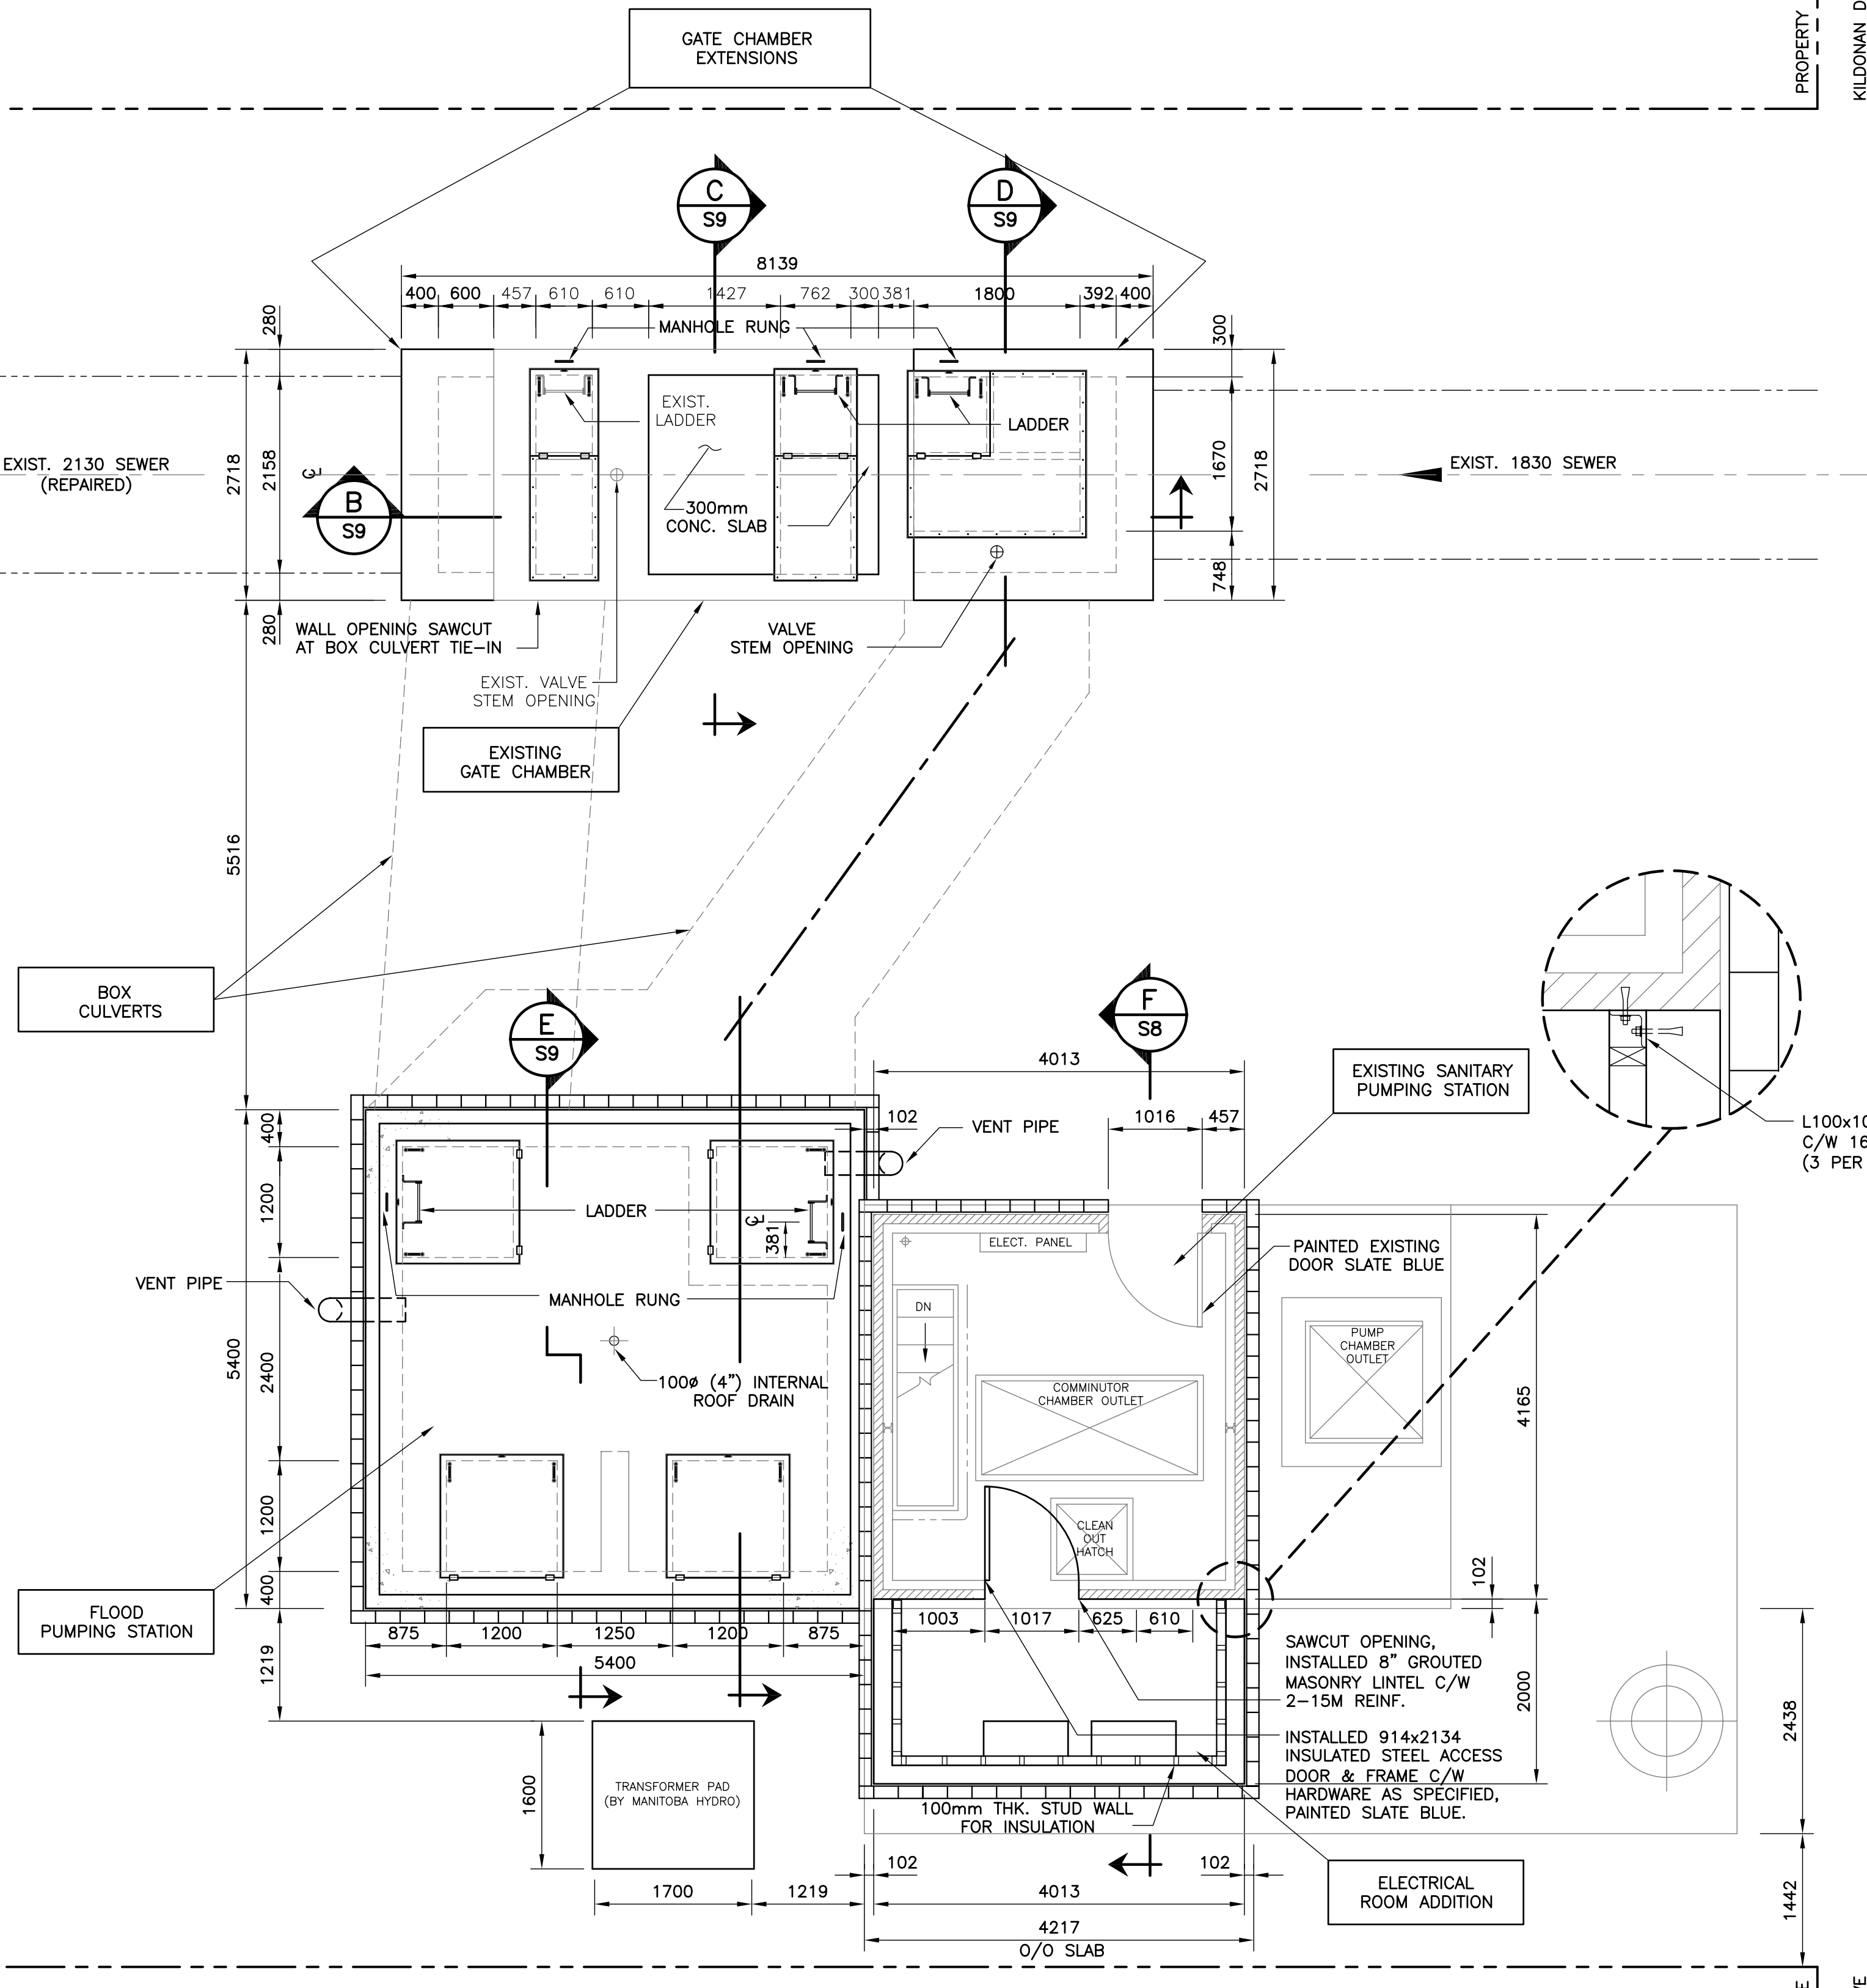

1 SITE PLAN  
SCALE: 1:50

COWLEGGEND



B.M.	XX-XXX				
ELEV.	XXX.XXX				
1	AS-CONSTRUCTED	06/12/13	CMS		
0	ISSUED FOR CONSTRUCTION	05/12/07	CMS		
NO.	REVISIONS	DATE	BY	DATE	05/11/08

**KGS GROUP**  
CONSULTING ENGINEERS & PROJECT MANAGERS  
WINNIPEG (204) 896-1209  
THUNDER BAY (807) 345-2233

DESIGNED BY	CMS	CHECKED BY	CMS
DRAWN BY	EdC	APPROVED BY	
SCALE:	AS NOTED	RELEASED FOR CONSTRUCTION:	

ENGINEER'S SEAL  
ORIGINAL DRAWING SIGNED BY:  
C.M. SIEPMAN  
12/02/07  
DD/MM/YY  
CONSULTANT DRAWING NO.  
05-0107-13-07



THE CITY OF WINNIPEG  
WATER & WASTE DEPARTMENT

HAWTHORNE FLOOD PUMPING STATION  
UPGRADE  
STRUCTURAL  
GENERAL ARRANGEMENT

SHEET 07 OF 24  
CAD FILE DRAWING NUMBER  
05-0107-13-07  
CITY DRAWING NUMBER  
LD-3244