



3 Roof Plan - Reading and Meeting Room
A-204 1:50

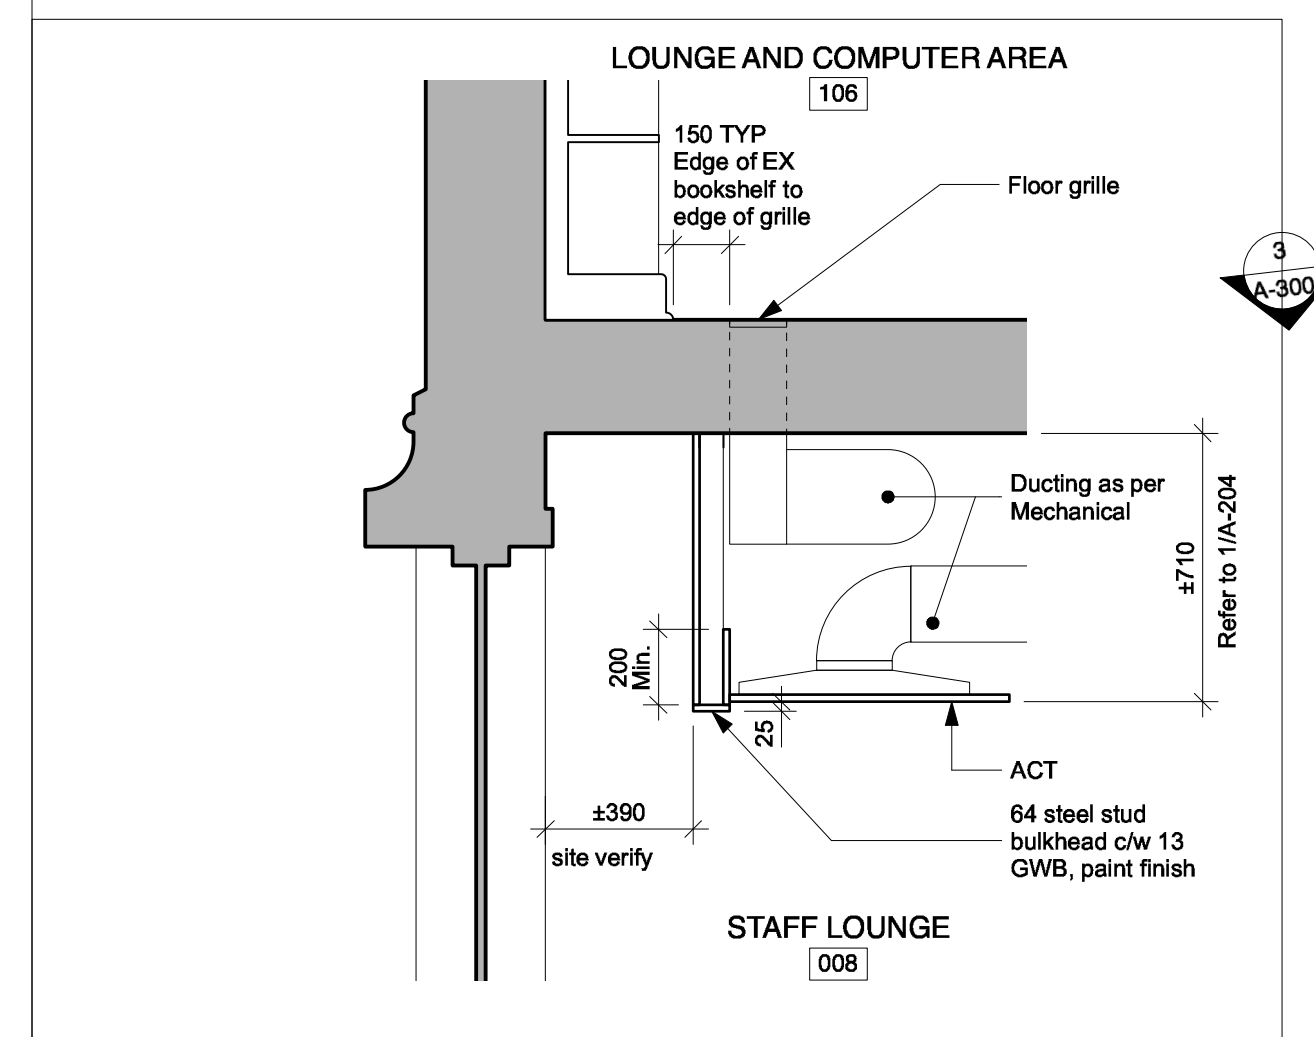

2 Section Thru Staff Lounge 008 Ceiling Bulkhead
A-204 1:20

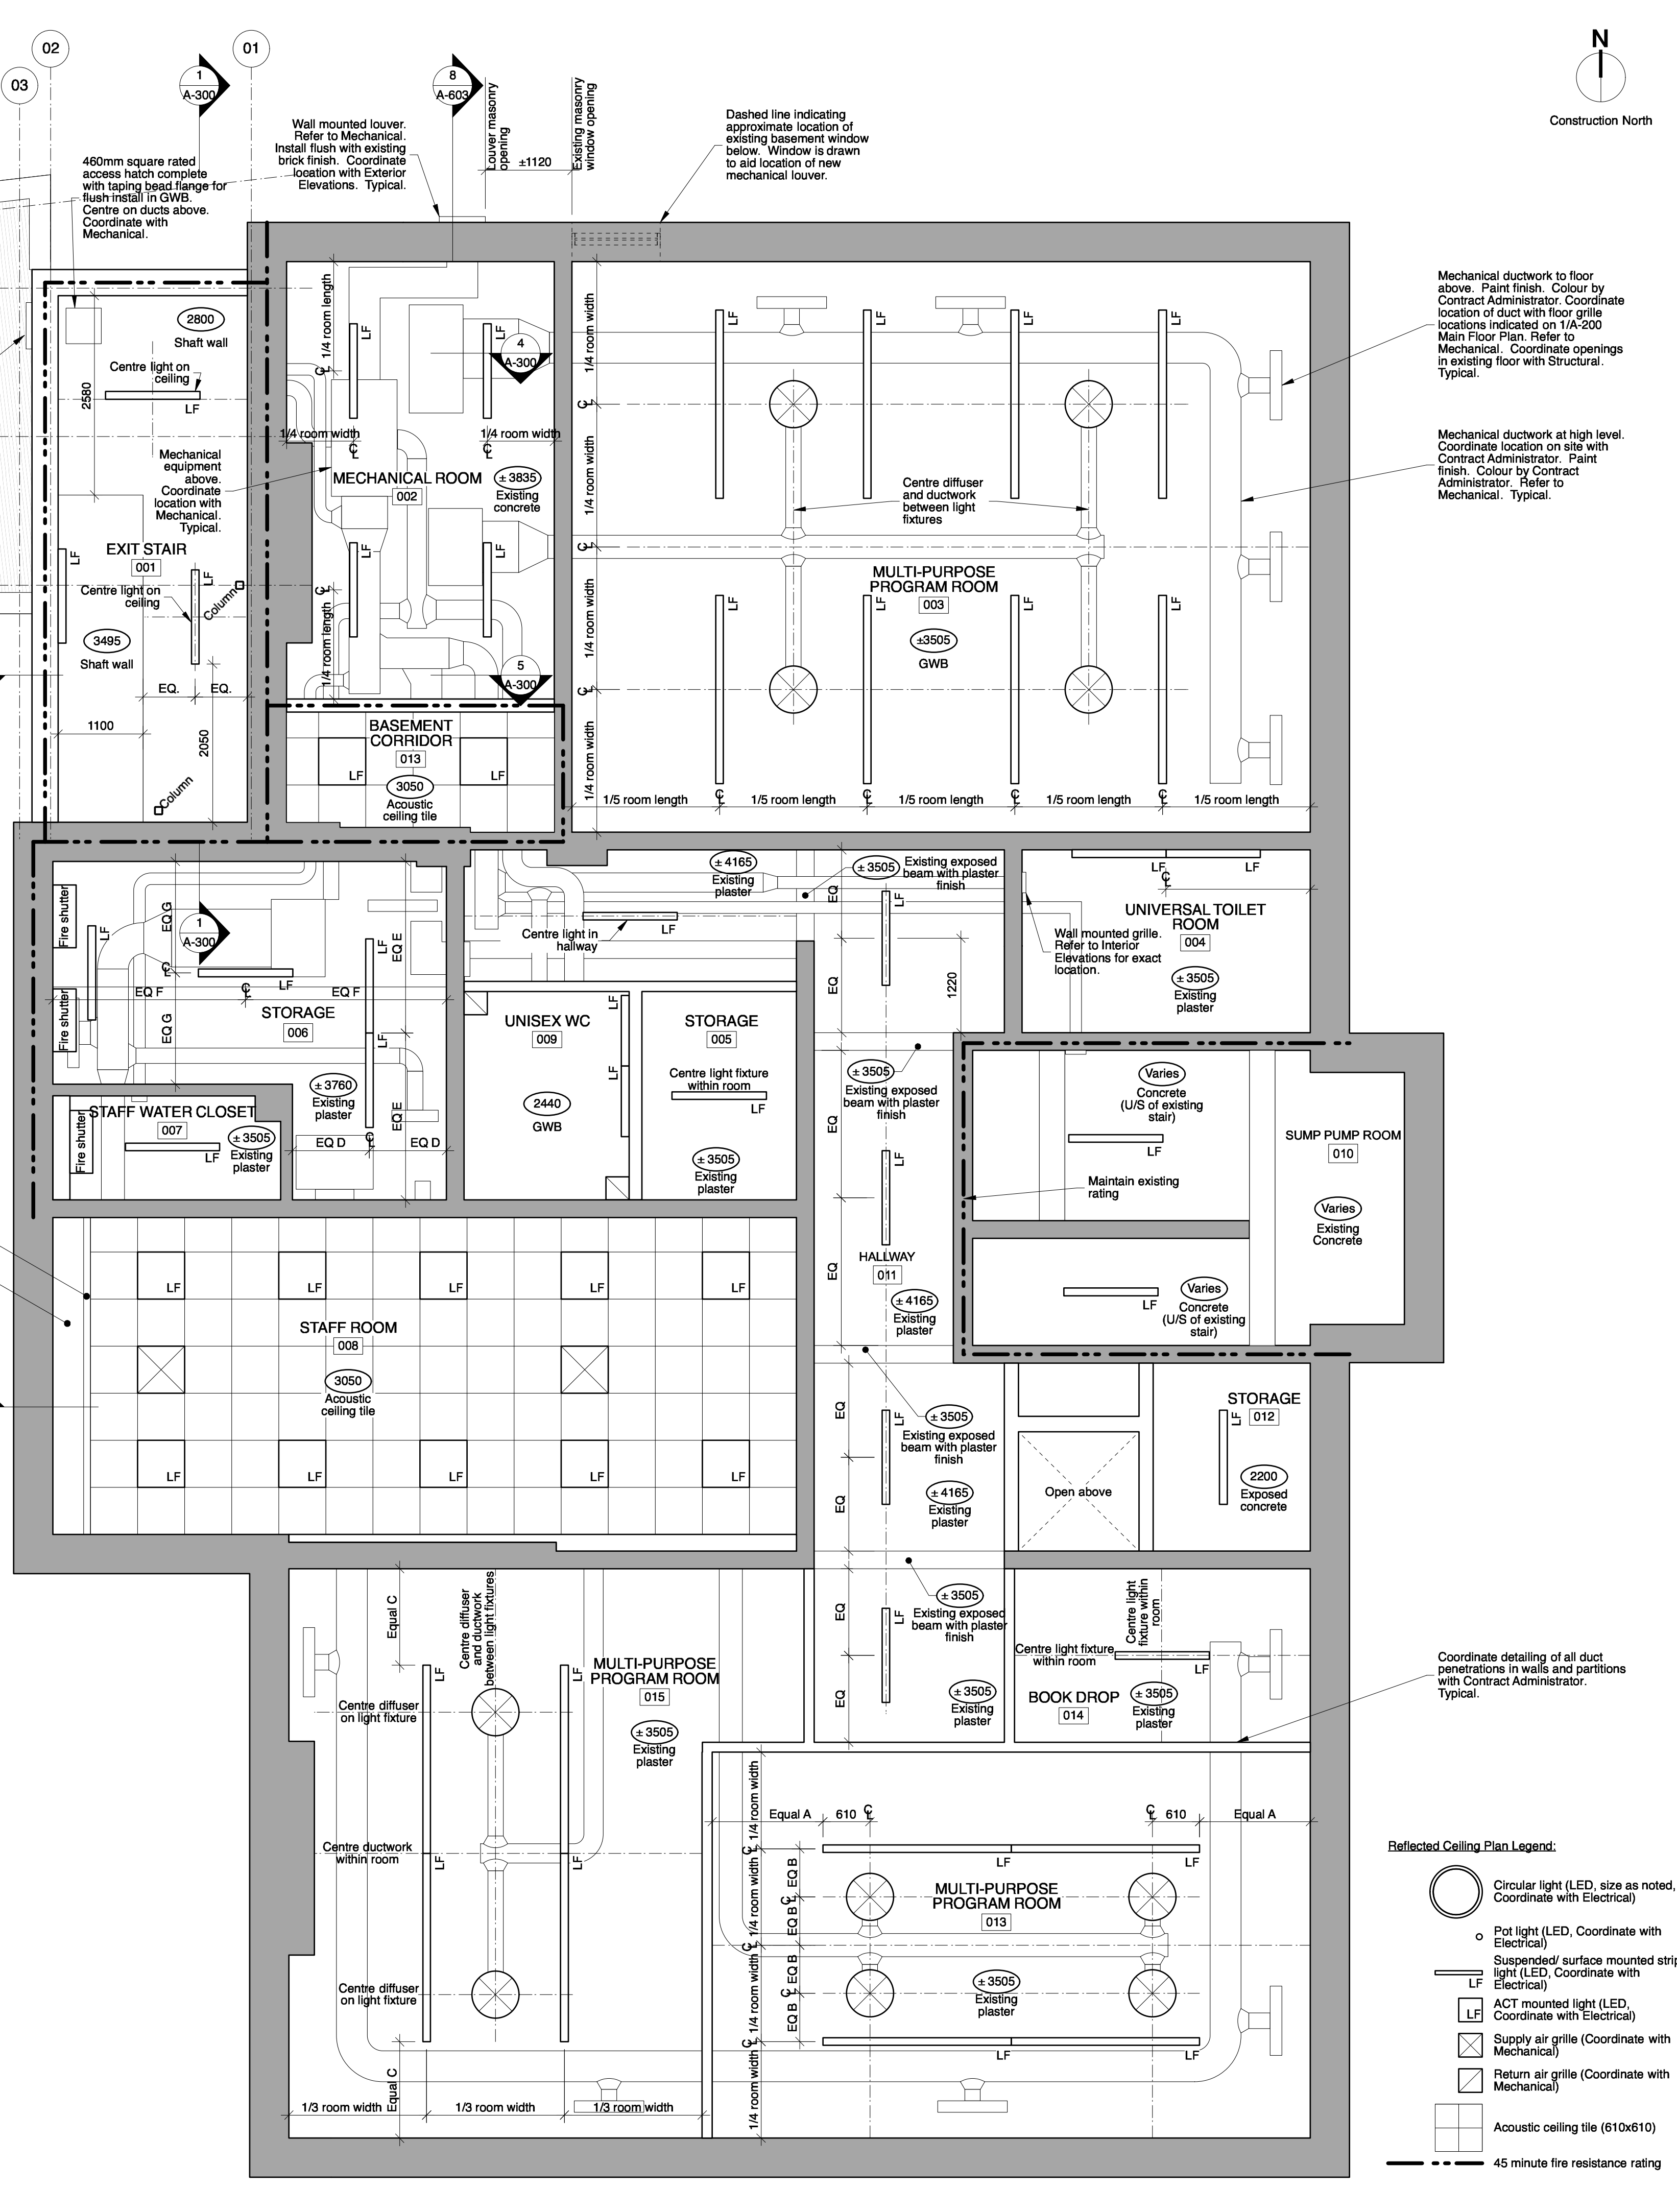

1 Basement Reflected Ceiling Plan
A-204 1:50

- Reflected Ceiling Plan Legend:**
- Circular light (LED, size as noted, Coordinate with Electrical)
 - Pot light (LED, Coordinate with Electrical)
 - Suspended/ surface mounted strip light (LED, Coordinate with Electrical)
 - ACT mounted light (LED, Coordinate with Electrical)
 - Supply air grille (Coordinate with Mechanical)
 - Return air grille (Coordinate with Mechanical)
 - Acoustic ceiling tile (610x610)
 - 45 minute fire resistance rating

This drawing must not be scaled. The contractor shall verify all dimensions and other data on site prior to commencement of work. Discrepancies, errors, and omissions are to be reported to Public City Architecture Inc. prior to proceeding with the Work.

Drawings and specifications as instruments of service are the property of Public City Architecture Inc. the copyright in the same being reserved.

No reproduction or revision to these drawings may be made without the permission of Public City Architecture Inc. and when made, must bear their name. All prints to be returned to Public City Architecture Inc. upon request.

Project
Cornish Library Renovation

Drawing
Reflected Ceiling Plan and Roof Plan

Drawn By
TH, MP

Reviewed By
PS

Scale
As noted

Drawing No.
A-204

Date
2016.10.06

Project No.
1503a

