

NOTE:
NOT ALL SYMBOLS SHOWN ON THIS LEGEND ARE NECESSARILY USED ON THIS PROJECT.

ELECTRICAL SYMBOL LEGEND



<p>LIGHTING</p> <p>LINEAR FLUORESCENT LUMINAIRE, TYPE 'A' AS SPECIFIED. HATCHING DENOTES CONNECTED TO EMERGENCY/NIGHT LIGHTING CIRCUIT</p> <p>CEILING MOUNTED LUMINAIRE, TYPE 'A' AS SPECIFIED</p> <p>WALL MOUNTED LUMINAIRE, TYPE 'A' AS SPECIFIED</p> <p>DOUBLE SURFACE MOUNTED EMERGENCY LIGHTING REMOTE HEADS, TYPE 'BU-1' INDICATES BATTERY BANK FED FROM</p> <p>EMERGENCY LIGHTING BATTERY UNIT C/W DUPLEX RECEPTACLE AND DOUBLE REMOTE HEADS, TYPE 'BU-1' AS SPECIFIED.</p> <p>WALL MOUNTED DOUBLE FACED EXIT LIGHT AND DIRECTIONAL ARROWS AS INDICATED. SHADED AREAS DENOTE DIRECTION OF FACE OF EXIT SIGN. 'BU-1' INDICATES BATTERY UNIT FED FROM.</p> <p>WALL MOUNTED SINGLE FACED EXIT LIGHT AND DIRECTIONAL ARROWS AS INDICATED. SHADED AREAS DENOTE DIRECTION OF FACE OF EXIT SIGN.</p> <p>CEILING MOUNTED SINGLE FACED EXIT LIGHT AND DIRECTIONAL ARROWS AS INDICATED. SHADED AREAS DENOTE DIRECTION OF FACE OF EXIT SIGN.</p> <p>COMBINATION CEILING MOUNTED SINGLE FACED EXIT LIGHT, DIRECTIONAL ARROWS & DOUBLE REMOTE HEAD AS INDICATED. SHADED AREAS DENOTE DIRECTION OF FACE OF EXIT SIGN.</p> <p>EQUIPMENT CONNECTIONS AND CONTROLS</p> <p>MOTORIZED DAMPER</p> <p>DIRECT CONNECTION - 120 OR 208V AS SPECIFIED</p> <p>MOTOR CONNECTION C/W UNFUSED DISCONNECT SWITCH</p> <p>POWER ACTIVATED DOOR EXIT BUTTON SUPPLIED BY DOOR HARDWARE SUPPLIER, WIRED BY ELECTRICAL</p> <p>RECESSED MOUNTED ELECTRICAL PANEL - 'SP' DENOTES PANEL DESIGNATION</p> <p>SURFACE MOUNTED ELECTRICAL PANEL - 'SP' DENOTES PANEL DESIGNATION</p> <p>LIGHTING CONTROL</p> <p>ONE, TWO AND THREE GANG SINGLE POLE TOGGLE SWITCHES</p> <p>SWITCH MOUNTED OCCUPANCY SENSOR, TYPE 'A' AS SPECIFIED</p> <p>CEILING MOUNTED OCCUPANCY SENSOR, TYPE 'A' AS SPECIFIED</p> <p>DIMMER SWITCH, TYPE 'A' AS SPECIFIED</p> <p>SECURITY AND ACCESS SYSTEMS</p> <p>MOTION DETECTING CAMERA</p> <p>DOOR CONTACT</p> <p>HOLD OPEN</p> <p>MOTION DETECTOR</p>	<p>FIRE ALARM SYSTEM</p> <p>PULL STATION</p> <p>HORN STROBE</p> <p>AUTOMATIC COMBINATION FIXED TEMPERATURE/RATE OF RISE HEAT DETECTOR - CEILING MOUNTED</p> <p>AUTOMATIC FIXED TEMPERATURE HEAT DETECTOR - CEILING MOUNTED</p> <p>SMOKE DETECTOR - CEILING MOUNTED</p> <p>GENERAL POWER</p> <p>15A, U-GROUND DUPLEX RECEPTACLE</p> <p>15A, U-GROUND DUPLEX RECEPTACLE C/W GROUND FAULT CIRCUIT INTERRUPTER - MOUNTED ABOVE COUNTER</p> <p>(5-20R) T-SLOT U-GROUND DUPLEX RECEPTACLE C/W GROUND FAULT CIRCUIT INTERRUPTER</p> <p>15A, U-GROUND DUPLEX RECEPTACLE - FLUSH FLOOR MOUNTED UNLESS NOTED OTHERWISE</p> <p>MISCELLANEOUS</p> <p>INDICATES EXISTING DEVICE TO REMAIN</p> <p>INDICATES EXISTING DEVICE TO BE MOVED</p> <p>INDICATES EXISTING DEVICE IN RELOCATED POSITION</p> <p>INDICATES EXISTING DEVICE TO BE DEMOLISHED</p> <p>INDICATES CONDUIT</p> <p>ELECTRICAL DRAWING NOTES</p> <p>COMBINATION VOICE/DATA OUTLET - WALL MOUNTED</p> <p>TELEPHONE OUTLET - FLUSH FLOOR MOUNTED</p> <p>DATA OUTLET - WALL MOUNTED</p> <p>DATA OUTLET - FLUSH CEILING MOUNTED UNLESS NOTED OTHERWISE</p> <p>ELECTRIC HEATING</p> <p>ELECTRIC FORCE FLOW HEATER, TYPE 'AKW' AS SPECIFIED</p>
---	--

ELECTRICAL DRAWING LIST

E1.0	ELECTRICAL SYMBOL LEGEND & DRAWING LIST
ED2.0	BASEMENT - ELECTRICAL DEMOLITION LAYOUT
ED2.1	MAIN FLOOR - ELECTRICAL DEMOLITION LAYOUT
EL2.0	BASEMENT - ELECTRICAL LIGHTING RENOVATION LAYOUT
EL2.1	MAIN FLOOR - ELECTRICAL LIGHTING RENOVATION LAYOUT
EP2.0	BASEMENT - ELECTRICAL POWER & SYSTEMS RENOVATION LAYOUT
EP2.1	MAIN FLOOR - ELECTRICAL POWER & SYSTEMS RENOVATION LAYOUT
E5.0	PANELBOARD SCHEDULES
ME1.1	ME SCHEDULES

ABBREVIATIONS

AFF	- ABOVE FINISHED FLOOR	MIC	- MICROWAVE
AFG	- ABOVE FINISHED GRADE	MV	- EXISTING TO BE MOVED
BB	- BASEBOARD HEATER	MW	- MOUNTED IN MILLWORK
BU	- BATTERY UNIT	NIC	- NOT IN CONTRACT
CH	- CHILDPROOF	NL	- NIGHT LIGHT
CP	- COPY MACHINE	NTS	- NOT TO SCALE
CSTE	- CUSTOMER SERVICE TERMINATION ENCLOSURE	PA	- PUBLIC ADDRESS
D	- DELETE	PR	- PRINTER
E	- EXISTING	QP	- QUAD PLEX
FA	- FIRE ALARM	R	- RELOCATE(D)
FC	- FAN COIL (WHEN USED WITH MOTOR SYMBOL)	RL	- REPLACE WITH NEW
FF	- FORCE FLOW	TYP	- TYPICAL
FR	- FRIDGE	UC	- UNDER COUNTER
FX	- FAX MACHINE	WG	- WIRE GUARD
MD	- MAIN DISTRIBUTION	WP	- WEATHERPROOF
MFC	- MULTI-FUNCTION COPIER	WTP	- WATERPROOF
NTS	- NOT TO SCALE	USB	- DUPLEX REC. C/W USB CHARGER

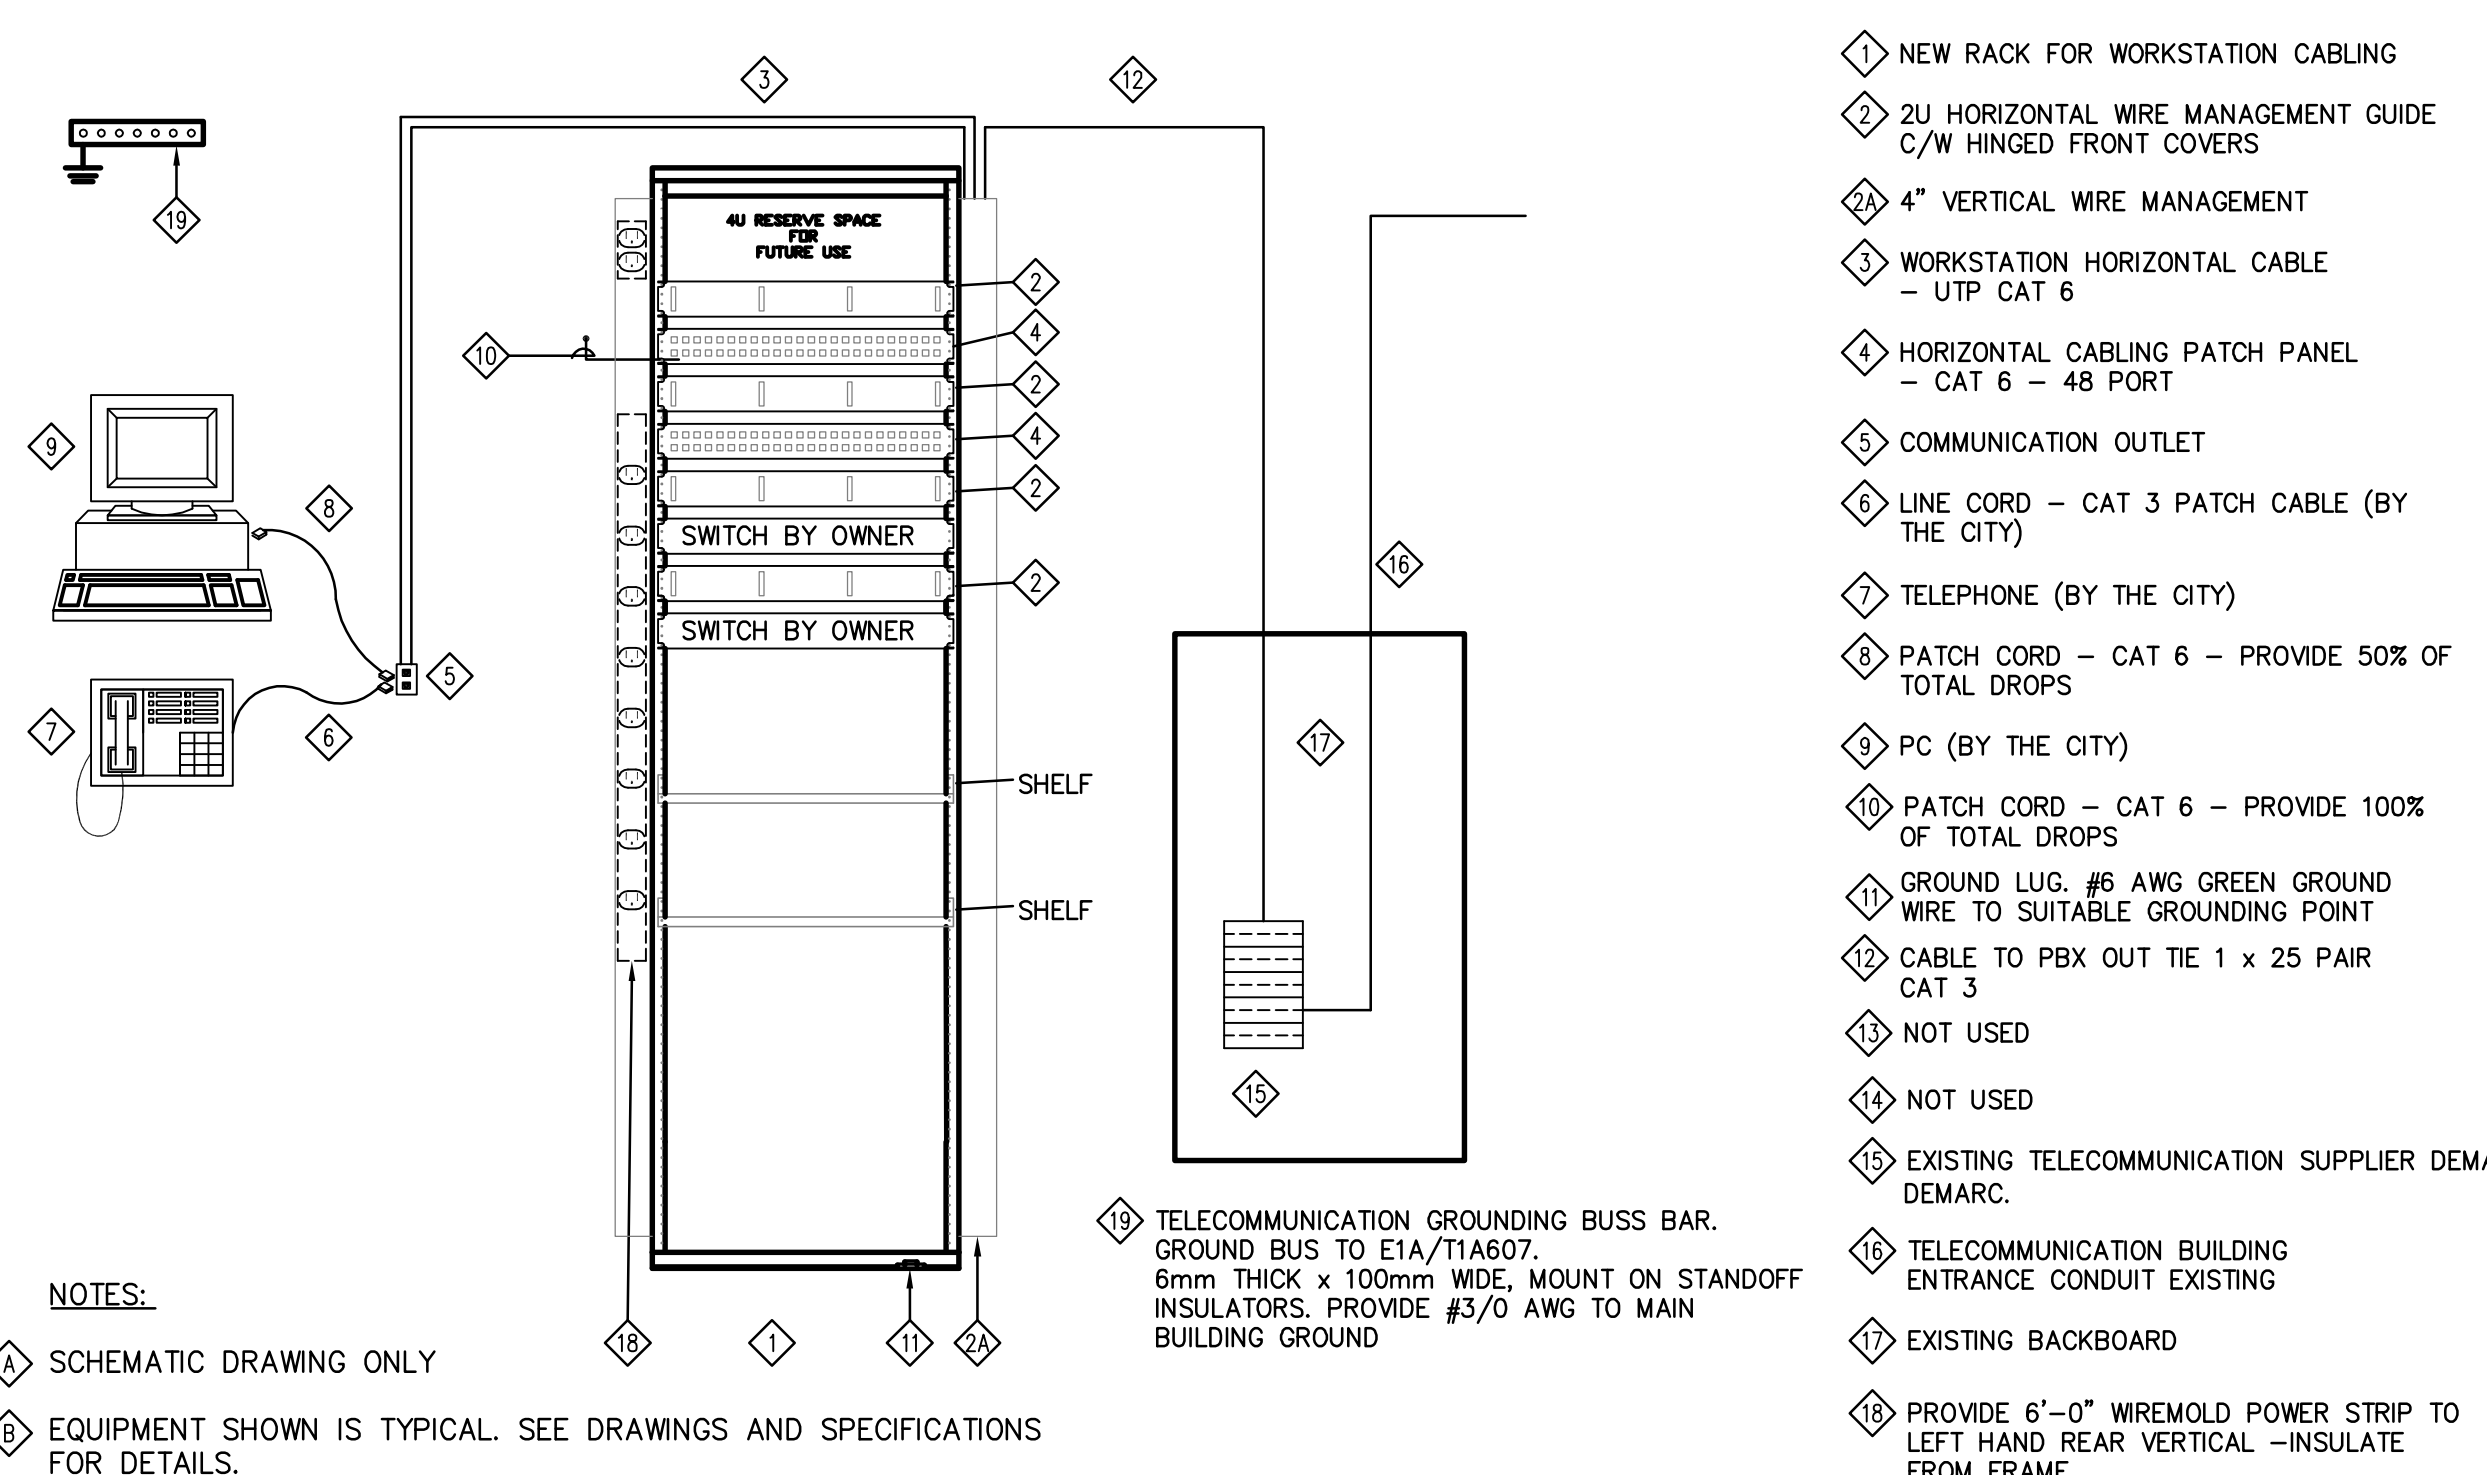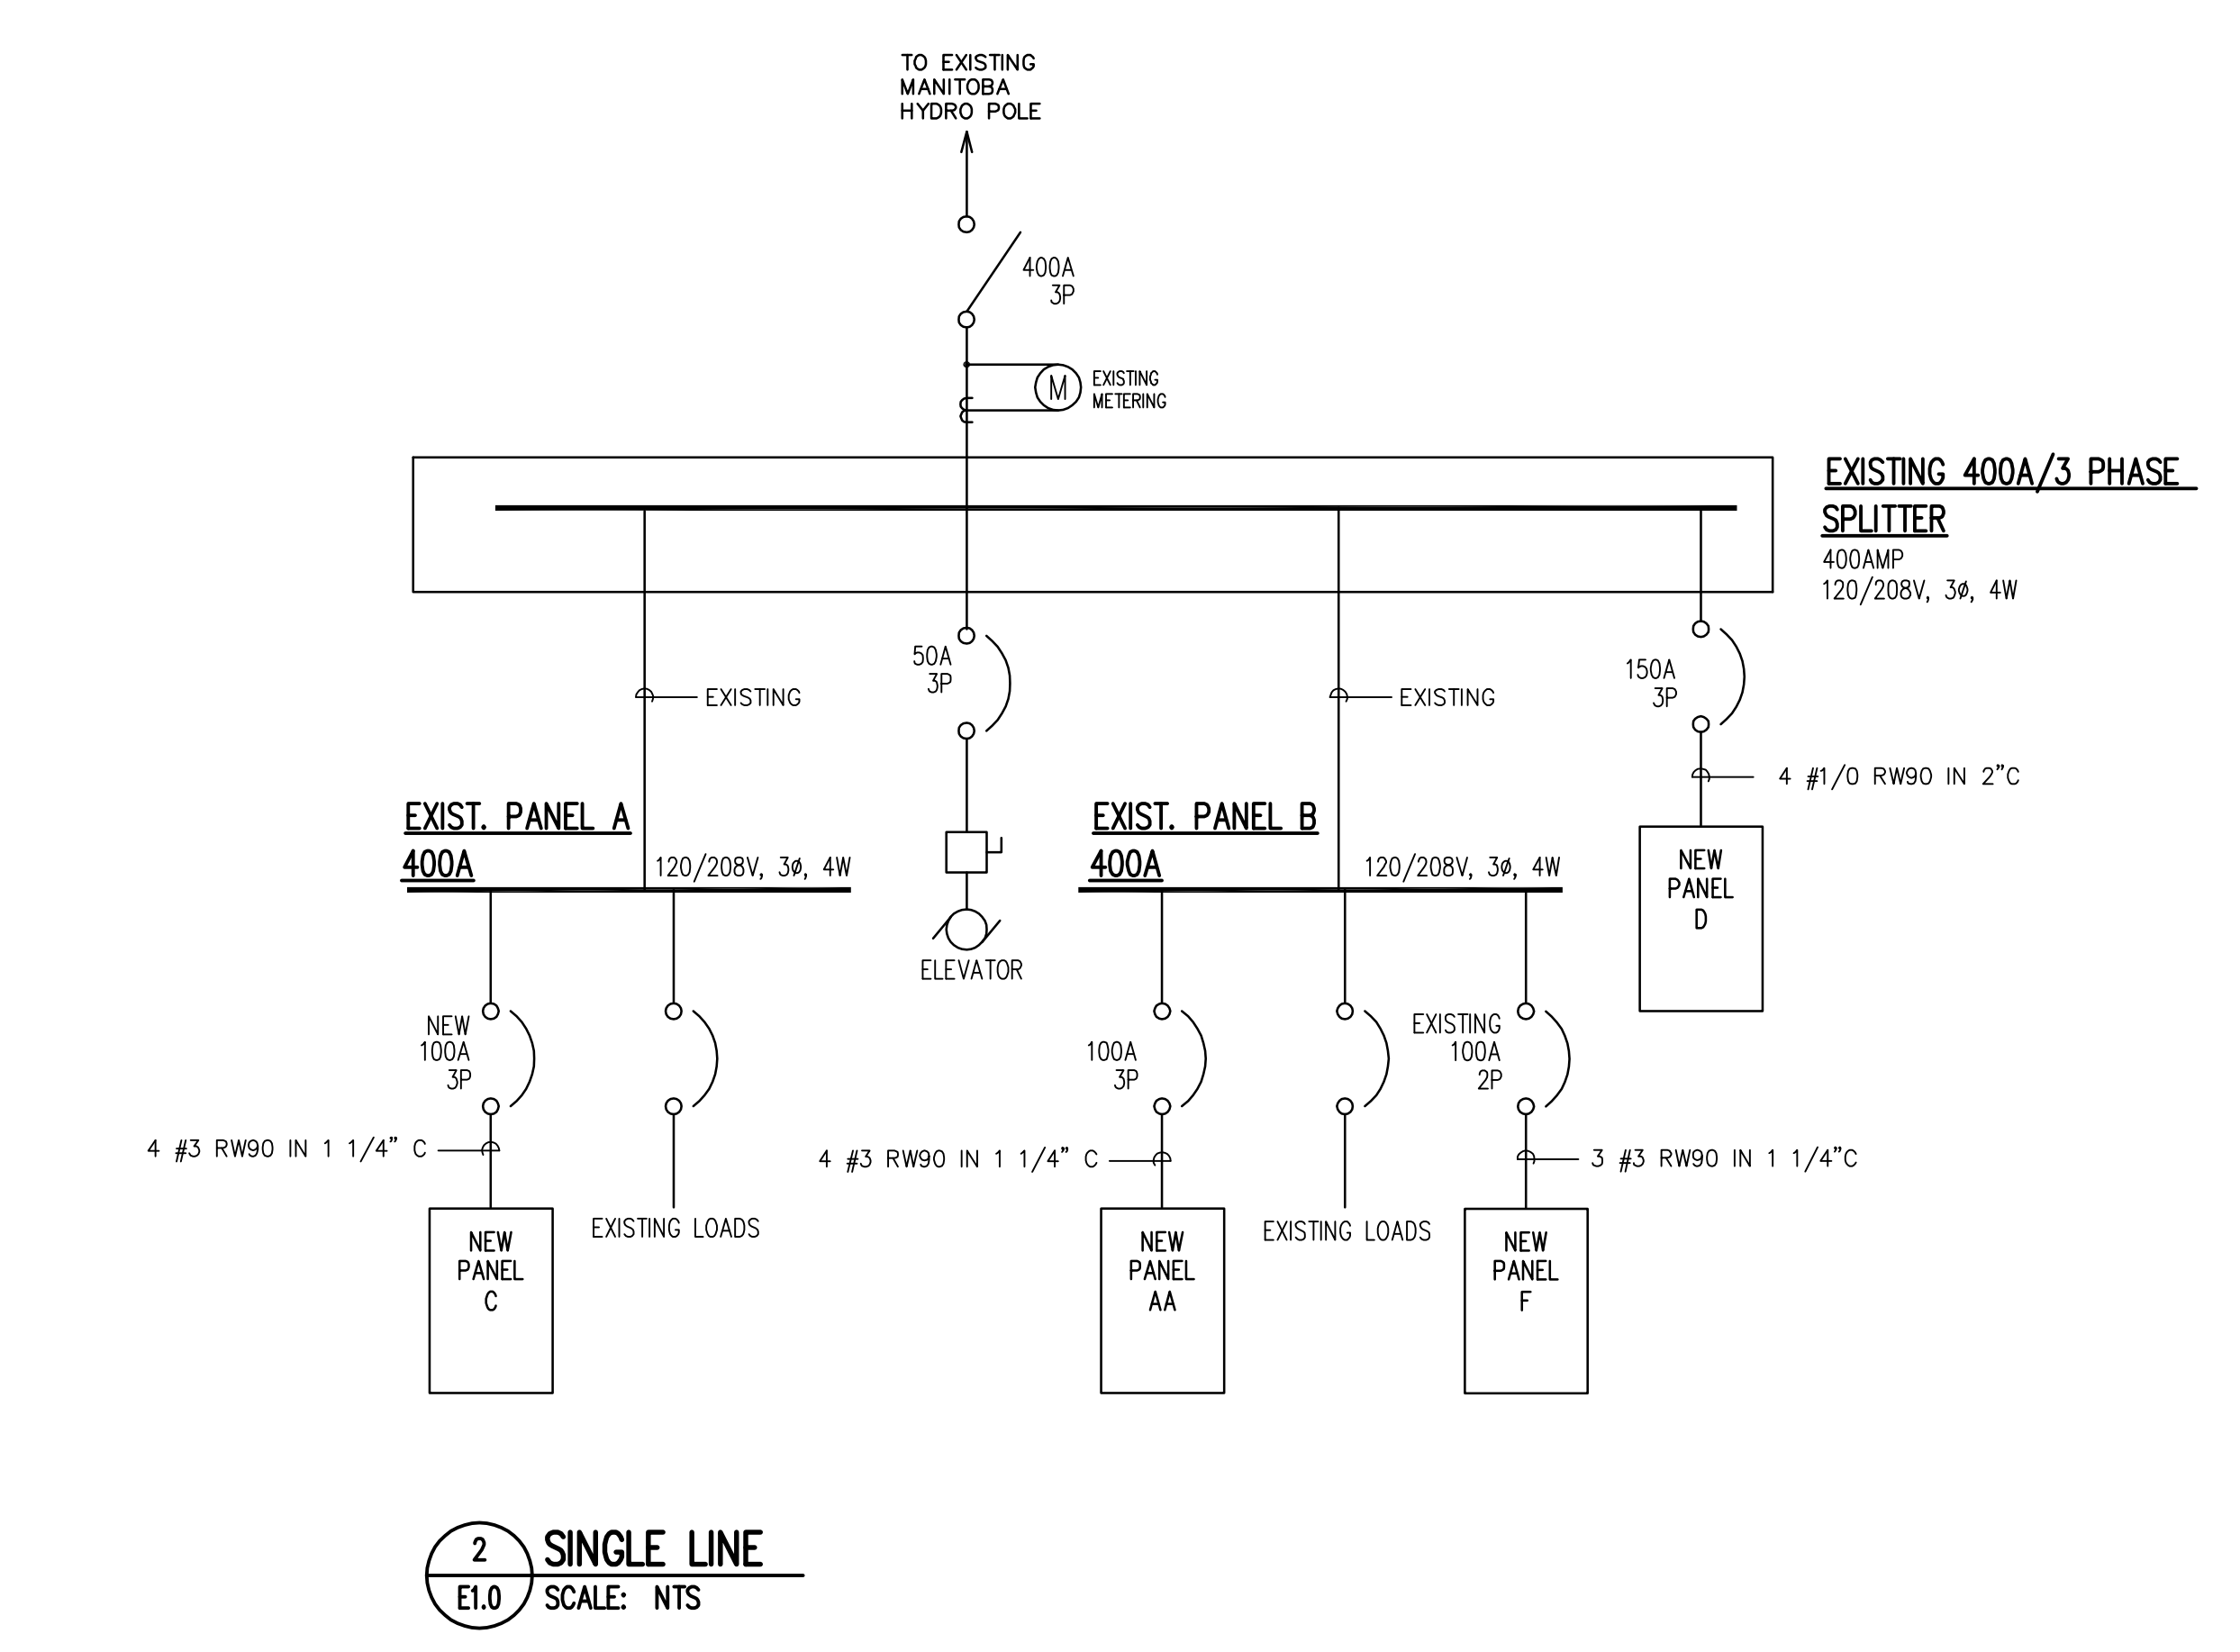

1 DATA RACK DETAIL SCALE: NTS