
 
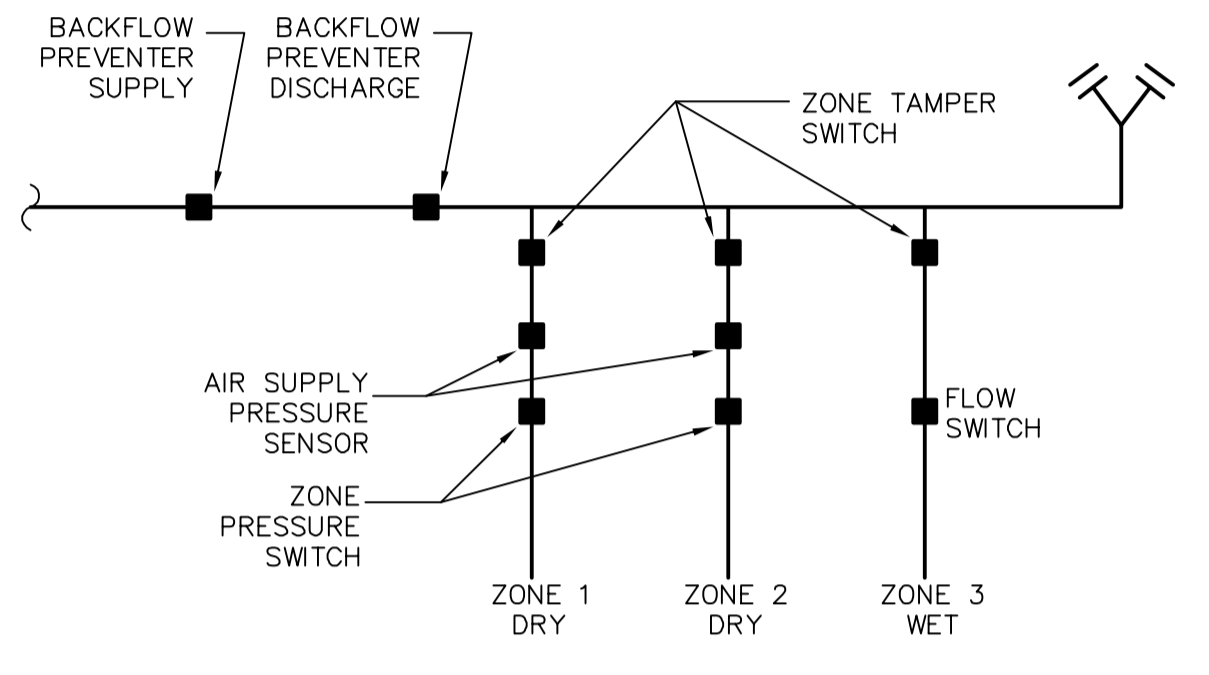


- FIRE ALARM DRAWING NOTES**
1. PROVIDE 100% HORN AND STROBE COVERAGE FOR AUDIBLE AND VISUAL INDICATION.
  2. PROVIDE MANUAL PULL STATIONS AT ALL EXTERIOR EGRESS DOORS.
  3. PROVIDE SIGNAL ISOLATORS AT FIRE SEPARATIONS.
  4. PROVIDE BREAKER AND ELECTRICAL CONNECTIONS FOR AIR COMPRESSOR.



**2** WATERMAIN RISER DIAGRAM

**1** FIRE ALARM PART PLAN A  
WEST GARAGE  
1 : 100

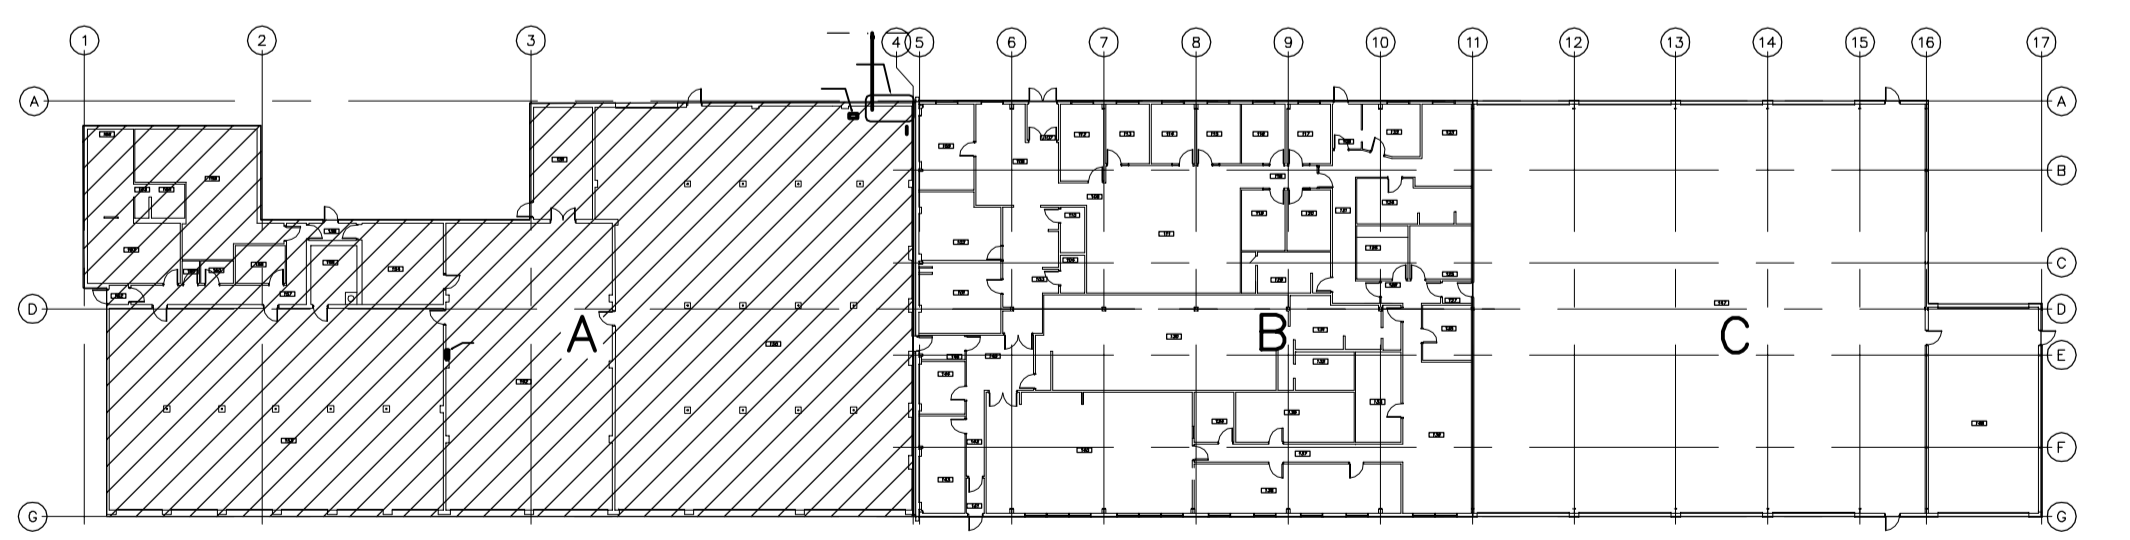


**METRIC**  
WHOLE NUMBERS INDICATE MILLIMETRES  
DECIMALIZED NUMBERS INDICATE METRES



LOCATION APPROVED UNDERGROUND STRUCTURES		B.M. ELEV.
SUPV. U/G STRUCTURES COMMITTEE	DATE	
NOTE:	LOCATION OF UNDERGROUND STRUCTURES AS SHOWN ARE BASED ON THE BEST INFORMATION AVAILABLE BUT NO GUARANTEE IS GIVEN THAT ALL EXISTING UTILITIES ARE SHOWN OR THAT THE GIVEN LOCATIONS ARE EXACT. CONFIRMATION OF EXISTENCE AND EXACT LOCATION OF ALL SERVICES MUST BE OBTAINED FROM THE INDIVIDUAL UTILITIES BEFORE PROCEEDING WITH CONSTRUCTION.	

NO.	REVISIONS	DATE	BY
1	ISSUED FOR BID OP 1077-2018	19/01/10	BLM

DESIGNED BY	BKB	CHECKED BY	BLM
DRAWN BY	SCK	APPROVED BY	
SCALE:	HORIZONTAL AS NOTED		
VERTICAL	RELEASED FOR CONSTRUCTION		
DATE	2019 01 10	DATE	

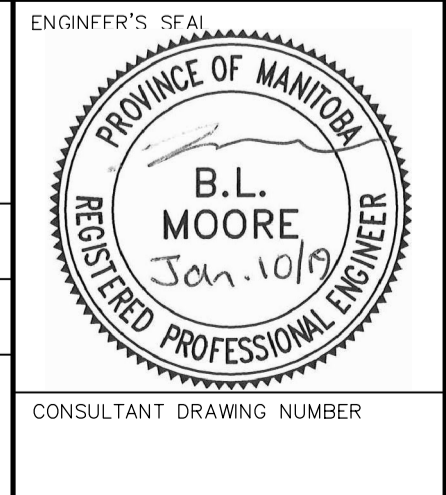

**THE CITY OF WINNIPEG**  
WATER AND WASTE DEPARTMENT  
ENGINEERING DIVISION

552 PLINGUET AVENUE  
FIRE PROTECTION UPGRADES  
BUILDING - 552 NORTH  
PART PLAN A - WEST GARAGE  
FIRE ALARM SYSTEM

SHEET 7 OF 18  
CITY DRAWING NUMBER  
1-0702N-M0006-001