


BESEMENT - AUDIO SYSTEM LAYOUT
 SCALE: 1/16"=1'-0"

NOTES:

- THESE DRAWINGS SHALL NOT BE SCALED.
- THE CONTRACTOR SHALL VISIT THE SITE AND SATISFY ONESELF ALL DIMENSIONS, DATUM, AND DETAILED INFORMATION SHOWN ARE CORRECT.
- THE CONTRACTOR IS TO REVIEW AND COORDINATE ALL ARCHITECTURAL, MECHANICAL, ELECTRICAL AND STRUCTURAL DRAWINGS FOR ADDITIONAL OPENINGS THROUGH FLOORS, WALLS, AND CEILINGS FOR DUCT, PIPE & ELECTRICAL RISERS AND ALL OPENINGS NOT SHOWN ON DRAWINGS.
- ALL OPENINGS THROUGH FIRE ASSEMBLIES ARE TO BE FIRE STOPPED AND SEALED WITH ULC APPROVED FIRE STOPPING TO MAINTAIN THE INTEGRITY OF THE FIRE SEPARATION, AND PROVIDE A SMOKE-TIGHT BARRIER.
- ALL PRODUCTS AND MATERIALS TO BE USED AND INSTALLED SHALL CONFORM WITH MANUFACTURER'S SPECIFICATIONS & APPLICABLE CODES.
- THE CONTRACTOR SHALL BE RESPONSIBLE TO PATCH AND MAKE GOOD ALL EXISTING CONSTRUCTION AFFECTED BY THE REMOVAL OF ALL ITEMS FORMING THE PART OF THE RENOVATION WORK.
- WHERE PAINTING OF EXISTING WALLS IS INDICATED, THESE WALLS MUST BE CLEANED OF ANY EXISTING WALL COVERING, PATCHED & PREPARED TO ACCEPT NEW MATERIAL, UNLESS OTHERWISE NOTED.
- CONTRACTOR WILL PROVIDE TEMPORARY SIGNAGE TO RESTRICT ACCESS TO MAIN POOL AREAS AT MAIN DOORS.

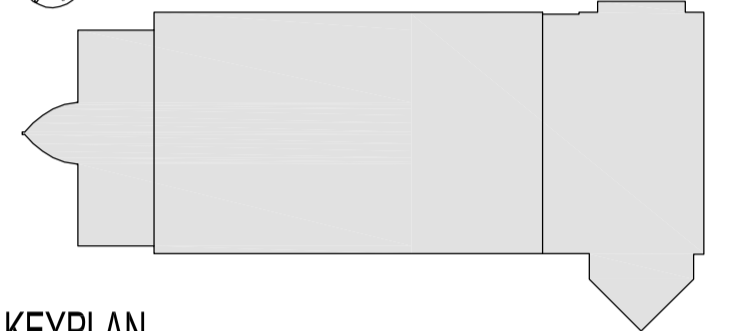

KEYPLAN

SCALE: N.T.S.

GENERAL NOTES

1. EXISTING P.A. SYSTEM SPEAKERS AND ASSOCIATED UNUSED WIRING TO BE REMOVED, UNLESS OTHERWISE NOTED.
2. COORDINATE EXACT LOCATIONS OF SPEAKERS WITH LIGHTING AND ARCHITECTURAL ELEMENTS. CONFIRM EXACT LOCATIONS PRIOR TO ROUGHAN.

No.	REVISION/DESCRIPTION	BY	DATE
3	ISSUED FOR TENDER / CONSTRUCTION		HPC/CTS 18.06.13
2	ISSUED FOR 99% REVIEW		HPC/CTS 18.05.31
1	ISSUED FOR 66% REVIEW		HPC/CTS 18.05.01

SEAL			
------	--	--	--

**ENGINEERS
 GEOSCIENTISTS
 MANITOBA**
 Certificate of Authorization
 Stantec Consulting Ltd.
 No. 1301



DRAWN	HPC	CHECKED	DESIGNED	LK	APPROVED
DATE	2018.03.23	USER	APPROVAL		

THE CITY OF WINNIPEG
 PLANNING, PROPERTY AND
 DEVELOPMENT DEPARTMENT
 MUNICIPAL ACCOMMODATIONS DIVISION
 3-65 GARRY STREET, R3C 4K4

PROJECT
 PAN-AM POOL
 CEILING RENOVATION
 BID OPPORTUNITY No. 178-2018
 25 POSEIDON BAY, WINNIPEG, MB

SHEET TITLE
 BASEMENT -
 AUDIO SYSTEM LAYOUT

SCALE	PROJECT No:	SHEET No:
AS SHOWN	2017-033	E1