


FIRST FLOOR - AUDIO SYSTEM LAYOUT - PART B
SCALE: 1/16"=1'-0"

NOTES:

- THESE DRAWINGS SHALL NOT BE SCALED.
- THE CONTRACTOR SHALL VISIT THE SITE AND SATISFY ONESELF ALL DIMENSIONS, DATUM, AND DETAILED INFORMATION SHOWN ARE CORRECT.
- THE CONTRACTOR IS TO REVIEW AND COORDINATE ALL ARCHITECTURAL, MECHANICAL, ELECTRICAL AND STRUCTURAL DRAWINGS FOR ADDITIONAL OPENINGS THROUGH FLOORS, WALLS, AND CEILINGS FOR DUCT, PIPE & ELECTRICAL RISERS AND ALL OPENINGS NOT SHOWN ON DRAWINGS.
- ALL OPENINGS THROUGH FIRE ASSEMBLIES ARE TO BE FIRE STOPPED AND SEALED WITH ULC APPROVED FIRE STOPPING TO MAINTAIN THE INTEGRITY OF THE FIRE SEPARATION, AND PROVIDE A SMOKE-TIGHT BARRIER.
- ALL PRODUCTS AND MATERIALS TO BE USED AND INSTALLED SHALL CONFORM WITH MANUFACTURER'S SPECIFICATIONS & APPLICABLE CODES.
- THE CONTRACTOR SHALL BE RESPONSIBLE TO PATCH AND MAKE GOOD ALL EXISTING CONSTRUCTION AFFECTED BY THE REMOVAL OF ALL ITEMS FORMING THE PART OF THE RENOVATION WORK.
- WHERE PAINTING OF EXISTING WALLS IS INDICATED, THESE WALLS MUST BE CLEANED OF ANY EXISTING WALL COVERING, PATCHED & PREPARED TO ACCEPT NEW MATERIAL, UNLESS OTHERWISE NOTED.
- CONTRACTOR WILL PROVIDE TEMPORARY SIGNAGE TO RESTRICT ACCESS TO MAIN POOL AREAS AT MAIN DOORS.

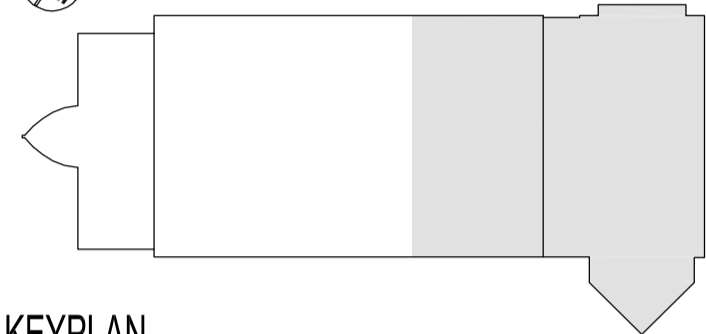

KEYPLAN

SCALE: N.T.S.

GENERAL NOTES

1. EXISTING P.A. SYSTEM SPEAKERS AND ASSOCIATED UNUSED WIRING TO BE REMOVED, UNLESS OTHERWISE NOTED.
2. COORDINATE EXACT LOCATIONS OF SPEAKERS WITH LIGHTING AND ARCHITECTURAL ELEMENTS. CONFIRM EXACT LOCATIONS PRIOR TO ROUGH-IN.

No.	REVISION/DESCRIPTION	BY	DATE
3	ISSUED FOR TENDER / CONSTRUCTION		HPCO/TS 18.06.13
2	ISSUED FOR 99% REVIEW		HPCO/TS 18.05.31
1	ISSUED FOR 66% REVIEW		HPCO/TS 18.05.01

No.	REVISION/DESCRIPTION	BY	DATE

SEAL

**ENGINEERS
GEOLOGISTS
MANITOBA**

Certificate of Authorization
Stantec Consulting Ltd.
No. 1301

PROVINCE OF MANITOBA

18.06.13

L. KORENBAUM

Member

10389

REGISTERED PROFESSIONAL ENGINEER

DRAWN	HPCO	CHECKED	DESIGNED	LK	APPROVED
DATE	2018.03.23	USER	APPROVAL		

THE CITY OF WINNIPEG
PLANNING, PROPERTY AND
DEVELOPMENT DEPARTMENT
MUNICIPAL ACCOMMODATIONS DIVISION
3-65 GARRY STREET, R3C 4K4

PROJECT
PAN-AM POOL
CEILING RENOVATION
BID OPPORTUNITY No. 178-2018
25 POSEIDON BAY, WINNIPEG, MB

SHEET TITLE
FIRST FLOOR -
AUDIO SYSTEM LAYOUT
PART B

SCALE	PROJECT No:	SHEET No:
AS SHOWN	2017-033	E3