

**NOTES:**

THESE DRAWINGS SHALL NOT BE SCALED.

THE CONTRACTOR SHALL VISIT THE SITE AND SATISFY ONESELF ALL DIMENSIONS, DATUM, AND DETAILED INFORMATION SHOWN ARE CORRECT.

THE CONTRACTOR IS TO REVIEW AND COORDINATE ALL ARCHITECTURAL, MECHANICAL, ELECTRICAL AND STRUCTURAL DRAWINGS FOR ADDITIONAL OPENINGS THROUGH FLOORS, WALLS, AND CEILINGS FOR DUCT, PIPE & ELECTRICAL RISERS AND ALL OPENINGS NOT SHOWN ON DRAWINGS.

ALL OPENINGS THROUGH THE FIRE SEPARATIONS AS A RESULT OF THE WORK OF THIS CONTRACT ARE TO BE FIRE STOPPED AND SEALED WITH ULC APPROVED FIRE STOPPING TO MAINTAIN THE INTEGRITY OF THE FIRE SEPARATION, AND PROVIDE AND SMOKE-TIGHT BARRIER.

ALL PRODUCTS AND MATERIALS TO BE USED AND INSTALLED SHALL CONFORM WITH MANUFACTURER'S SPECIFICATIONS & APPLICABLE CODES.

THE CONTRACTOR SHALL BE RESPONSIBLE TO PATCH AND MAKE GOOD ALL EXISTING CONSTRUCTION AFFECTED BY THE REMOVAL OF ALL ITEMS FORMING THE PART OF THE RENOVATION WORK.


WHERE NEW FLOORING AND BASE IS TO BE INSTALLED IN EXISTING AREAS (REFER TO FLOOR PLAN AND ROOM SCHEDULE) THE EXISTING FLOORING SURFACE AND BASE MUST BE REMOVED, UNLESS OTHERWISE NOTED. ALL FLOOR SURFACES SHALL BE PREPARED IN ACCORDANCE TO MANUFACTURER'S RECOMMENDATIONS FOR INSTALLATION OF NEW FLOOR.

WHERE PAINTING OF EXISTING WALLS IS INDICATED ON THE ROOM SCHEDULE, THESE WALLS MUST BE CLEANED OF ANY EXISTING WALL COVERING, PATCHED & PREPARED TO ACCEPT NEW MATERIAL, UNLESS OTHERWISE NOTED.

**GENERAL NOTES:**


- NOT ALL LOADS ARE SHOWN ON THE SINGLE LINE DIAGRAM.

- KEYNOTES:**
- DISCONNECT AND REMOVE ALL CONDUIT, WIRING, CONNECTORS AND ELECTRICAL EQUIPMENT FOR RTU-1, RTU-2 AND GLYCOL CIRC. PUMP BACK TO THE CIRCUIT BREAKERS IN DISTRIBUTION 'B'.
  - PROVIDE NEW LISTED CIRCUIT BREAKERS IN THE EXISTING WESTINGHOUSE PANEL BOARD AS INDICATED CW LISTED MOUNTING HARDWARE.
  - PROVIDE NEW STARTERS FOR PUMPS P-1A AND P-1B.
  - PROVIDE NEW ELECTRICAL CONNECTIONS INCLUDING CONDUIT, WIRING AND DISCONNECT SWITCHES FOR THE NEW MECHANICAL EQUIPMENT.
  - PROVIDE NEW MCC BUCKETS CW MCP, OVERLOADS, CONTACTORS, HOA, PILOT LIGHTS AND DISCONNECT SWITCH FOR PUMPS P-3A AND P-3B.

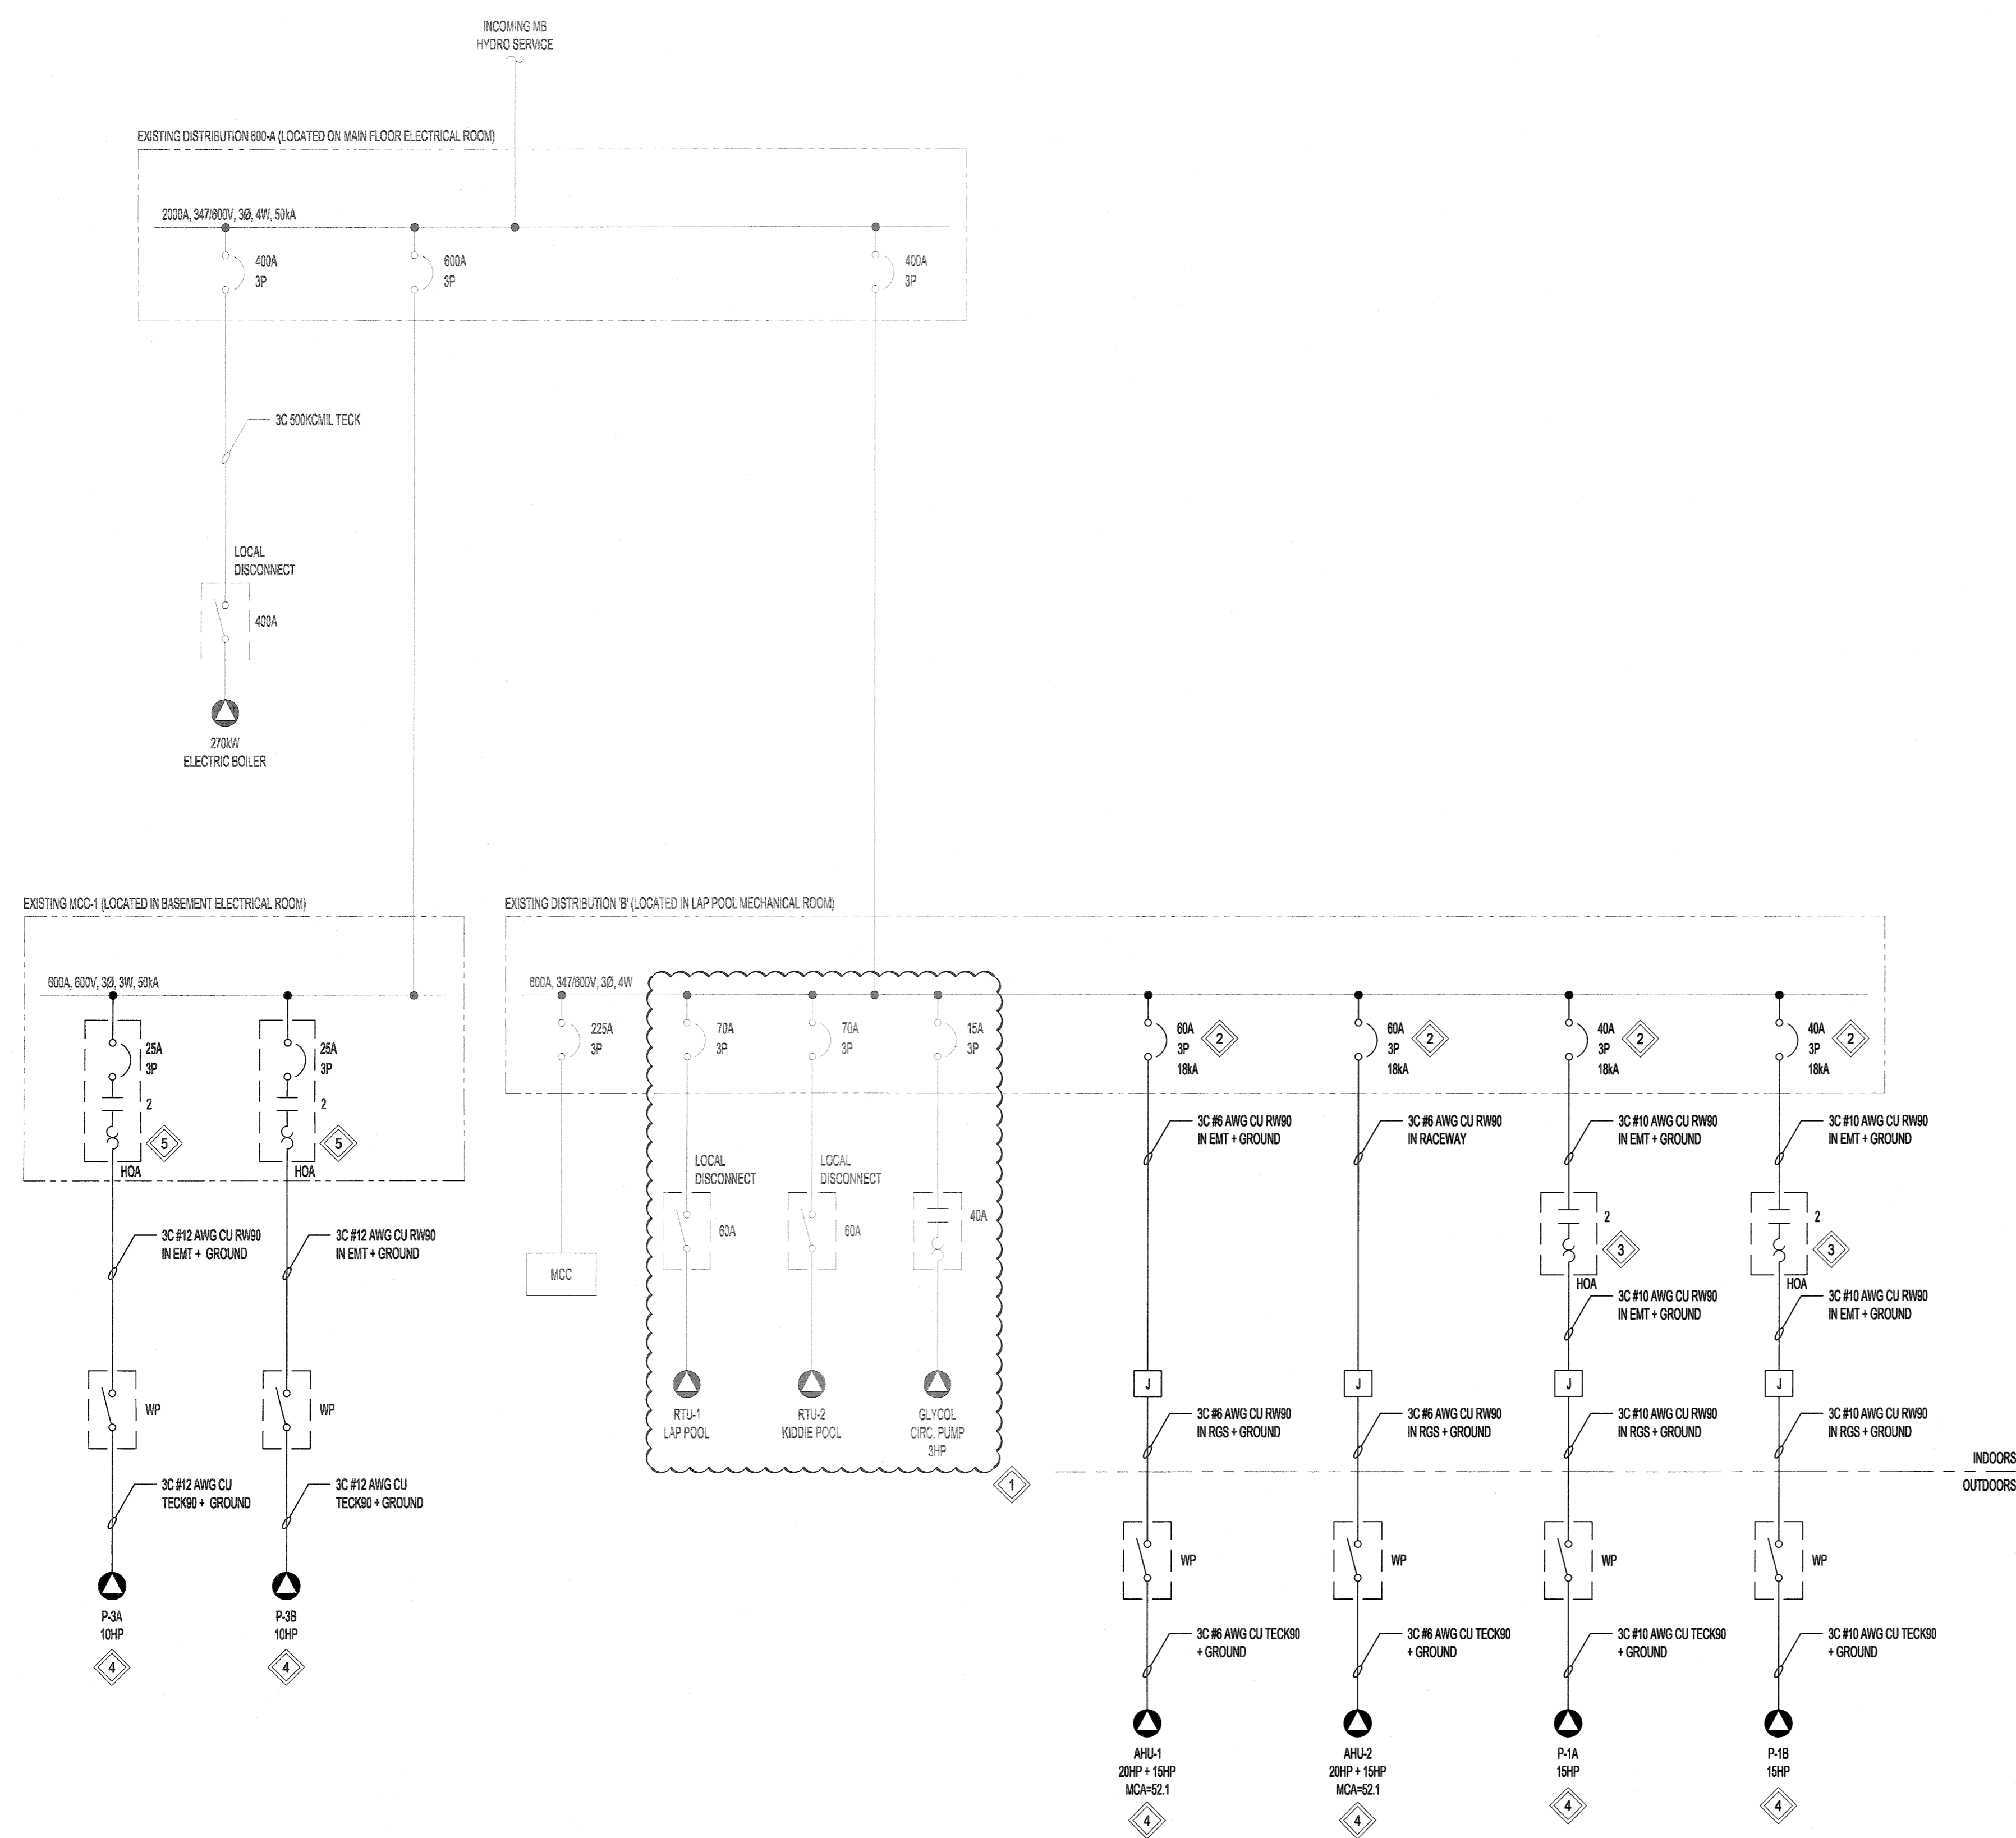

**SINGLE LINE DIAGRAM**  
SCALE: N.T.S.

No.	REVISION/DESCRIPTION	BY	DATE
0	ISSUED FOR TENDER	C.L.S.	18.03.08

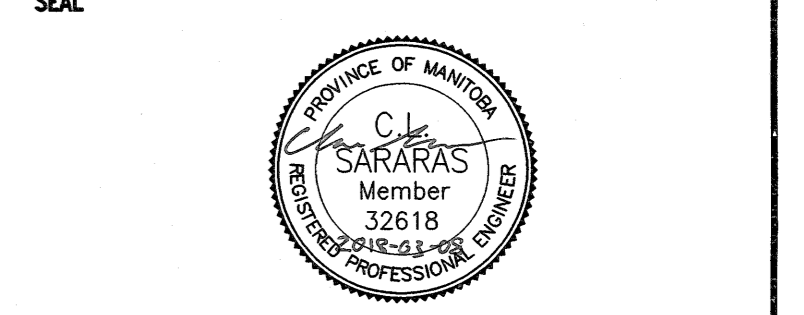

DRAWN	CHECKED	DESIGNED	APPROVED
	CS		C.L.S.

THE CITY OF WINNIPEG  
PLANNING, PROPERTY AND  
DEVELOPMENT DEPARTMENT  
MUNICIPAL ACCOMMODATIONS DIVISION  
3-65 GARRY STREET, R3C 4K4

PROJECT  
**REPLACEMENT OF ROOF TOP UNITS  
SERVING LAP POOL  
AT PAN AM POOL  
25 POSEIDON BAY**

SHEET TITLE  
**ELECTRICAL  
SINGLE LINE DIAGRAM**

SCALE	PROJECT No:	SHEET No:
AS SHOWN	17-0107-023	E02

