



# THE CITY OF WINNIPEG


PUBLIC WORKS DEPARTMENT

## PAN AM POOL MAIN POOL PUMPS AND MOTOR CONTROL CENTRE UPGRADES

BID OPPORTUNITY No. 247-2018

SHEET NO.	DRAWING NO.	DRAWING TITLE
1 of 5	00	COVER
2 of 5	M-101	MECHANICAL - BASEMENT LEVEL BOILER ROOM
3 of 5	E-101	ELECTRICAL - BASEMENT LEVEL BOILER ROOM
4 of 5	E-102	ELECTRICAL - SINGLE LINE DIAGRAM
5 of 5	E-103	ELECTRICAL - CONTROL SCHEMATIC

CITY DRAWING NO.
247-2018_DRAWING_COVER-R0.PDF
247-2018_DRAWING_M-101-R0.PDF
247-2018_DRAWING_E-101-R0.PDF
247-2018_DRAWING_E-102-R0.PDF
247-2018_DRAWING_E-103-R0.PDF

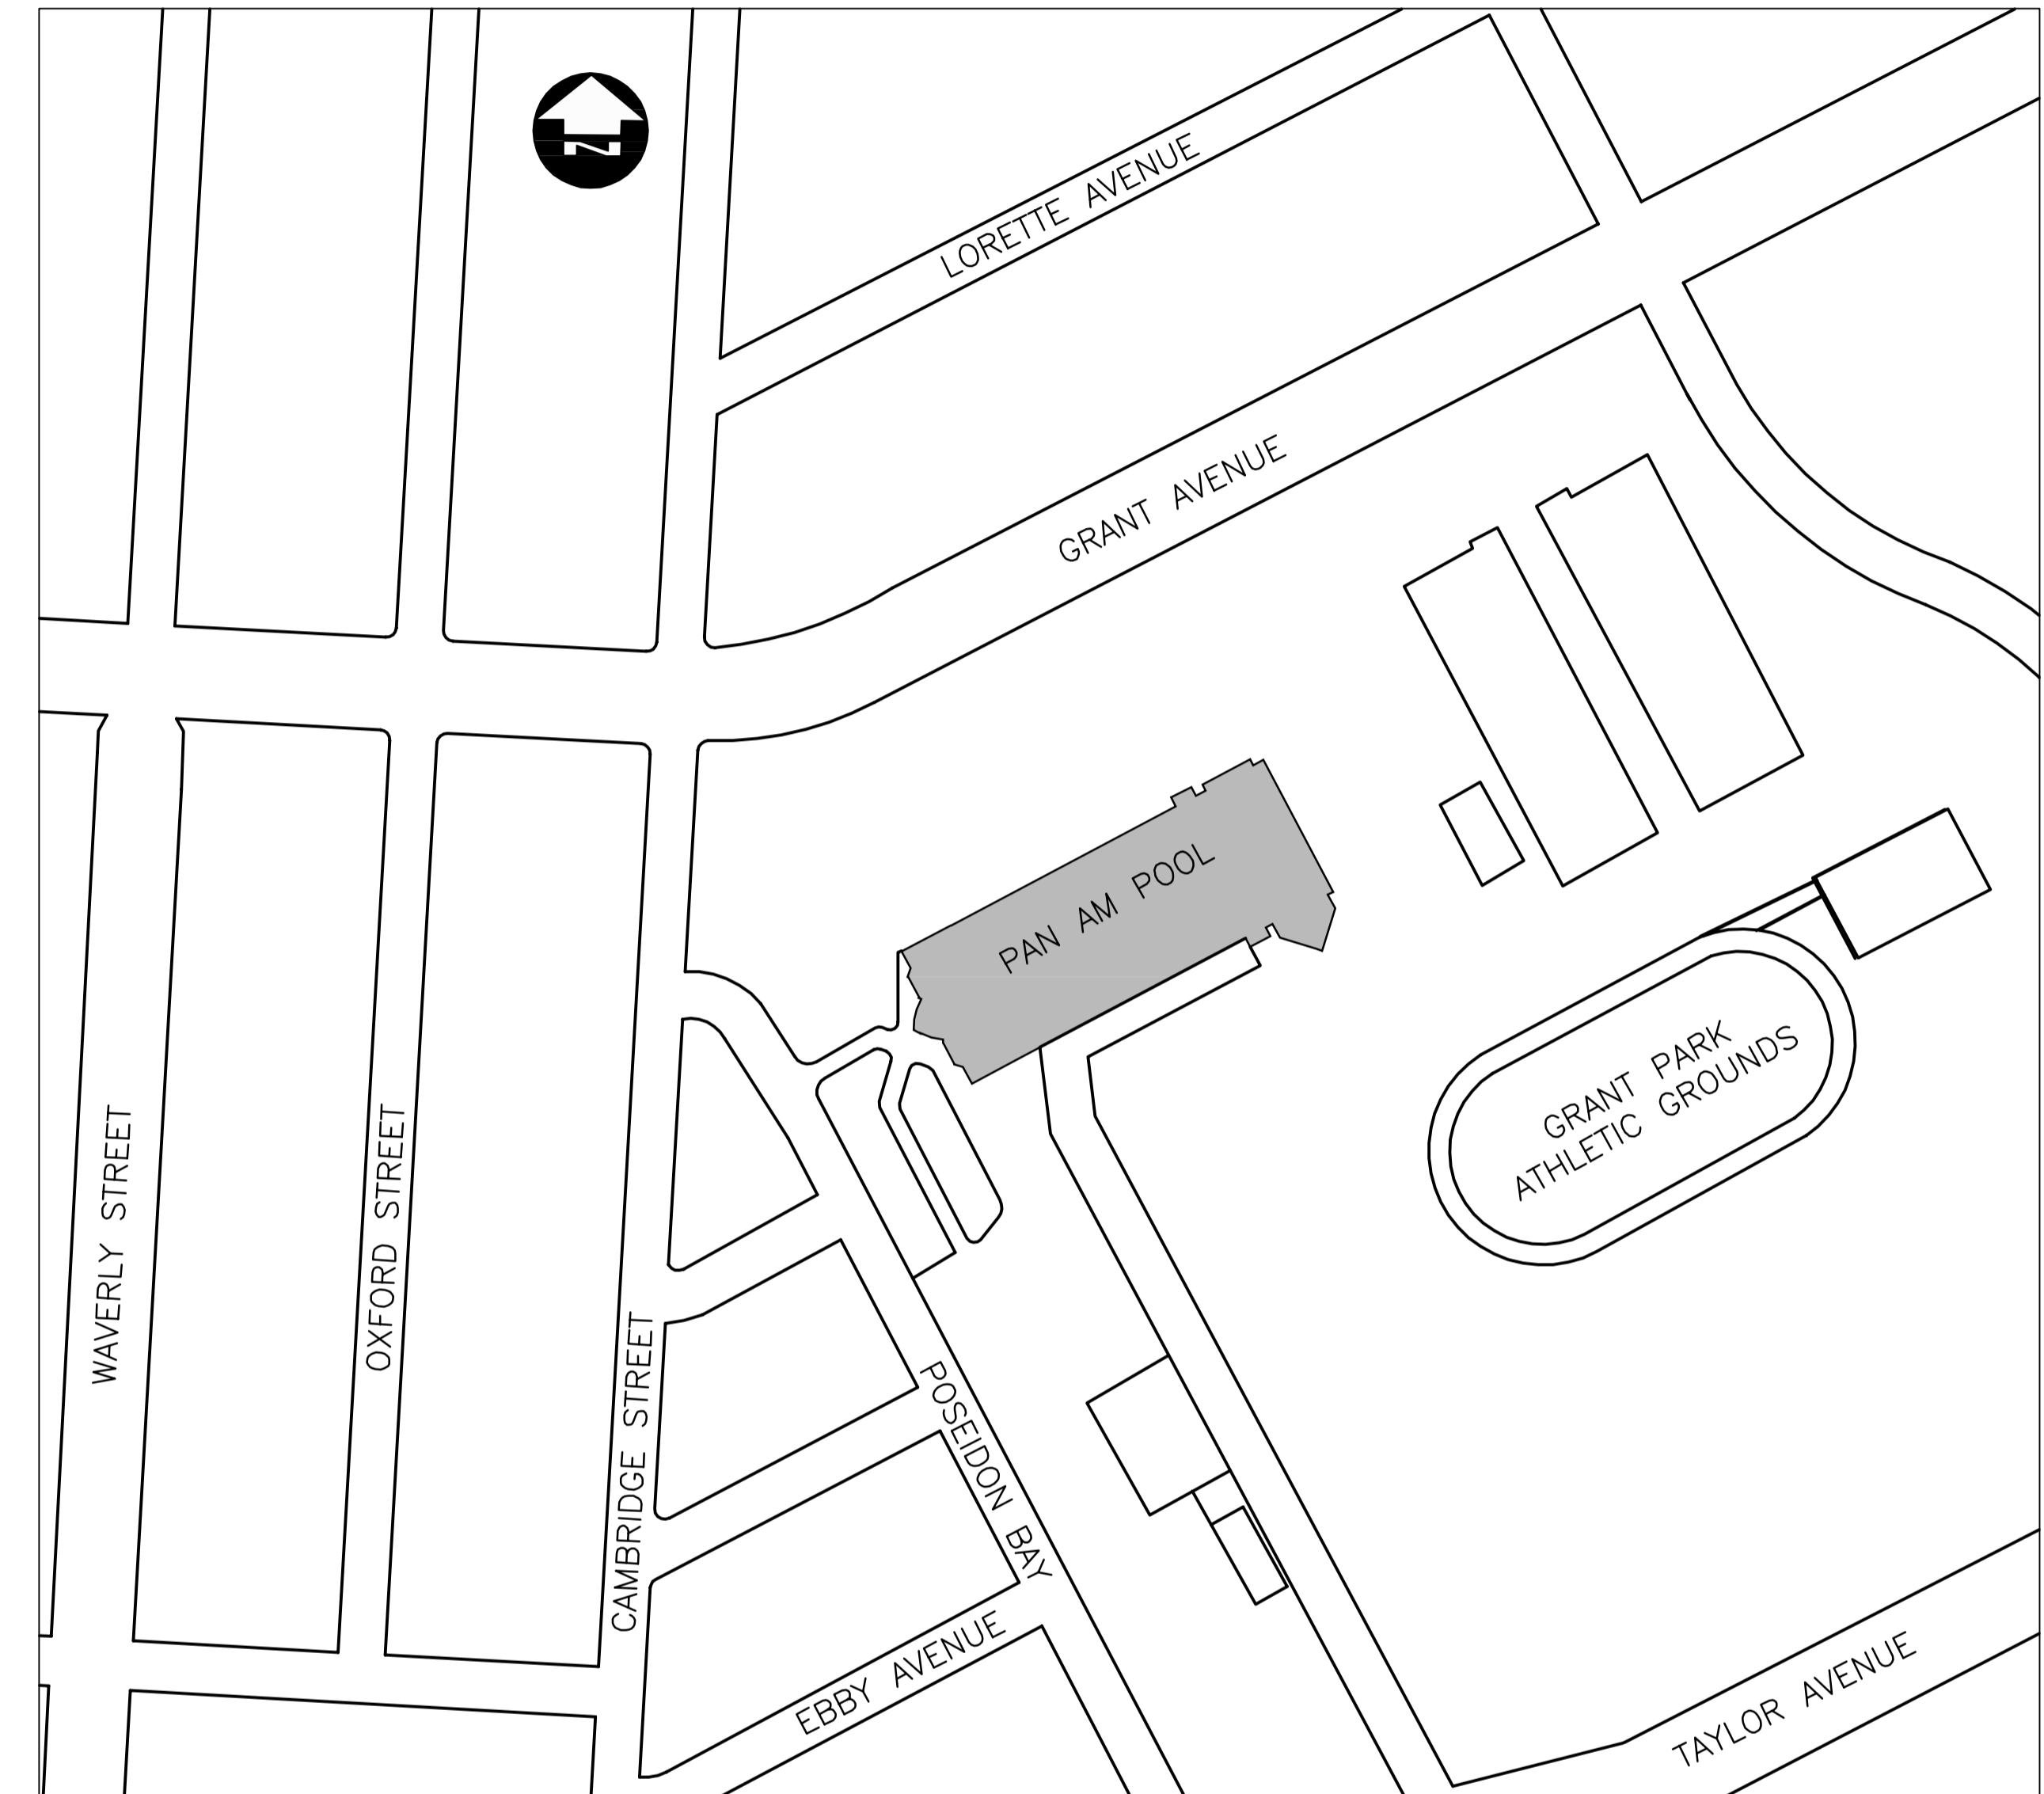

RELEASED FOR CONSTRUCTION

DATE

SET NO. \_\_\_\_\_