



EXISTING HYDRO POLE

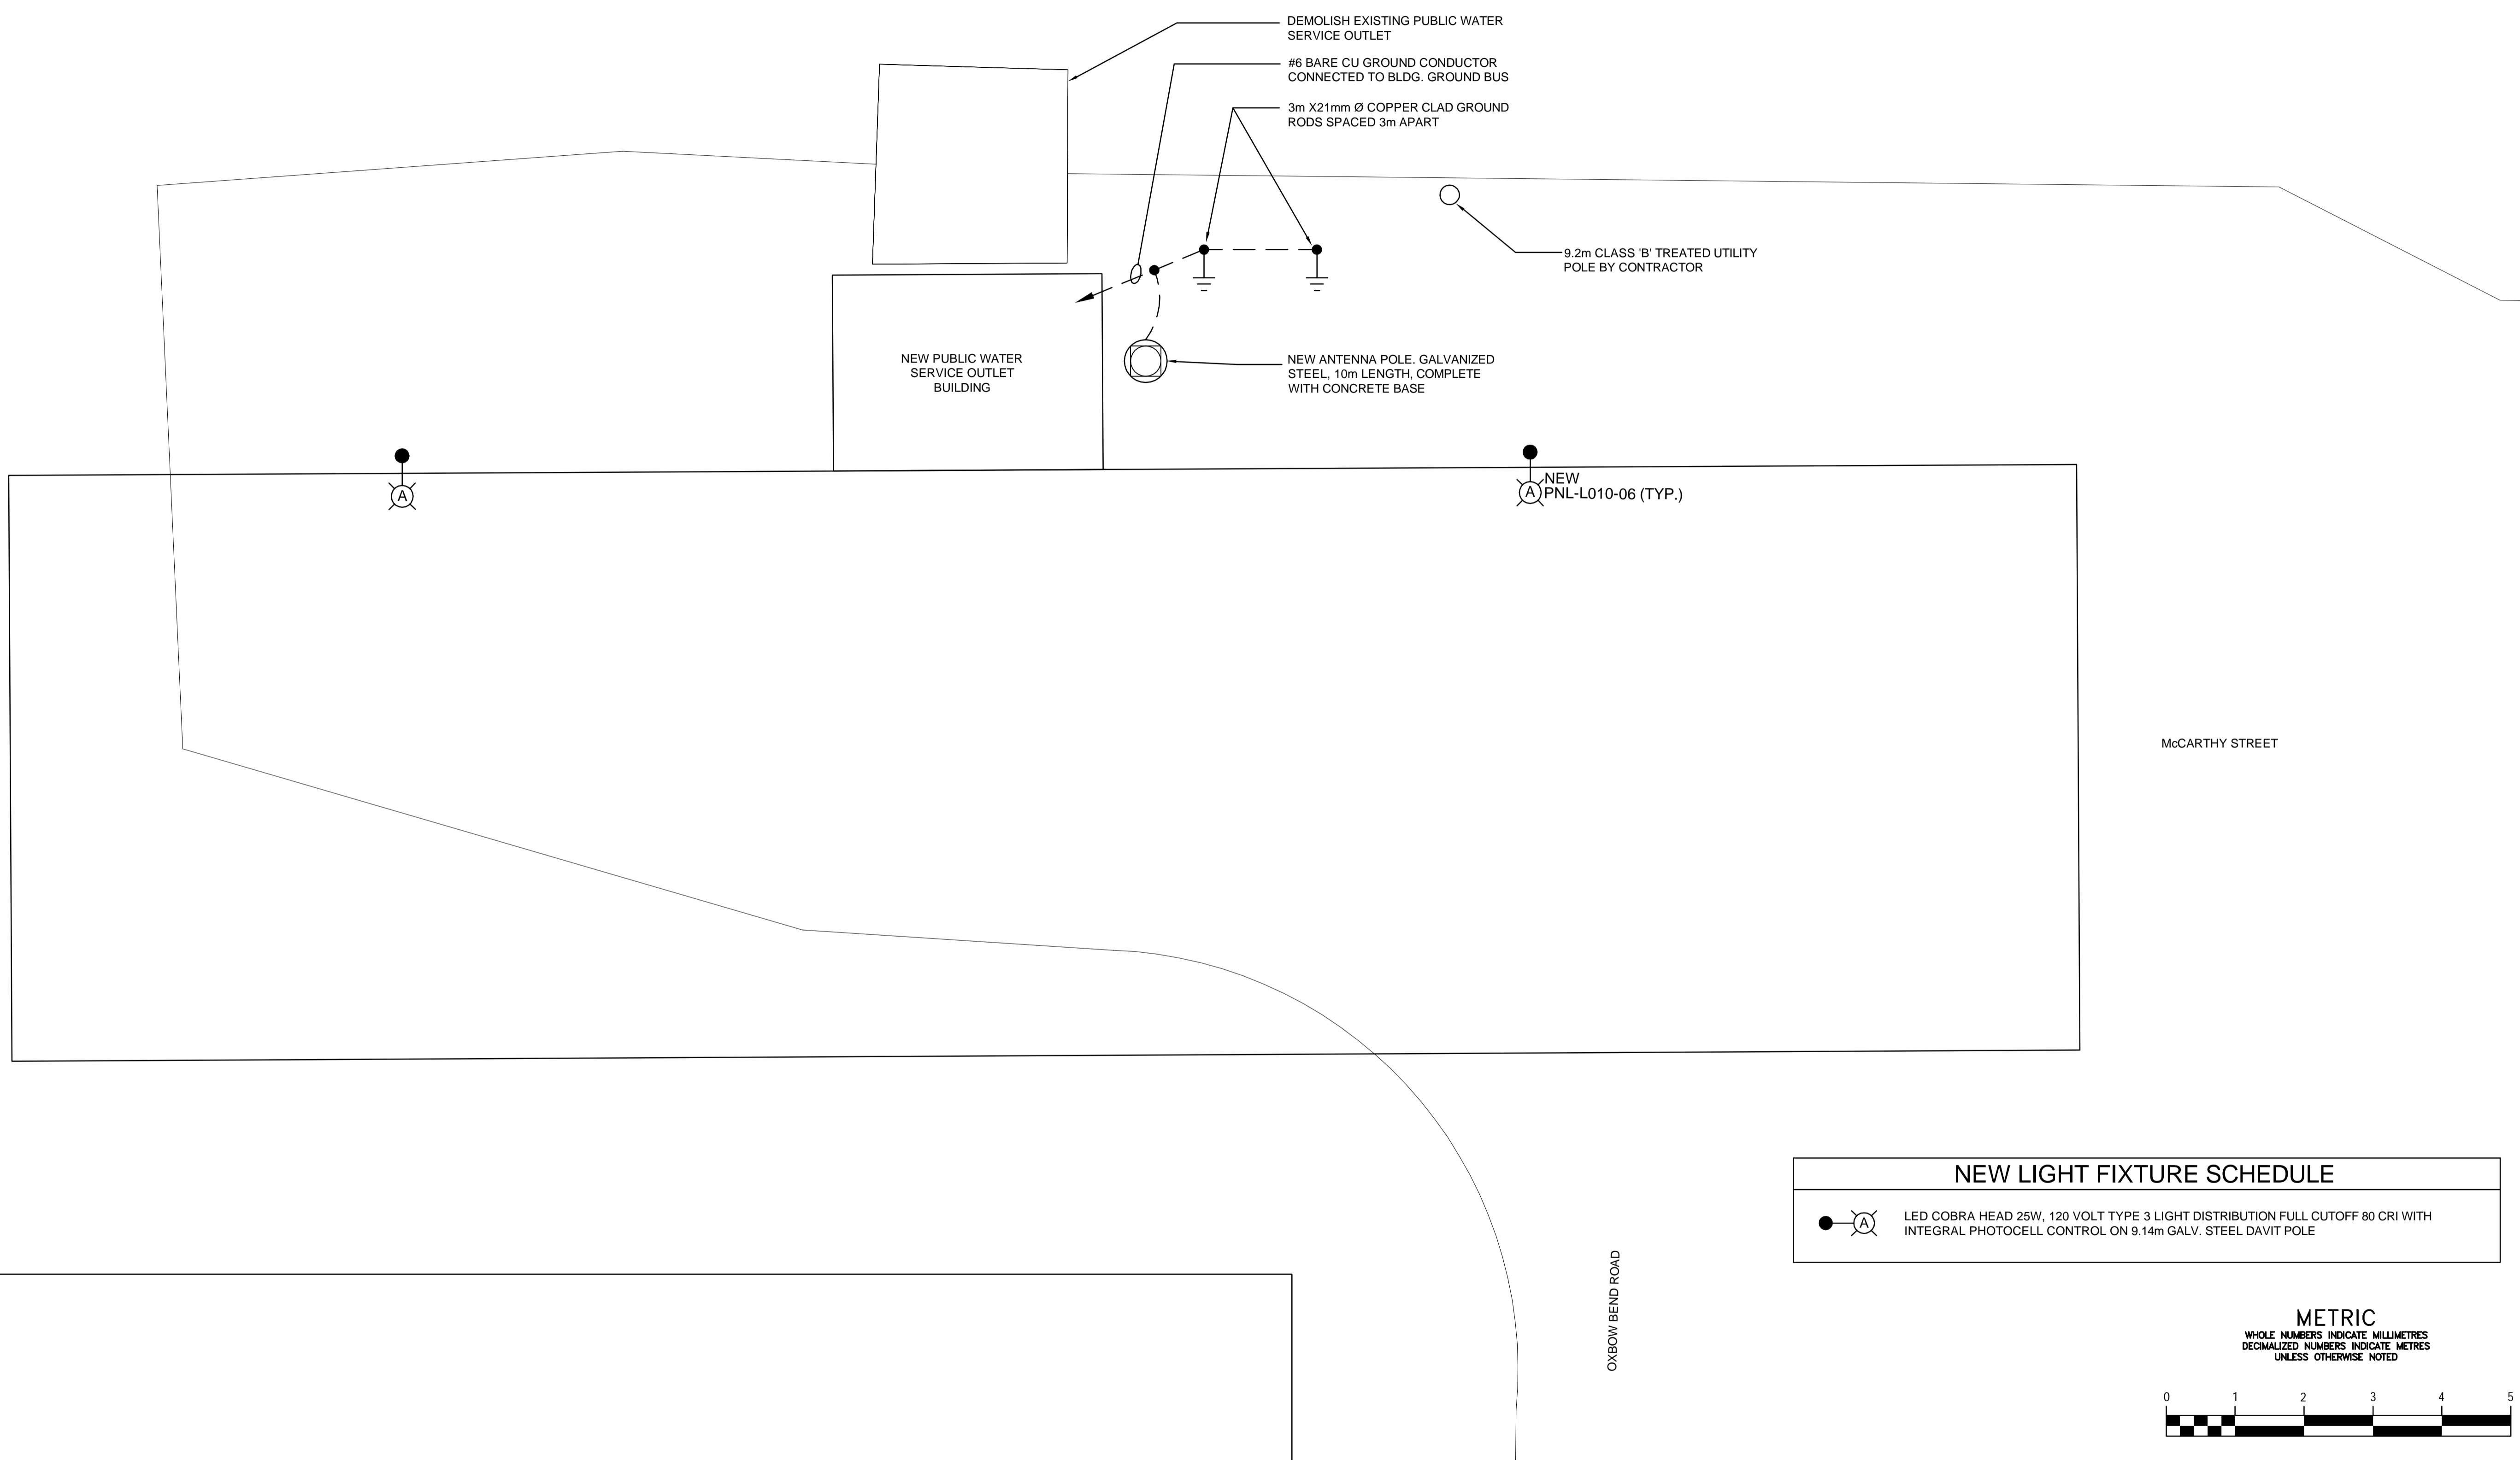

NEW LIGHT FIXTURE SCHEDULE	
	LED COBRA HEAD 25W, 120 VOLT TYPE 3 LIGHT DISTRIBUTION FULL CUTOFF 80 CRI WITH INTEGRAL PHOTOCCELL CONTROL ON 9.14m GALV. STEEL DAVIT POLE

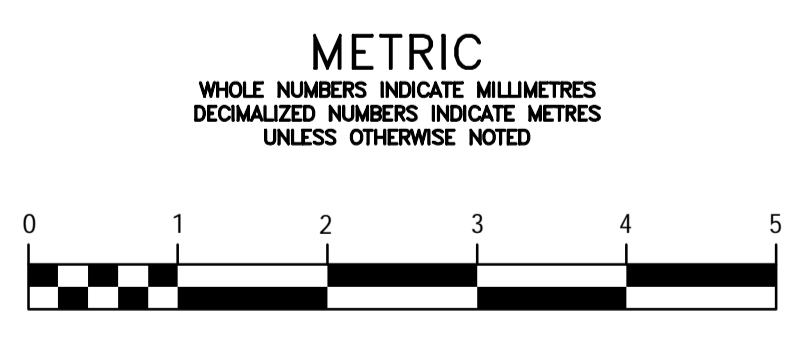


FILENAME: C:\PROJECTS\WORKING DIRECTORY\ACTIVE\40SK\1063107\175009-10-McCARTHY-ST-ELECT-SITE-PLAN.DWG PLOTTED BY: KOWALSKI, STANLEY
PLOT DATE: 2018-07-06 @ 8:14:58 AM PLOT SCALE: 1:1.0008 PLOT STYLE: FULL-COLOR.CTB



LOCATION APPROVED UNDERGROUND STRUCTURES		B.M. ELEV.
SUPV. U/G STRUCTURES COMMITTEE	DATE	CONSTRUCTION COMPLETION DATE: YYYY MM DD
NOTE: LOCATION OF UNDERGROUND STRUCTURES AS SHOWN ARE BASED ON THE BEST INFORMATION AVAILABLE BUT NO GUARANTEE IS GIVEN THAT ALL EXISTING UTILITIES ARE SHOWN OR THAT THE GIVEN LOCATIONS ARE EXACT. CONFIRMATION OF EXISTENCE AND EXACT LOCATION OF ALL SERVICES MUST BE OBTAINED FROM THE INDIVIDUAL UTILITIES BEFORE PROCEEDING WITH CONSTRUCTION.		
0	ISSUED FOR BID OP 330-2018	18/04/19 B.L.M.
NO.	REVISIONS	DATE BY

DILLON CONSULTING	
DESIGNED BY B.L.M.	CHECKED BY
DRAWN BY E.J.H.	APPROVED BY
SCALE: HORIZONTAL VERTICAL	RELEASED FOR CONSTRUCTION
1:50	
DATE 2017 07 07	DATE
PLOT DATE: 2018 07 06	

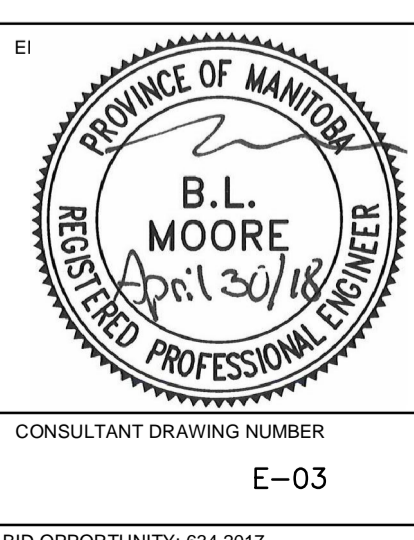

THE CITY OF WINNIPEG WATER AND WASTE DEPARTMENT ENGINEERING DIVISION	
REHABILITATION OF PUBLIC WATER SERVICE OUTLETS: BILLING SYSTEM, BUILDING SUPPLY, DEMOLITION AND ELECTRICAL ELECTRICAL - McCARTHY STREET SITE PLAN	
CONSULTANT DRAWING NUMBER E-03	SHEET 7 OF 18 CITY DRAWING NUMBER D-14917