


MAIN FLOOR PLAN  
SCALE: 1 : 20

DEMOLITION NOTES

- (A) PROVIDE DEMOLITION OF EXISTING FUSIBLE DISCONNECT SWITCH AND ASSOCIATED CABLING AND CONDUIT.
- (B) PROVIDE DEMOLITION OF 600V DISTRIBUTION PANEL AND ALL ASSOCIATED CABLING AND CONDUIT.
- (C) PROVIDE DEMOLITION OF EXISTING WESTINGHOUSE CONTACTOR ENCLOSURE.
- (D) PROVIDE DEMOLITION OF EXISTING PANELBOARD AND ALL ASSOCIATED CABLING, CONDUIT, AND CONTROLS.
- (E) PROVIDE DEMOLITION OF EXISTING UNIT HEATER AND ASSOCIATED CABLING, CONDUIT, AND CONTROLS.
- (F) PROVIDE DEMOLITION OF EXISTING ANNUNCIATOR PANEL AND ALL ASSOCIATED CABLE, CONDUIT, AND CONTROLS.
- (G) PROVIDE DEMOLITION OF EXISTING RTU PANEL AND ALL ASSOCIATED CABLE, CONDUIT, AND CONTROLS.
- (H) PROVIDE DEMOLITION OF EXISTING LIGHT FIXTURE AND ALL ASSOCIATED CABLE, CONDUIT, AND CONTROLS.
- (J) PROVIDE DEMOLITION OF EXISTING PUMP STARTER PANEL AND ALL ASSOCIATED CABLE, CONDUIT, AND CONTROLS.
- (K) PROVIDE DEMOLITION OF EXISTING RECEPTACLES AND ALL ASSOCIATING CABLING AND CONDUIT.
- (L) PROVIDE DEMOLITION OF EXISTING PUMP MOTOR FEEDER CABLES AND ASSOCIATED CONDUIT. MOTORS ARE TO REMAIN.
- (M) PROVIDE DEMOLITION OF NATURAL GAS ENGINE AND ALL ASSOCIATED CABLE, CONDUIT, AND CONTROLS. REFER TO MECHANICAL DRAWINGS FOR ADDITIONAL DEMOLITION.
- (N) PROVIDE DEMOLITION OF EXISTING TELEPHONE.
- (O) PROVIDE DEMOLITION OF EXHAUST FAN MOTOR STARTER AND ALL ASSOCIATED CABLE, CONDUIT, AND CONTROLS.
- (P) PROVIDE DEMOLITION OF METER AND ALL ASSOCIATED CABLE, CONDUIT, AND CONTROLS.
- (Q) CONTRACTOR TO ALLOW FOR CITY OF WINNIPEG TO SALVAGE ANY EQUIPMENT OR COMPONENTS PRIOR TO REMOVAL AND DISPOSAL.

LEGEND:

- EXISTING
- - - DEMOLISH

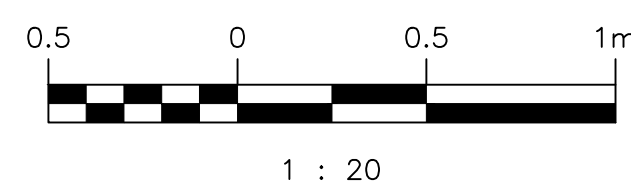

00	ISSUED FOR TENDER, BID OPP: 475-2018	2018/05/09	BC	PP
NO.	REVISIONS	DATE	DESIGN	CHECK

SNC-LAVALIN INC. 148 Nature Park Way Winnipeg, MB, Canada R3P 0X7 204-786-8080	
DESIGNED BY: B. CLEVEN	CHECKED BY: P. PANUFNIK
DRAWN BY: Y. KONIG	APPROVED BY: B. CLEVEN
SCALE: 1:20	ISSUED FOR CONSTRUCTION BY: DATE:
DATE: 2017/08/14	DATE:
CONSULTANT NO.:	

ENGINEER'S SEAL  
  
**PRELIMINARY  
NOT TO BE  
USED FOR  
CONSTRUCTION**

THE CITY OF WINNIPEG WATER AND WASTE DEPARTMENT			
METRO ROUTE 20 UNDERPASS PUMPING STATION 2018 UPGRADES ELECTRICAL AND LIGHTING PLAN LAYOUT MAIN FLOOR DEMOLITION			
CITY DRAWING NUMBER	SHEET	REV.	SIZE
1-0309U-E0003	001	00	A1

DRAWING NUMBER	REFERENCE DRAWINGS
----------------	--------------------