


LEGEND:

| | |
|-------|------------------------|
| — | EXISTING TO REMAIN |
| - - - | EXISTING TO BE REMOVED |


REMOVAL NOTES

- ① EXISTING ROOF EXHAUST FAN HOOD AND DAMPER TO REMAIN. HOWEVER, FOR THE SAKE OF THE ROOF REPLACEMENT THE HOOD MAY NEED TO BE TEMPORARILY REMOVED AND REINSTALLED.
- ② EXISTING ENGINE COOLING EXHAUST HOOD TO REMAIN. HOWEVER, FOR THE SAKE OF THE ROOF REPLACEMENT THE HOOD MAY NEED TO BE TEMPORARILY REMOVED AND REINSTALLED.
- ③ REMOVE EXISTING ENGINE COOLING AIR DUCTWORK AND DAMPERS.
- ④ EXISTING WET WELL VENT TO REMAIN.
- ⑤ REMOVE EXISTING LOUVER. EXISTING DAMPER TO REMAIN.

ROOF PLAN - REMOVALS
SCALE: 1 : 30

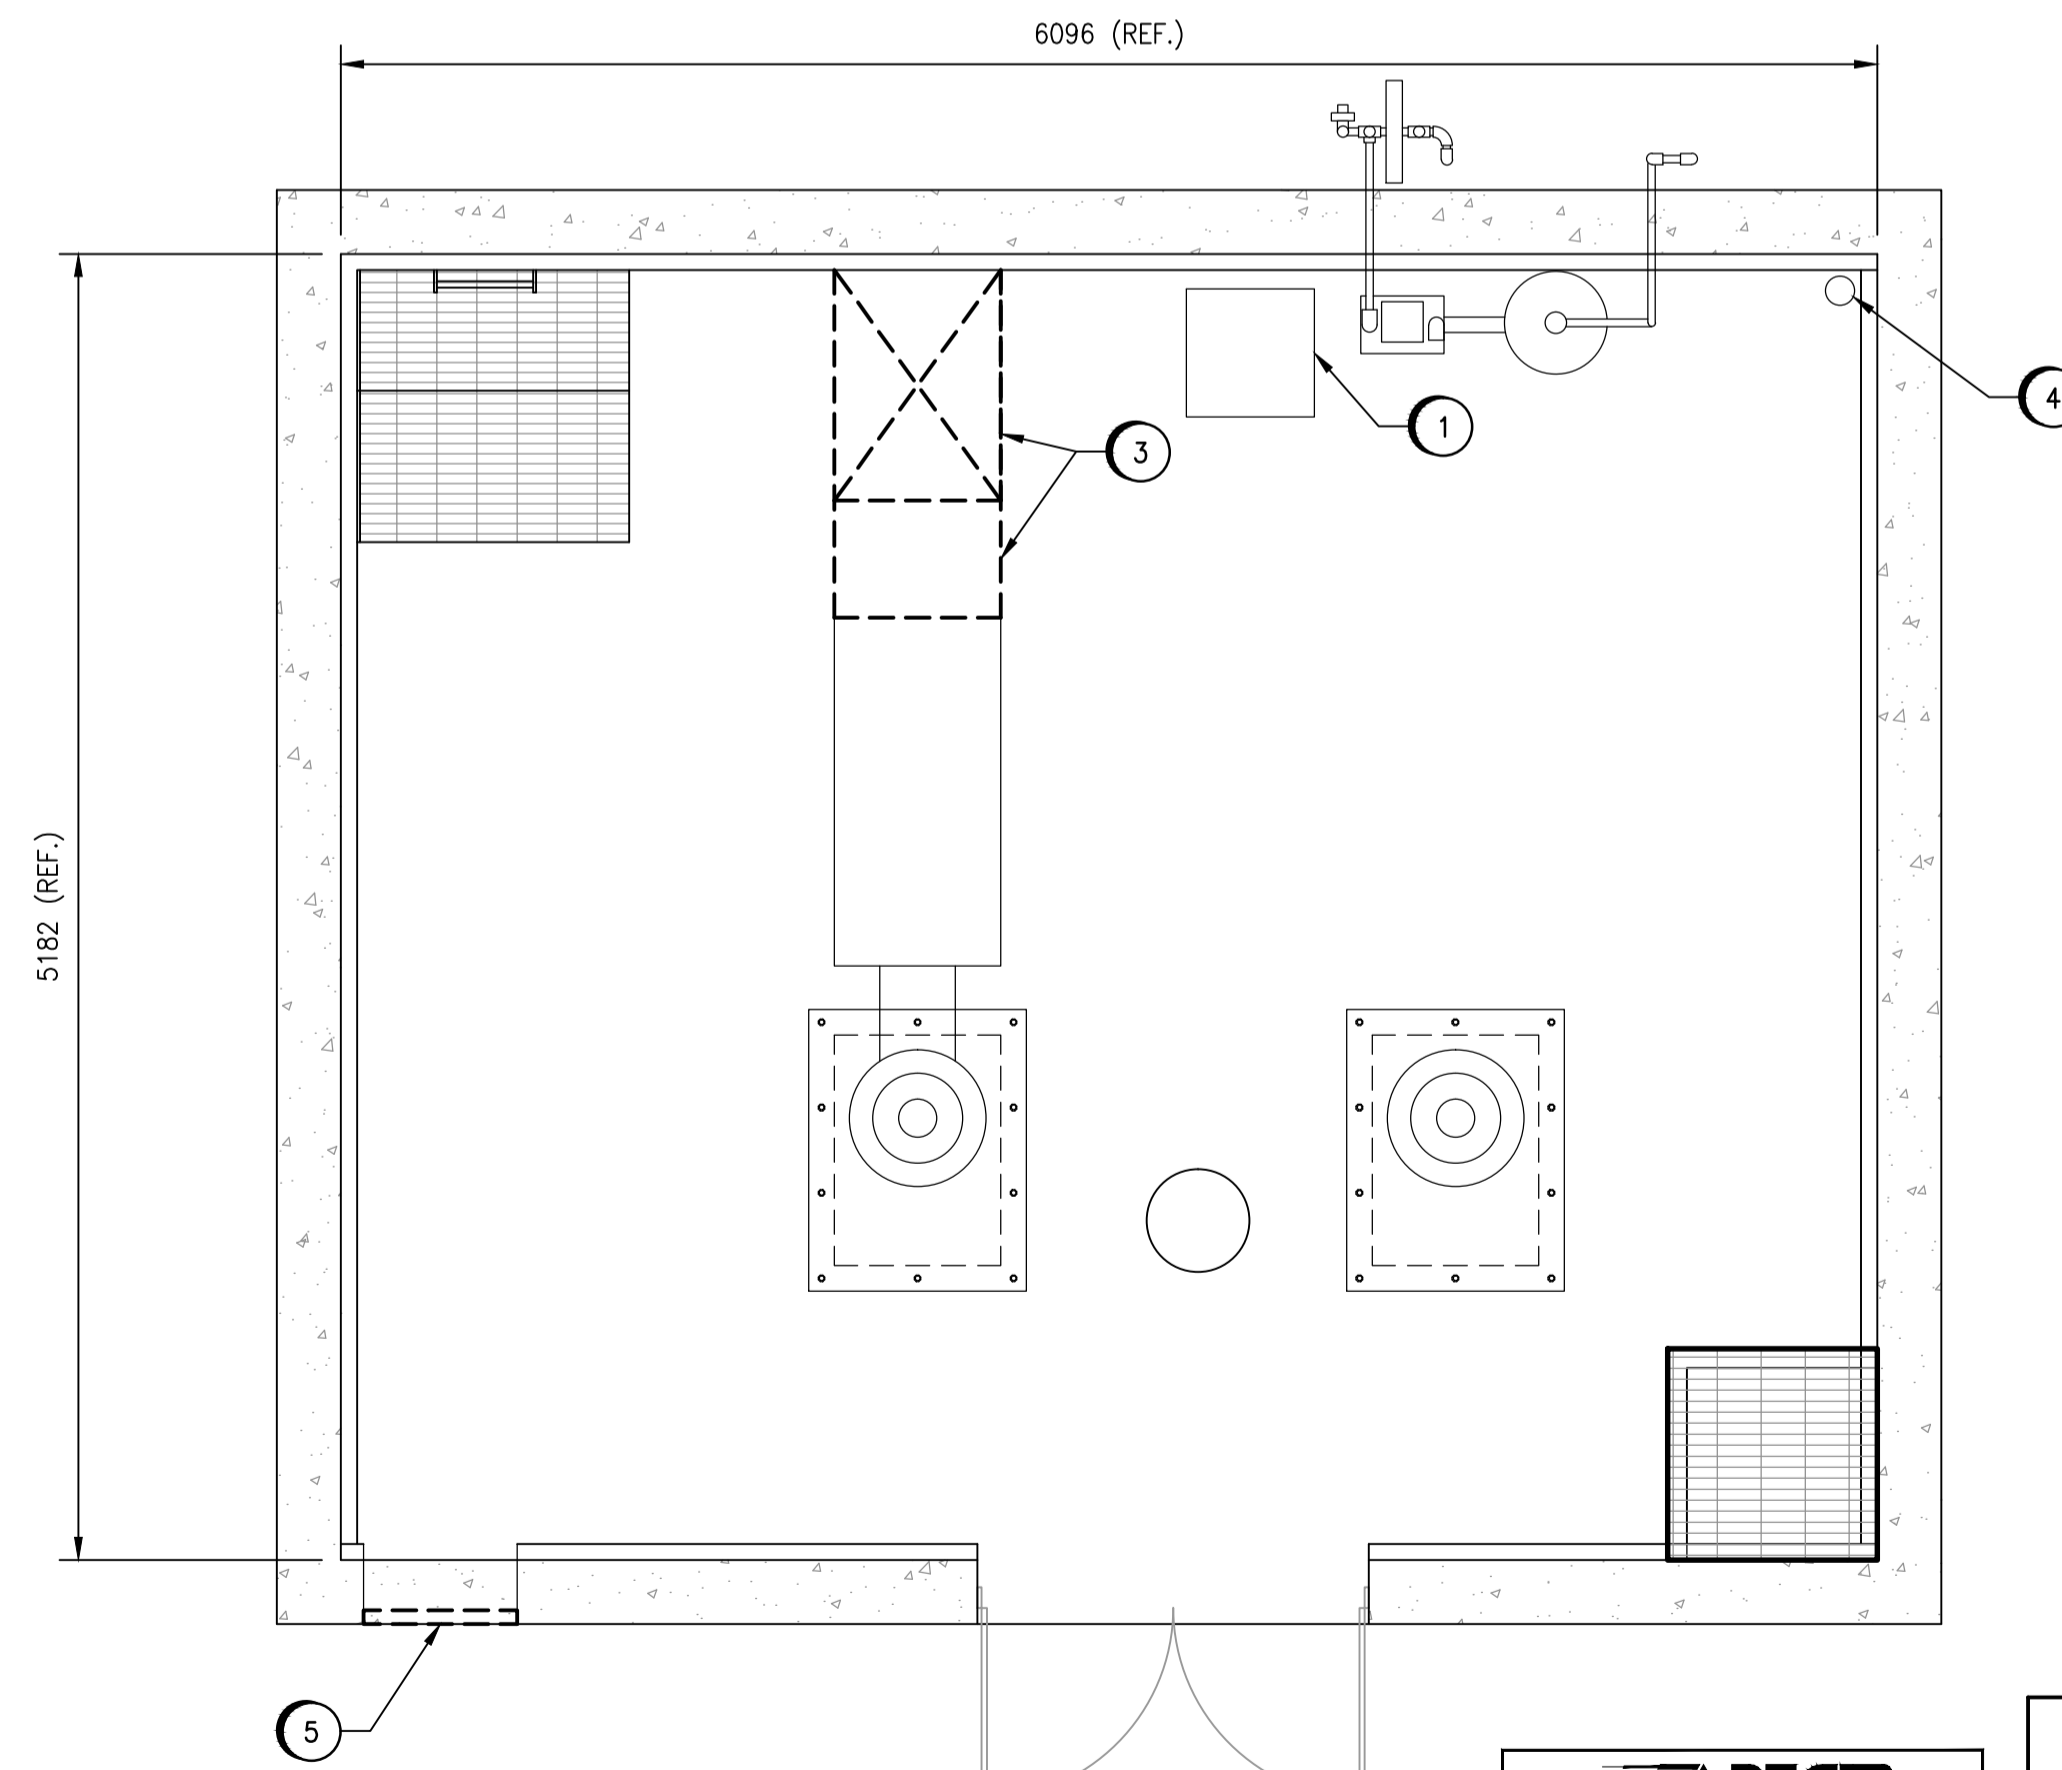

MAIN FLOOR PLAN - REMOVALS
SCALE: 1 : 30

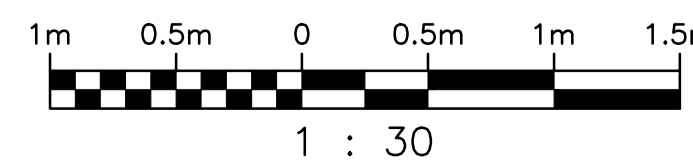

| NO. | REVISIONS | DATE | DESIGN | CHECK |
|-----|--------------------------------------|------------|--------|-------|
| 00 | ISSUED FOR TENDER, BID OPP: 475-2018 | 2018/05/09 | HO | SN |

| | |
|---|---|
| SNC-LAVALIN INC. 148 Nature Park Way Winnipeg, MB, Canada R3P 0X7 204-796-8080 | |
| DESIGNED BY: H. OJO | CHECKED BY: S. NORSWORTHY |
| DRAWN BY: D. CALVERLEY | APPROVED BY: B. CLEVEN |
| SCALE: 1:30 | ISSUED FOR CONSTRUCTION BY: DATE: |
| DATE: 2017/08/24 | DATE: |
| CONSULTANT NO.: | |

ENGINEER'S SEAL
PRELIMINARY
NOT TO BE
USED FOR
CONSTRUCTION

THE CITY OF WINNIPEG
WATER AND WASTE DEPARTMENT

METRO ROUTE 20 UNDERPASS PUMPING STATION
2018 UPGRADES
PLAN & SECTIONS
HVAC
REMOVALS

| | | | |
|---------------------|-------|------|------|
| CITY DRAWING NUMBER | SHEET | REV. | SIZE |
| 1-0309U-M0001 | 001 | 00 | A1 |