

OUTLINE OF BUILDING FOOTPRINT ABOVE

LADDER WITH CAGE GALVANIZED

2400

PLAN AT PUMP FLOOR  
1:50

CORE HOLE FOR NEW 250Ø DUCT TO PUMP FLOOR

FLOOR MOUNTED GUARD AT OPENING

4877

GROUT HOLE

FLOOR MOUNTED GUARD EACH SIDE OF LADDER OPENING WITH SAFETY CHAINS


FILL HOLE IN FLOOR WITH HIGH STRENGTH NON-SHRINK GROUT (TYP)

LINE OF ROOF OVERHANG ABOVE


ROOF SCUPPER TO BE FILLED IN WITH SALVAGED BRICKS

PATCH WALLS AT MECHANICAL AND ELECTRICAL REMOVALS (TYP)

PLAN AT MOTOR FLOOR  
1:50

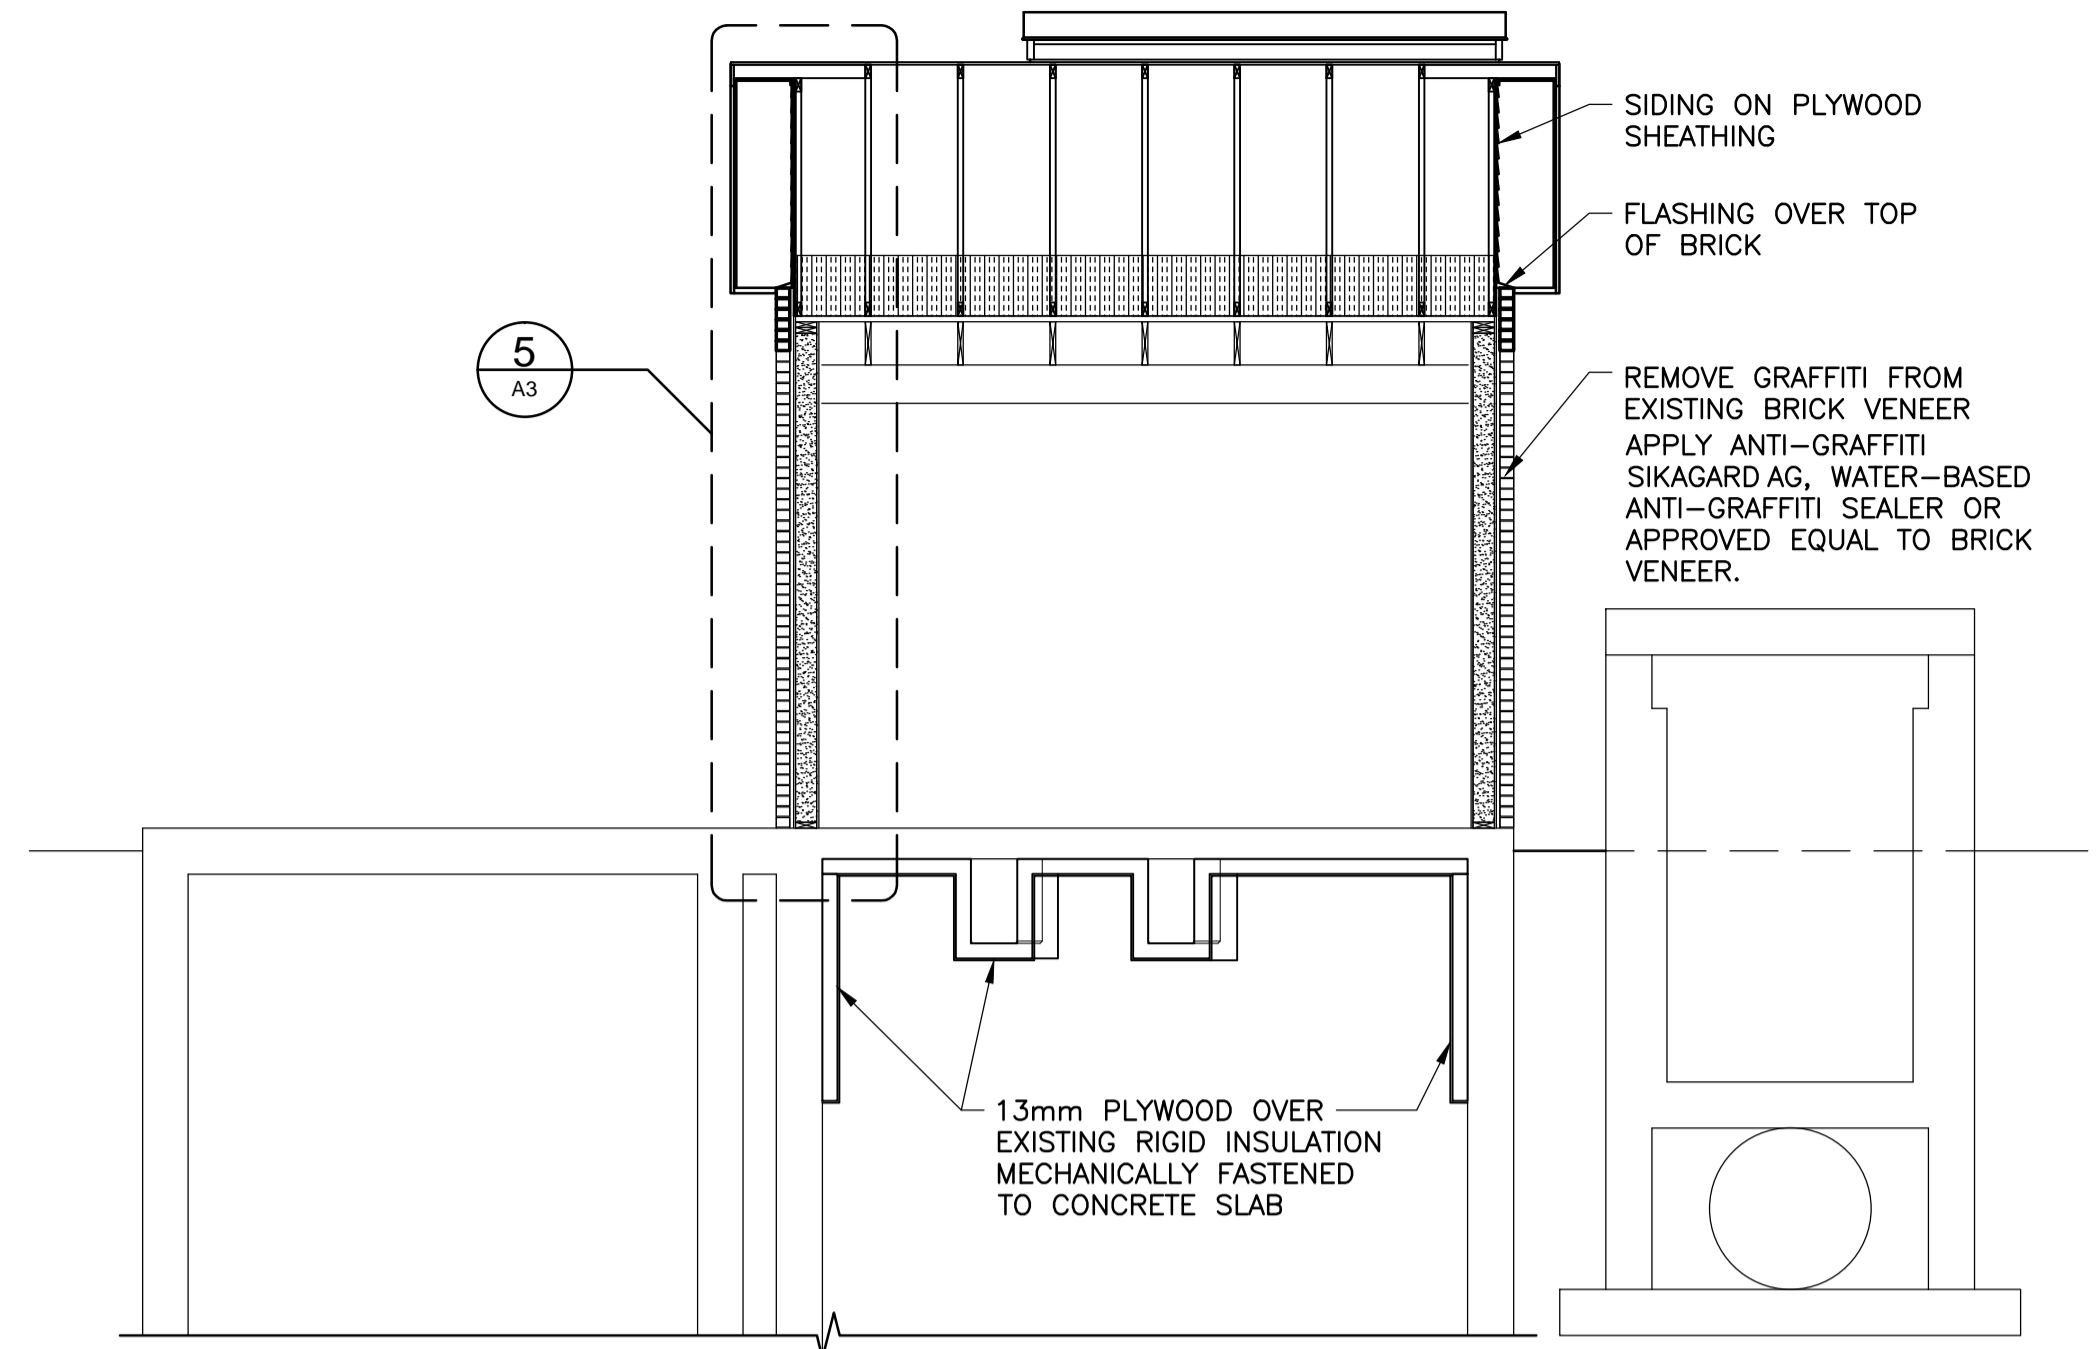

2 CROSS SECTION  
1:50

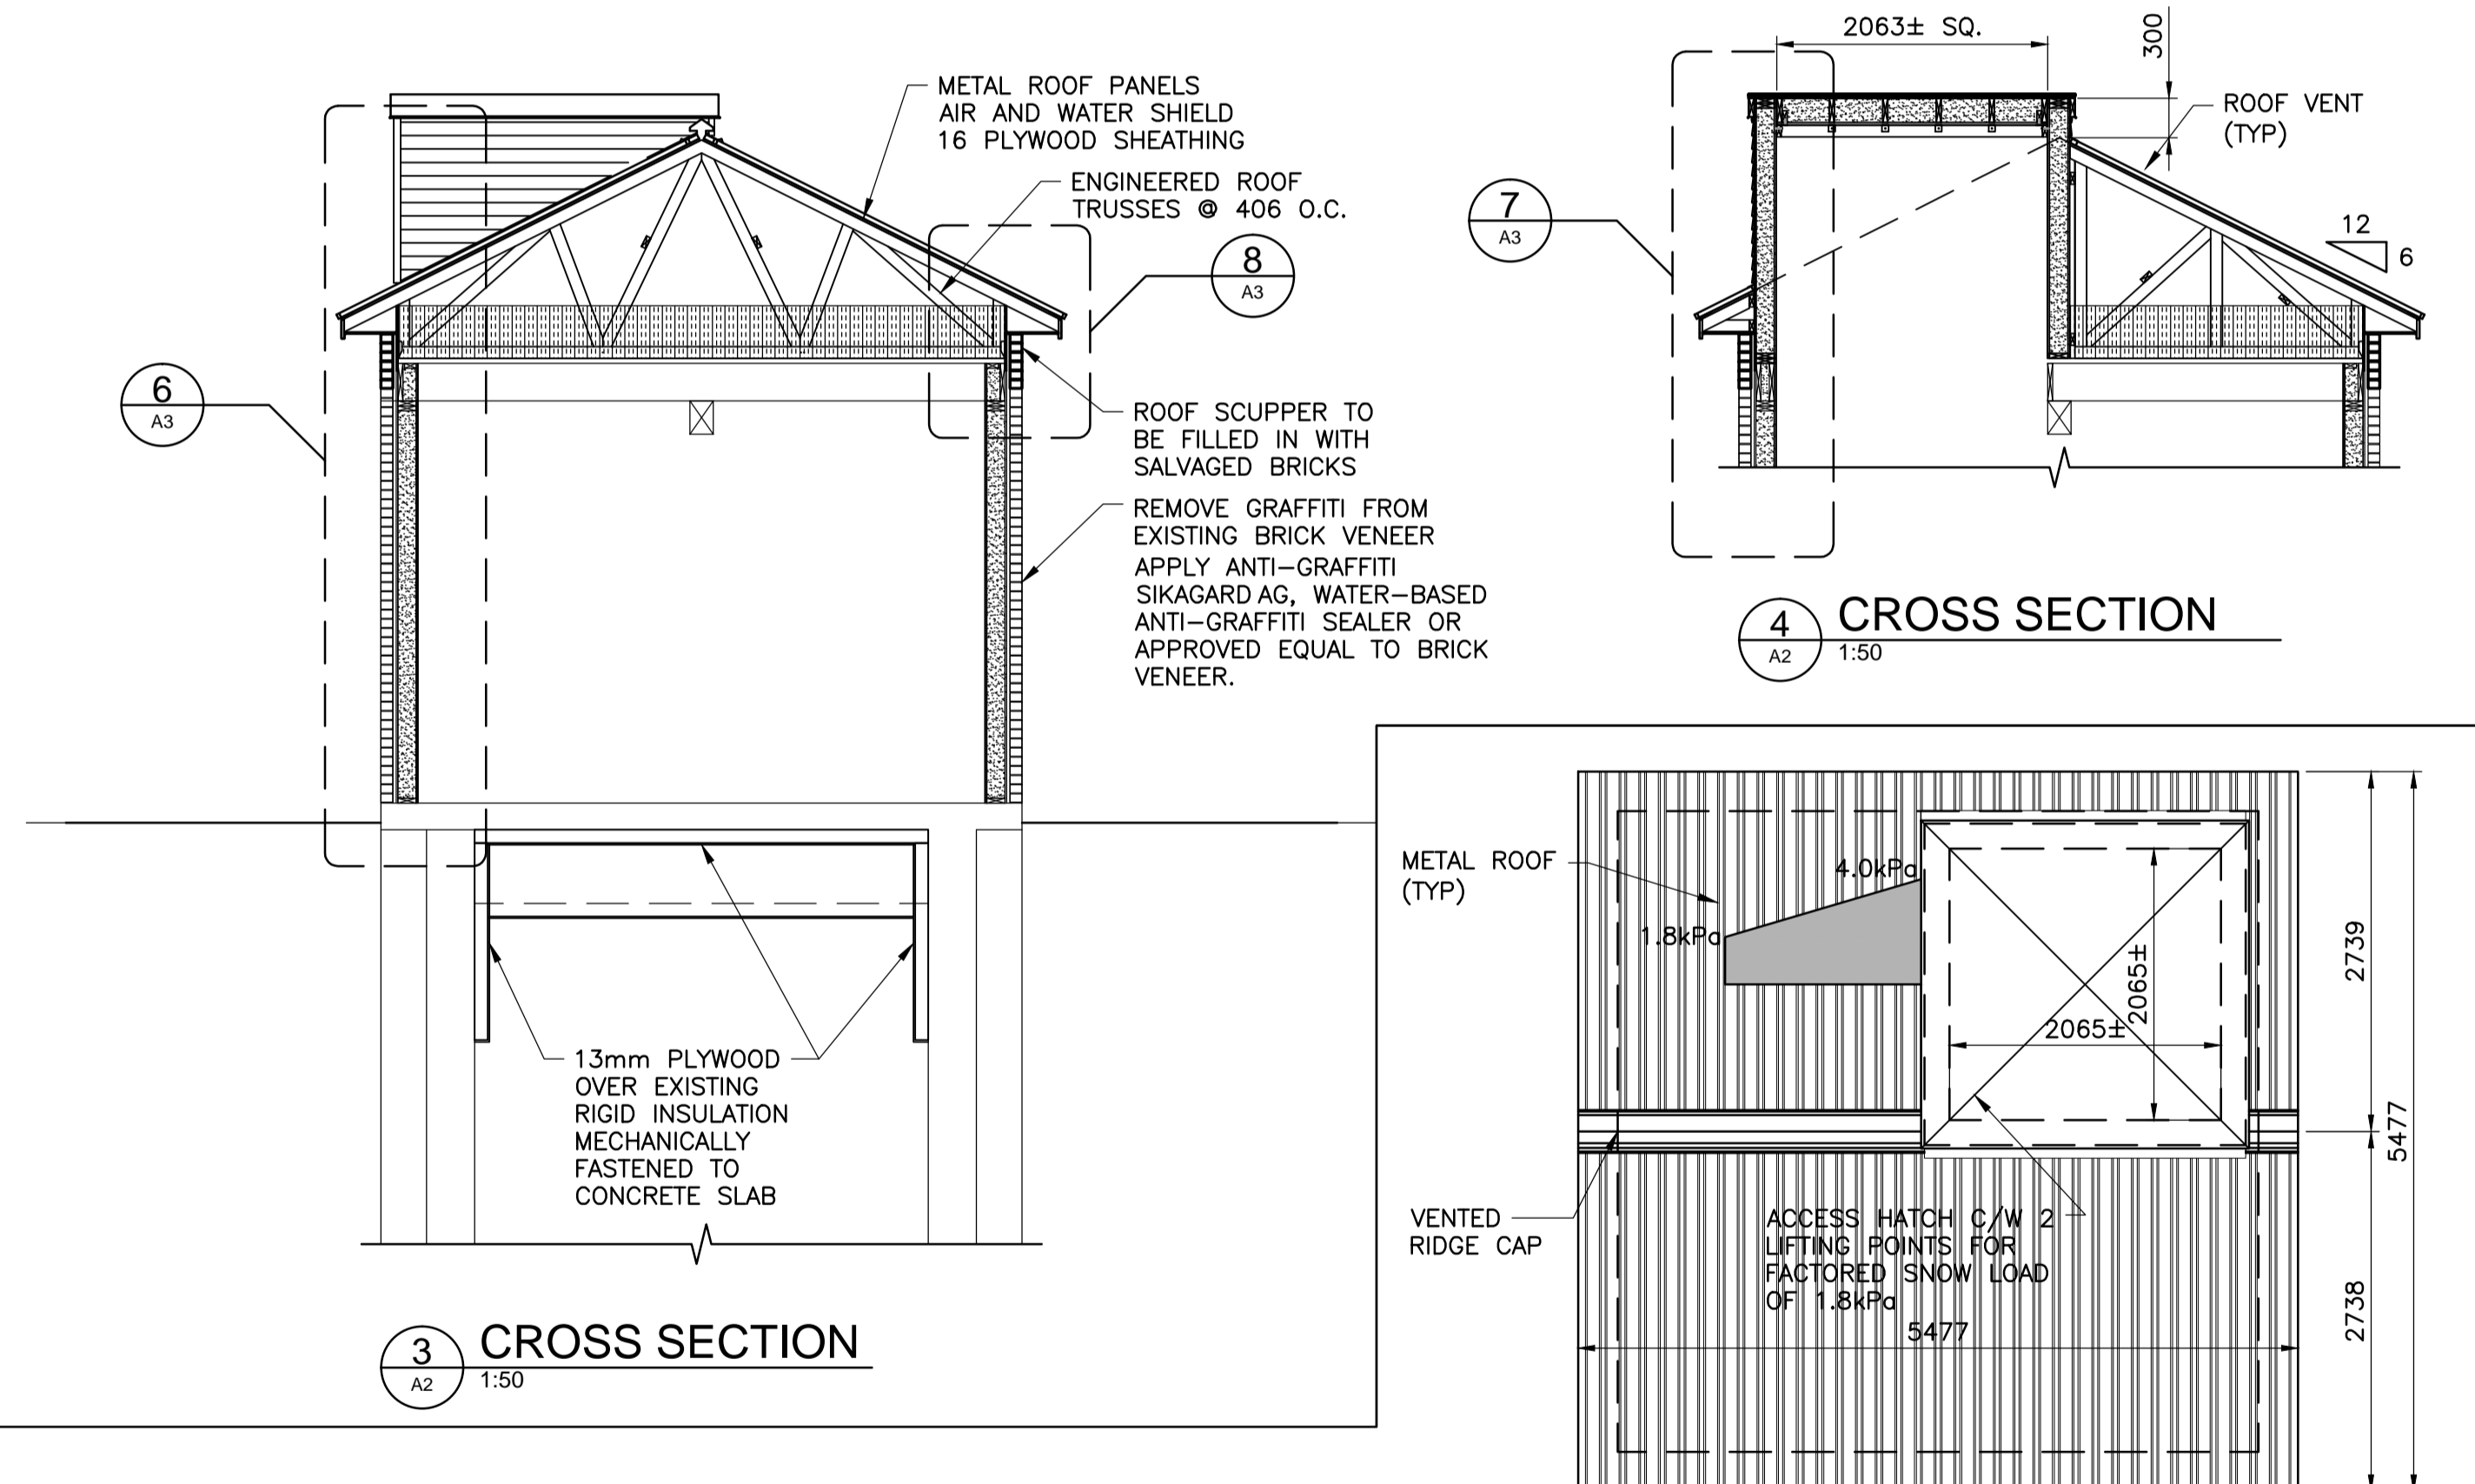

3 CROSS SECTION  
1:50

4 CROSS SECTION  
1:50

ROOF PLAN WITH SNOW LOADINGS  
1:50

NOTE:  
IMPORTANT FACTOR:  $I_s = 1.25$   
(FACTOR TO BE APPLIED TO THE SHOWN VALUES)

METRIC

WHOLE NUMBERS INDICATE MILLIMETRES  
DECIMALIZED NUMBERS INDICATE METRES

FILENAME: C:\PROJECTS\WORKING DIRECTORY\PROJECTS 2018\4063\UNITS\661\18872\_01\_ARCH\_DRAWING\_PLOTTED BY: GRAHAM, GREG  
PLOT DATE: 2018-06-18 10:16:16 AM  
PLOTTER: HP DesignJet 2550C  
PLOT SCALE: 1:50  
PLOT SHEET: 2 OF 7

B.M. ELEV.	DESIGNED BY JAA		ENGINEER'S SEAL	 <b>THE CITY OF WINNIPEG</b> WATER AND WASTE DEPARTMENT	
	DRAWN BY PDR		CONSULTANT PROJECT NUMBER 18-6872		
	CHECKED BY NR		SYNDICATE FLOOD PUMPING STATION UPGRADES		CITY DRAWING NUMBER 1-0189F-B0002-001
	APPROVED BY MH		NEW CONSTRUCTION FLOOR PLANS, CROSS SECTIONS		SHEET 2 OF 7
	HOR. SCALE AS SHOWN		RELEASED FOR CONSTRUCTION NOT FOR CONSTRUCTION		CONSULTANT DRAWING NUMBER A2
1 ISSUED FOR TENDER	15/06/18	BLM	VERTICAL		
NO. REVISIONS	DATE	BY	DATE		