


29 June 2018

186936-E-101-E-102.dwg

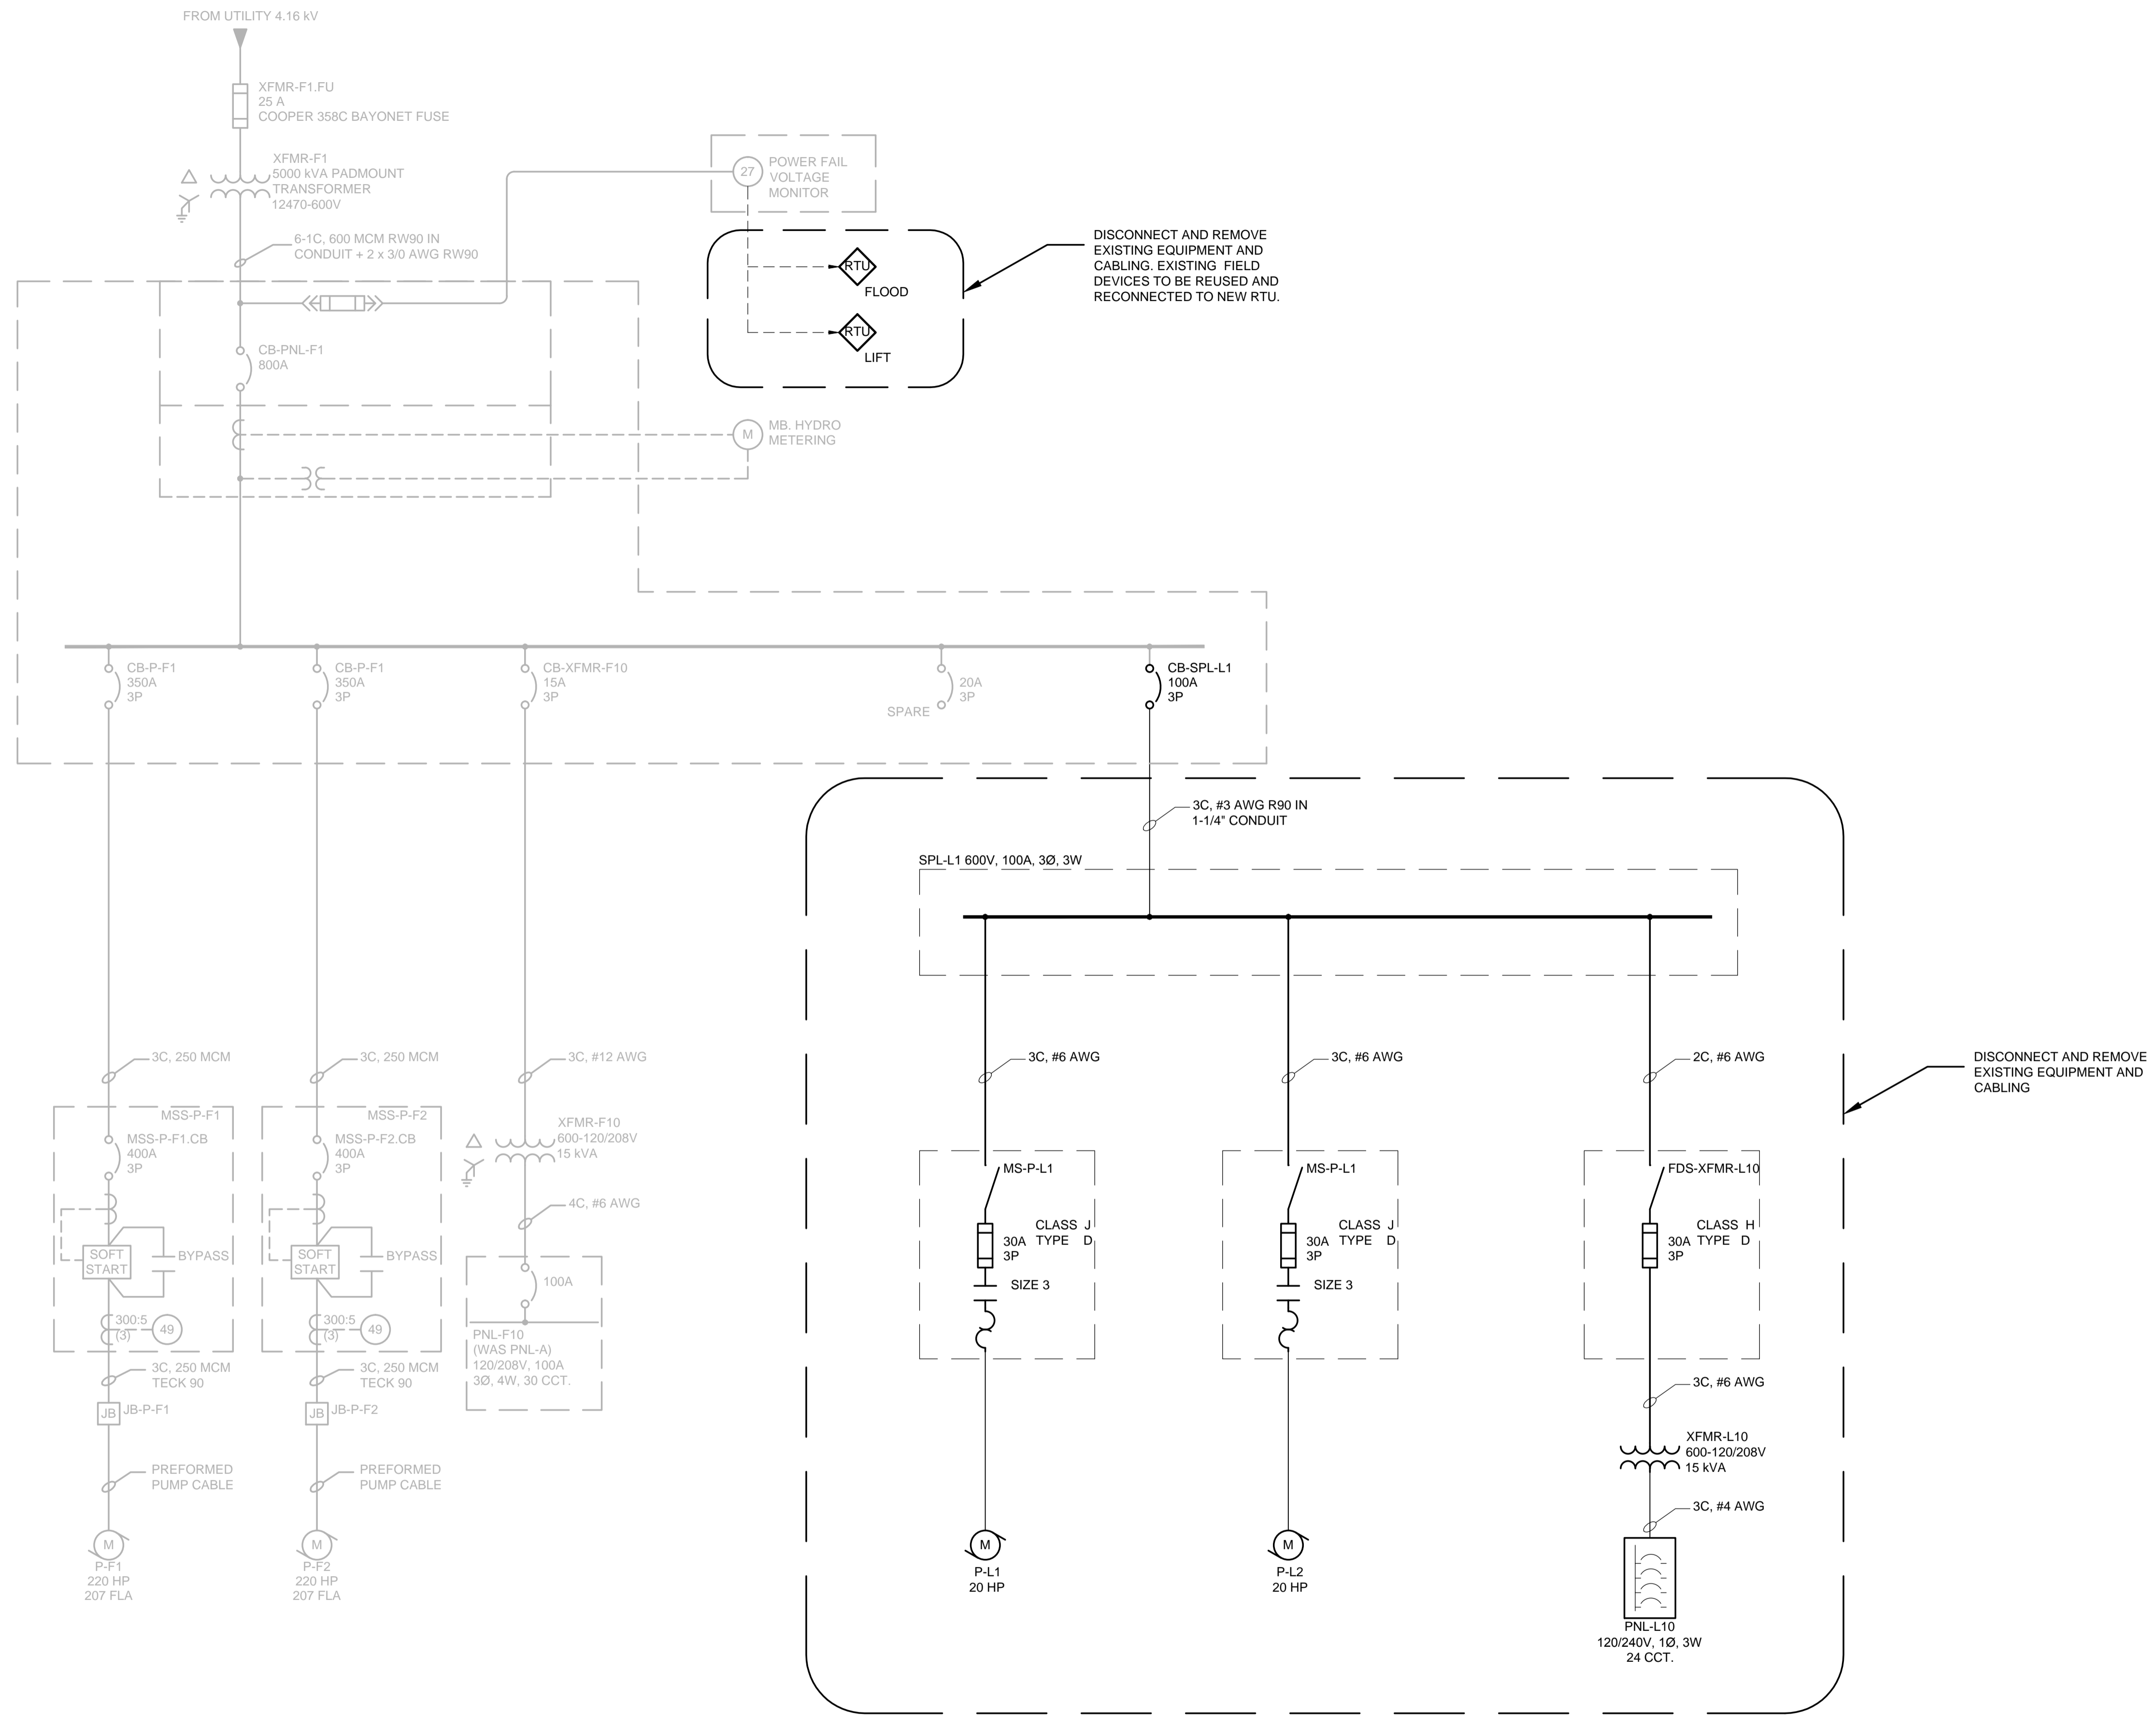

SINGLE LINE DIAGRAM
N.T.S.

NOT FOR CONSTRUCTION



NO.	REVISIONS	DATE	BY
0	ISSUED FOR TENDER	06/29/18	BLM

DILLON CONSULTING	
DESIGNED BY	B.B.
CHECKED BY	B.L.M.
DRAWN BY	S.C.K.
APPROVED BY	MH
HOR. SCALE	AS SHOWN
VERTICAL	AS SHOWN
RELEASED FOR CONSTRUCTION	DATE
DATE	June 2018

ENGINEER'S SEAL
CONSULTANT PROJECT NUMBER
18-6936

THE CITY OF WINNIPEG WATER AND WASTE DEPARTMENT	
HAWTHORNE WASTEWATER PUMPING STATION UPGRADES	
ELECTRICAL - SINGLE LINE DIAGRAM - DEMOLITION	
CITY DRAWING NUMBER	1-0145L-E0004-001
SHEET	15 OF 21
CONSULTANT DRAWING NUMBER	E-01