




**ENTRY LEVEL FLOOR PLAN**  
1:50

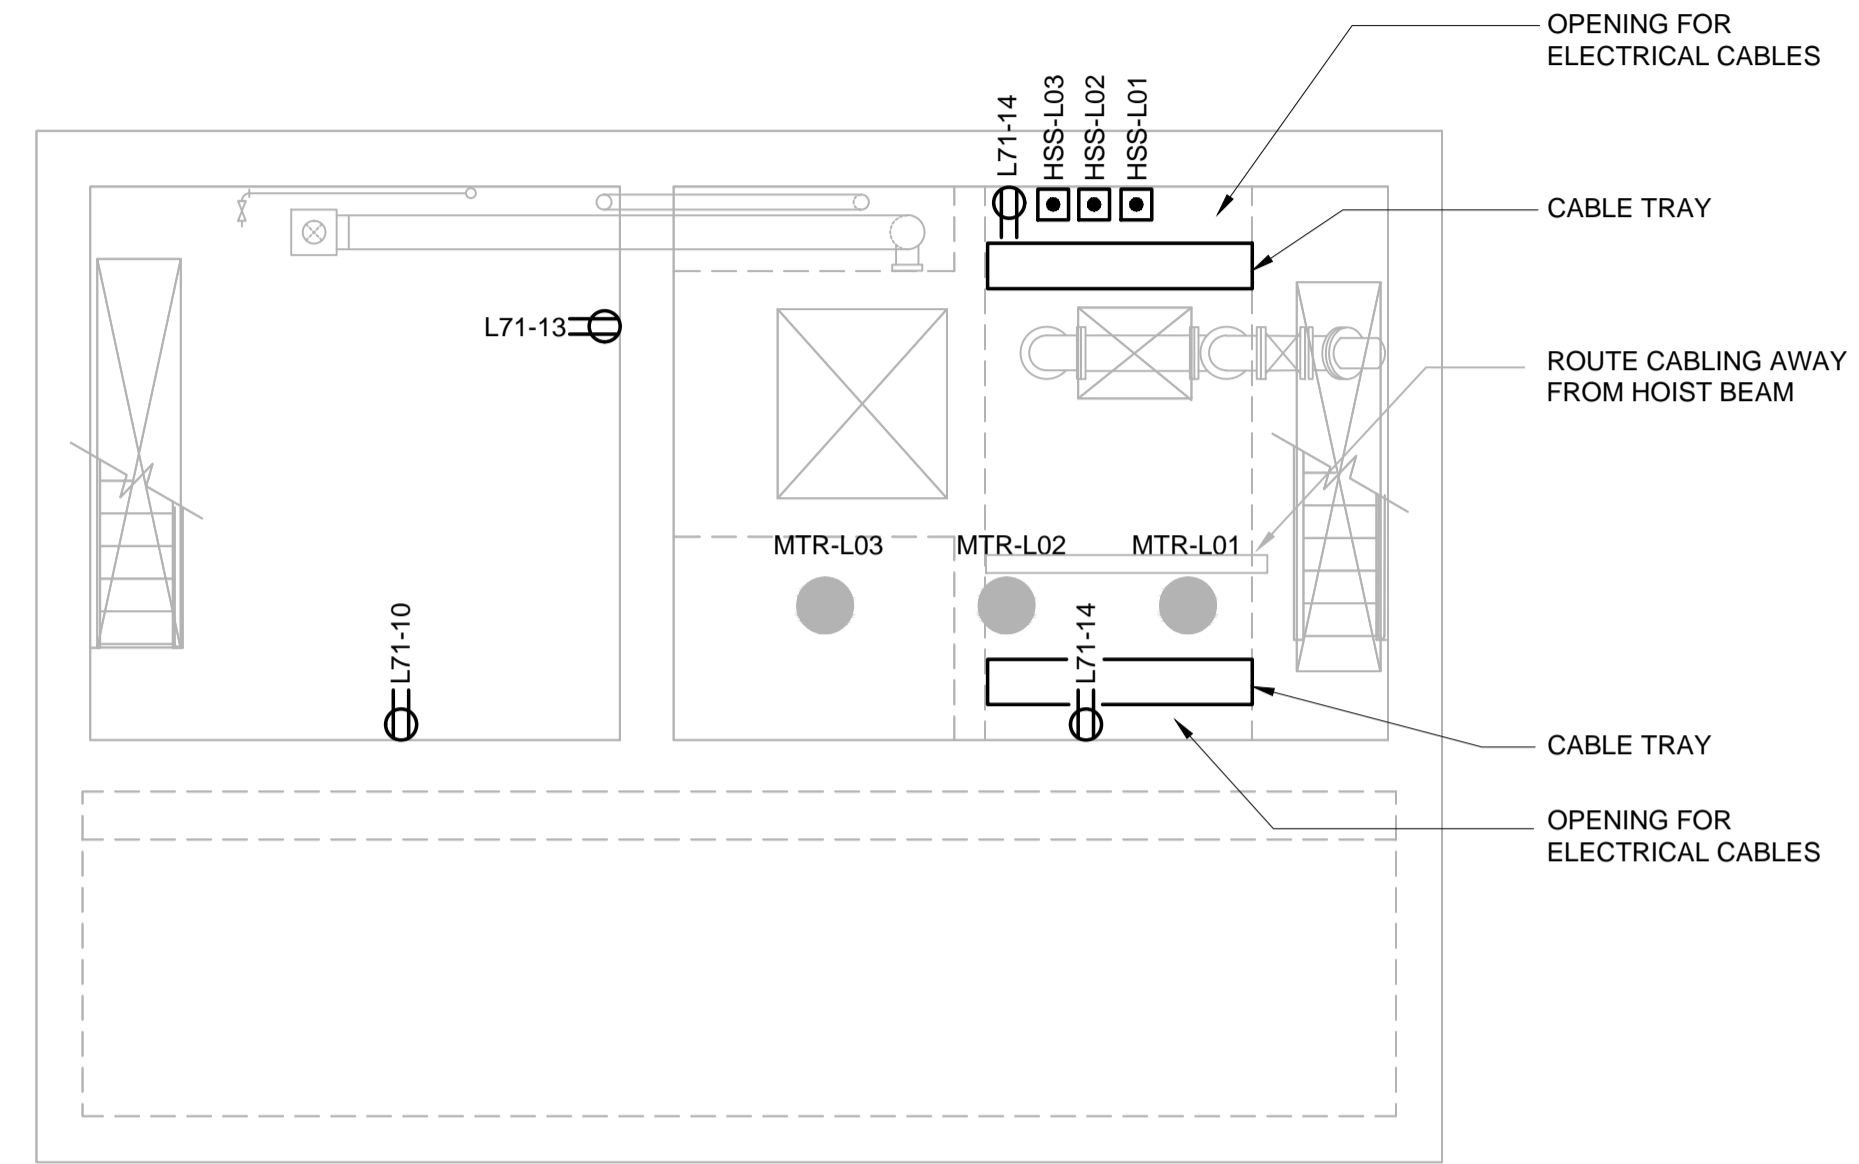

**COMM. ROOM, PUMP MOTOR ROOM FLOOR PLAN**  
1:50

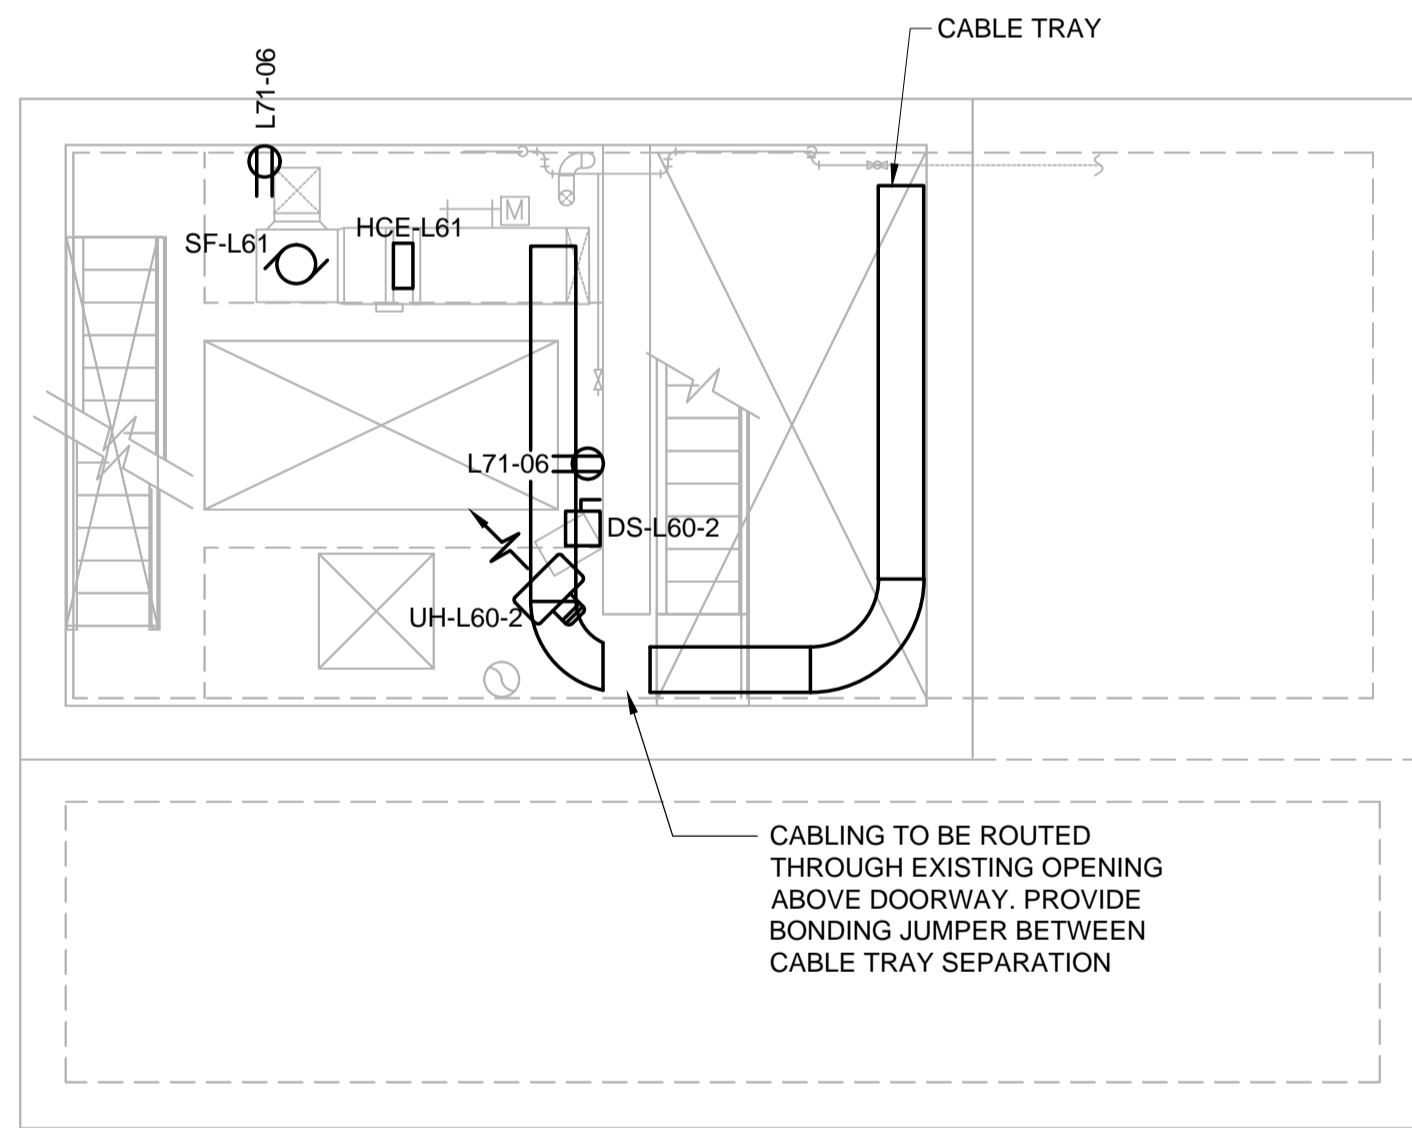

**COMM. MOTOR ROOM FLOOR PLAN**  
1:50

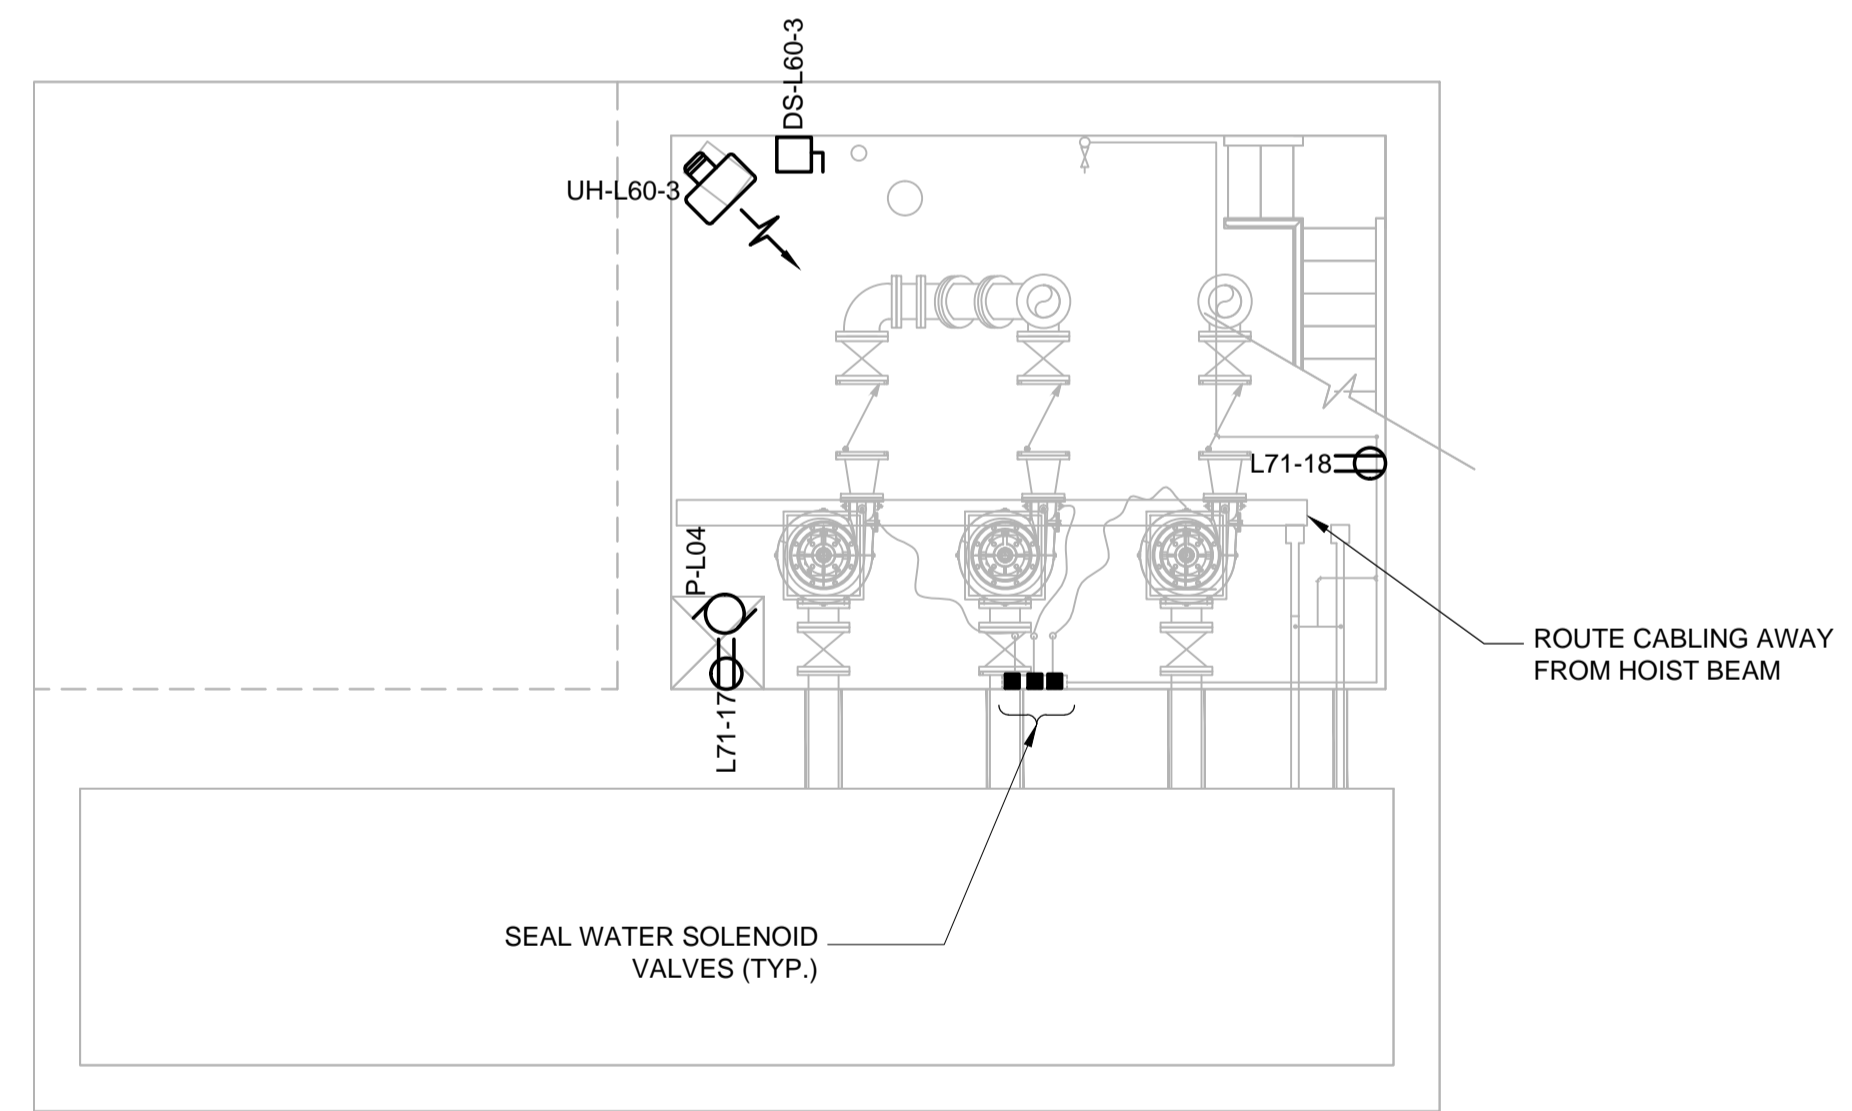

**PUMP ROOM FLOOR PLAN**  
1:50

29 June 2018

186936-E-104.dwg

**NOT FOR CONSTRUCTION**



				ENGINEER'S SEAL	
				DESIGNED BY: B.B.      CHECKED BY: B.L.M. DRAWN BY: S.C.K.      APPROVED BY: MH HOR. SCALE: AS SHOWN      RELEASED FOR CONSTRUCTION VERTICAL: AS SHOWN	
0 ISSUED FOR TENDER      06/29/18      BLM		CONSULTANT PROJECT NUMBER 18-6936		CITY DRAWING NUMBER 1-0145L-E0007-001	
NO. REVISIONS      DATE      BY		DATE: June 2018		SHEET 18 OF 21 CONSULTANT DRAWING NUMBER E-04	

**THE CITY OF WINNIPEG**  
 WATER AND WASTE DEPARTMENT  
**HAWTHORNE WASTEWATER PUMPING STATION UPGRADES**  
 ELECTRICAL - FLOOR PLANS