




DEMOLITION ENTRY LEVEL FLOOR PLAN
1:50

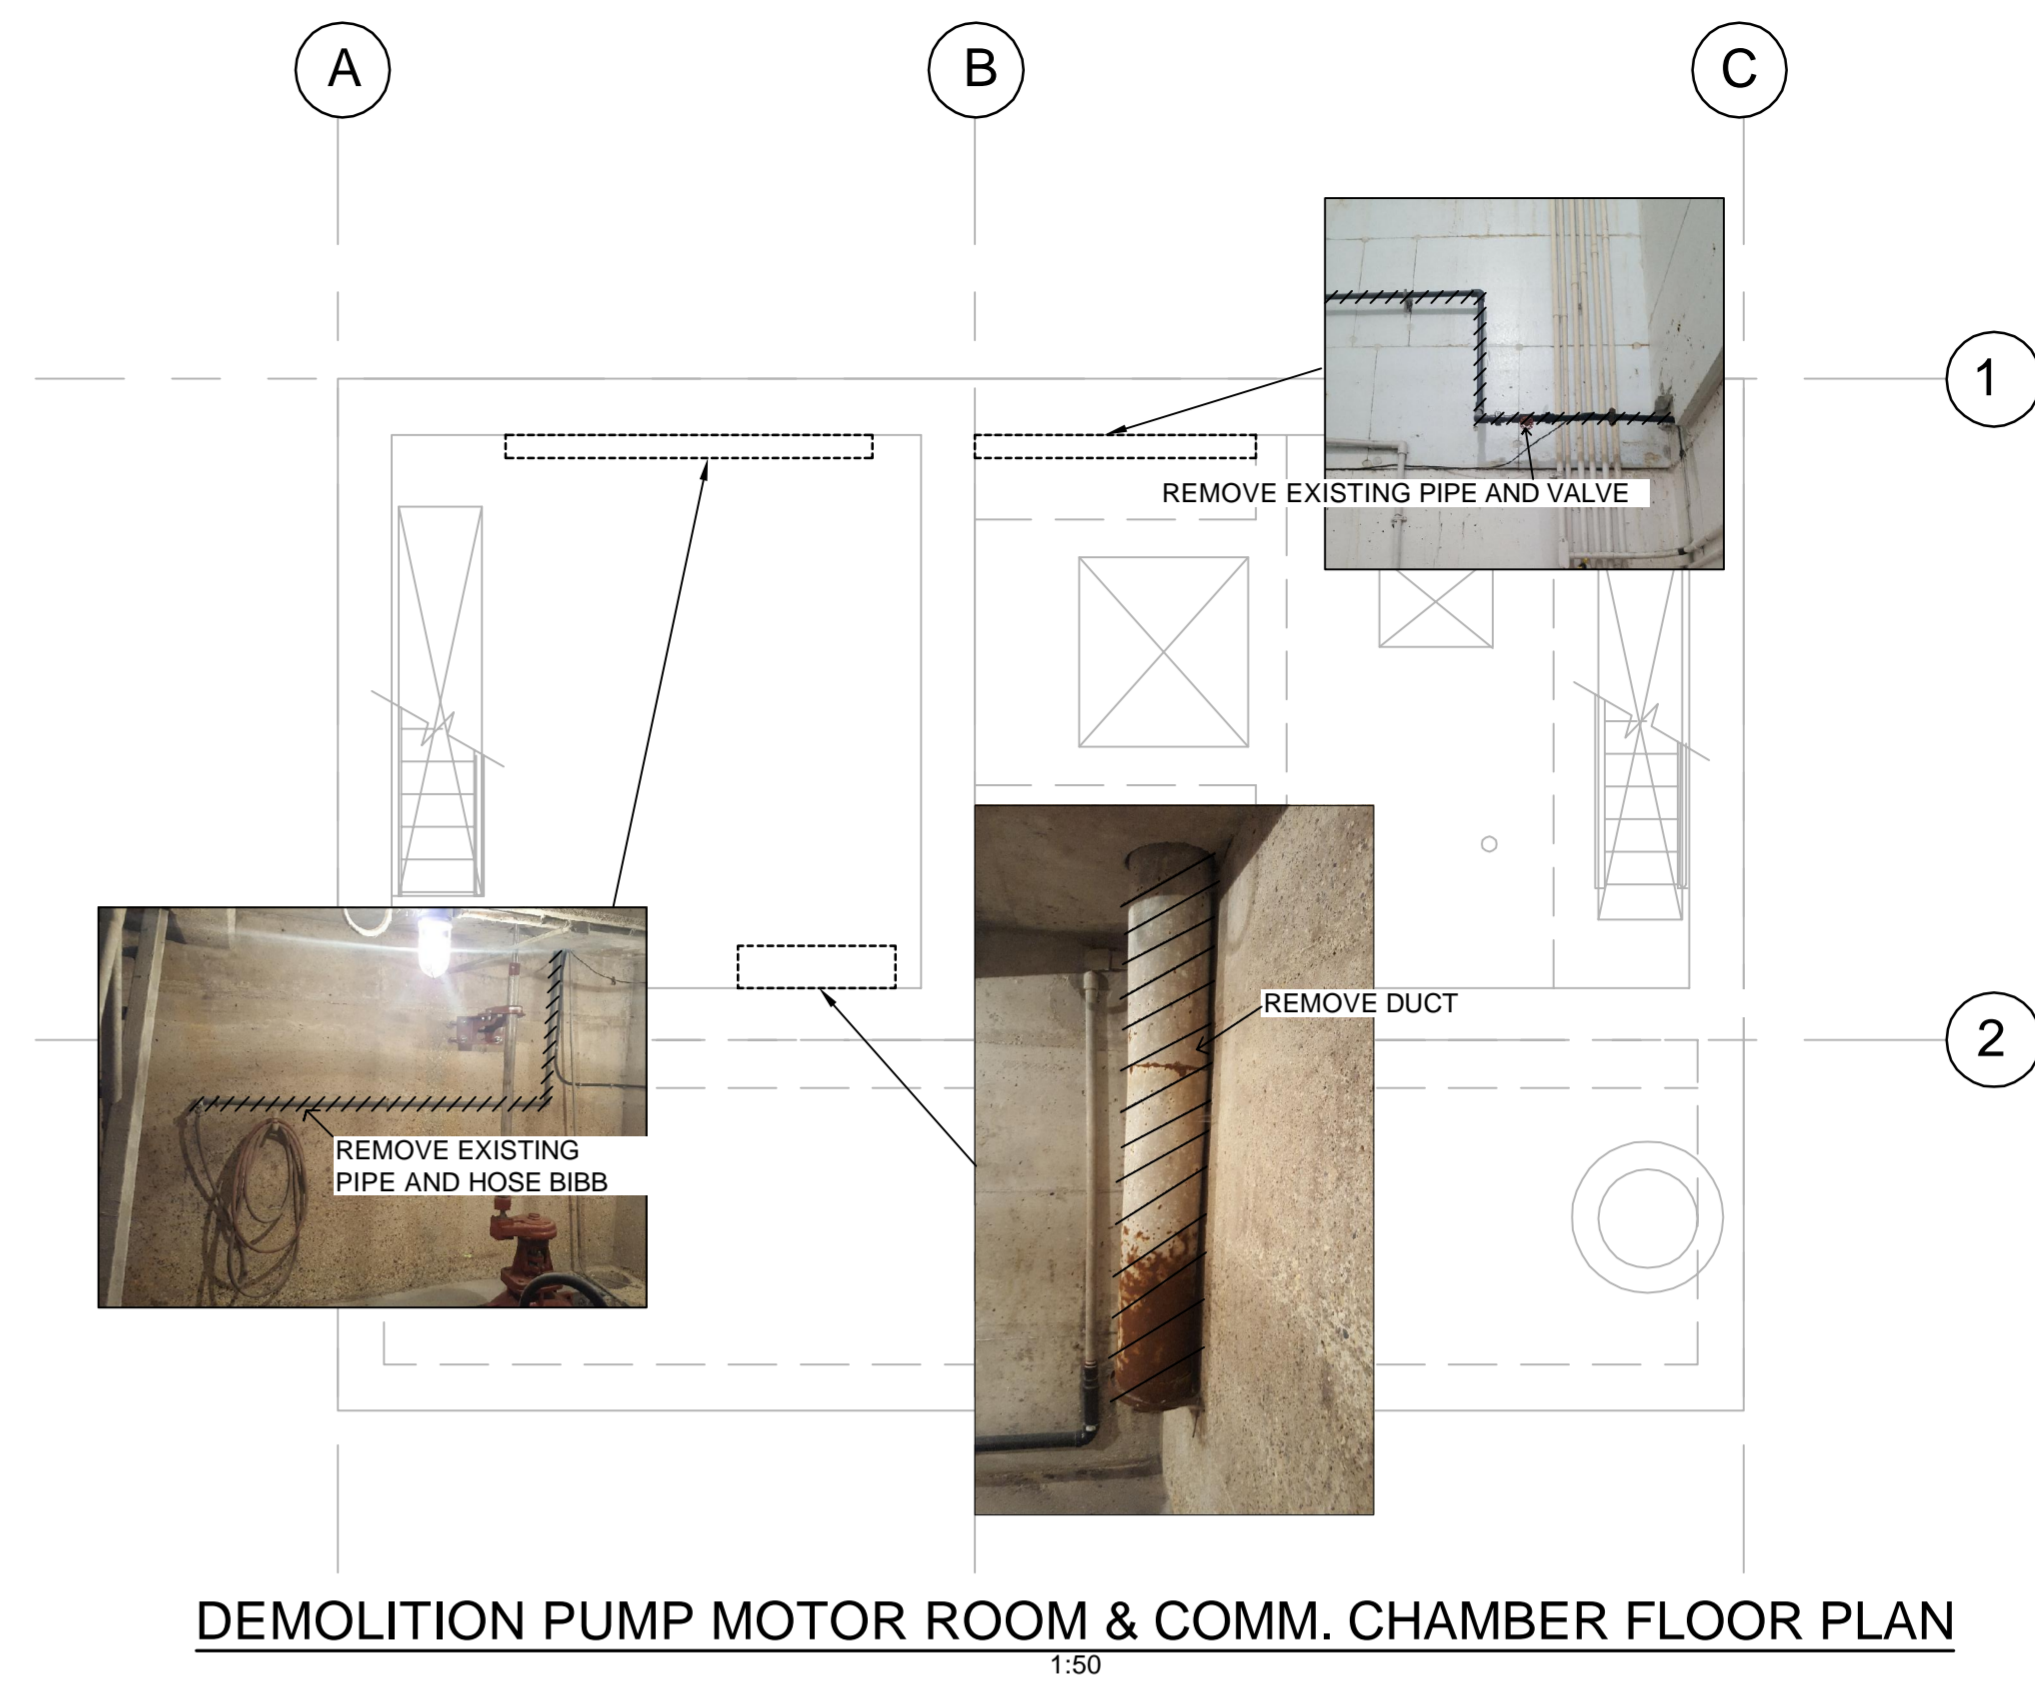

DEMOLITION PUMP MOTOR ROOM & COMM. CHAMBER FLOOR PLAN
1:50

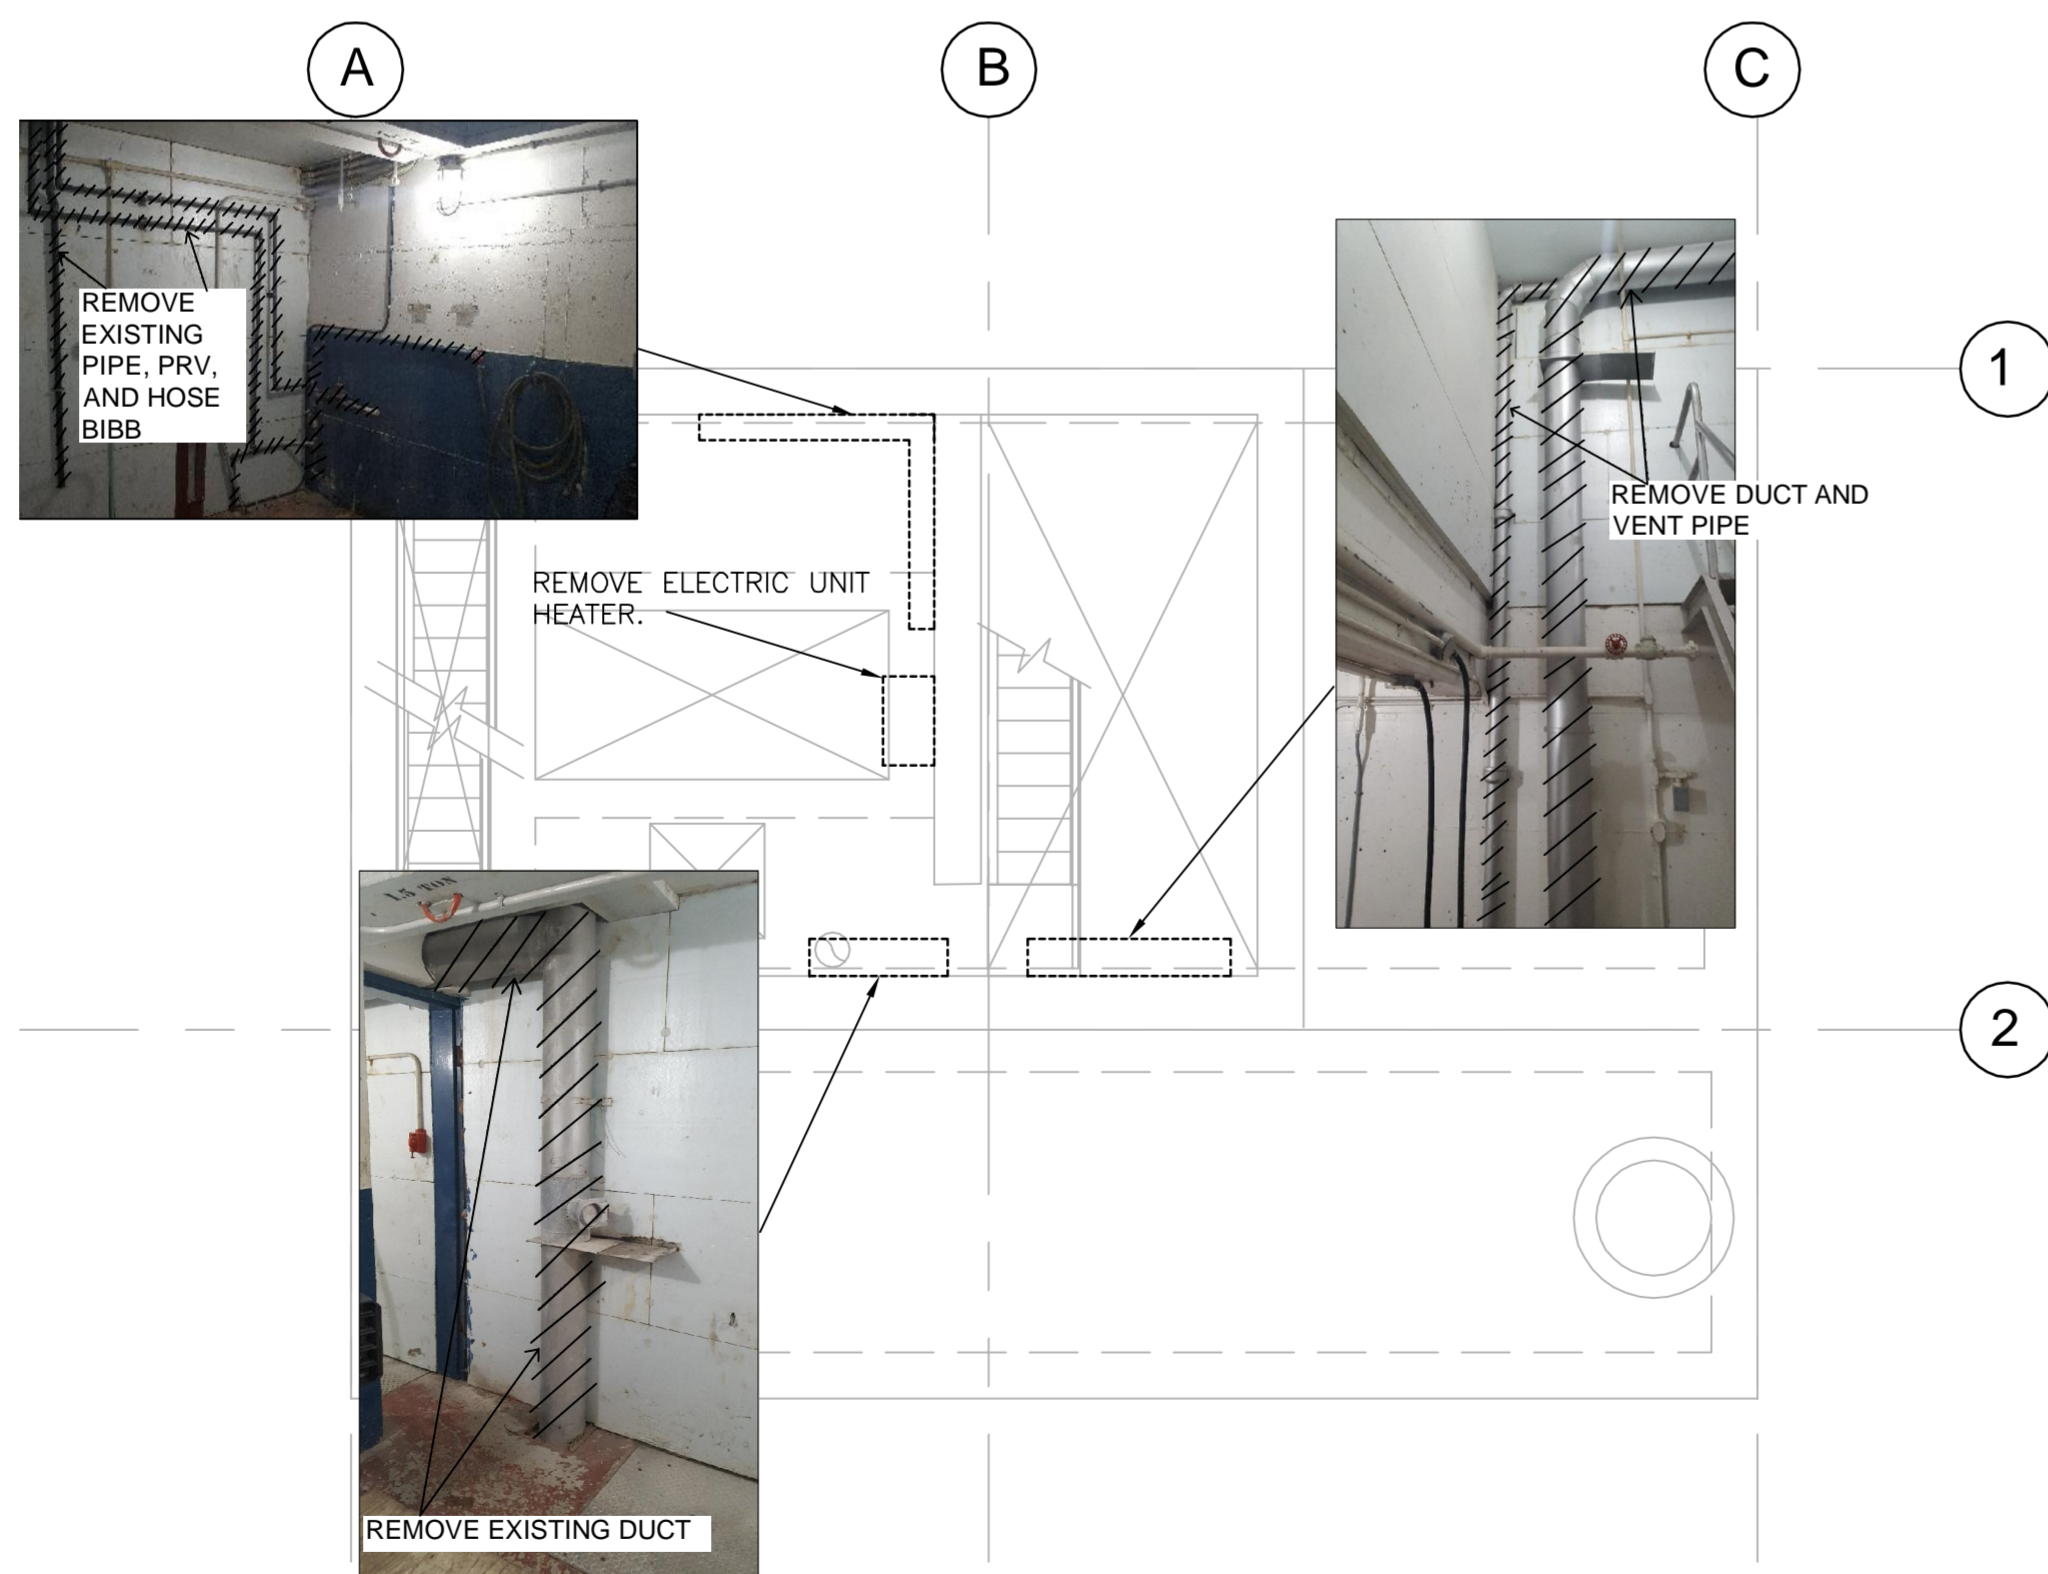

DEMOLITION COMM & MOTOR ROOM FLOOR PLAN
1:50

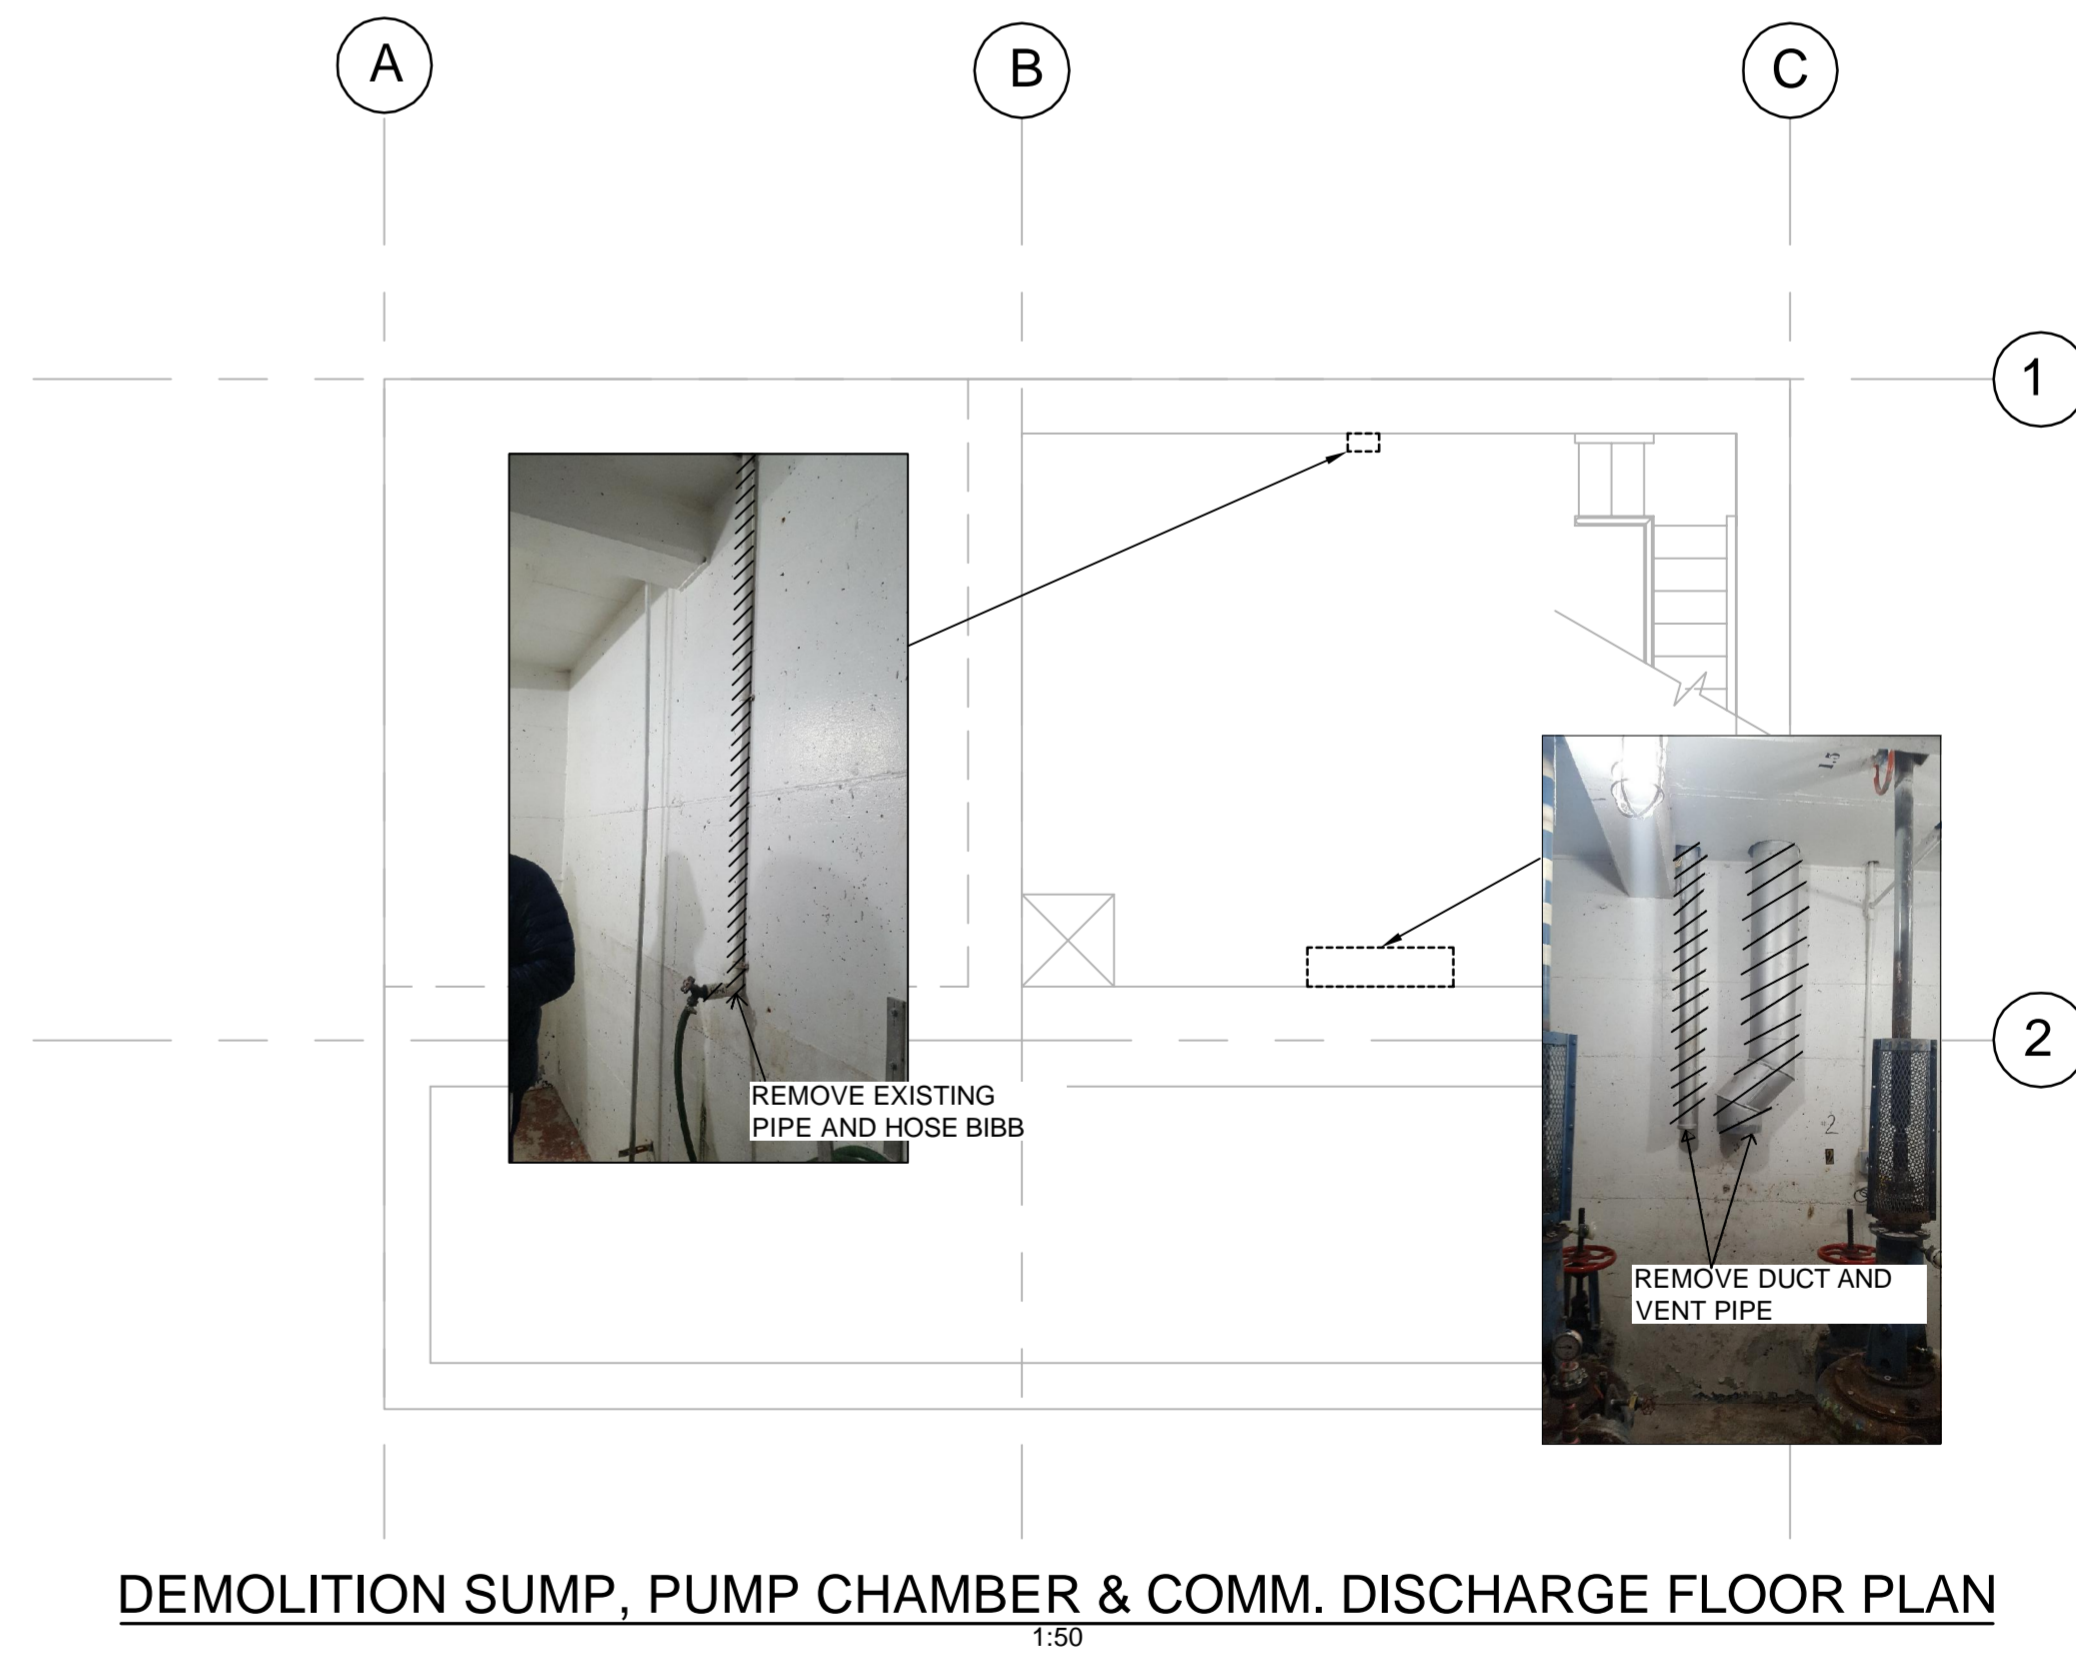

DEMOLITION SUMP, PUMP CHAMBER & COMM. DISCHARGE FLOOR PLAN
1:50

FILENAME: C:\PROJECTS\WORKING DIRECTORY\PROJECTS 2018\ZERRA\DWG\186936_01_MECH_DESIGNING_PLOTTED BY: FELLETER, ERIC
 PLOT DATE: 2018 JUN 29 2:05:56 PM PLOT SCALE: 1:1 PLOT STYLE: DILLON-STANDARD.ctb
 PLOTTER: HP DesignJet 5000 Series PLOTTER DRIVER: HP DesignJet 5000 Series PLOTTER

NOT FOR CONSTRUCTION



NO.	REVISIONS	DATE	BY
0	ISSUED FOR TENDER	06/29/18	EP

DILLON CONSULTING			
DESIGNED BY	E.P.	CHECKED BY	P.D.T
DRAWN BY	E.R.P.	APPROVED BY	MH
HOR. SCALE	AS SHOWN	NOT RELEASED FOR CONSTRUCTION	
VERTICAL	AS SHOWN		
DATE	JUNE 2018	DATE	

ENGINEER'S SEAL	
CONSULTANT PROJECT NUMBER	18-6936

THE CITY OF WINNIPEG WATER AND WASTE DEPARTMENT	
HAWTHORNE WASTEWATER PUMPING STATION UPGRADES	
CITY DRAWING NUMBER	1-0145L-M0002-001
SHEET	9 OF 21
MECHANICAL - DEMOLITION	
CONSULTANT DRAWING NUMBER	M-01