


3 SECTION
 P08 P09 SCALE 1:50

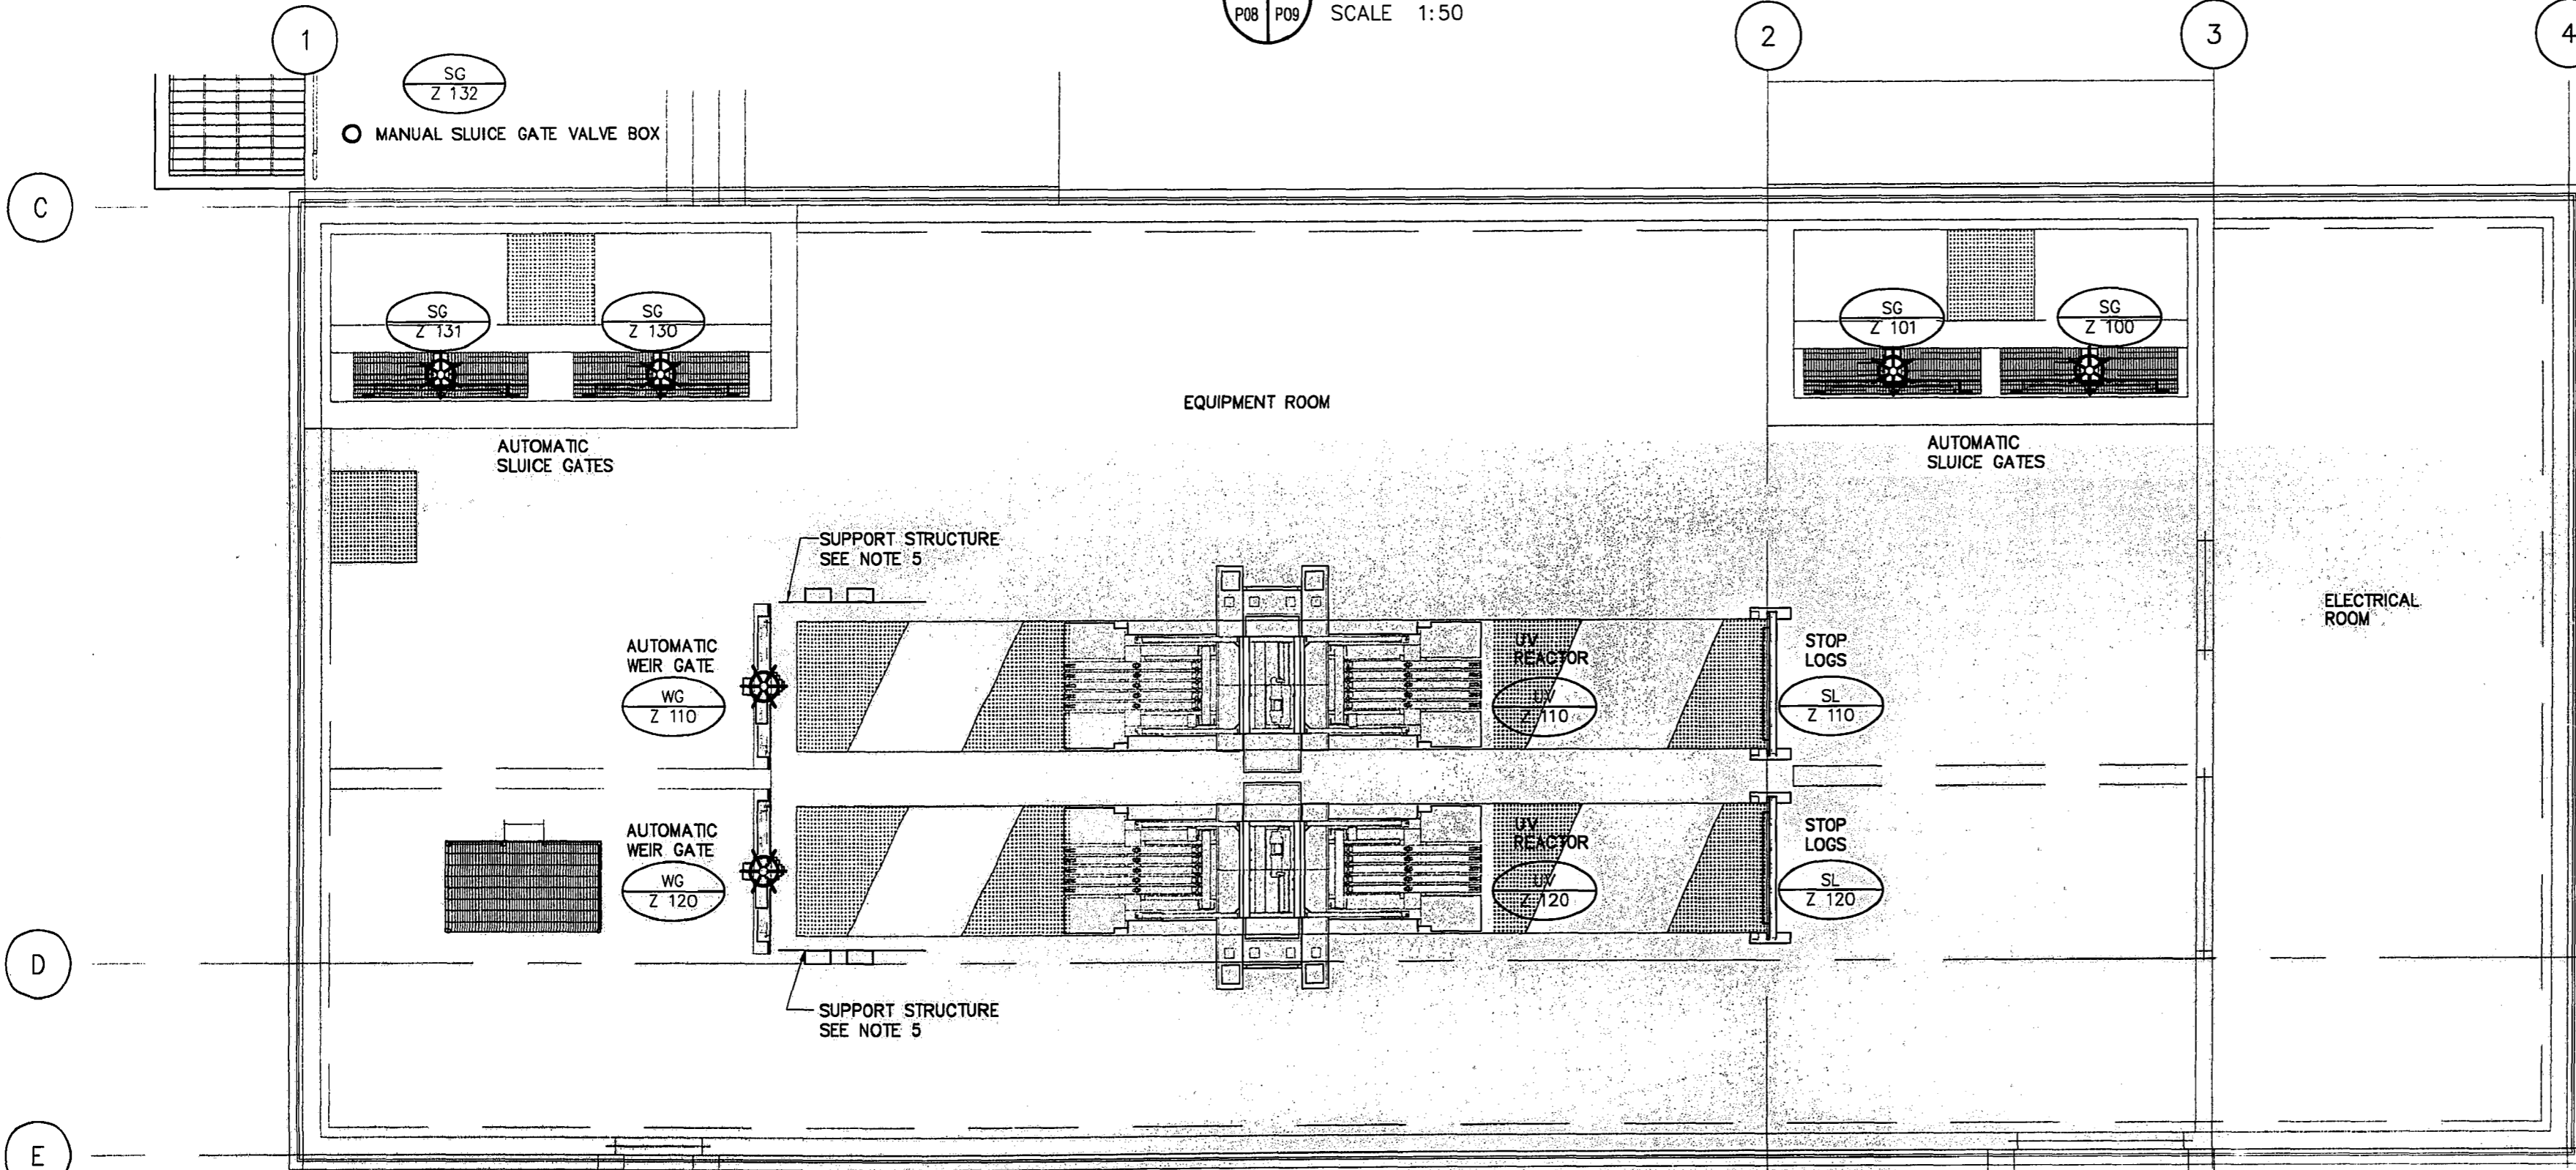

MAIN FLOOR PLAN
 SCALE 1:50

- NOTES:
- 1). DIMENSIONS GIVEN BY EQUIPMENT SUPPLIER TO BE CONFIRMED ON SHOP DRAWINGS.
 - 2). DIFFERENCE IN ELEVATION IS EQUAL TO HEIGHT OF EQUIPMENT GIVEN BY EQUIPMENT SUPPLIER. TO BE CONFIRMED ON SHOP DRAWINGS.
 - 3). EXISTING ELEVATIONS AND DIMENSIONS.
 - 4). ACTUATORS TO BE LOCATED ABOVE CONCRETE WALL.
 - 5). PROVIDE AN ALUMINUM SUPPORT STRUCTURE FOR THE UVT PANEL, THE LEVEL SENSOR AND THE WEIR GATE CONTROL REFER TO SECTION 16800.3.1.4

THESE RECORD DRAWINGS HAVE BEEN PREPARED, IN PART, ON THE BASIS OF INFORMATION COMPILED AND FURNISHED BY OTHERS. AS A RESULT, THE ENGINEER WILL NOT BE RESPONSIBLE FOR ANY ERRORS OR OMISSIONS WHICH HAVE BEEN INCORPORATED INTO THIS DOCUMENT.

REID CROWTHER & PARTNERS LIMITED
 WINNIPEG
RECORD DRAWING
 SIG. DATE SEP. 17. 1999

NO.	REVISIONS	DATE	BY
1	RECORD DRAWING	99/09/17	LLI
0	ISSUED FOR TENDER	98/07/27	LLI

Reid Crowther
 Consulting Engineering Worldwide

DESIGNED BY	KAS	CHECKED BY	BDS
DRAWN BY	K.H./LLI	APPROVED BY	
HOR. SCALE:		RELEASED FOR CONSTRUCTION BY:	
VERTICAL:		DATE	98/04/8

ENGINEER'S SEAL

ORIGINAL SIGNED BY D.J. TANIGUCHI 7/22/1998

CONSULTANT DRAWING NO. 61786.01 P09

THE CITY OF WINNIPEG
 WATER AND WASTE DEPARTMENT

SOUTH END WATER POLLUTION CONTROL CENTRE
 EFFLUENT DISINFECTION FACILITY

MAIN FLOOR PLAN AND SECTION

CITY DRAWING NUMBER SEP-2432
 SHEET OF

REV-1