


File Name: \\k-file-4-p-data\Projects\2018\18-0107-005\Dwg\Elec\18-0107-005_E15.dwg - Tab: E15 Plotted By: jdeleon 09/12/2018 [Wed 11:15am] CW-9-M564-1

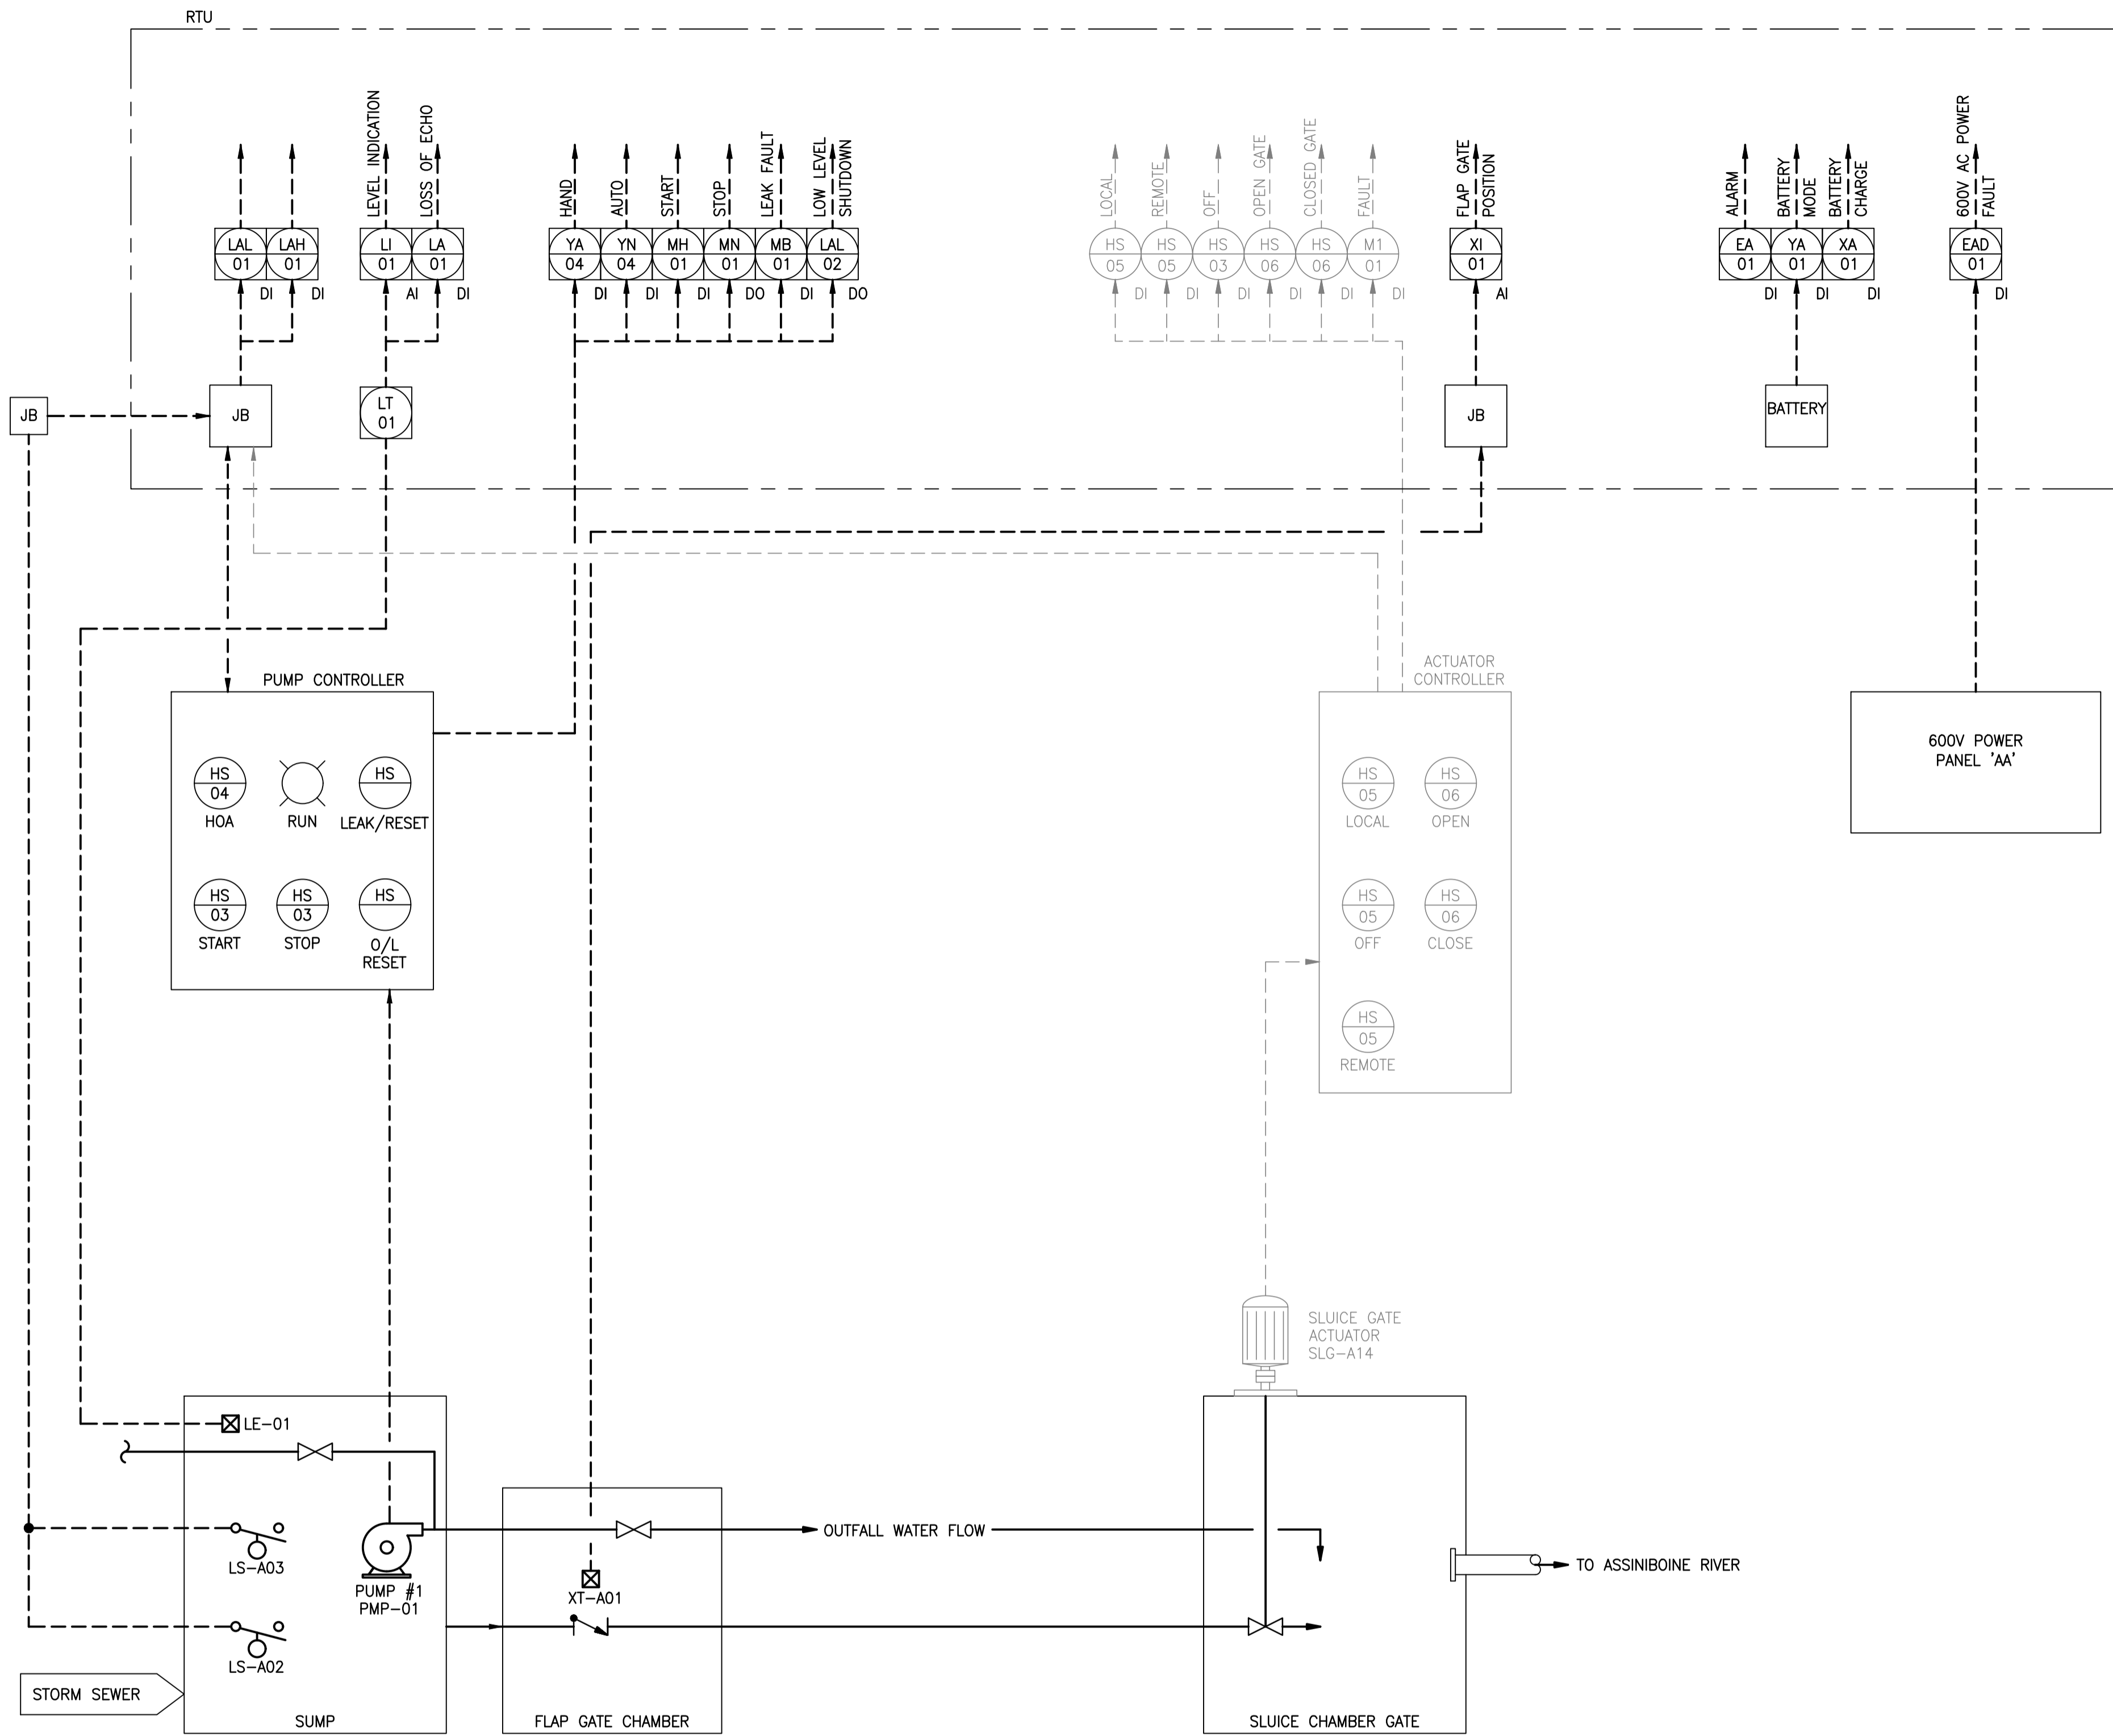

NOTES:
 1. GREY ITEMS DENOTES FUTURE PROVISIONS. GREY ITEMS ARE NOT PART OF PROJECT.

LEGEND:
 [JB] JUNCTION BOX
 [Symbol] LEVEL SWITCH
 [Symbol] FIELD DEVICE
 - - - - - ELECTRIC SIGNAL



POSTED TO LBIS		FIELD BOOK #:	
DESIGNED BY	LU	CHECKED BY	JAB
DRAWN BY	JPL	APPROVED BY	JAB
HDR. SCALE	AS NOTED	RELEASED FOR CONSTRUCTION	K. ZUREK
VERTICAL	AS NOTED	DATE	2018 09 11
0 ISSUED FOR CONSTRUCTION	18/09/11	JAB	
ND. REVISIONS	DATE	BY	DATE

ENGINEER'S SEAL

E15

THE CITY OF WINNIPEG
 WATER AND WASTE DEPARTMENT

DONALD OUTFALL CHAMBER UPGRADES

ELECTRICAL
 INSTRUMENTATION CONTROL
 P&ID

SHEET 24 OF 24
 CITY DRAWING NUMBER
 LD-8656