




# THE CITY OF WINNIPEG

WATER AND WASTE DEPARTMENT  
ENGINEERING DIVISION

## SHOAL LAKE AQUEDUCT CROSSING & ASSOCIATED ROADWORKS

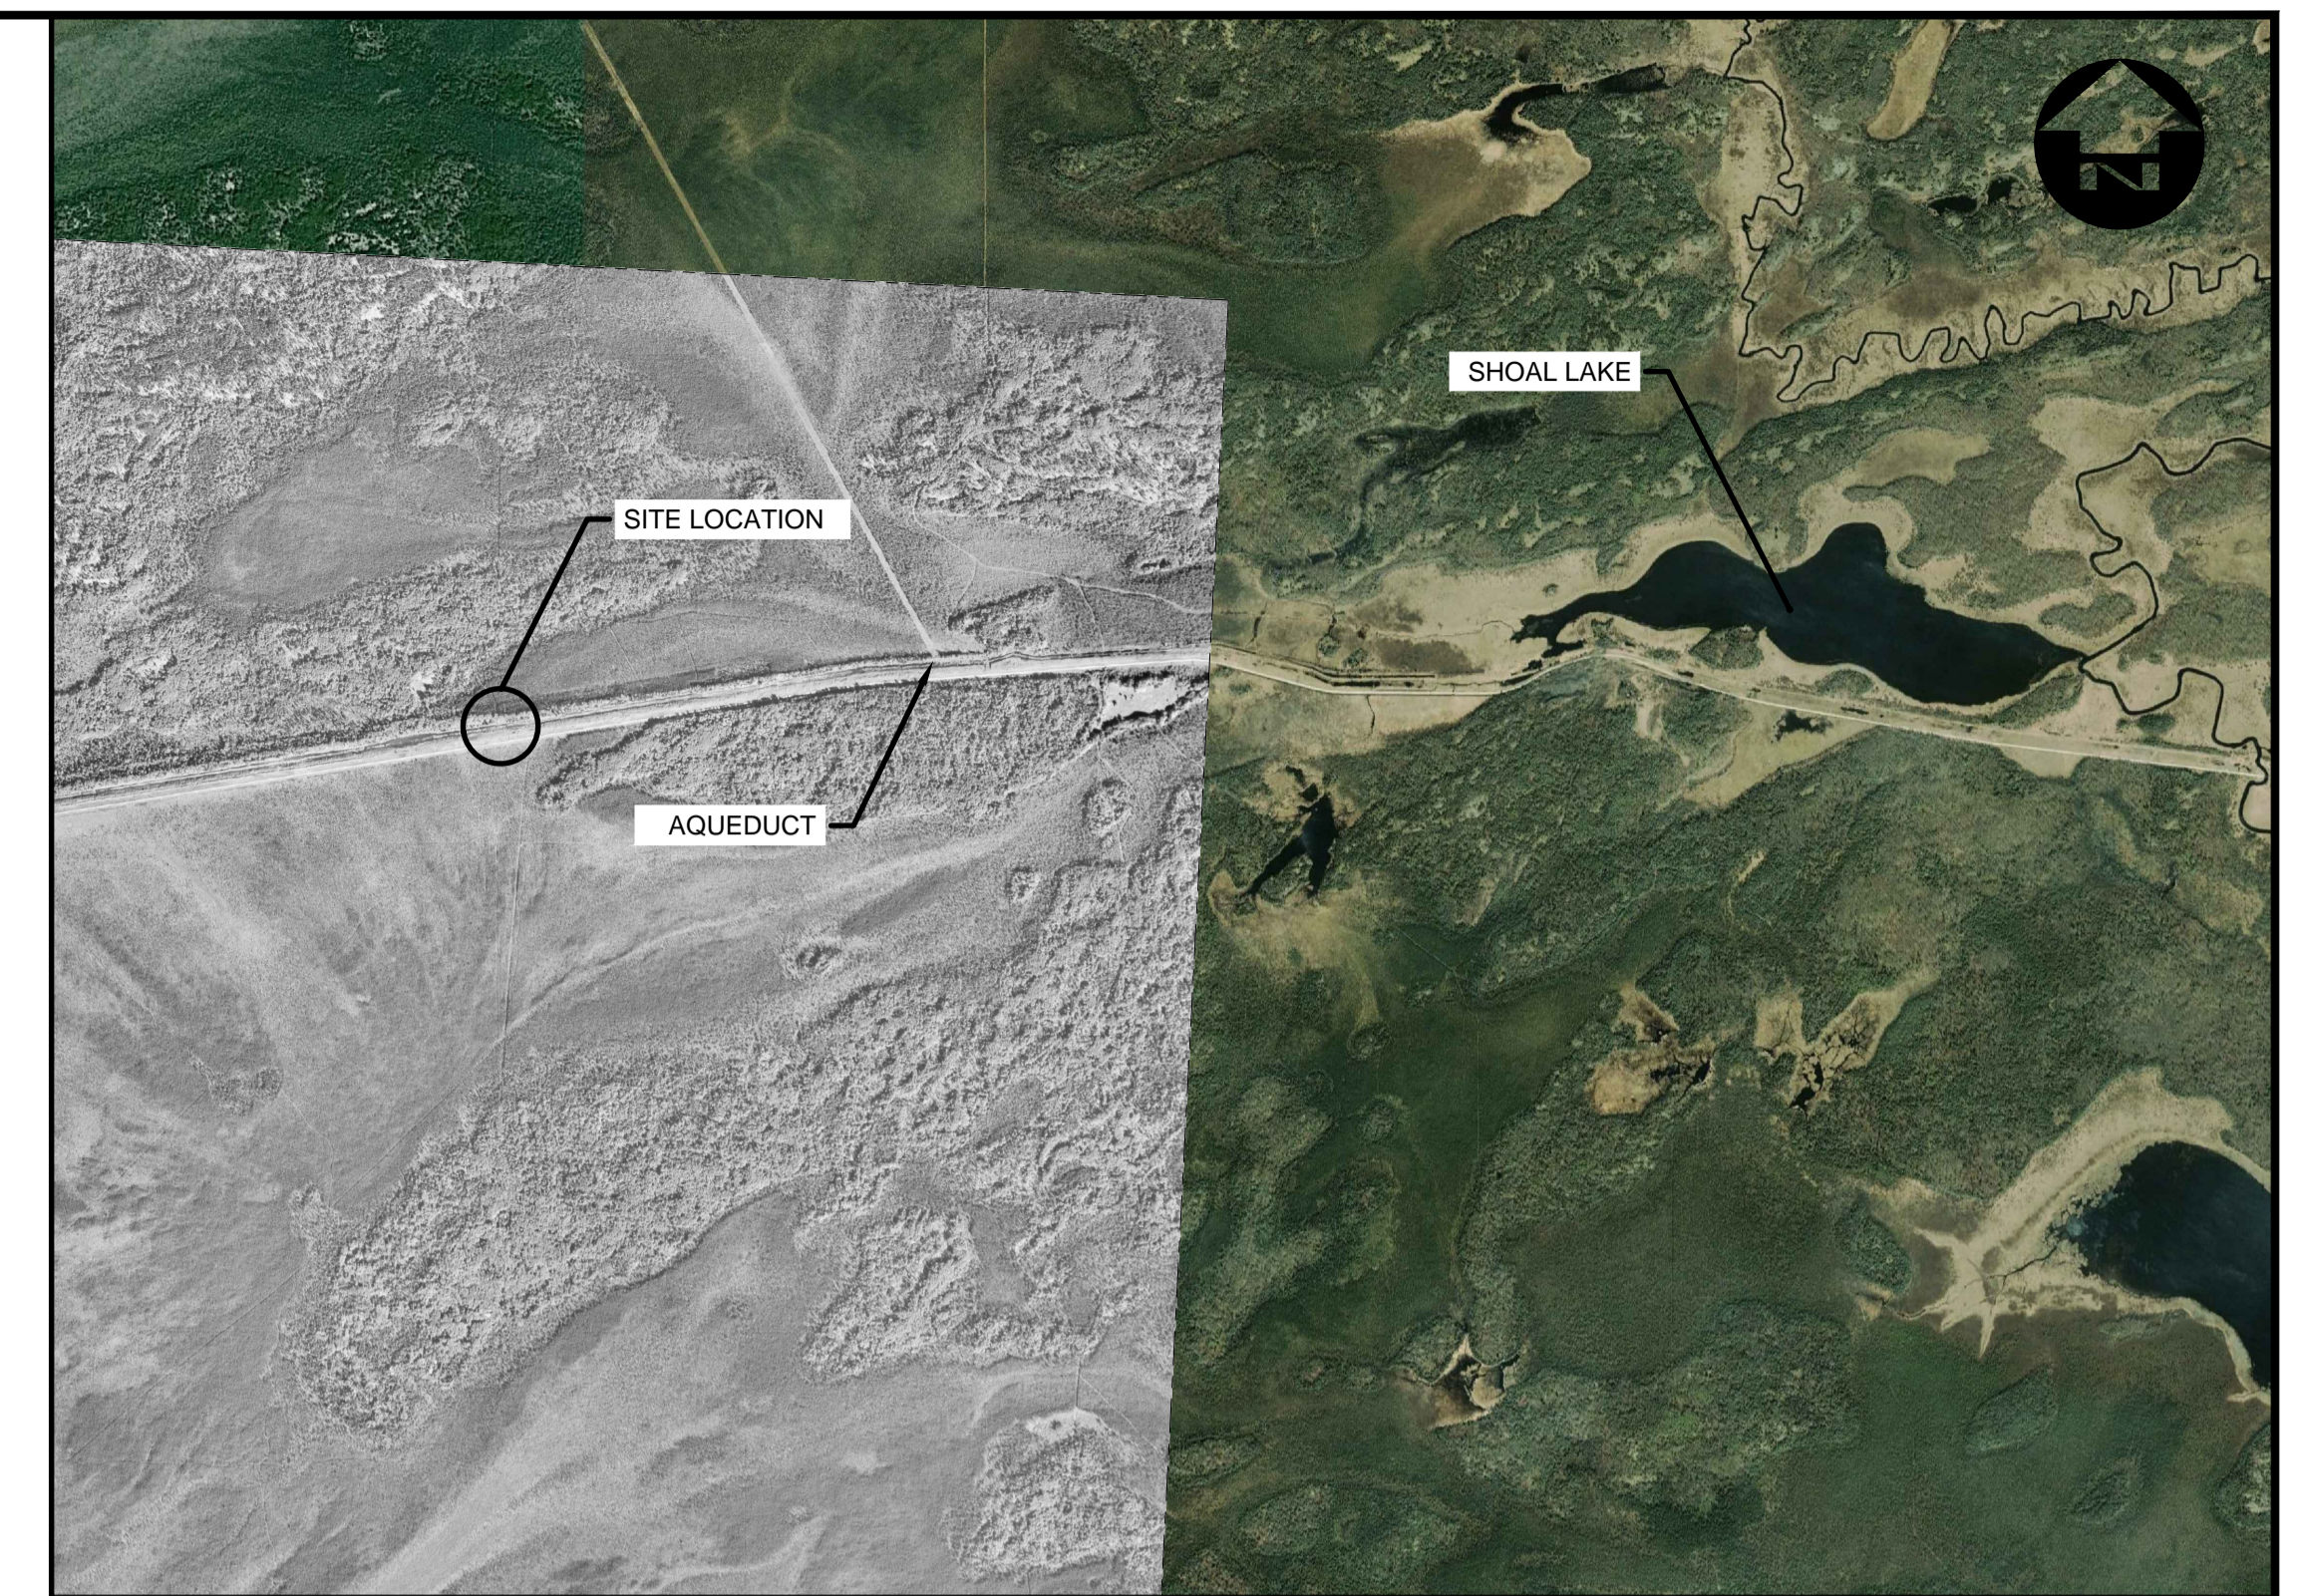

LOCATION PLAN

BID OPPORTUNITY 9-2018

DRAWING LIST

SHT. NO.	Sheet Number	Sheet Title	CITY DRAWING NO.
1 of 14	00	COVER SHEET	1-0701A-D0001-001
2 of 14	CS-01	GENERAL ARRANGEMENT	1-0701A-C0001-001
3 of 14	CS-02	BORE HOLE DETAILS 1 OF 3	1-0701A-S0001-001
4 of 14	CS-03	BORE HOLE DETAILS 2 OF 3	1-0701A-S0001-002
5 of 14	CS-04	BORE HOLE DETAILS 3 OF 3	1-0701A-S0001-003
6 of 14	CS-05	ABUTMENT AND PILE DETAILS	1-0701A-S0002-001
7 of 14	CS-06	ABUTMENT REINFORCEMENT DETAILS	1-0701A-S0003-001
8 of 14	CS-07	BACKWALL DETAILS	1-0701A-S0004-001
9 of 14	CS-08	BEARING DETAILS	1-0701A-S0005-001
10 of 14	CS-09	DECK AND GUARDRAIL DETAILS 1 OF 2	1-0701A-S0006-001
11 of 14	CS-10	DECK AND GUARDRAIL DETAILS 2 OF 2	1-0701A-S0006-002
12 of 14	CS-11	EROSION CONTROL	1-0701A-C0002-001
13 of 14	CT-01	PLAN AND PROFILE	1-0701A-C0003-001
14 of 14	CT-02	SIGNAGE PLAN	1-0701A-D0002-001



CONSULTANT DRAWING No. 00 CITY DRAWING No. 1-0701A-D0001-001 SHEET OF SHEET 1 14