


1 MAIN FLOOR PLAN - TRACK 13-24 - NEW CONSTRUCTION - FIRE PROTECTION
 M2.3 SCALE: 1/8" = 1'-0"

GENERAL NOTES

- A. THIS BUILDING MAY CONTAIN ASBESTOS. REFER TO FRONT END SPECIFICATION FOR INFORMATION.
- B. THE SPRINKLER SYSTEM SHALL BE DESIGNED AND INSTALLED IN ACCORDANCE WITH NFPA 13, MANITOBA BUILDING CODE, MANITOBA FIRE CODE, LOCAL BUILDING BY-LAWS, THE AUTHORITY HAVING JURISDICTION, AND THE SPECIFICATION.
- C. REFER TO ROOF DETAILS AND SPECIFICATIONS FOR ALL NEW AND CAPPED OPENINGS.

KEY NOTES

- 1. SPRINKLER SYSTEM AT HIGH LEVEL NOT SHOWN. PROVIDE NEW SPRINKLER HEADS UNDER NEW DUCTWORK AS REQUIRED. PROVIDE LOWER LEVEL SPRINKLER HEADS UNDER NEW DUCTWORK AS FAR AWAY FROM BUR TAIL PIPE AS POSSIBLE. LOWER LEVEL SPRINKLER HEADS UNDER NEW DUCTWORK SHALL BE HIGH TEMPERATURE TYPE (200 F ACTIVATION). HIGH LEVEL SPRINKLER HEADS AT UNDERSIDE OF STRUCTURE SHALL BE STANDARD TEMPERATURE TYPE (165 F ACTIVATION).
- 2. RELOCATE EXISTING SPRINKLER MAIN TO SUIT NEW DUCTWORK.

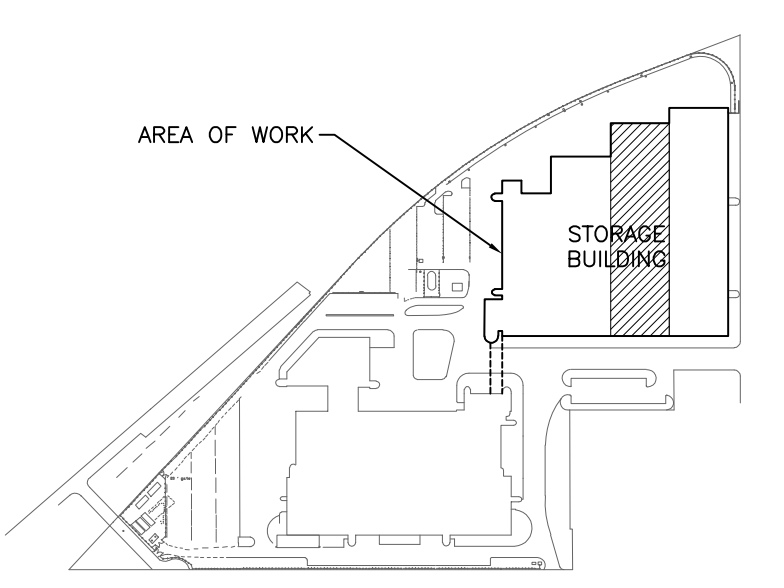

KEY PLAN

NO.	Description	BY	DATE
1	ISSUED FOR ADDENDUM 3	JH	09/12/18
0	ISSUED FOR CONSTRUCTION	JH	09/11/18

ENGINEERS
 GEOSCIENTISTS
 MANITOBA
 Certificate of Authorization
 SMS Engineering Ltd.
 No. 166

ORIGINAL
 CONTRACT DRAWING
 BONED AND SEALED BY
 J.T. HOPKOCKS, P. ENG
 NOVEMBER 9, 2018

770 Bradford Street
 Winnipeg, Canada
 T 204 775 0291
 SMSeng.com

SMS
 ENGINEERING

Project Title
**CITY OF WINNIPEG FORT ROUGE
 TRANSIT BASE - STORAGE TRACK
 13-24 - MECHANICAL UPGRADE**

WINNIPEG MANITOBA

Drawing Title
**MAIN FLOOR PLAN - TRACK
 13-24 - NEW CONSTRUCTION -
 FIRE PROTECTION**

Drawn By	Checked By	Approved By
JC/AS	XZ	JH
Scale AS NOTED	Date NOVEMBER, 2018	Project No. 18-246-01
Revision Number 1	Drawing Number M2.3	Sheet Order 8 OF 12